

**PLANNING, CONTENT DEVELOPMENT, DESIGNING, RETROFITTING  
AND CURATORIAL WORK FOR THE INDIAN MUSEUM, KOLKATA**

TENDER DRAWINGS

**PLANNING, CONTENT DEVELOPMENT, DESIGNING, RETROFITTING AND CURATORIAL WORK FOR  
THE INDIAN MUSEUM, KOLKATA**


**List of Drawings**

<b>S.No.</b>	<b>Drawing Title</b>	<b>Drawing No.</b>	<b>Scale</b>	<b>Sheet Size</b>
	<b>Museum Exhibition Layout</b>			
1	Ground Floor and Mezzanine Plan	IMK/GF/01	1:200	A1
	<b>Gallery 1 - Entrance Foyer</b>			
2	Layout	IMK/GF/EF/01	1:100	A2
3	Elevations	IMK/GF/EF/02	1:100	A2
4	Details	IMK/GF/EF/03	1:25	A2
5	Details	IMK/GF/EF/04	1:25	A2
6	Detail – Reception Table	IMK/GF/EF/05	1:25	A2
7	Lighting Layout	IMK/GF/EF/06	1:100	A2
	<b>Gallery 2 – Bharhut and Bodh Gaya</b>			
8	Layout	IMK/GF/BH/01	1:100	A2
9	Elevations	IMK/GF/BH/02	1:100	A2
10	Interior Elevations	IMK/GF/BH/03	1:100	A2
11	Lighting Layout	IMK/GF/BH/04	1:100	A2
12	Covering of Insitu Artefacts	IMK/GF/BH/05	1:100	A2
	<b>Gallery 3 – Gandhara School of Art</b>			
13	Layout	IMK/GF/GA/01	1:100	A2
14	Elevations	IMK/GF/GA/02	1:100	A2
15	Detail – Display Case	IMK/GF/GA/03	1:25	A2
16	Details	IMK/GF/GA/04	1:25	A2
17	Lighting Layout	IMK/GF/GA/05	1:100	A2
	<b>Gallery 4 – Numismatics Gallery</b>			
18	Layout	IMK/GF/NU/01	1:100	A2
19	Elevations	IMK/GF/NU/02	1:100	A2
20	Internal Elevations	IMK/GF/NU/03	1:25	A2
21	Detail – Display Case	IMK/GF/NU/04	1:25	A2
22	Detail – Display Case	IMK/GF/NU/05	1:25	A2
23	Details	IMK/GF/NU/06	1:25	A2
24	Lighting Layout	IMK/GF/NU/07	1:100	A2
	<b>Gallery 5 – Panorama of Indian Sculptural Art (Long Archaeology Gallery)</b>			
25	Layout	IMK/GF/LA/01	1:125	A2
26	Elevations	IMK/GF/LA/02	1:125	A2
27	Internal Elevations	IMK/GF/LA/03	1:125	A2
28	Details	IMK/GF/LA/04	1:25	A2
29	Details	IMK/GF/LA/05	1:25	A2
30	Details	IMK/GF/LA/06	1:25	A2
31	Lighting Layout	IMK/GF/LA/07	1:125	A2


	<b>Gallery 6 – Metal Sculpture Gallery</b>			
32	Layout	IMK/GF/MS/01	1:100	A2
33	Elevations	IMK/GF/MS/02	1:100	A2
34	Internal Elevations	IMK/GF/MS/03	1:100	A2
35	Detail – Display Case	IMK/GF/MS/04	1:25	A2
36	Detail – Display Case	IMK/GF/MS/05	1:25	A2
37	Lighting Layout	IMK/GF/MS/06	1:100	A2
	<b>Gallery 7 – Gallery of Stone Age Cultures and Harappan Civilization (Pre and Proto History Gallery)</b>			
38	Layout	IMK/GF/PH/01	1:100	A2
39	Elevations	IMK/GF/PH/02	1:100	A2
40	Detail – Display Case	IMK/GF/PH/03	1:25	A2
41	Detail – Display Case	IMK/GF/PH/04	1:25	A2
42	Detail – Display Case	IMK/GF/PH/05	1:25	A2
43	Detail – Central Display	IMK/GF/PH/06	1:25	A2
44	Lighting Layout	IMK/GF/PH/07	1:100	A2
	<b>Gallery 8 – Human Evolution Gallery</b>			
45	Layout	IMK/GF/HE/01	1:100	A2
46	Elevations	IMK/GF/HE/02	1:100	A2
47	Internal Elevations	IMK/GF/HE/03	1:100	A2
48	Details	IMK/GF/HE/04	1:30	A2
49	Details	IMK/GF/HE/05	1:30	A2
50	Details – Central Display	IMK/GF/HE/06	1:25	A2
51	Lighting Layout	IMK/GF/HE/07	1:100	A2
	<b>Gallery 9 – Cultural Anthropology Gallery</b>			
52	Layout	IMK/GF/CA/01	1:100	A2
53	Elevations	IMK/GF/CA/02	1:100	A2
54	Elevations	IMK/GF/CA/03	1:100	A2
55	Detail – Display Case	IMK/GF/CA/04	1:20	A2
56	Detail – Display Case	IMK/GF/CA/05	1:20	A2
57	Detail – Display Case	IMK/GF/CA/06	1:20	A2
58	Detail – Display Case	IMK/GF/CA/07	1:20	A2
59	Detail – Display Case	IMK/GF/CA/08	1:20	A2
60	Lighting Layout	IMK/GF/CA/09	1:100	A2

**GROUND FLOOR PLAN AND FIRST FLOOR PLAN OF ANNEXE**



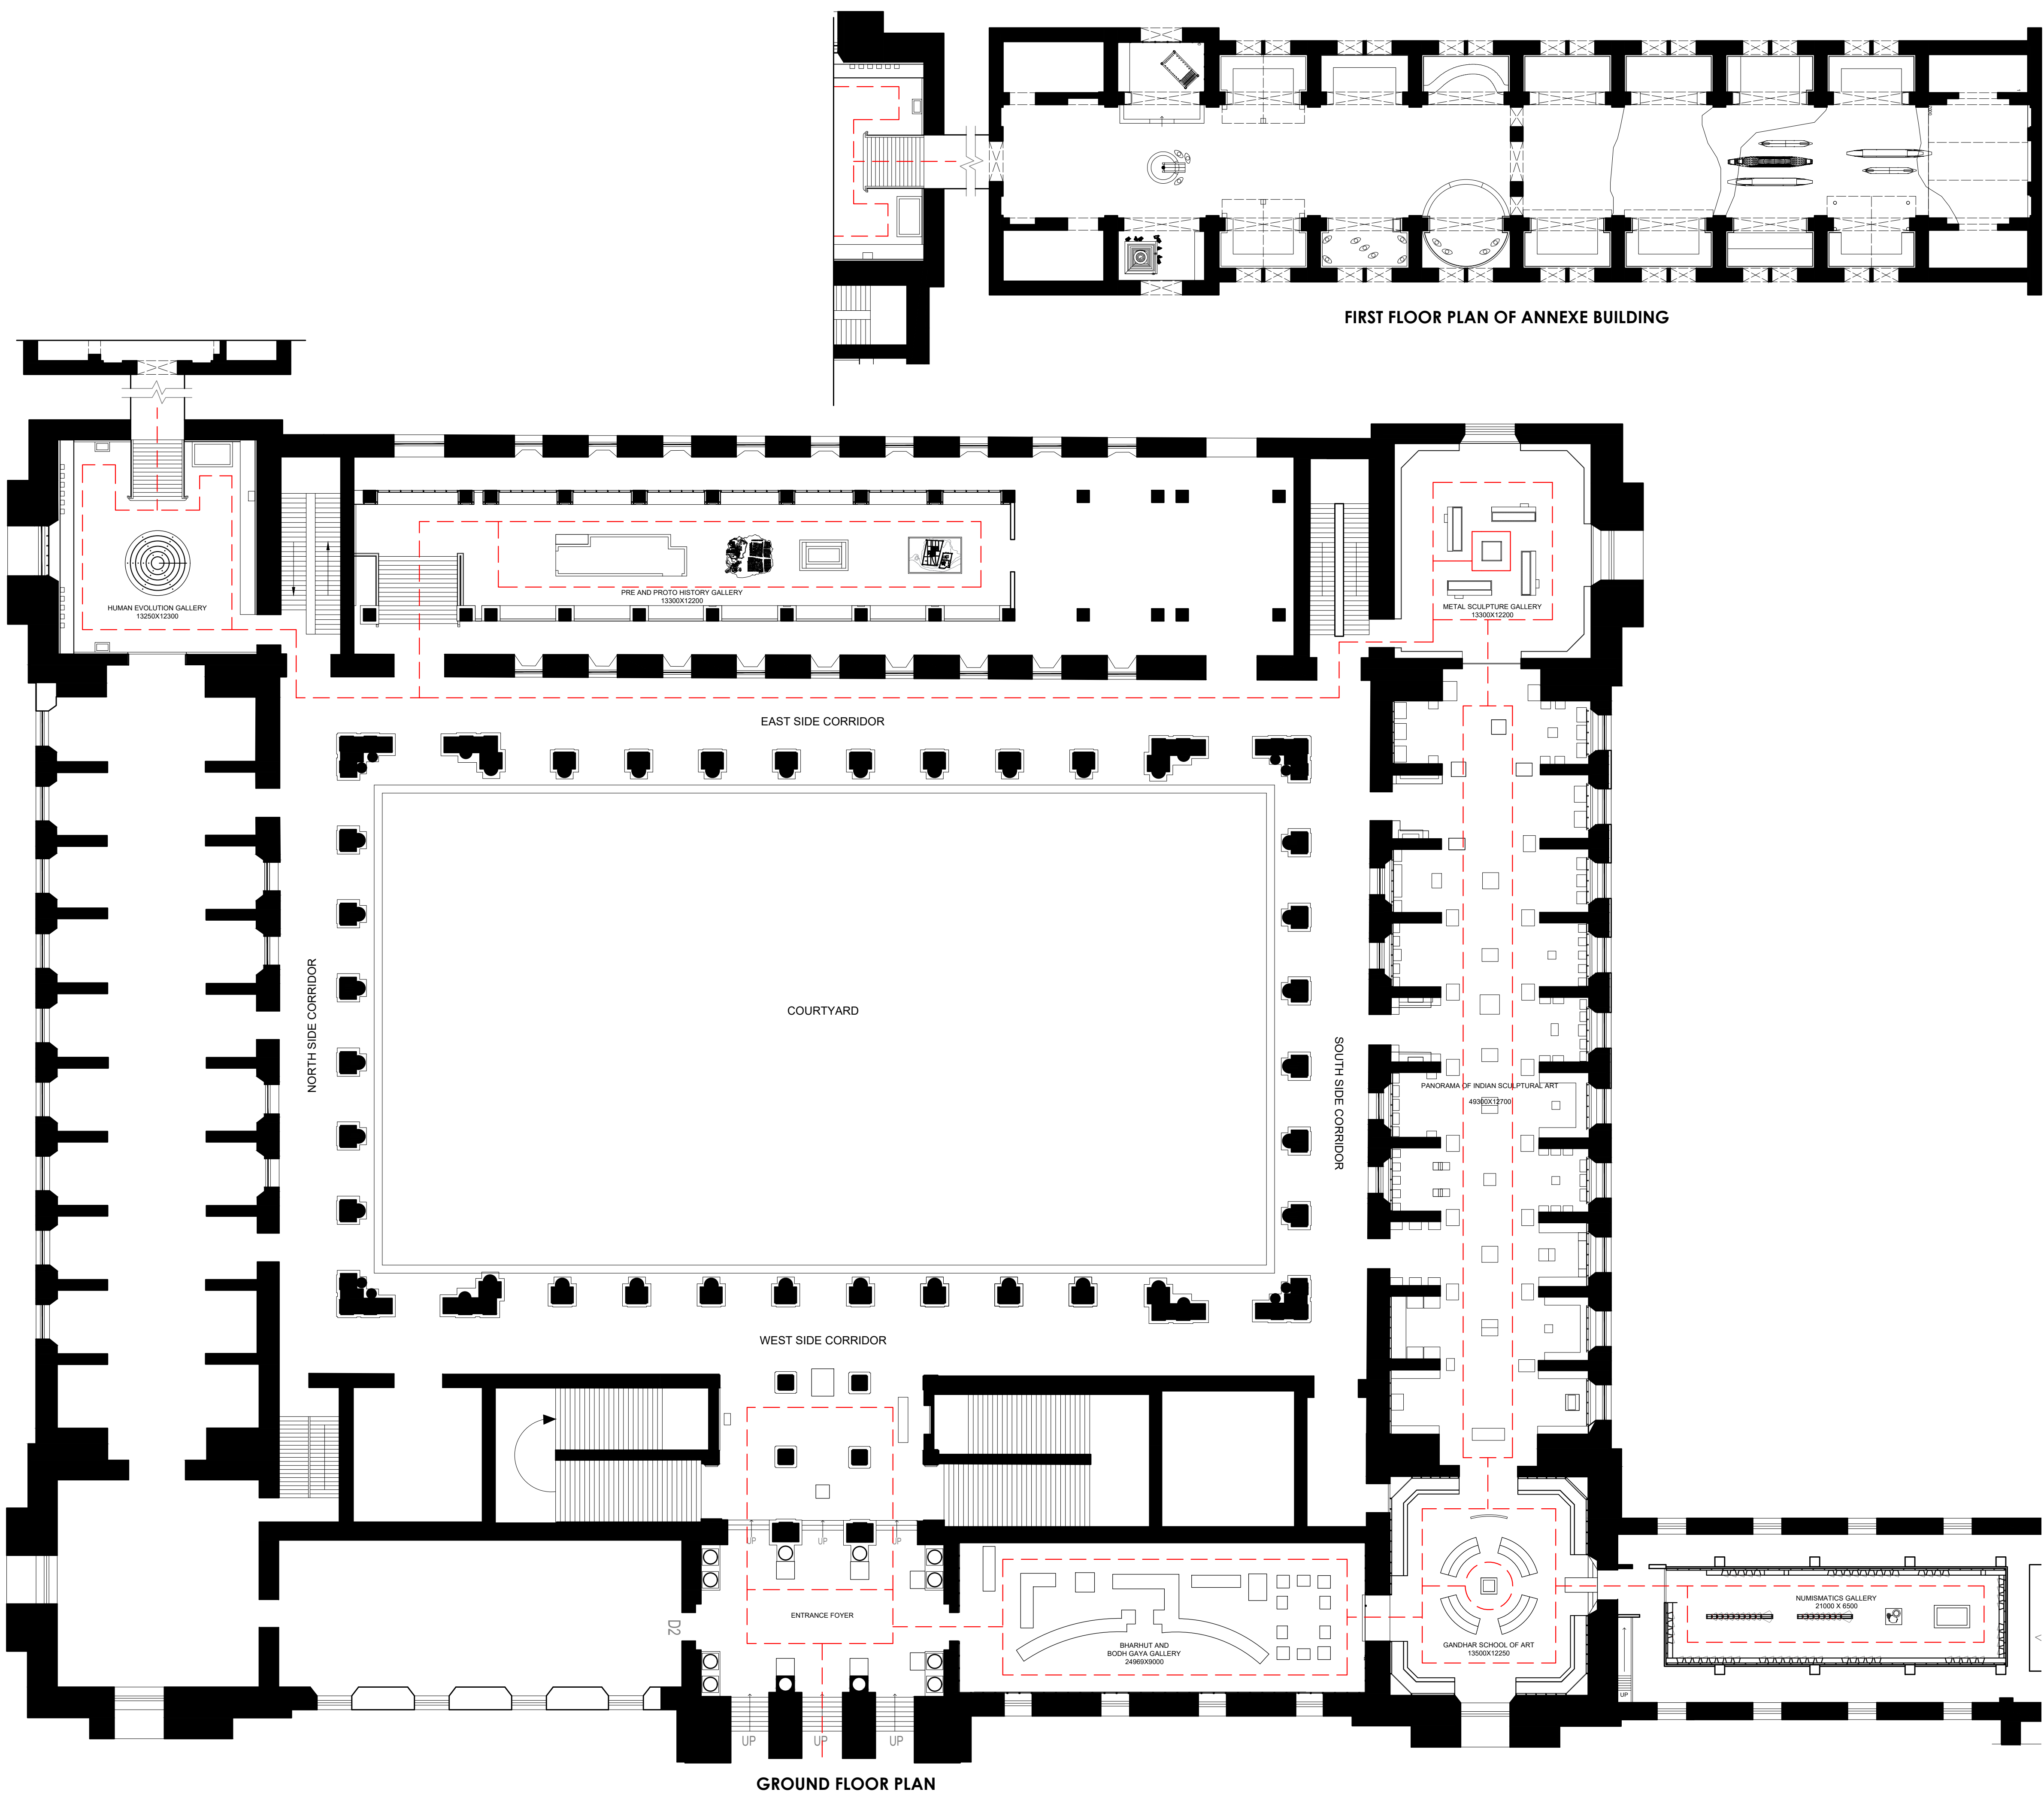

**NOTES:**  
All dimensions are in millimeters

<b>SCALE:</b> 1:200	 <b>NORTH</b>
0 2m	

<b>DRAWING NAME:</b>	<b>LAYOUT</b>
<b>GROUND FLOOR AND FIRST FLOOR OF ANNEXE BUILDING</b>	
<b>DRAWN BY:</b>	Sohini Pyne
<b>CHECKED BY:</b>	Shikha Jain
<b>DRAWING NUMBER:</b>	IMK/GF/01

<b>SERIES:</b>	Tender Drawings
----------------	-----------------

<b>PROJECT:</b>
PLANNING, CONTENT DEVELOPMENT, DESIGNING, RETROFITTING AND CURATORIAL WORK FOR THE INDIAN MUSEUM, KOLKATA


<b>CLIENT:</b>
INDIAN MUSEUM, KOLKATA
<b>CONSULTANT:</b>

**DRONAH**  
DEVELOPMENT & RESEARCH  
ORGANISATION FOR NATURE,ARTS  
& HERITAGE  
  
A-258, SOUTH CITY-1  
GURGAON-122001

GALLERY 1  
**ENTRANCE FOYER**

LEGEND


SR. NO.	NAME
PE 1	Rampurba Lion Capital
PE 2	Wish Fulfilling Tree
PE 3	Besnagar Yakshi
PE 4	Yaksha
PE 5	Yaksha and Yakshi (Bharhut)
PE 6	Yaksha and Yakshi (Bharhut)
PE 7	Yaksha (Patna)
DC 1	Serpent Hood
	Winged Griffin

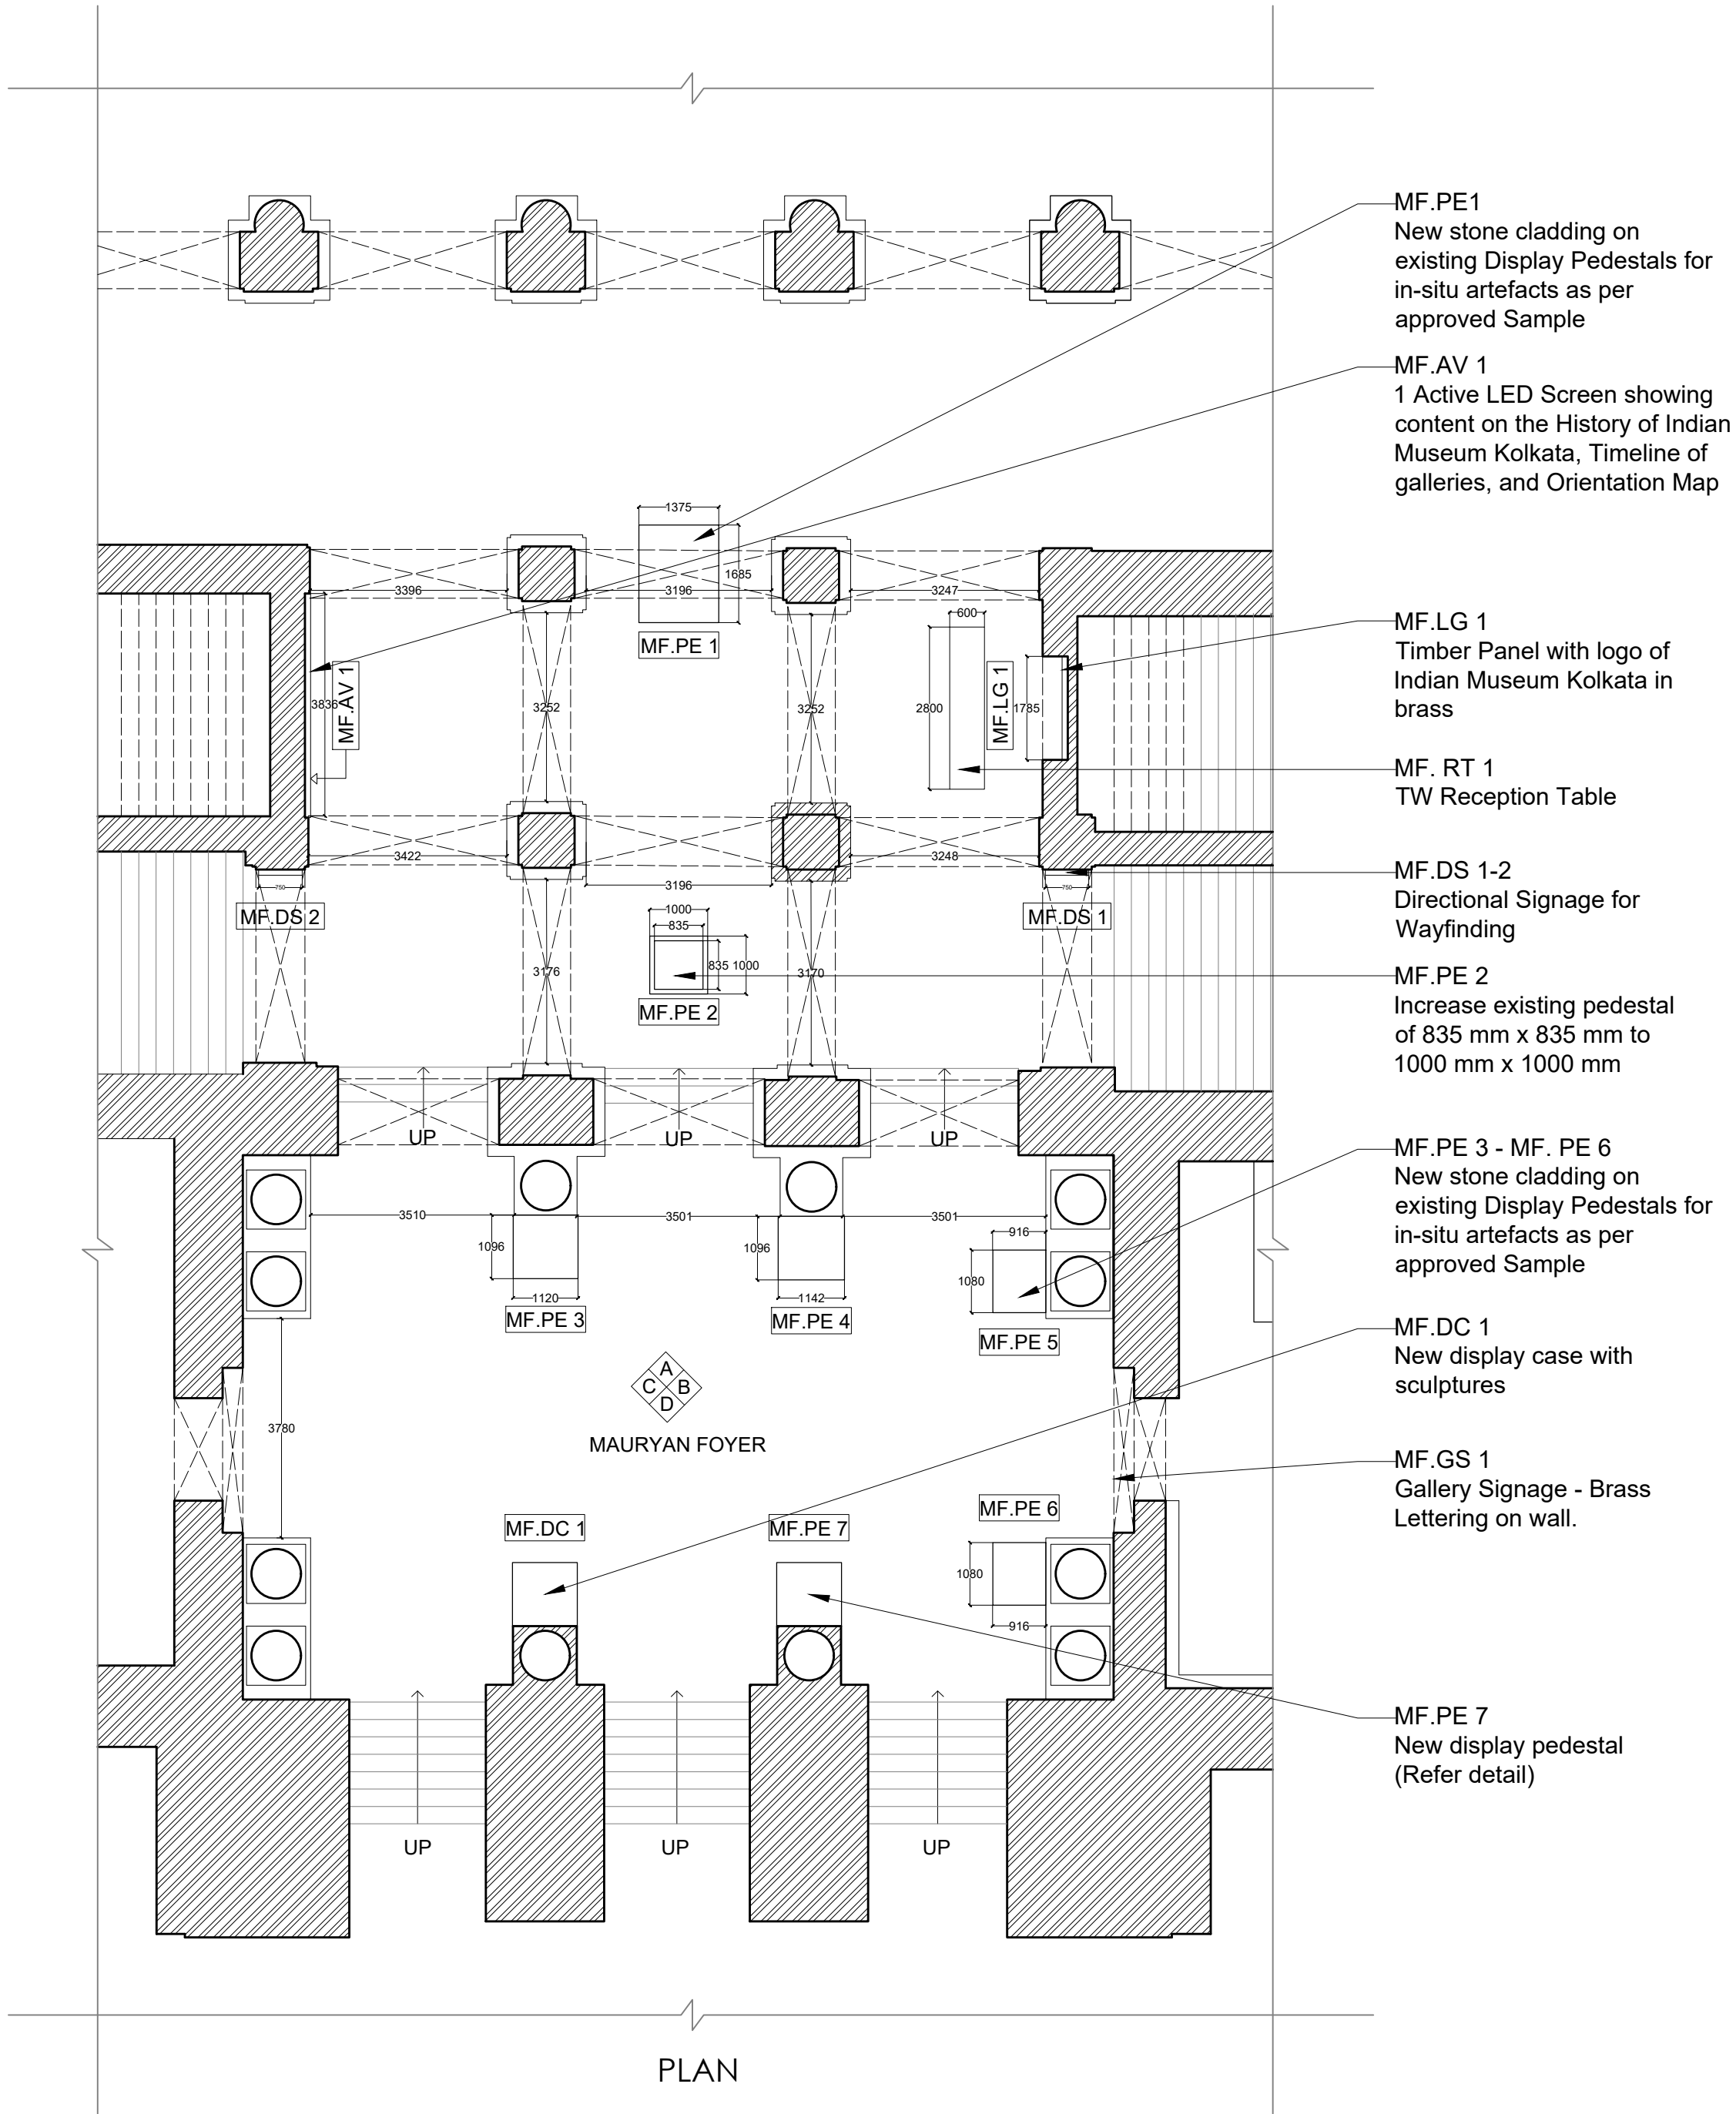

NOTES:

All dimensions are in millimeters

KEY PLAN

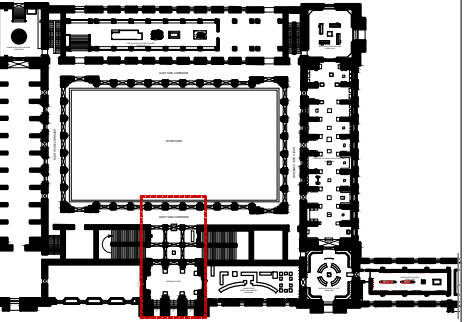

LEGEND

DP	Display Panel
DC	Display Case
DS	Display Shelf
PE	Pedestal
WM	Wall Mural
WG	Wall Graphics
CP	Canvas Painting
M	Model
MET	Mock Excavation Trench
CP	Canvas Painting
AV	Audio Visuals
I	Interactive
P	Projection
HP	Holographic Projection
GS	Gallery Signage
DS	Directional Signage
LG	Logo
RT	Reception Table
CC	Crowd Control Barrier

SCALE: 1:100

0 1m 2m



DRAWING NAME: LAYOUT

ENTRANCE FOYER

DRAWN BY: Sohini Pyne

CHECKED BY: Shikha Jain

DRAWING NUMBER: IMK/GF/MF/01

SERIES: Tender Drawings

PROJECT:

PLANNING, CONTENT DEVELOPMENT, DESIGNING, RETROFITTING AND CURATORIAL WORK FOR THE INDIAN MUSEUM, KOLKATA


CLIENT:

INDIAN MUSEUM, KOLKATA


CONSULTANT:

**DRONAH**  
DEVELOPMENT & RESEARCH ORGANISATION FOR NATURE,ARTS & HERITAGE


A-258, SOUTH CITY-1  
GURGAON-122001

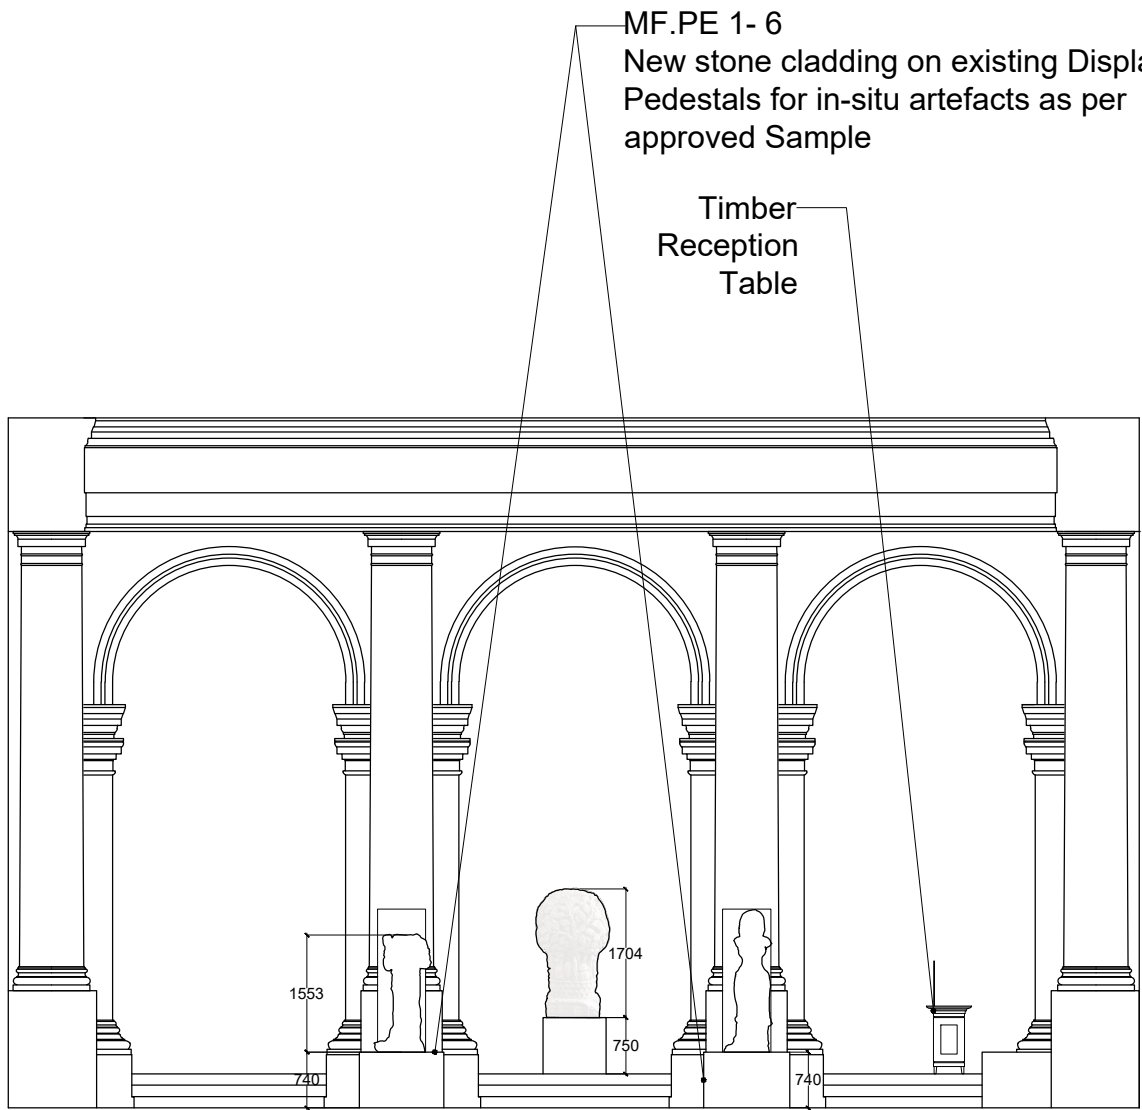


ELEVATION A

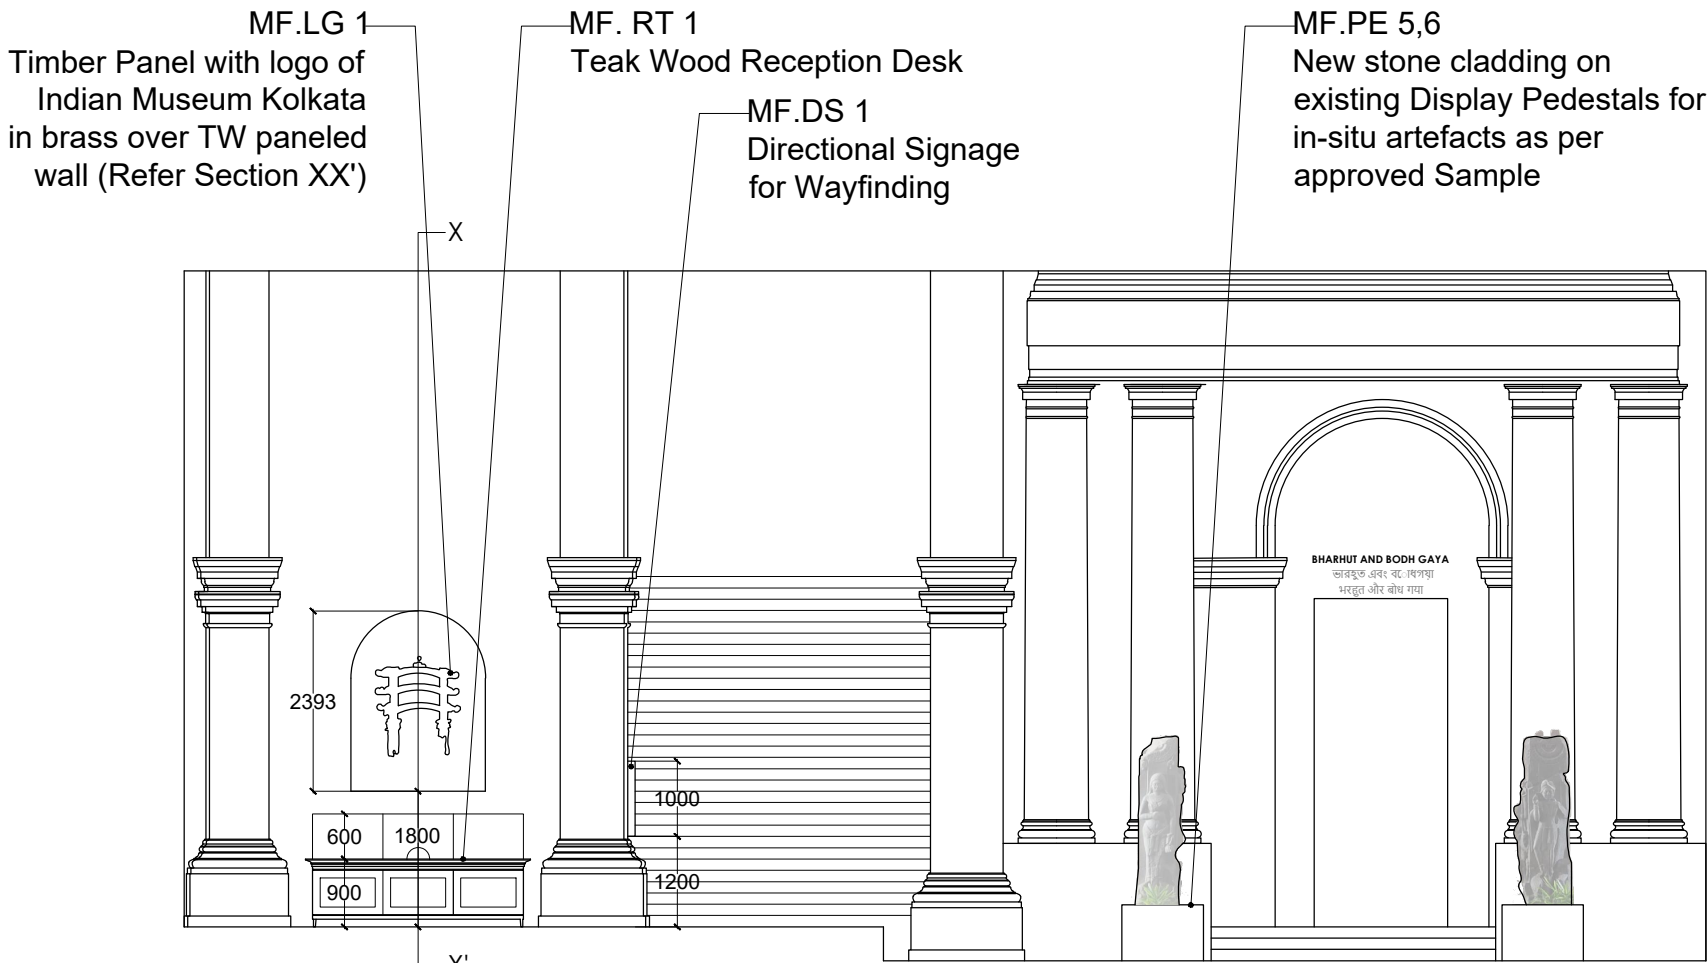

ELEVATION B

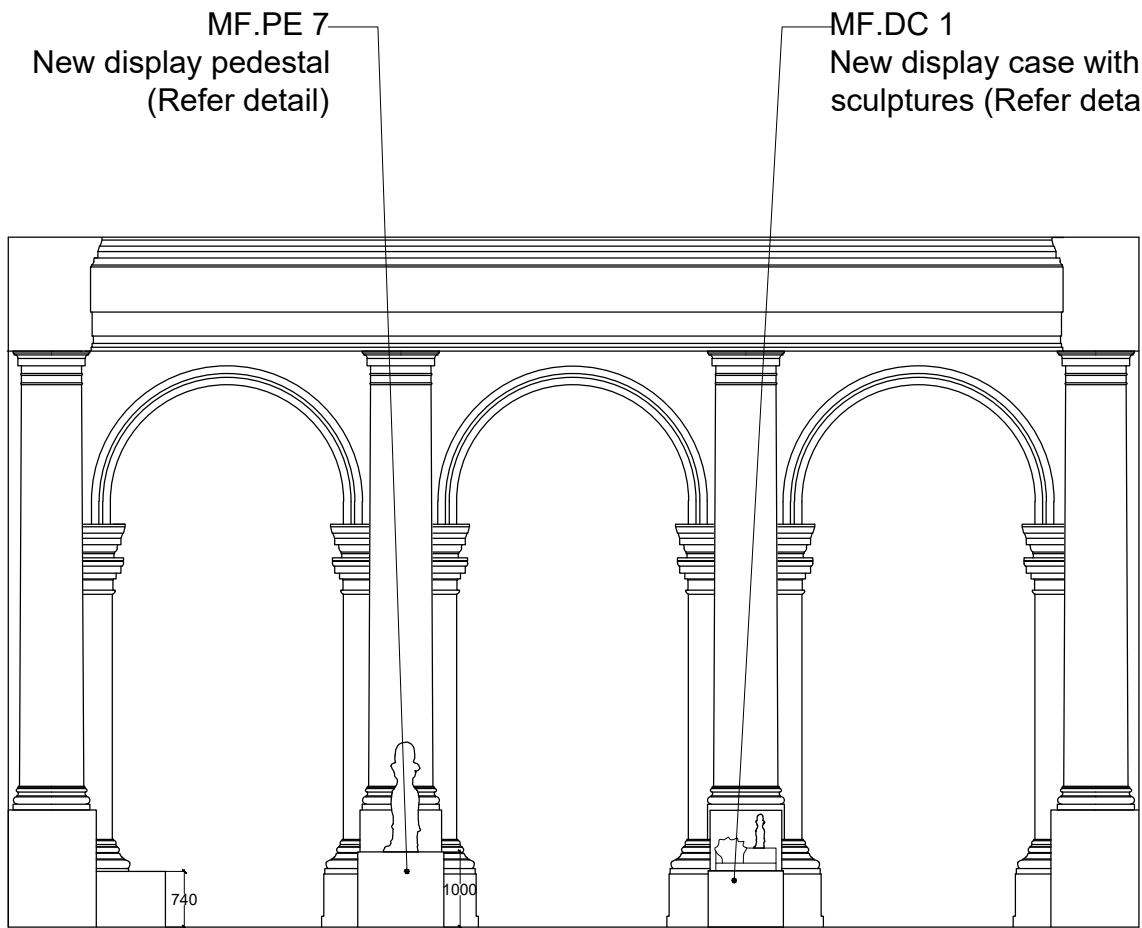

ELEVATION D

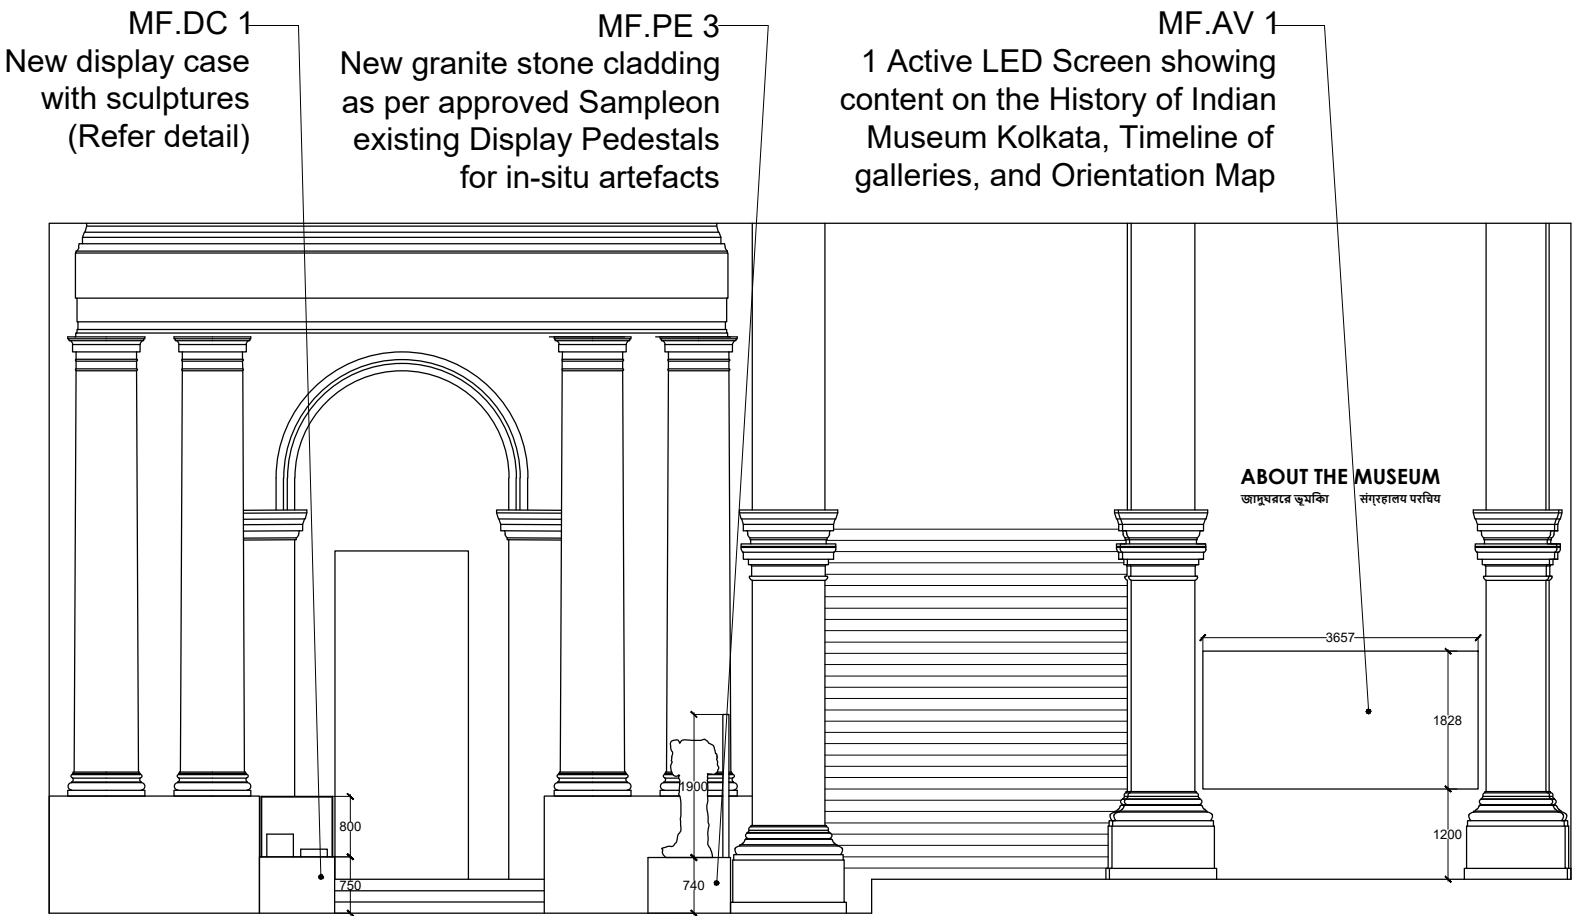


ELEVATION C

**NOTES:**

All dimensions are in millimeters

**KEY PLAN**

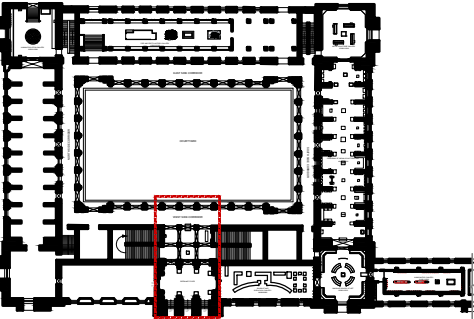

**LEGEND**

DP	Display Panel
DC	Display Case
DS	Display Shelf
PE	Pedestal
WM	Wall Mural
WG	Wall Graphics
CP	Canvas Painting
M	Model
MET	Mock Excavation Trench
CP	Canvas Painting
AV	Audio Visuals
	Interactive
P	Projection
HP	Holographic Projection
GS	Gallery Signage
DS	Directional Signage
LG	Logo
RT	Reception Table
CC	Crowd Control Barrier

**SCALE:** 1:100

0 1m 2m



**DRAWING NAME:** LAYOUT

**ENTRANCE FOYER**

**DRAWN BY:** Sohini Pyne

**CHECKED BY:** Shikha Jain

**DRAWING NUMBER:** IMK/GF/MF/02

**SERIES:** Tender Drawings

**PROJECT:**

PLANNING, CONTENT DEVELOPMENT, DESIGNING, RETROFITTING AND CURATORIAL WORK FOR THE INDIAN MUSEUM, KOLKATA

**CLIENT:**

INDIAN MUSEUM, KOLKATA

**CONSULTANT:**


**DRONAH**  
DEVELOPMENT & RESEARCH  
ORGANISATION FOR NATURE,ARTS  
& HERITAGE

A-258, SOUTH CITY-1  
GURGAON-122001




MF. PE 1, 3-6

As existing

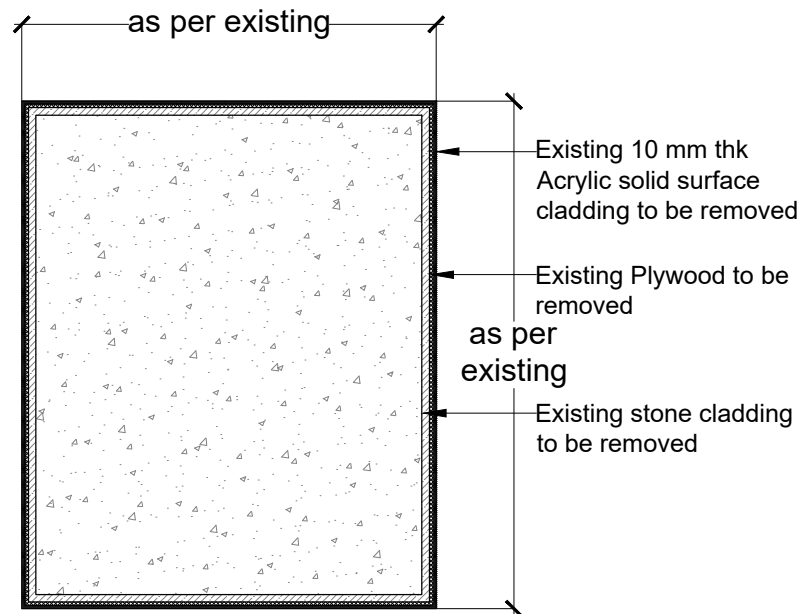


PLAN

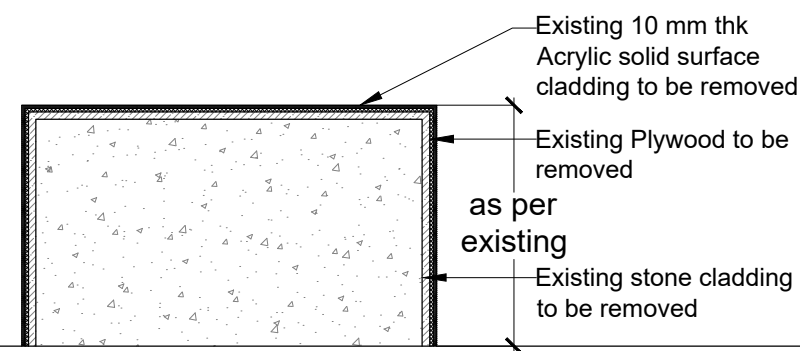


SECTION

Proposed

as per existing  
dimension of  
concrete base

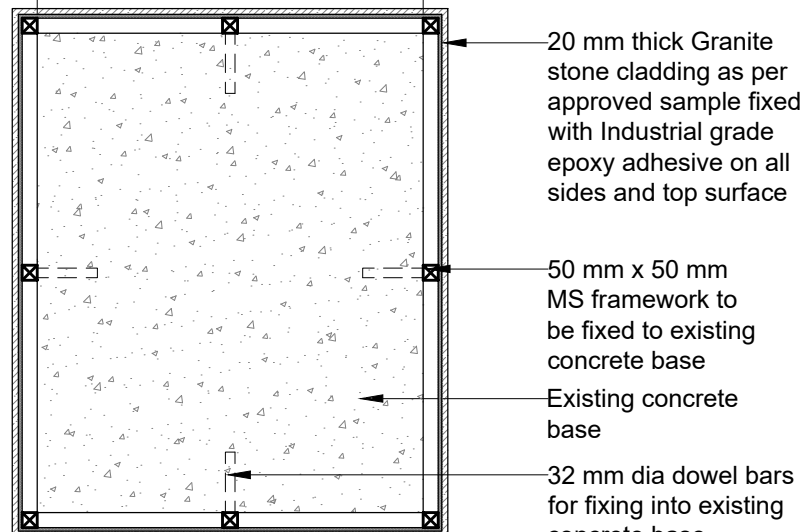


PLAN

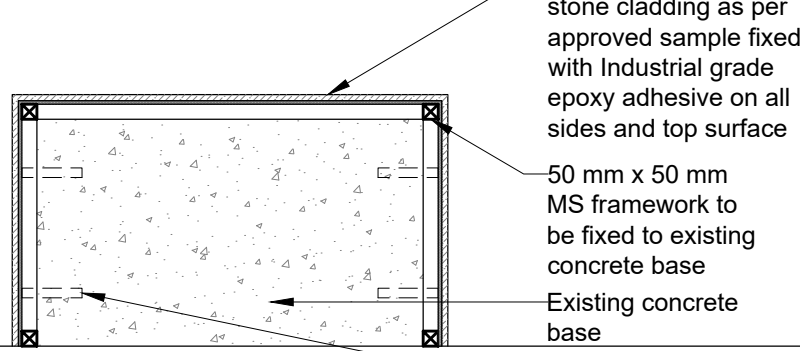


SECTION

MF. PE 2

As existing

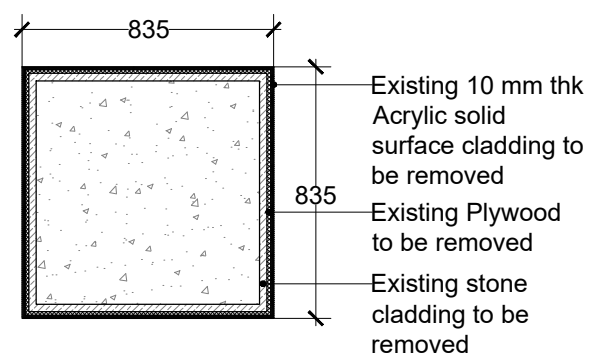


PLAN

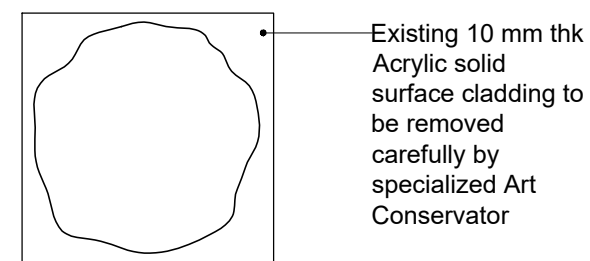


TOP VIEW

Proposed

1000  
as per existing

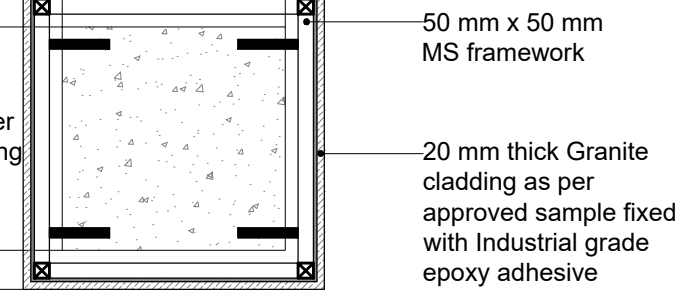


PLAN

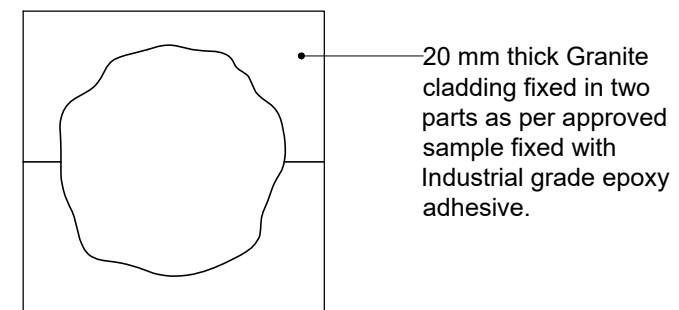


TOP VIEW


MF. PE 3-4

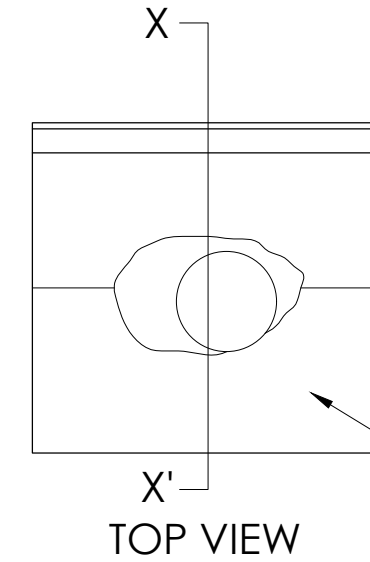


TOP VIEW

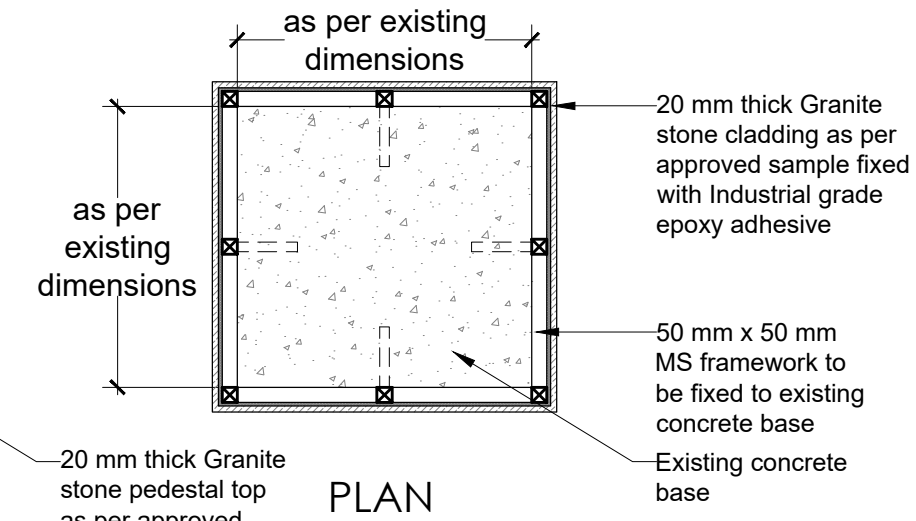

PLAN

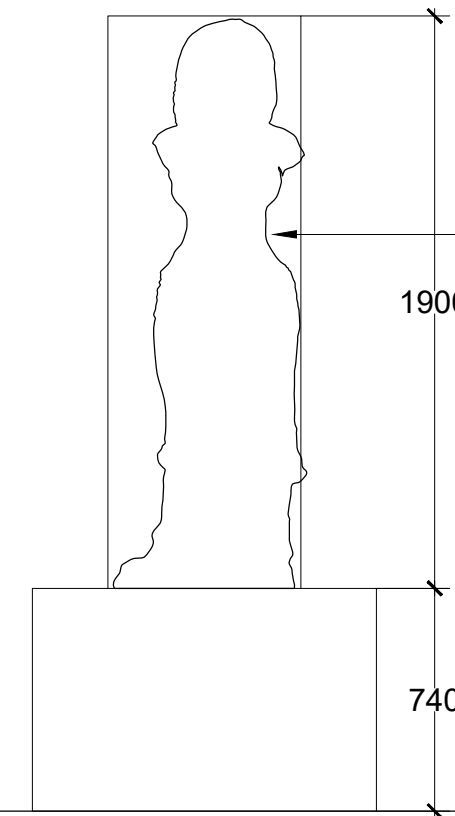

ELEVATION

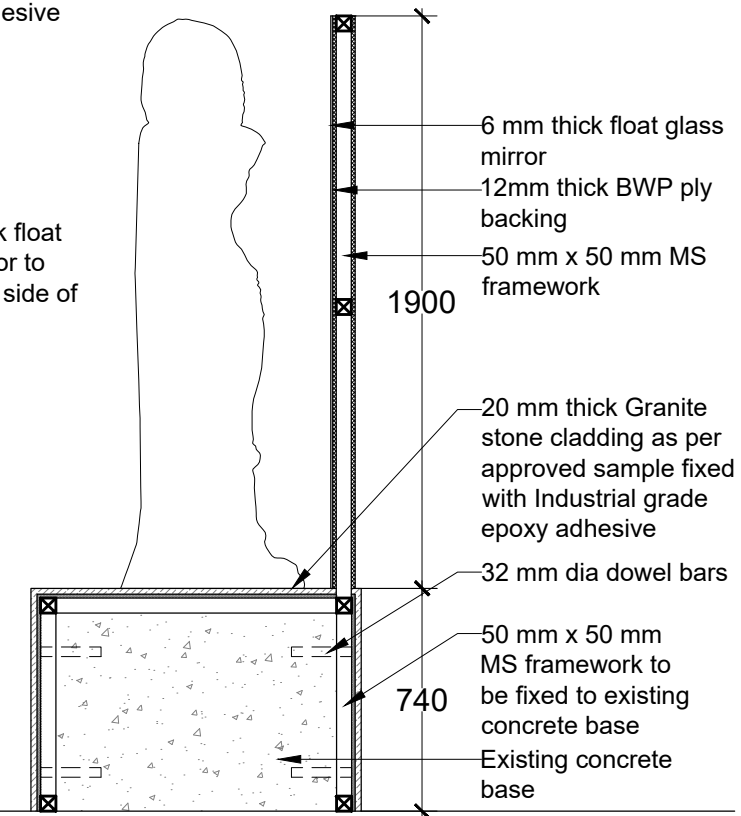


SECTION XX'

NOTES:

All dimensions are in millimeters

KEY PLAN

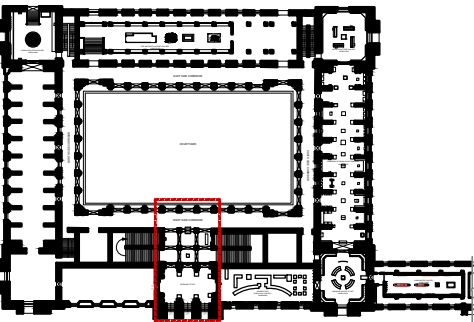

LEGEND

DP	Display Panel
DC	Display Case
DS	Display Shelf
PE	Pedestal
WM	Wall Mural
WG	Wall Graphics
CP	Canvas Painting
M	Model
MET	Mock Excavation Trench
CP	Canvas Painting
AV	Audio Visuals
	Interactive
P	Projection
HP	Holographic Projection
GS	Gallery Signage
DS	Directional Signage
LG	Logo
RT	Reception Table
CC	Crowd Control Barrier

SCALE: 1:20

0 1m 2m



DRAWING NAME: LAYOUT

ENTRANCE FOYER

DRAWN BY: Sohini Pyne

CHECKED BY: Shikha Jain

DRAWING NUMBER: IMK/GF/MF/03

SERIES: Tender Drawings

PROJECT:

PLANNING, CONTENT DEVELOPMENT, DESIGNING, RETROFITTING AND CURATORIAL WORK FOR THE INDIAN MUSEUM, KOLKATA

CLIENT:

INDIAN MUSEUM, KOLKATA

CONSULTANT:

**DRONAH**  
DEVELOPMENT & RESEARCH  
ORGANISATION FOR NATURE,ARTS  
& HERITAGE

A-258, SOUTH CITY-1  
GURGAON-122001

The figure consists of four technical drawings of a square stone sample frame:

- TOP VIEW:** A simple square outline with a dimension line on the left side labeled '1' and a dimension line on the bottom side labeled '1'.
- PLAN:** A detailed top-down view of the frame. It shows an outer square with a total width of 1000 mm and a total height of 1000 mm. Inside this is a smaller square with a width of 926 mm and a height of 926 mm. The frame is composed of a 50 mm x 50 mm MS frame and 25 mm thick Granite stone cladding fixed with Industrial grade epoxy adhesive. The cladding is shown as a hatched area surrounding the inner square.
- ELEVATION:** A simple square outline with a dimension line on the left side labeled '1'.
- SECTION:** A detailed cross-sectional view of the frame. It shows the 50 mm x 50 mm MS framework and the 25 mm thick Granite stone cladding fixed with Industrial grade epoxy adhesive. The total height is 1000 mm. The cladding is shown as a hatched area surrounding the inner square.

The drawings illustrate the construction and dimensions of the MF DC 1 display case. The **TOP VIEW** shows a rectangular layout with a central display area and two side panels. The **PLAN @ 2-2'** provides a cross-sectional view of the top, showing the 20 mm thick Granite stone cladding, the 50 mm x 50 mm MS framework, and the 20 mm thick Granite stone cladding. The **ELEVATION** shows the front view with a total height of 1550 mm and a base width of 750 mm. The **SECTION @ 3-3'** shows a cross-section of the side, highlighting the 8mm thick extra clear toughened glass, the 50 mm x 50 mm MS framework, and the 20 mm thick Granite stone cladding. The section also shows the 20 mm thick Granite stone cladding and the 50 mm x 50 mm MS framework.

**MF. DC 1**

20 mm thick Granite cladding as per approved sample fixed with Industrial grade epoxy adhesive

**TOP VIEW**

Matt acrylic pedestal x 2

**PLAN @ 2-2'**

1000  
926

1000

50 mm x 50 mm MS framework

926

20 mm thick Granite stone cladding as per approved sample fixed with Industrial grade epoxy adhesive

**ELEVATION**

3

1550

2

2'

3'

**SECTION @ 3-3'**

800

750

100

300

713

Glass to glass UV joint

8mm thick extra clear toughened glass to be fixed in groove of stone

Matt acrylic pedestal x 2

50 mm x 50 mm MS framework

20 mm thick Granite stone cladding as per approved sample fixed with Industrial grade epoxy adhesive

750

BENGAL PAINTING GALLERY  
বাংলা পটচিত্র গ্যালারী

1200

টোলট  
উৎসর্গ  
পর্যবেক্ষণ

50x75 mm TW battens

30 mm thick solid teakwood fixed to wall

10 mm thick Brass letters of 100 mm height

12 mm thk Brass Logo of Indian Museum

30 mm thk Solid Teak Wood Panel with Melamine polish finish

48mm x 100mm timber battens fixed on wall

**SCALE- 1:50**

Technical drawing of a Cornice band to camouflage metal conduits. The drawing shows a cross-section of the band with dimensions and material specifications.

Dimensions:

- Overall height: 140
- Overall width: 76
- Top decorative element height: 20
- Top decorative element width: 25
- Top decorative element depth: 12
- Top decorative element thickness: 20
- Top decorative element width: 43
- Top decorative element depth: 50

Material specifications:


- Ornamental beading in solid Wood finished with Melamine polish.
- 19mm thick Marine Grade BWP Plywood (IS: 710)
- Solid wood finished with Melamine polish.

Cornice band to camouflage Metal conduits


<b>DP</b>	Display Panel
<b>DC</b>	Display Case
<b>DS</b>	Display Shelf
<b>PE</b>	Pedestal
<b>WM</b>	Wall Mural
<b>WG</b>	Wall Graphics
<b>CP</b>	Canvas Painting
<b>M</b>	Model
<b>MET</b>	Mock Excavation Trench
<b>CP</b>	Canvas Painting
<b>AV</b>	Audio Visuals
	Interactive
<b>P</b>	Projection
<b>HP</b>	Holographic Projection
<b>GS</b>	Gallery Signage
<b>DS</b>	Directional Signage
<b>LG</b>	Logo
<b>RT</b>	Reception Table
<b>CC</b>	Crowd Control Barrier

A-258, SOUTH CITY-1  
GURGAON-122001

MF. RT 1

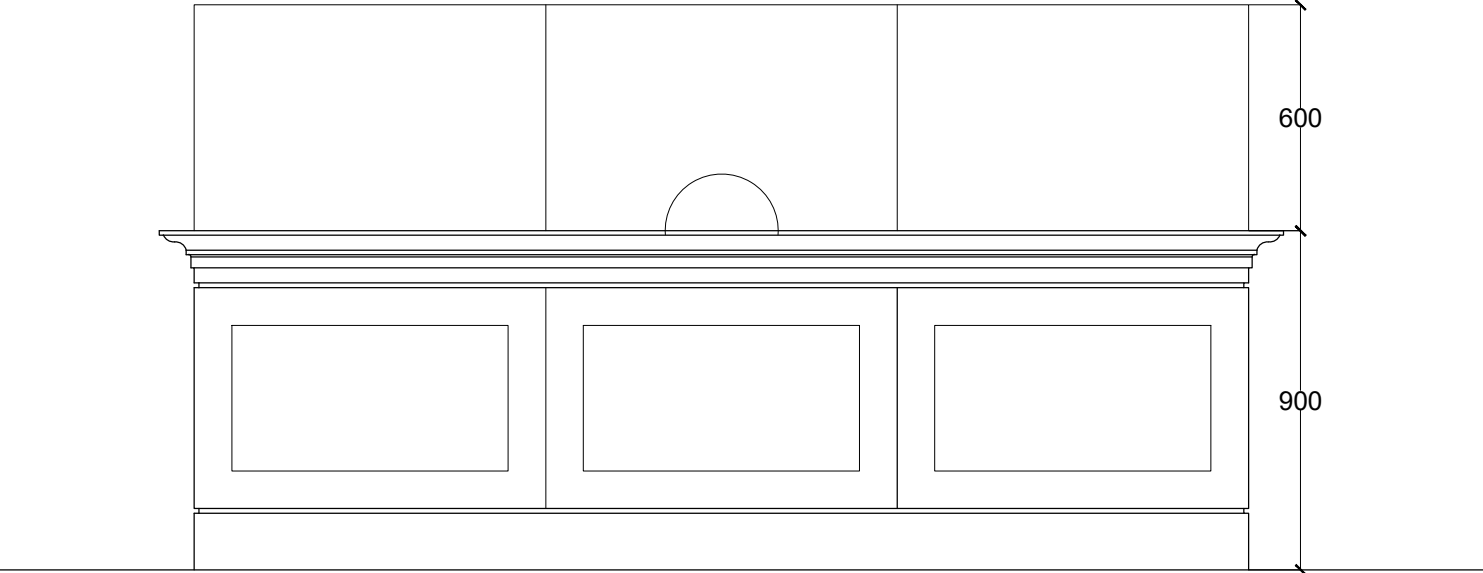


FRONT ELEVATION

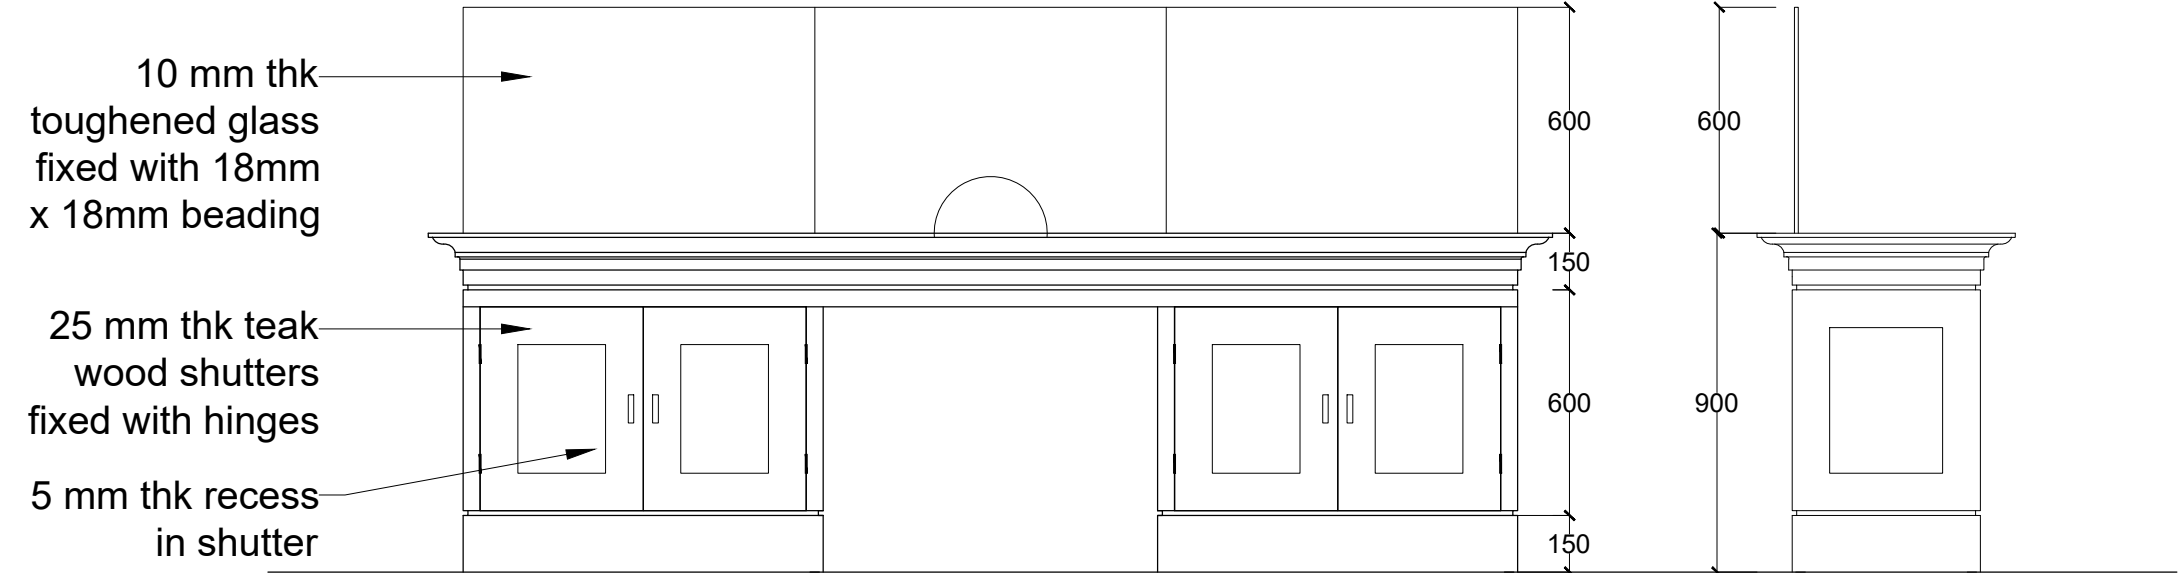


REAR ELEVATION

SIDE ELEVATION

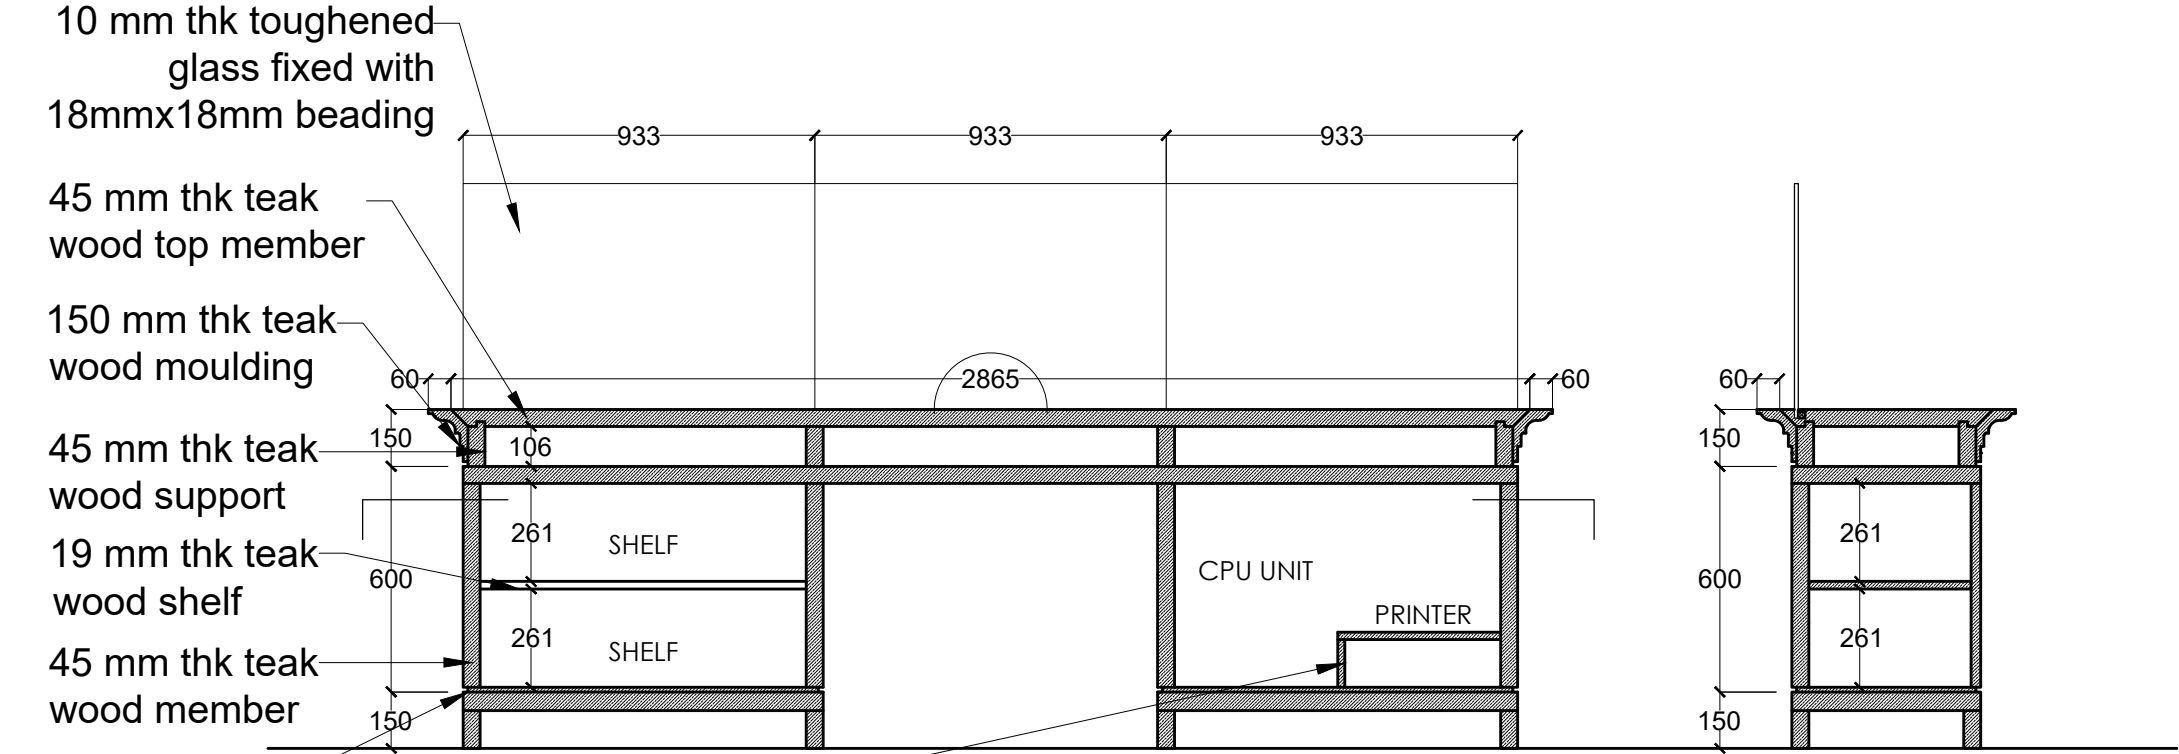

SECTION AA'

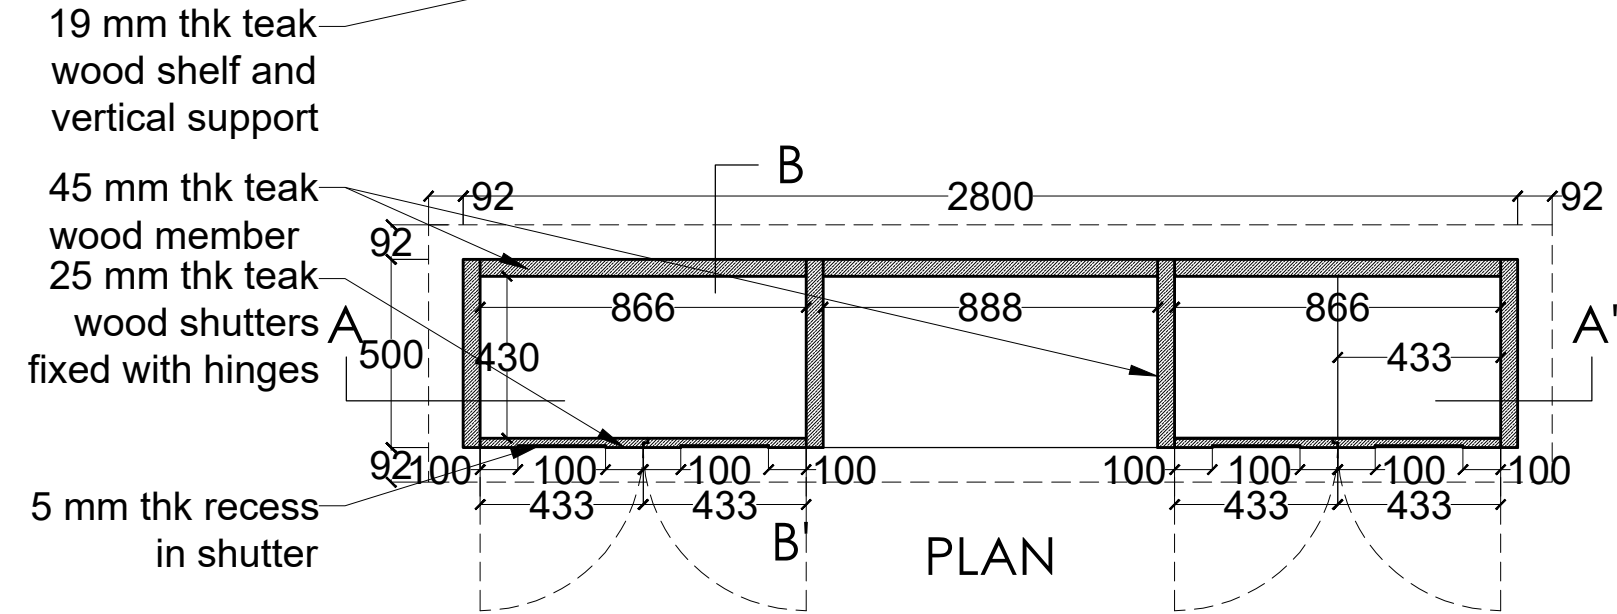


PLAN

Note:  
45 mm thick Second Class TW and 18 mm thick Marine grade BWP (IS 710) ply to be used and finished with Melamine polish.

NOTES:

All dimensions are in millimeters

KEY PLAN

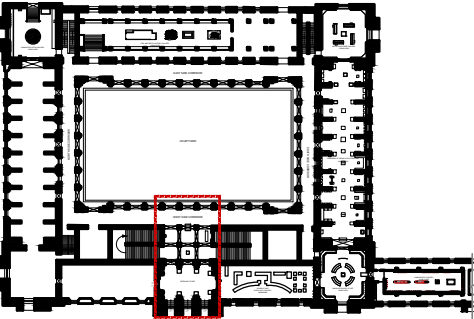

LEGEND

DP	Display Panel
DC	Display Case
DS	Display Shelf
PE	Pedestal
WM	Wall Mural
WG	Wall Graphics
CP	Canvas Painting
M	Model
MET	Mock Excavation Trench
CP	Canvas Painting
AV	Audio Visuals
	Interactive
P	Projection
HP	Holographic Projection
GS	Gallery Signage
DS	Directional Signage
LG	Logo
RT	Reception Table
CC	Crowd Control Barrier

SCALE: 1:20

0 1m 2m



DRAWING NAME: LAYOUT

ENTRANCE FOYER

DRAWN BY: Sohini Pyne

CHECKED BY: Shikha Jain

DRAWING NUMBER: IMK/GF/EF/05

SERIES: Tender Drawings

PROJECT:

PLANNING, CONTENT DEVELOPMENT, DESIGNING, RETROFITTING AND CURATORIAL WORK FOR THE INDIAN MUSEUM, KOLKATA

CLIENT:


INDIAN MUSEUM, KOLKATA

CONSULTANT:

**DRONAH**  
DEVELOPMENT & RESEARCH  
ORGANISATION FOR NATURE,ARTS  
& HERITAGE

A-258, SOUTH CITY-1  
GURGAON-122001



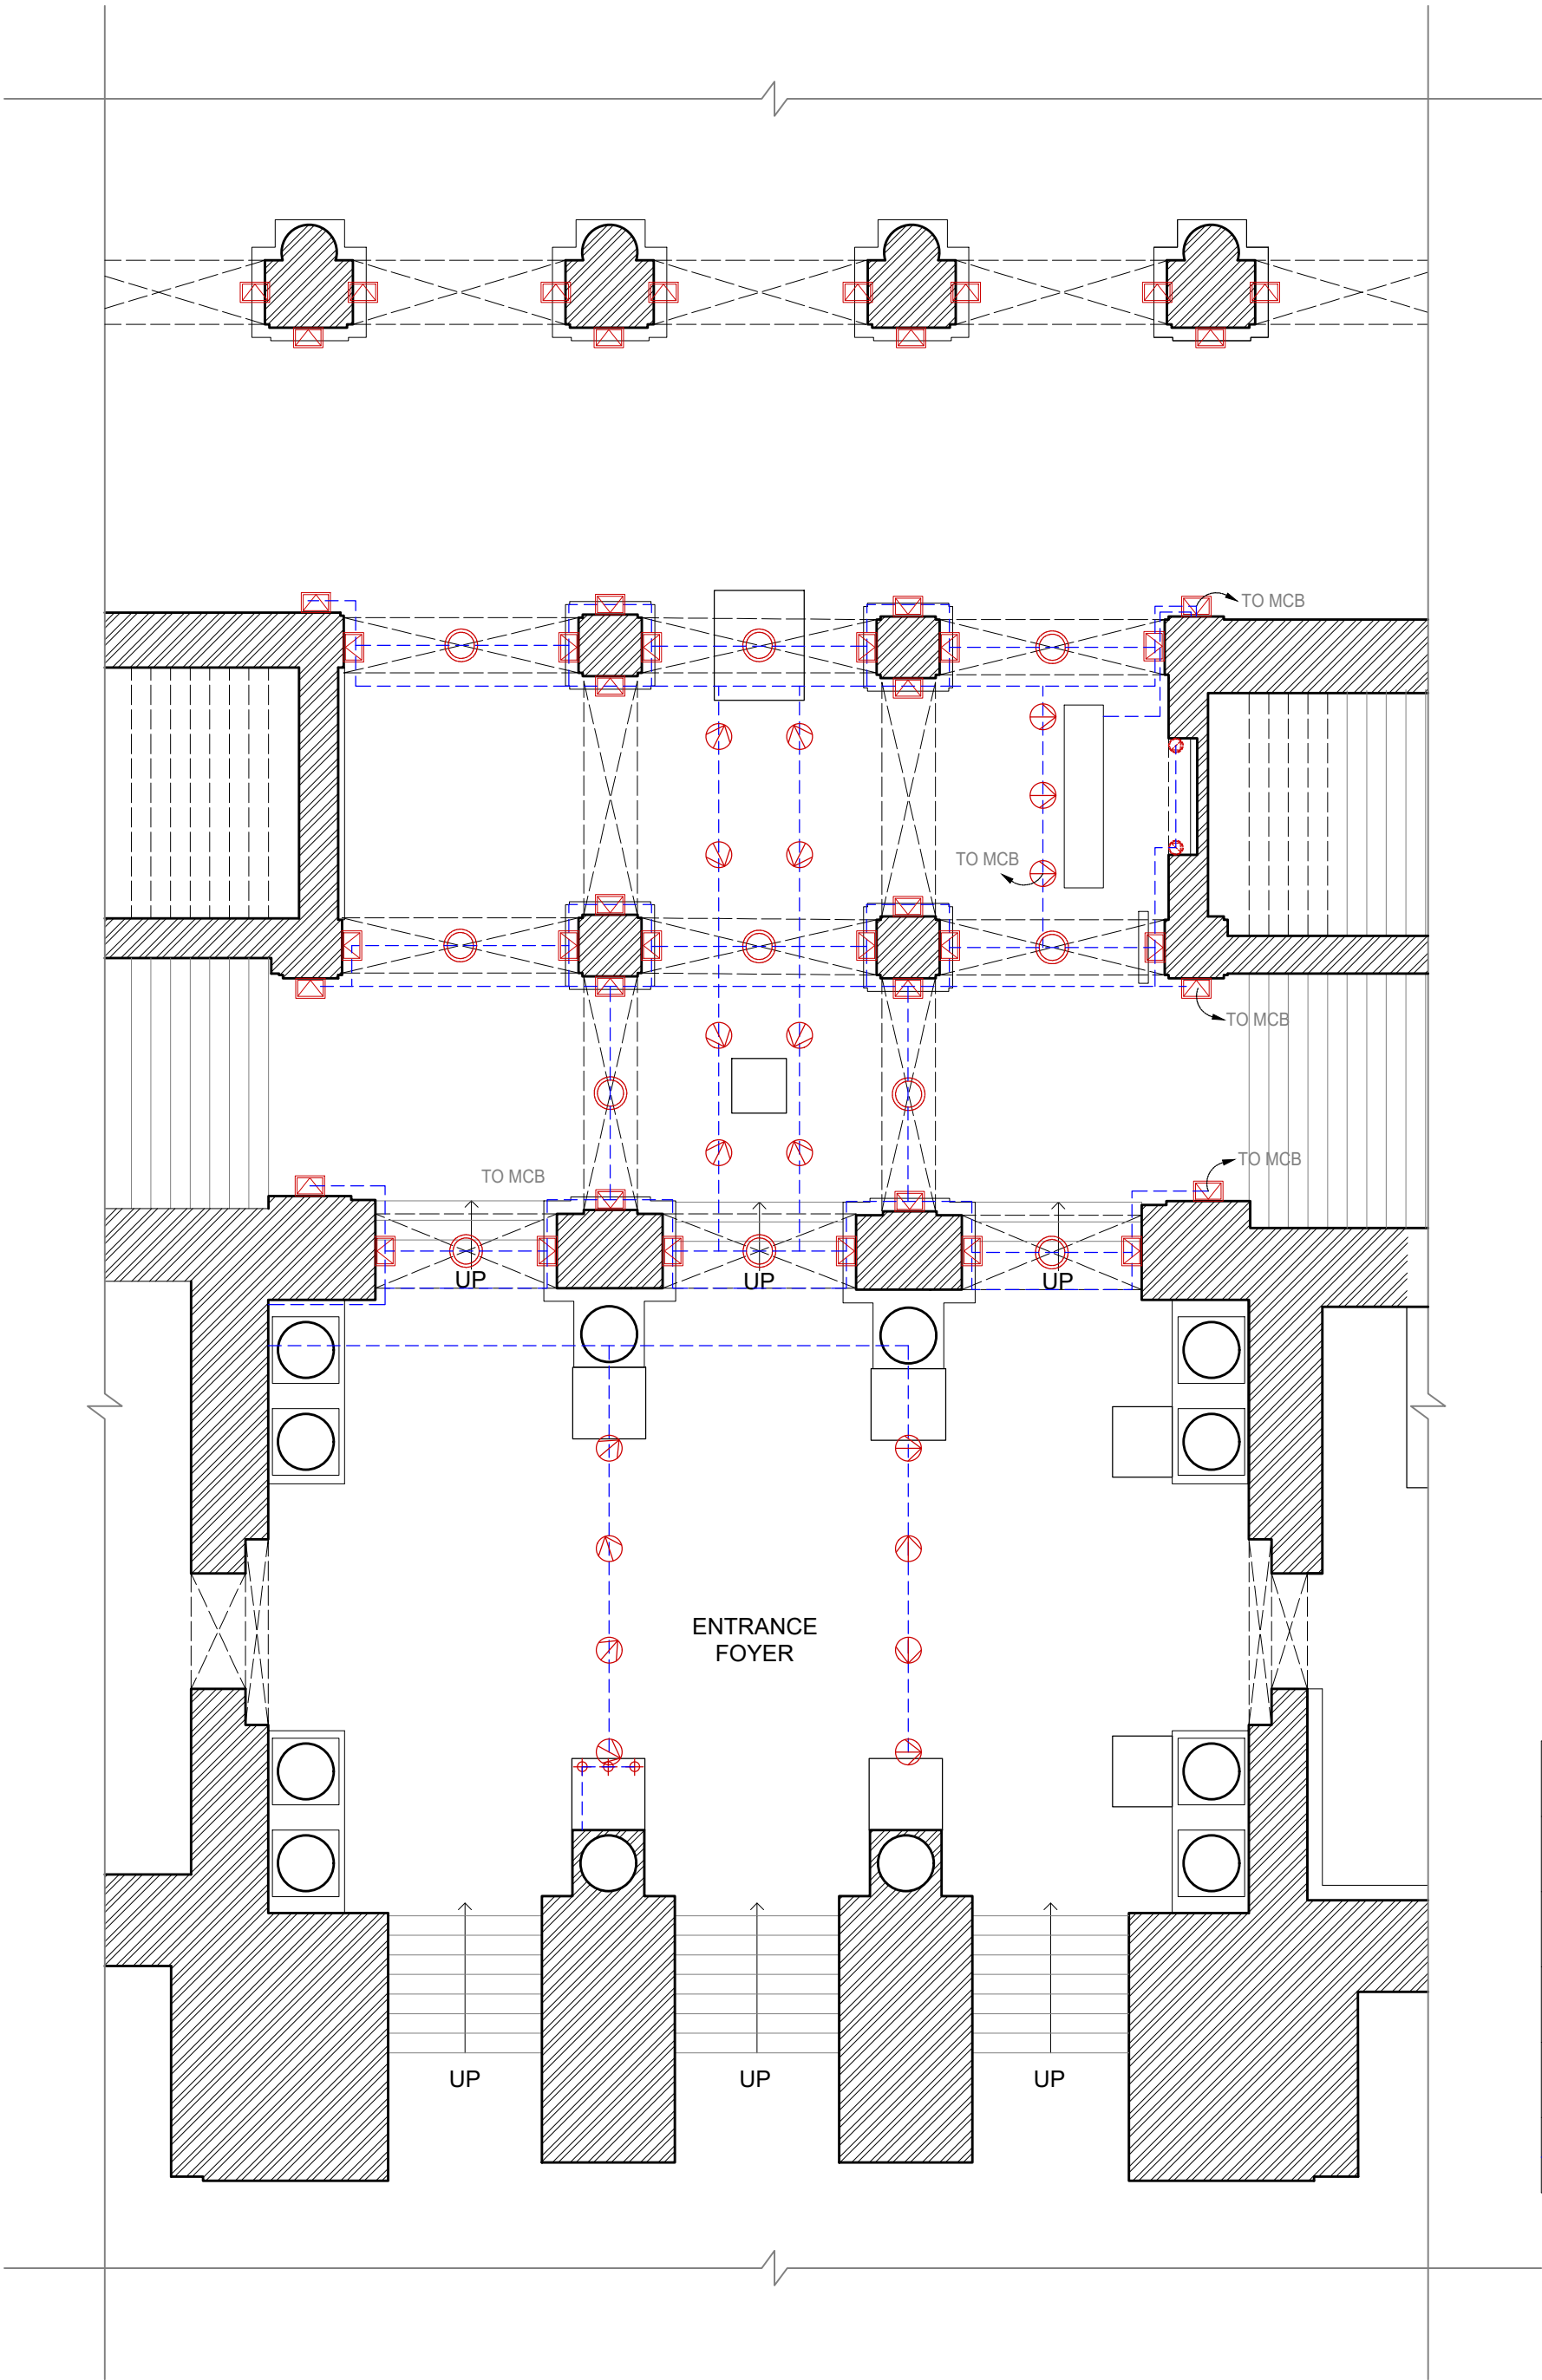


Sym	Type
	Track light on frame
	Pendant Light (for general lighting)
	Mini cabinet tiltable spot light
	LED Wall washer uplight (for arches)
	Ceiling Light Conduit

NOTES:

All dimensions are in millimeters

KEY PLAN

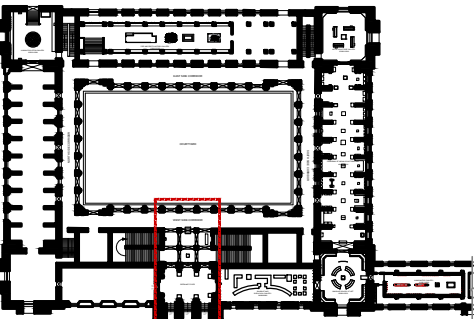

LEGEND

DP	Display Panel
DC	Display Case
DS	Display Shelf
PE	Pedestal
WM	Wall Mural
WG	Wall Graphics
CP	Canvas Painting
M	Model
MET	Mock Excavation Trench
CP	Canvas Painting
AV	Audio Visuals
	Interactive
P	Projection
HP	Holographic Projection
GS	Gallery Signage
DS	Directional Signage
LG	Logo
RT	Reception Table
CC	Crowd Control Barrier

SCALE: 1:100

0 1m 2m



DRAWING: LIGHTING LAYOUT

ENTRANCE FOYER

DRAWN BY: Sohini Pyne

CHECKED BY: Shikha Jain

DRAWING NUMBER: IMK/GF/MF/06

SERIES: Tender Drawings

PROJECT:

PLANNING, CONTENT DEVELOPMENT, DESIGNING, RETROFITTING AND CURATORIAL WORK FOR THE INDIAN MUSEUM, KOLKATA

CLIENT:

INDIAN MUSEUM, KOLKATA


CONSULTANT:

**DRONAH**  
DEVELOPMENT & RESEARCH  
ORGANISATION FOR NATURE,ARTS  
& HERITAGE

A-258, SOUTH CITY-1  
GURGAON-122001






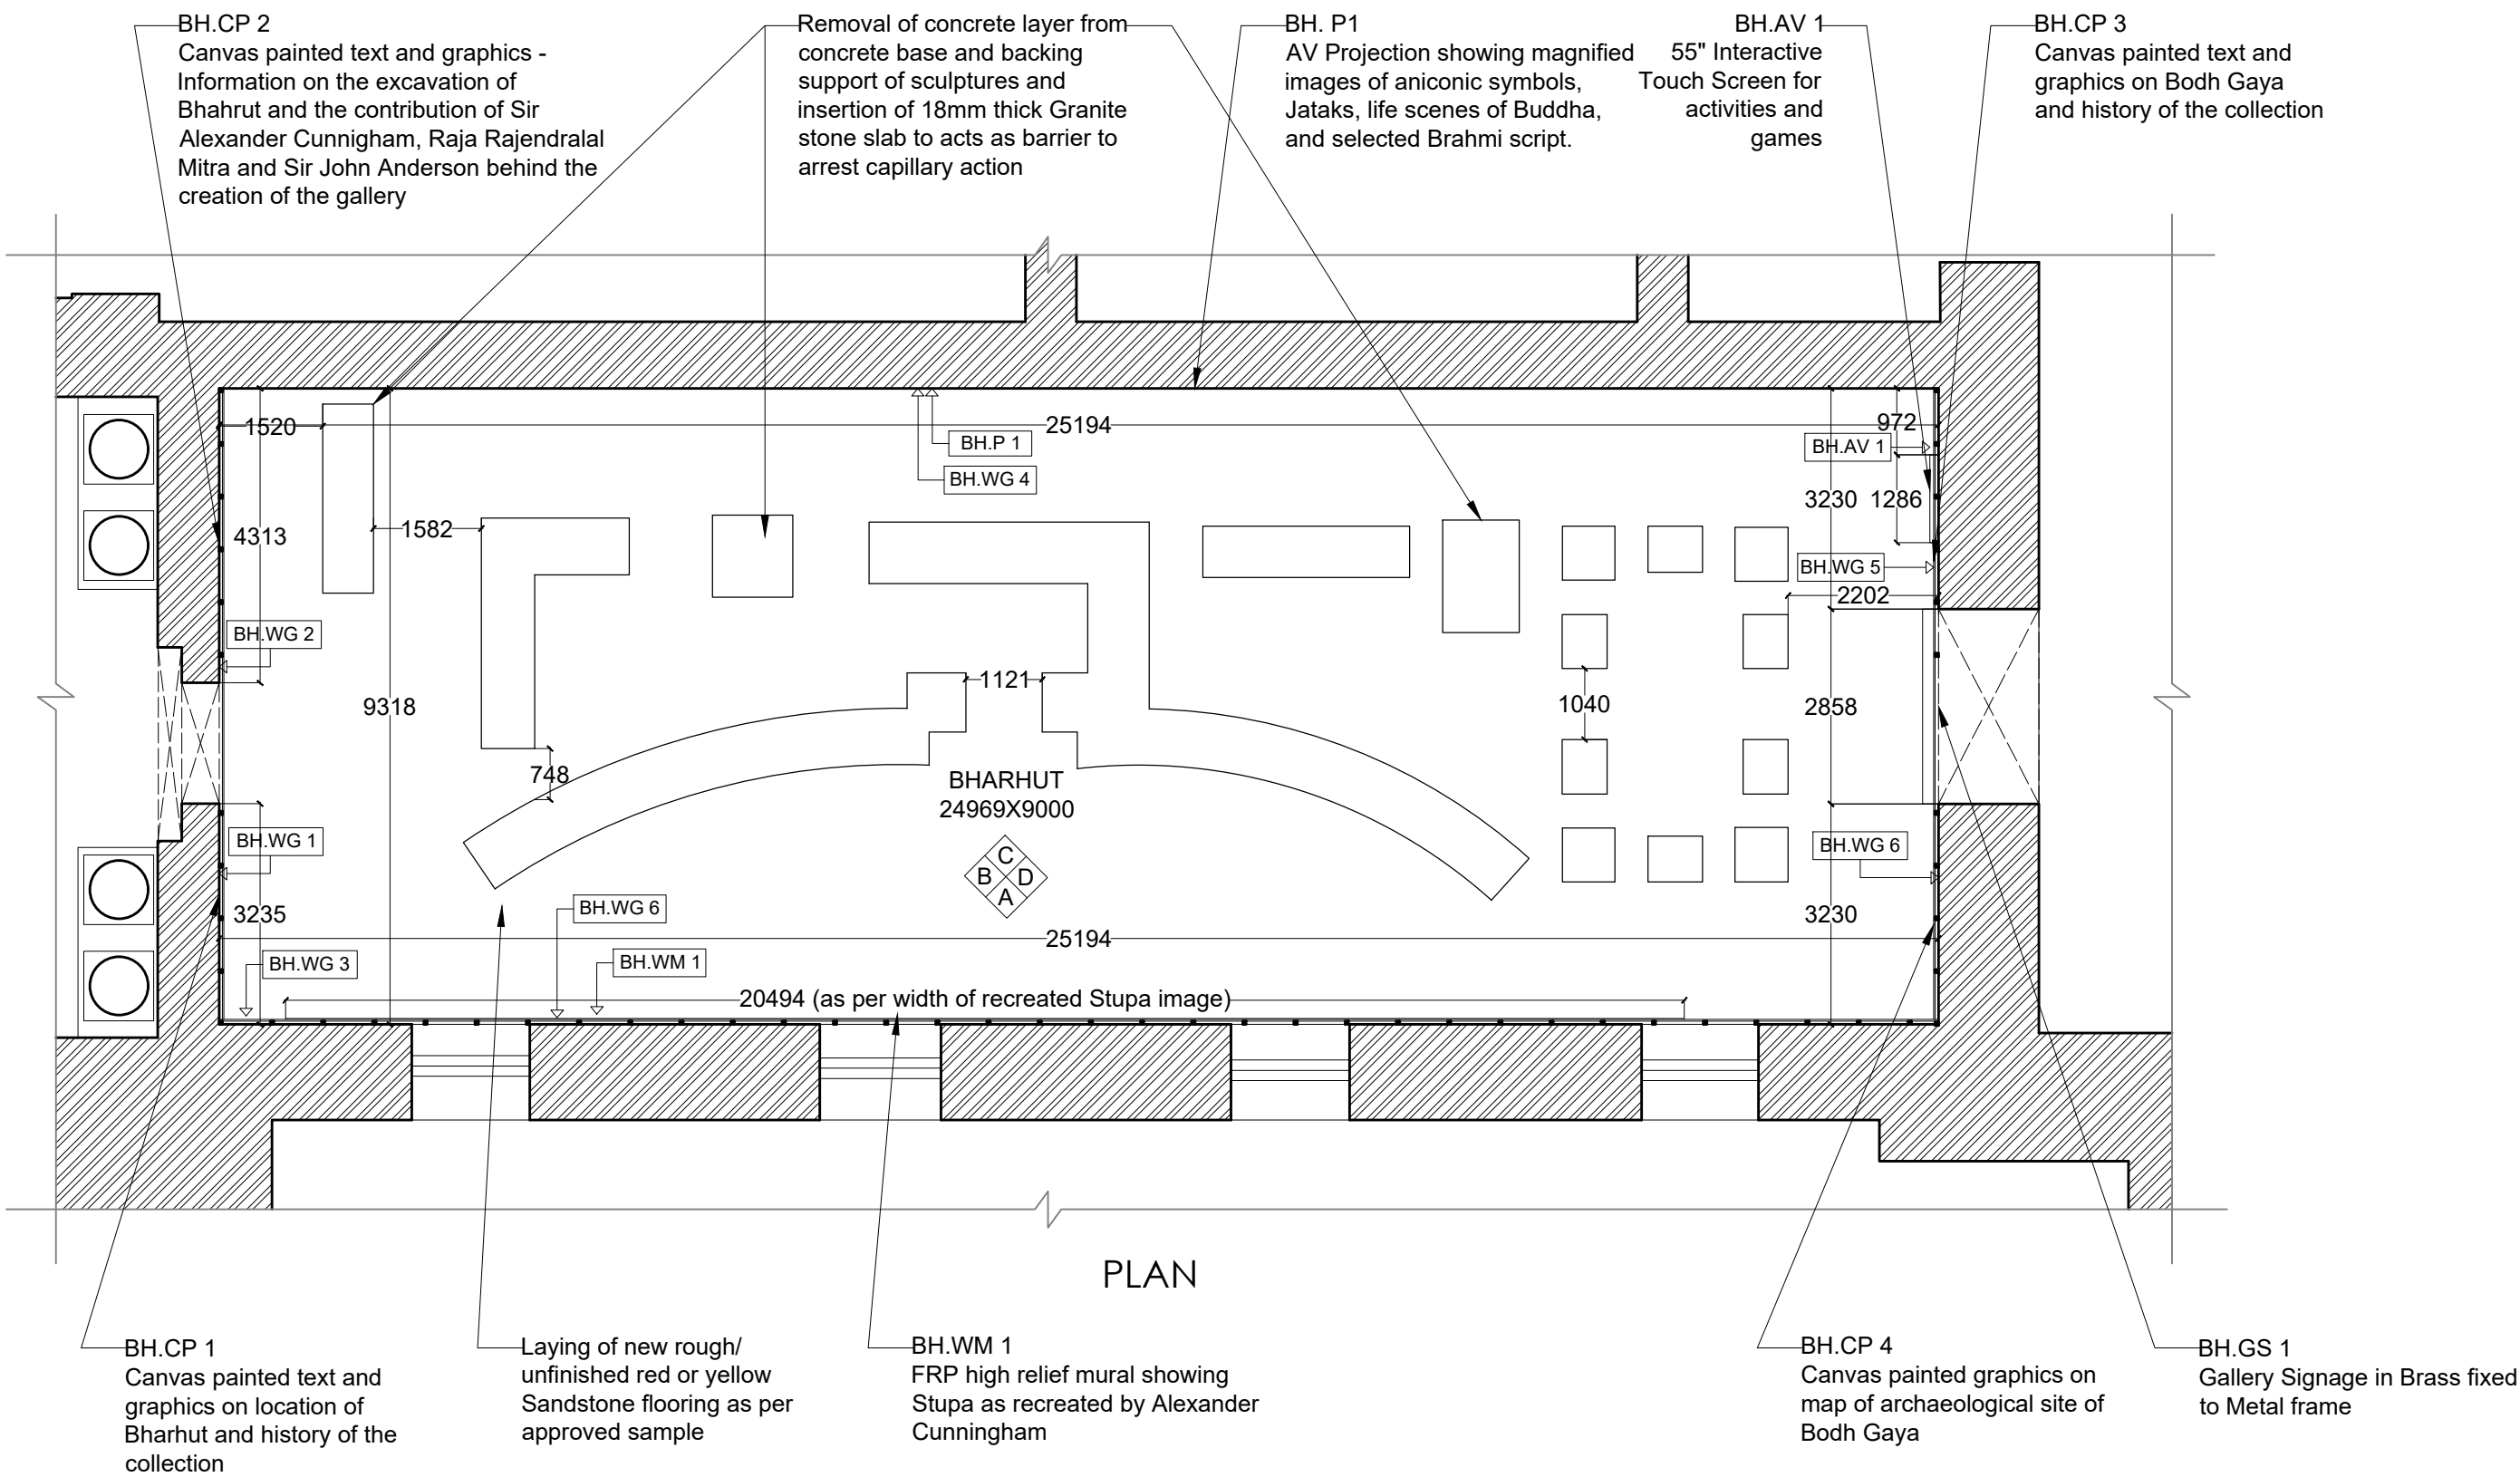

NOTES:

All dimensions are in millimeters

KEY PLAN

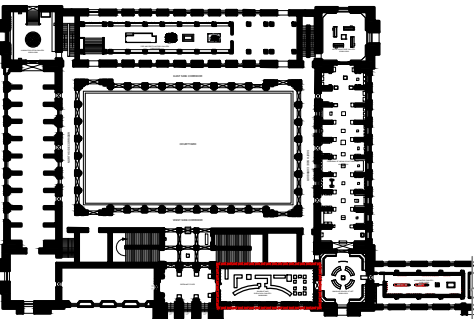

LEGEND

DP	Display Panel
DC	Display Case
DS	Display Shelf
PE	Pedestal
WM	Wall Mural
WG	Wall Graphics
CP	Canvas Painting
M	Model
MET	Mock Excavation Trench
CP	Canvas Painting
AV	Audio Visuals
I	Interactive
P	Projection
HP	Holographic Projection
GS	Gallery Signage
DS	Directional Signage
LG	Logo
RT	Reception Table
CC	Crowd Control Barrier

SCALE: 1:100

0 1m 2m



NORTH

DRAWING NAME: LAYOUT

BHARHUT AND BODH GAYA

DRAWN BY: Sohini Pyne

CHECKED BY: Shikha Jain

DRAWING NUMBER: IMK/GF/BH/01

SERIES: Tender Drawings

PROJECT:

PLANNING, CONTENT  
DEVELOPMENT, DESIGNING,  
RETROFITTING AND CURATORIAL  
WORK FOR THE INDIAN MUSEUM,  
KOLKATA


CLIENT:

INDIAN MUSEUM, KOLKATA

CONSULTANT:


**DRONAH**  
DEVELOPMENT & RESEARCH  
ORGANISATION FOR NATURE,ARTS  
& HERITAGE

A-258, SOUTH CITY-1  
GURGAON-122001

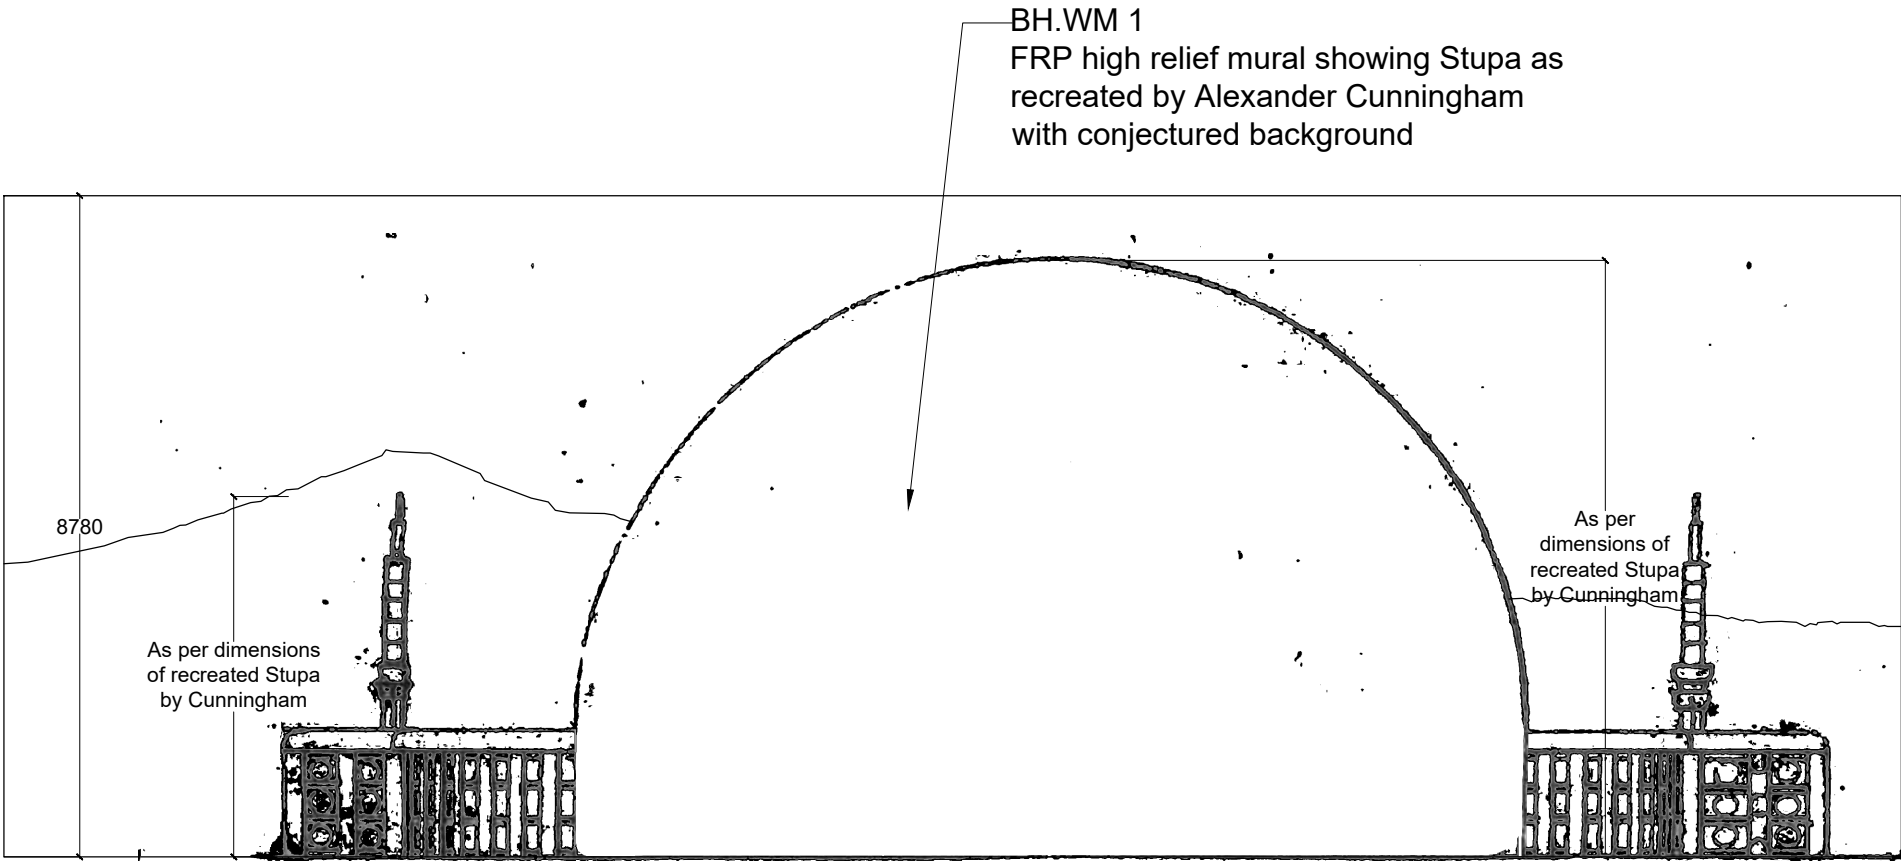


ELEVATION A

BH.CP 2  
Canvas painted text and graphics -  
Information on the excavation of Bhahrut and  
the contribution of Sir Alexander Cunningham,  
Raja Rajendralal Mitra and Sir John Anderson  
behind the creation of the gallery

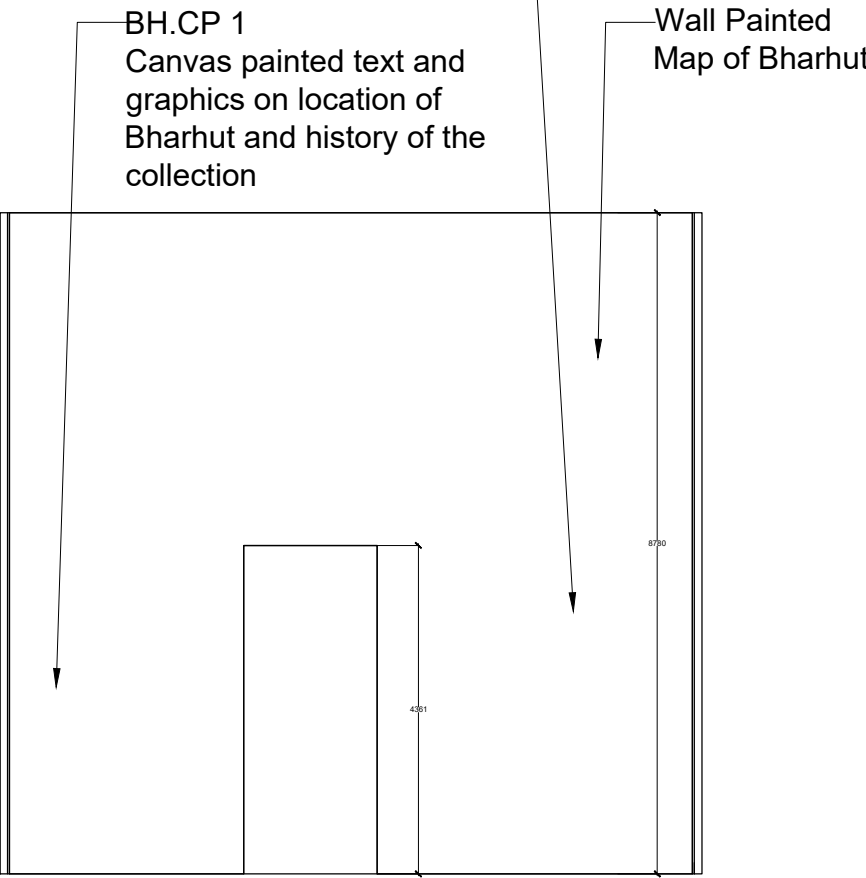

ELEVATION B

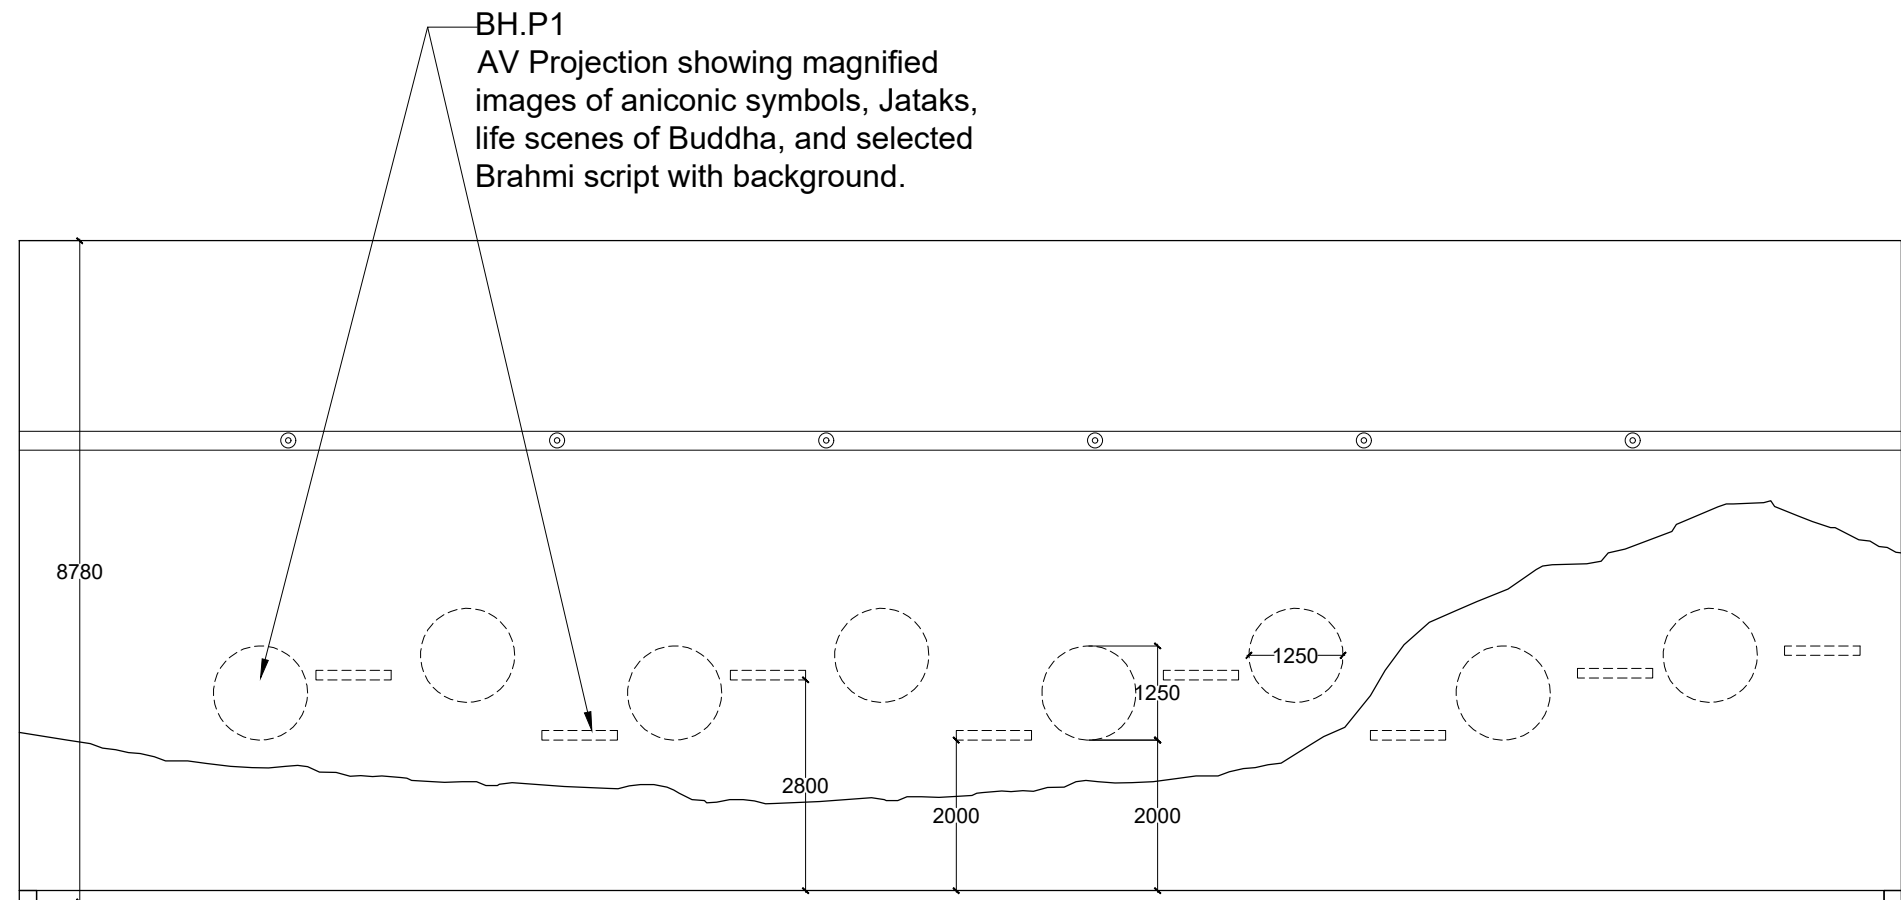


ELEVATION C

BH.CP 3  
Canvas painted text and  
graphics on Bodh Gaya and  
history of the collection

BH.AV 1  
55" Interactive  
Touch Screen

BH.CP 4  
Canvas painted  
graphics on map of  
archaeological site  
of Bodh Gaya

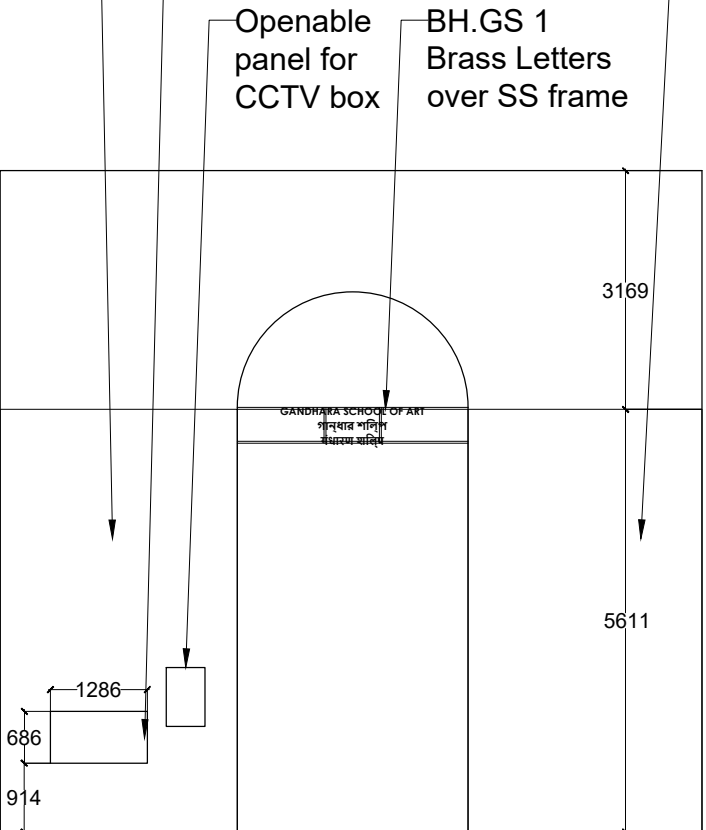


ELEVATION D

NOTES:

All dimensions are in millimeters

KEY PLAN

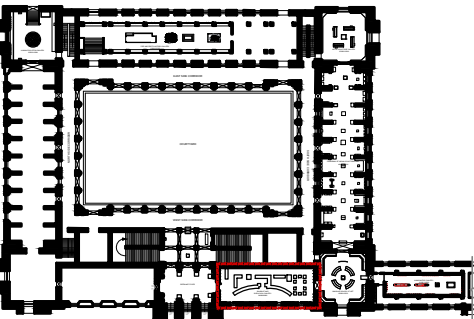

LEGEND

DP	Display Panel
DC	Display Case
DS	Display Shelf
PE	Pedestal
WM	Wall Mural
WG	Wall Graphics
CP	Canvas Painting
M	Model
MET	Mock Excavation Trench
CP	Canvas Painting
AV	Audio Visuals
I	Interactive
P	Projection
HP	Holographic Projection
GS	Gallery Signage
DS	Directional Signage
LG	Logo
RT	Reception Table
CC	Crowd Control Barrier

SCALE: 1:100

0 1m 2m



DRAWING NAME: LAYOUT

BHARHUT AND BODH GAYA

DRAWN BY: Sohini Pyne

CHECKED BY: Shikha Jain

DRAWING NUMBER: IMK/GF/BH/02

SERIES: Tender Drawings

PROJECT:

PLANNING, CONTENT  
DEVELOPMENT, DESIGNING,  
RETROFITTING AND CURATORIAL  
WORK FOR THE INDIAN MUSEUM,  
KOLKATA


CLIENT:

INDIAN MUSEUM, KOLKATA


CONSULTANT:

**DRONAH**  
DEVELOPMENT & RESEARCH  
ORGANISATION FOR NATURE,ARTS  
& HERITAGE


A-258, SOUTH CITY-1  
GURGAON-122001

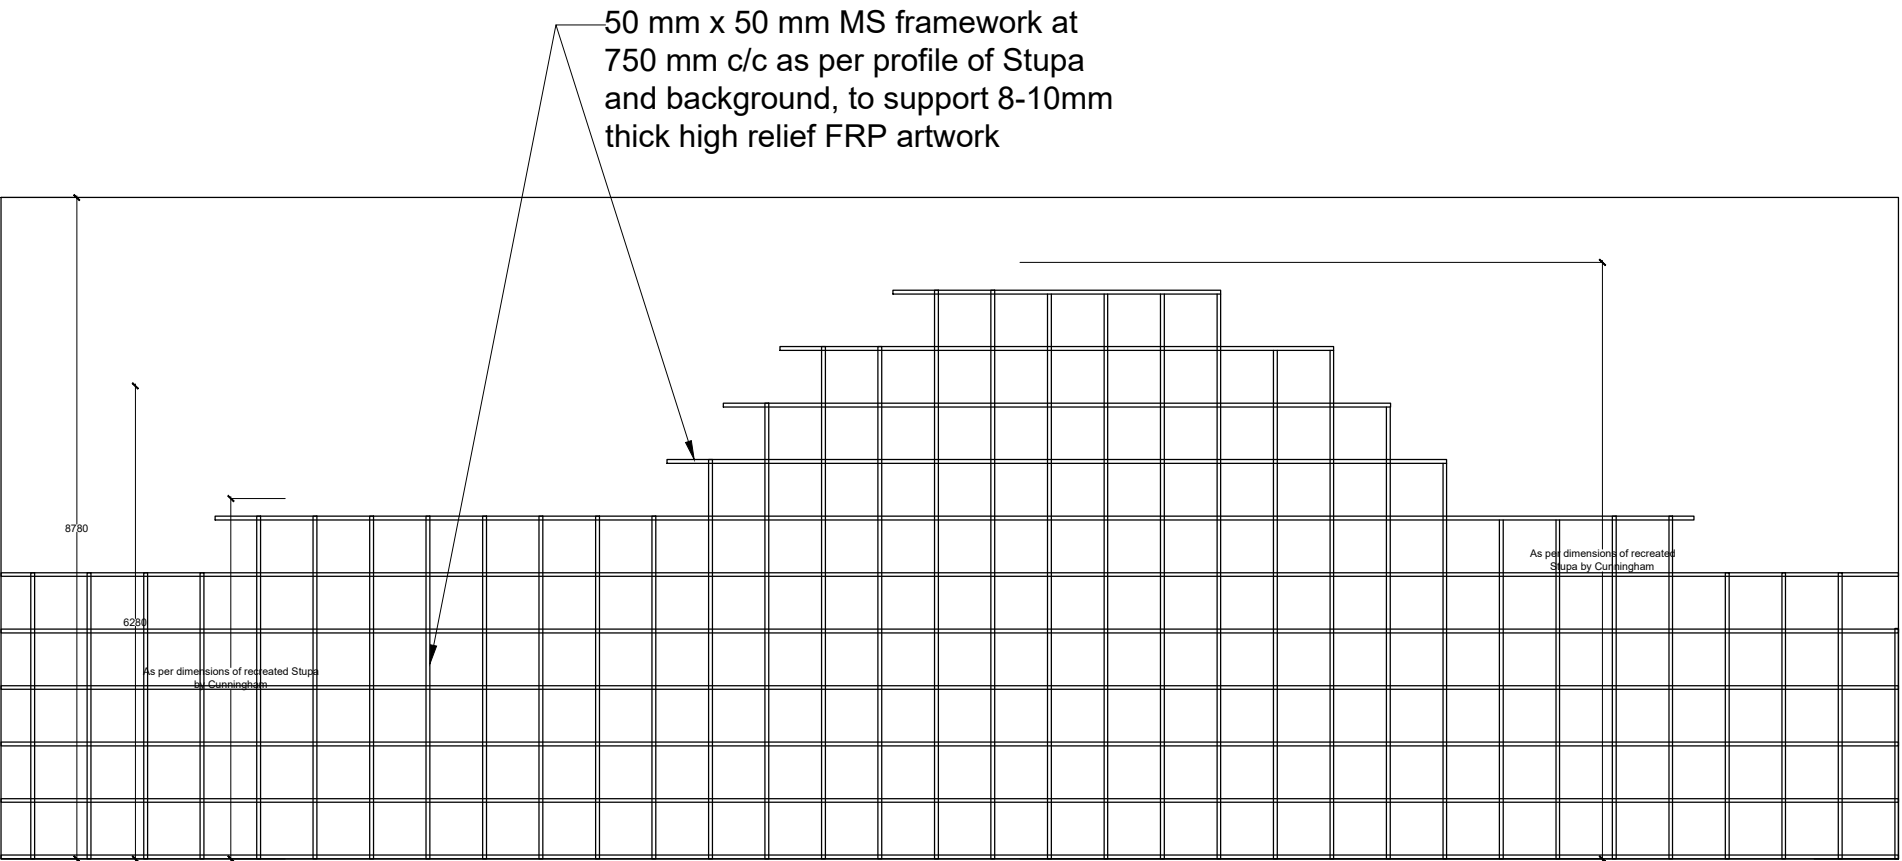

INTERNAL ELEVATION A

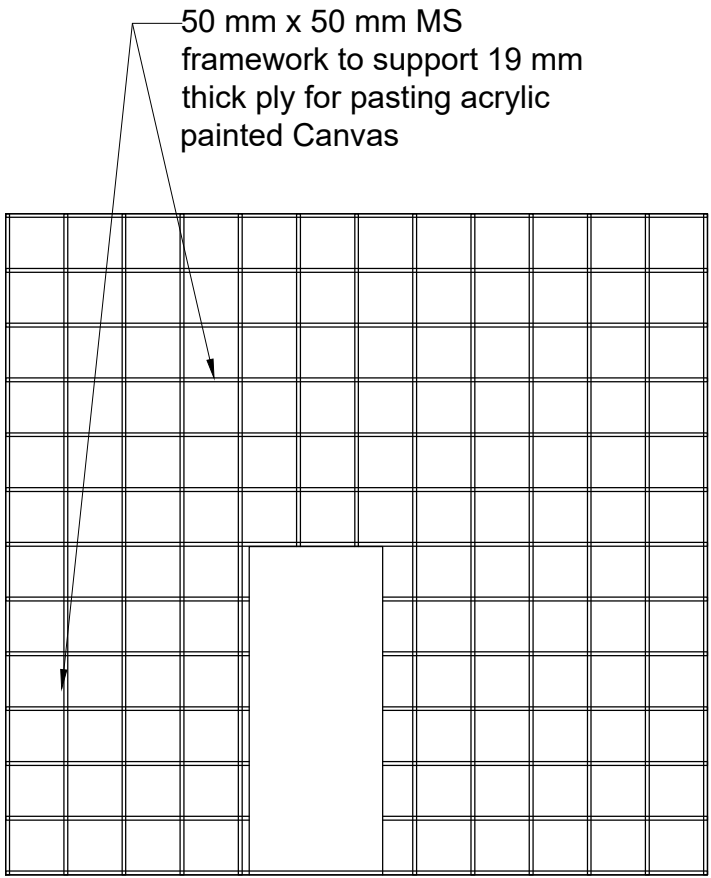


ELEVATION B

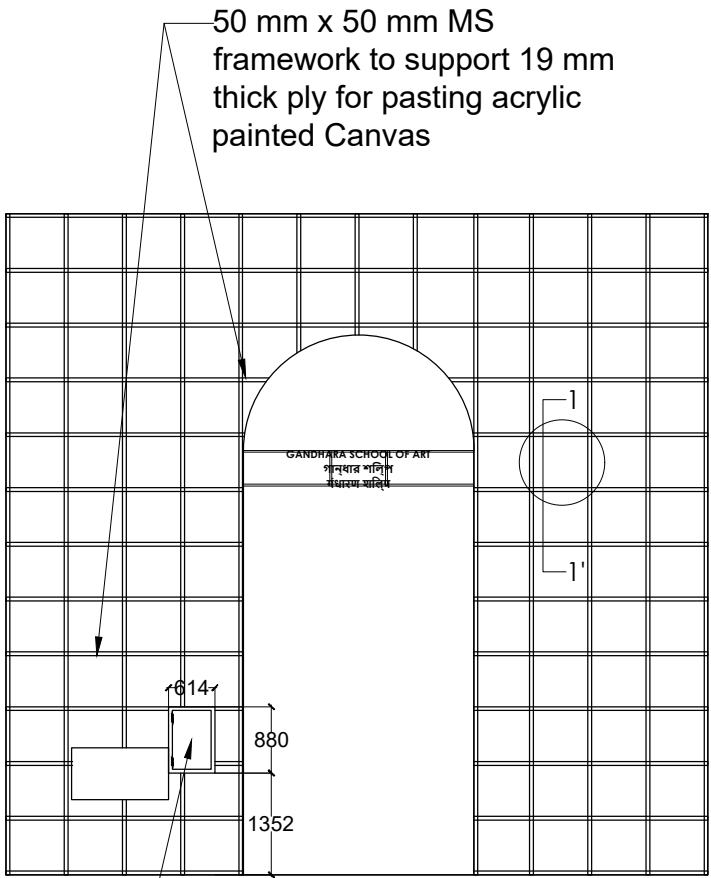


INTERNAL ELEVATION D


SECTION 1-1'  
Scale - 1:20

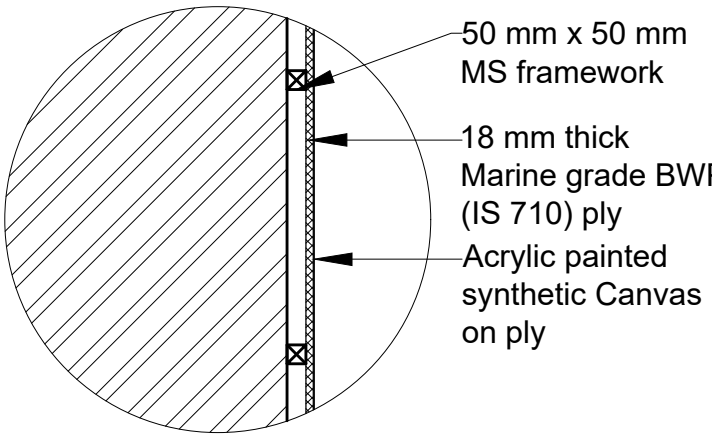

BH.GS 1 GALLERY SIGNAGE  
Scale - 1:50

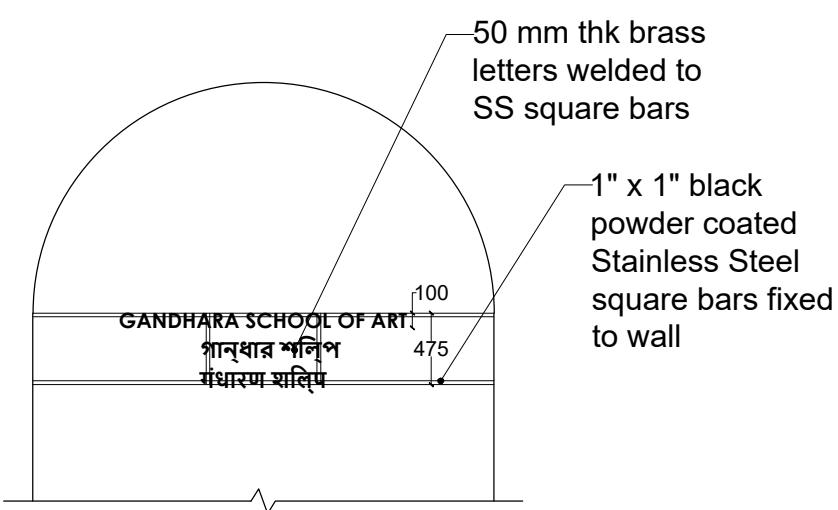

CORNICE MOULDING  
SCALE - 1:5

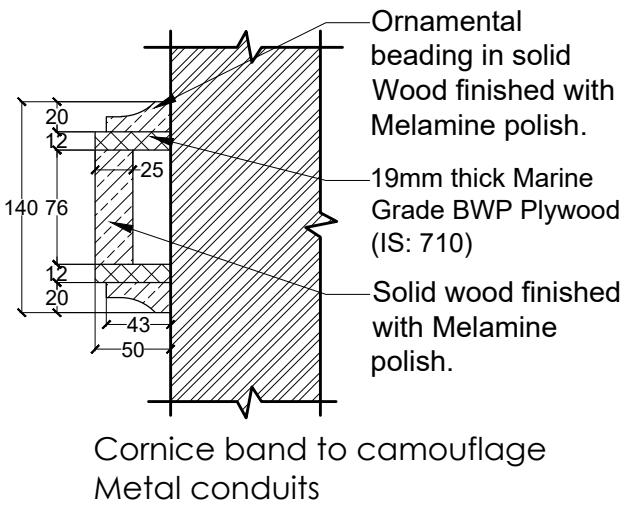

**NOTES:**

All dimensions are in millimeters

**KEY PLAN**

**LEGEND**

DP	Display Panel
DC	Display Case
DS	Display Shelf
PE	Pedestal
WM	Wall Mural
WG	Wall Graphics
CP	Canvas Painting
M	Model
MET	Mock Excavation Trench
CP	Canvas Painting
AV	Audio Visuals
I	Interactive
P	Projection
HP	Holographic Projection
GS	Gallery Signage
DS	Directional Signage
LG	Logo
RT	Reception Table
CC	Crowd Control Barrier

**SCALE:** 1:100

0 1m 2m

**NORTH**

**DRAWING NAME:** LAYOUT

**BHARHUT AND BODH GAYA**

**DRAWN BY:** Sohini Pyne

**CHECKED BY:** Shikha Jain

**DRAWING NUMBER:** IMK/GF/BH/03

**SERIES:** Tender Drawings

**PROJECT:**

PLANNING, CONTENT DEVELOPMENT, DESIGNING, RETROFITTING AND CURATORIAL WORK FOR THE INDIAN MUSEUM, KOLKATA


**CLIENT:**

INDIAN MUSEUM, KOLKATA

**CONSULTANT:**

**DRONAH**  
DEVELOPMENT & RESEARCH ORGANISATION FOR NATURE,ARTS & HERITAGE

A-258, SOUTH CITY-1  
GURGAON-122001

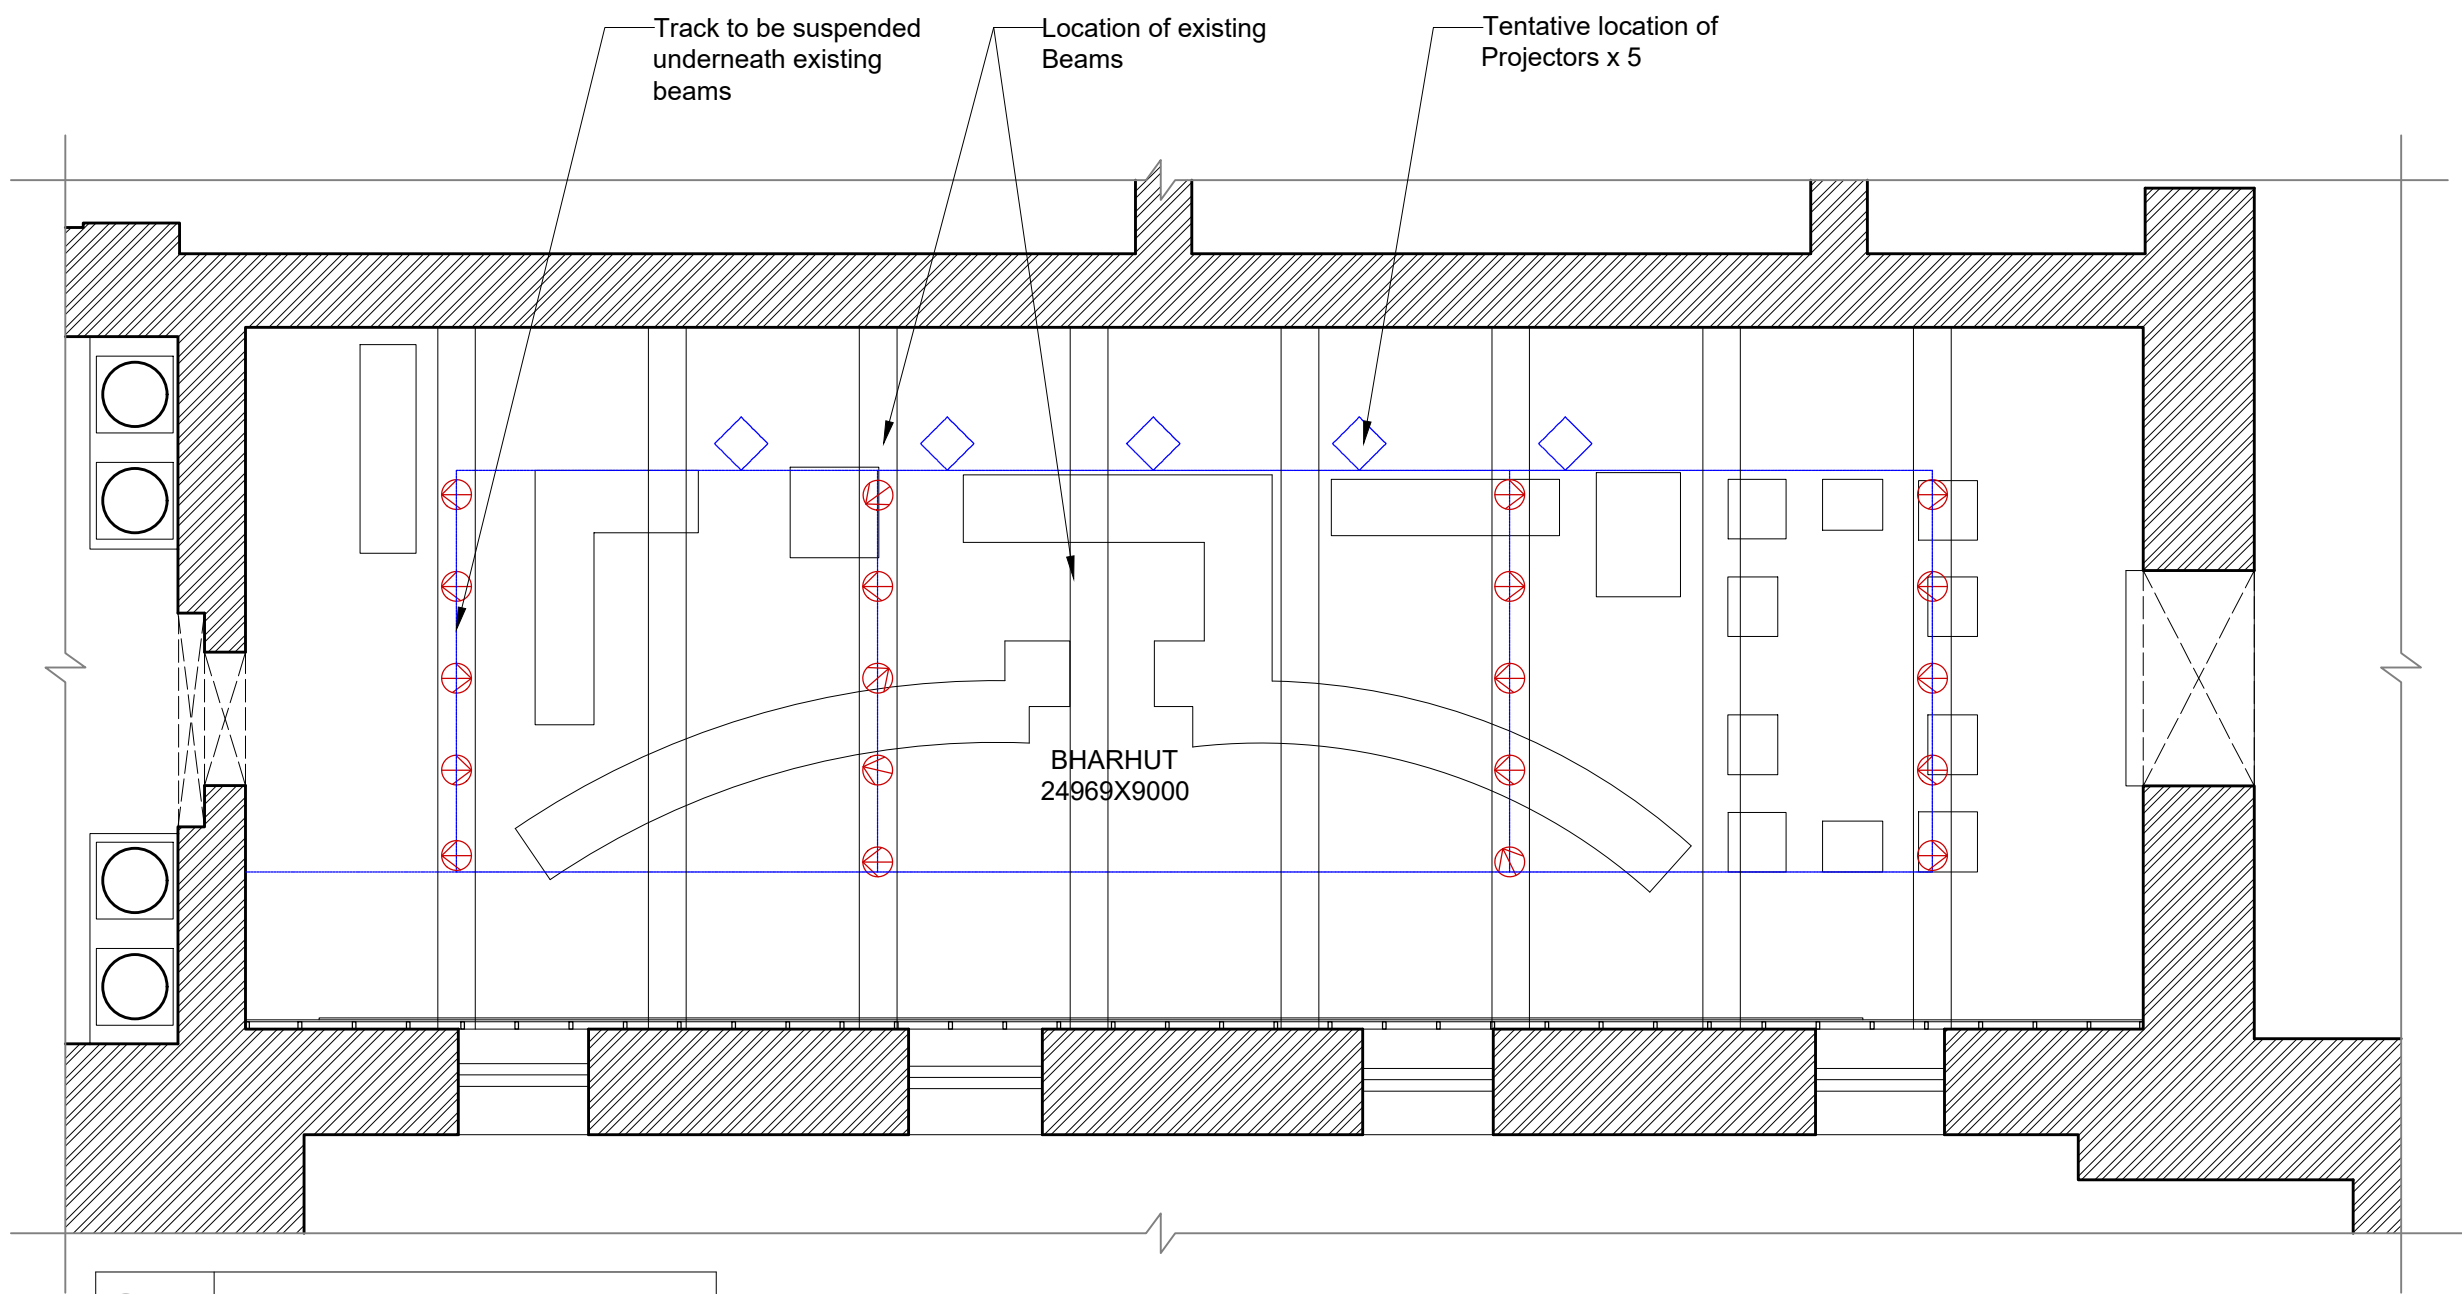


Sym	Type
	Track light on frame
	Ceiling Light Conduit

REFLECTED CEILING PLAN

NOTES:

All dimensions are in millimeters

KEY PLAN

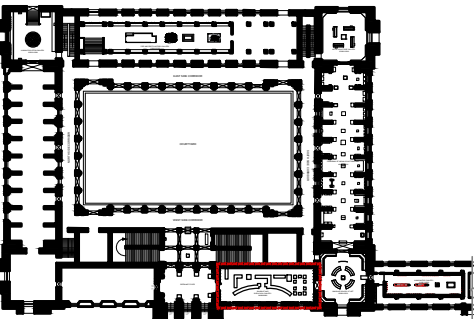

SCALE: 1:100

0 1m 2m



NORTH

DRAWING: LIGHTING LAYOUT

BHARHUT AND BODH GAYA

DRAWN BY: Sohini Pyne

CHECKED BY: Shikha Jain

DRAWING NUMBER: IMK/GF/BH/04

SERIES: Tender Drawings

PROJECT:

PLANNING, CONTENT DEVELOPMENT, DESIGNING, RETROFITTING AND CURATORIAL WORK FOR THE INDIAN MUSEUM, KOLKATA

CLIENT:

INDIAN MUSEUM, KOLKATA


CONSULTANT:

**DRONAH**  
DEVELOPMENT & RESEARCH  
ORGANISATION FOR NATURE,ARTS  
& HERITAGE

A-258, SOUTH CITY-1  
GURGAON-122001




COVERING AND PACKING OF INSITU ARTEFACTS PRIOR TO IMPLEMENTATION OF WORKS

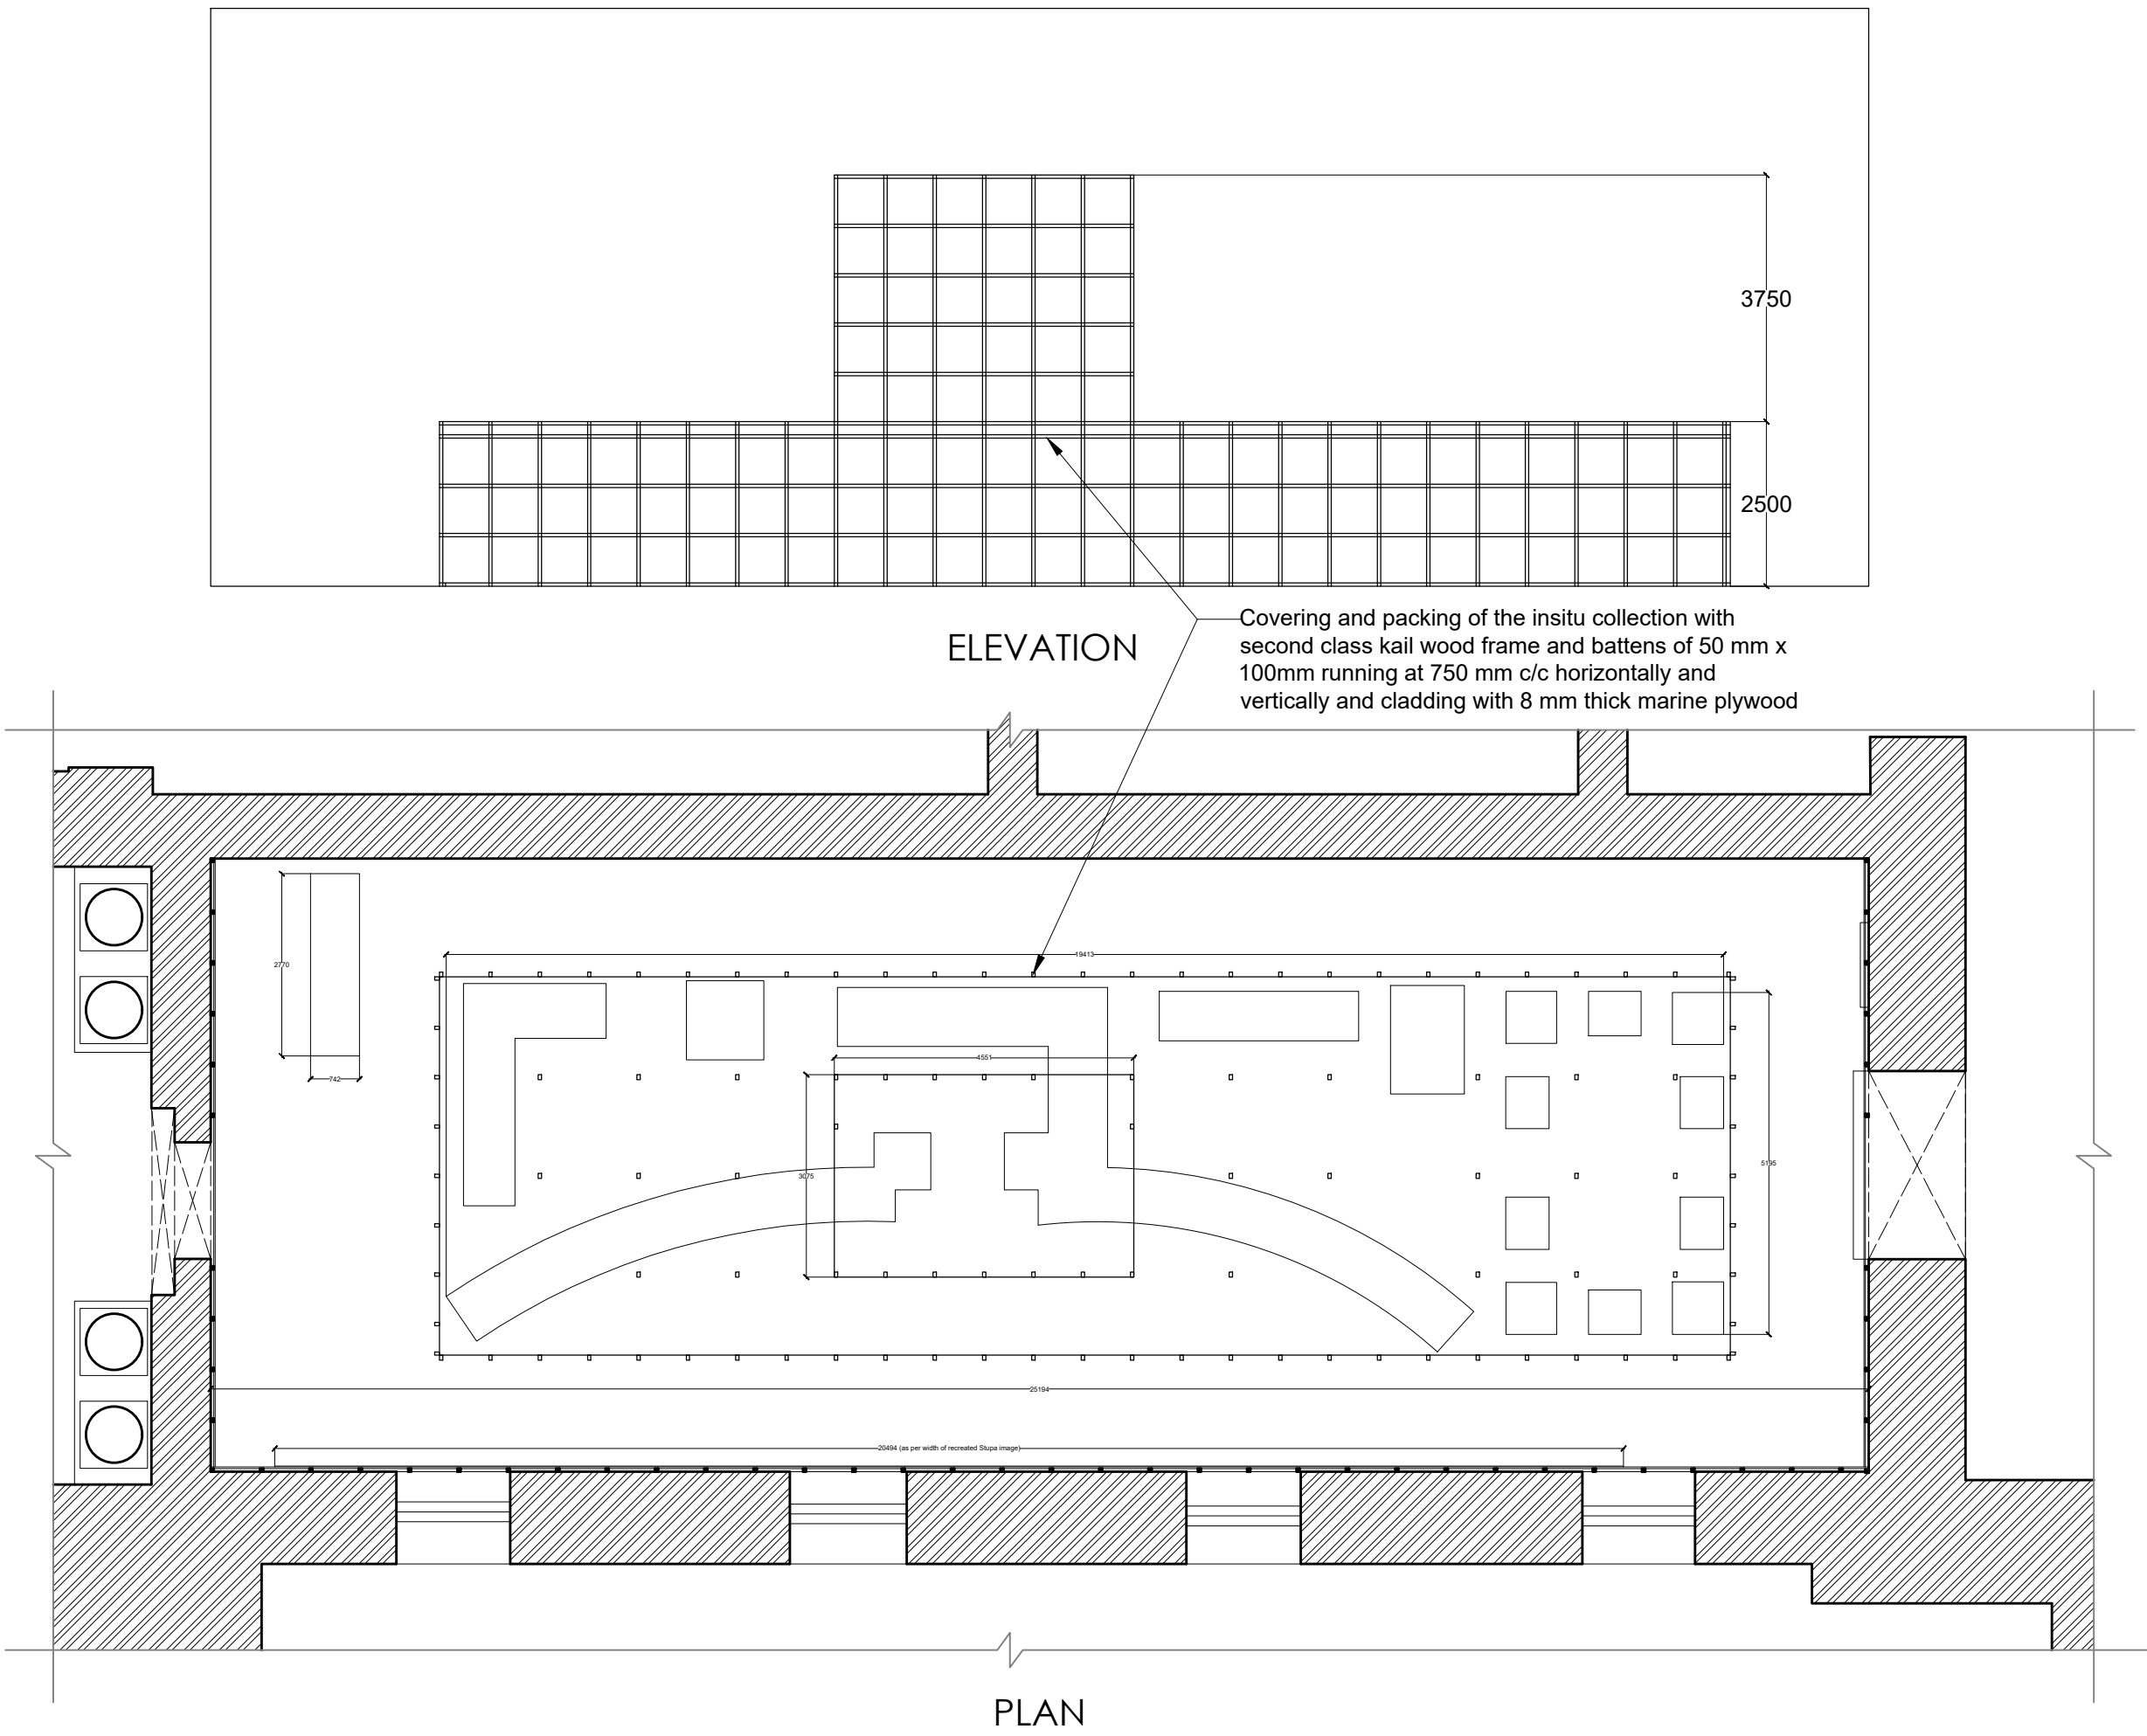

NOTES:

All dimensions are in millimeters

KEY PLAN

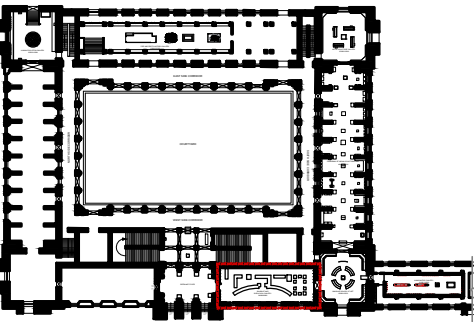

SCALE: 1:100

0 1m 2m



DRAWING: LIGHTING LAYOUT

BHARHUT AND BODH GAYA

DRAWN BY: Sohini Pyne

CHECKED BY: Shikha Jain

DRAWING NUMBER: IMK/GF/BH/05

SERIES: Tender Drawings

PROJECT:

PLANNING, CONTENT DEVELOPMENT, DESIGNING, RETROFITTING AND CURATORIAL WORK FOR THE INDIAN MUSEUM, KOLKATA

CLIENT:

INDIAN MUSEUM, KOLKATA

CONSULTANT:


**DRONAH**  
DEVELOPMENT & RESEARCH  
ORGANISATION FOR NATURE,ARTS  
& HERITAGE

A-258, SOUTH CITY-1  
GURGAON-122001









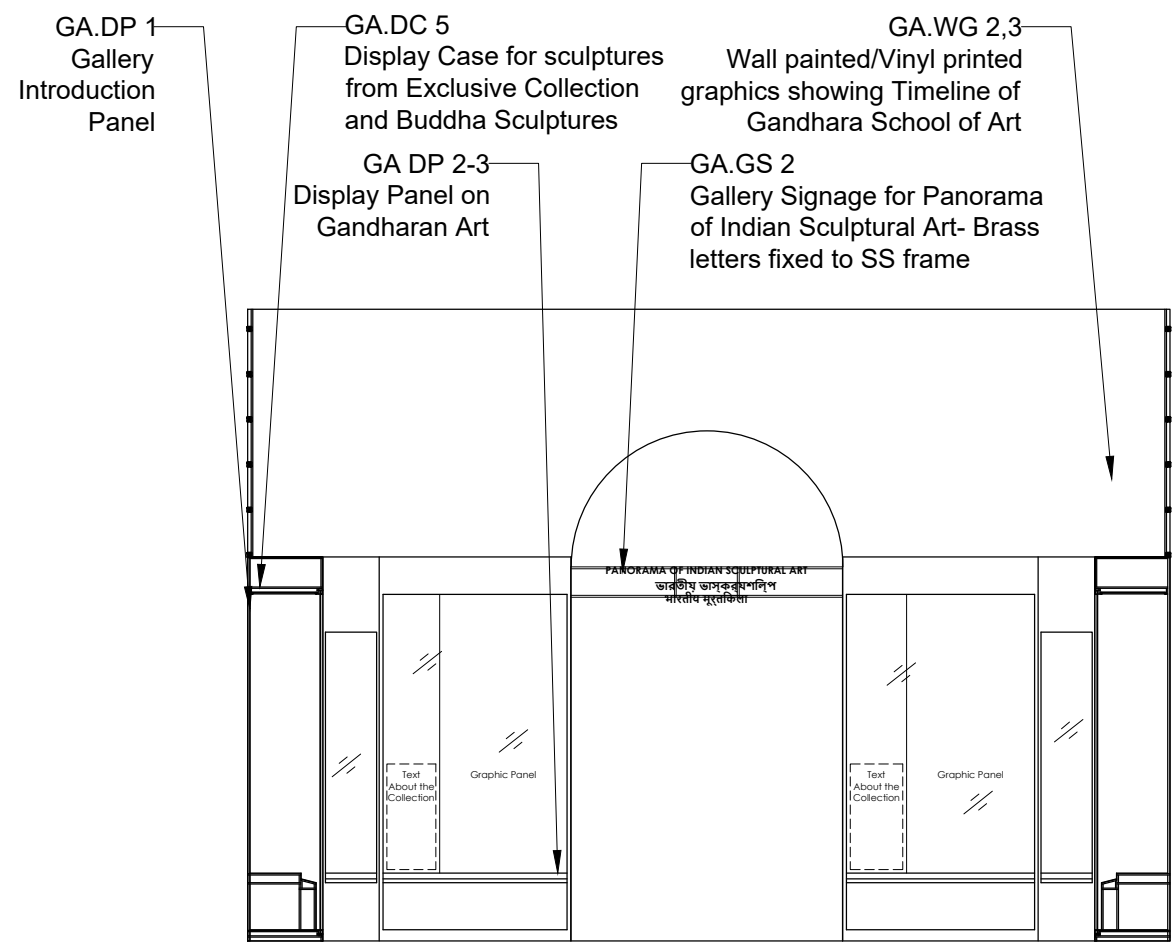


ELEVATION A

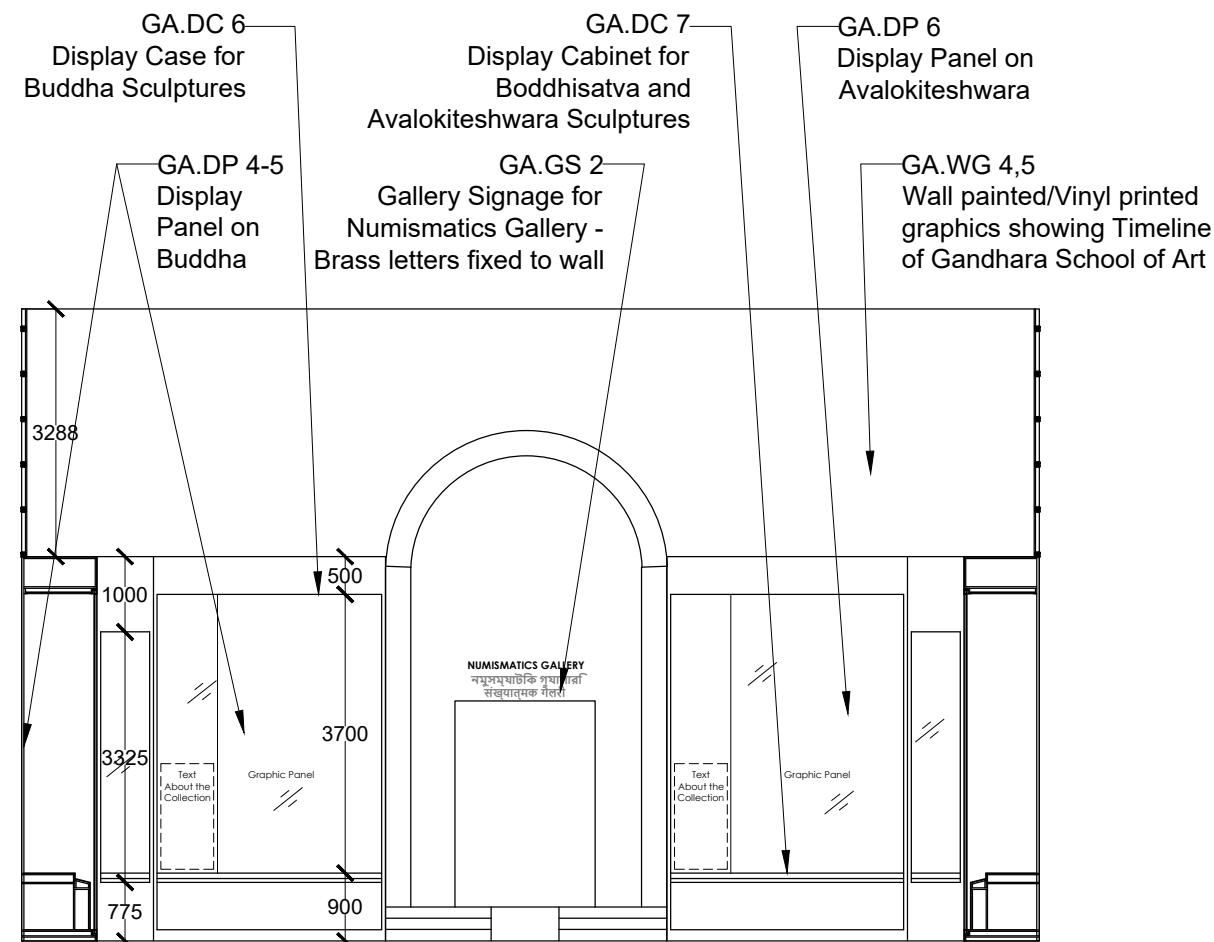

ELEVATION B

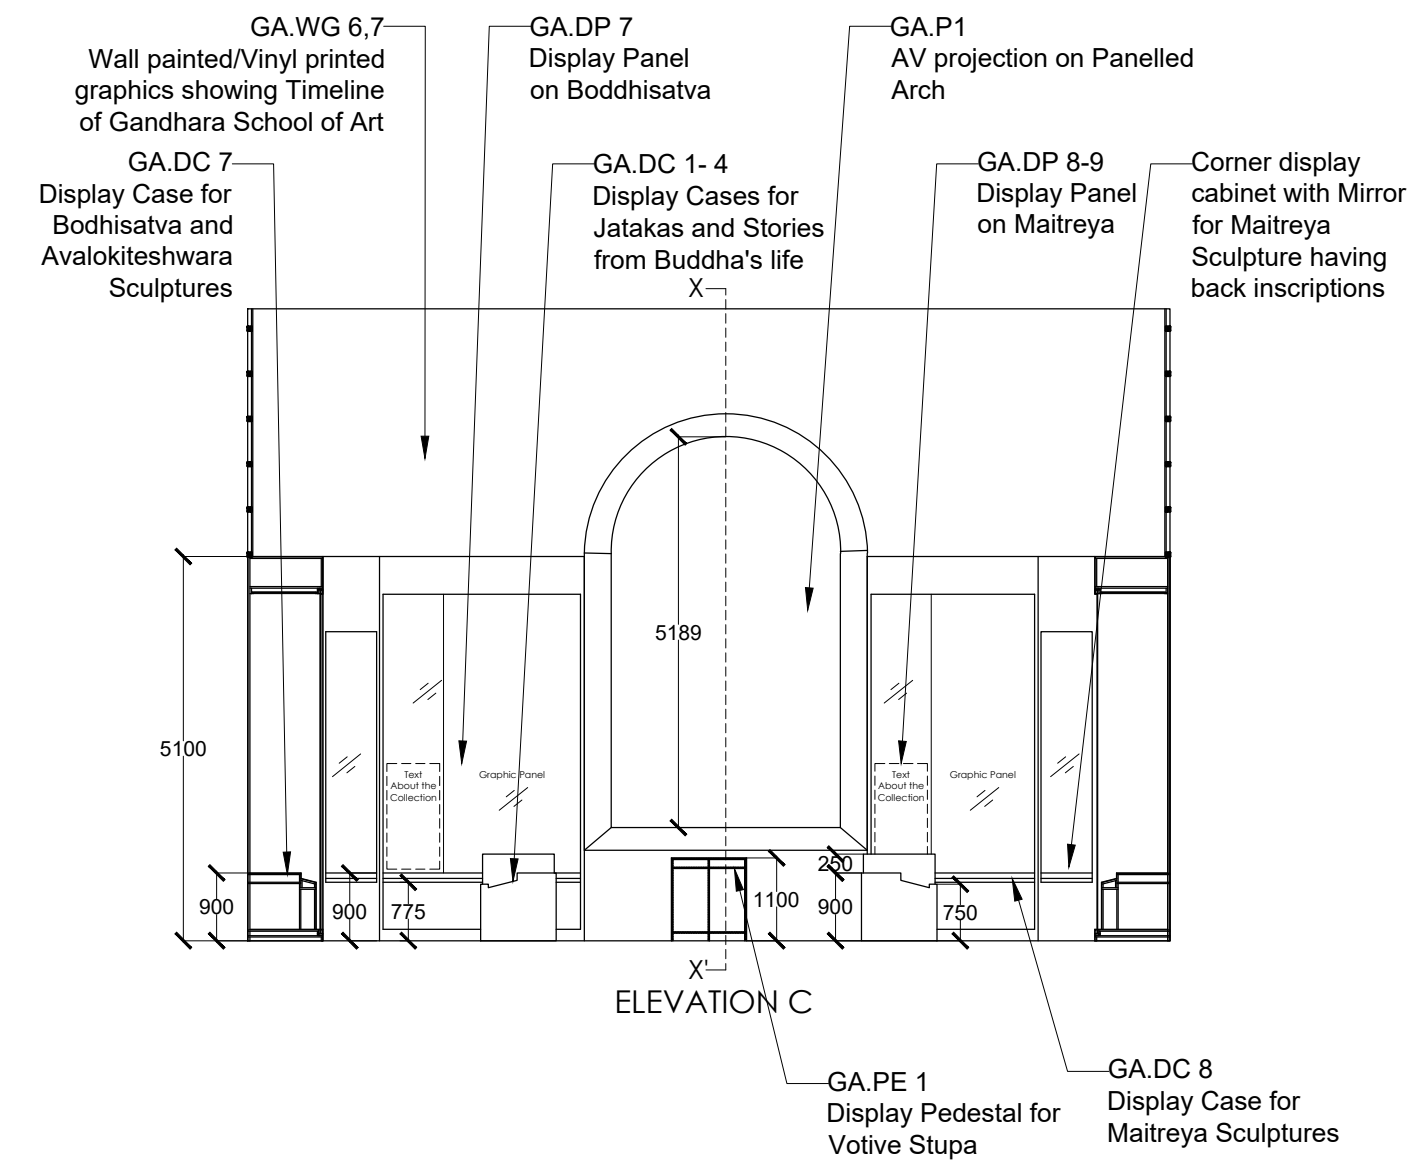

ELEVATION C

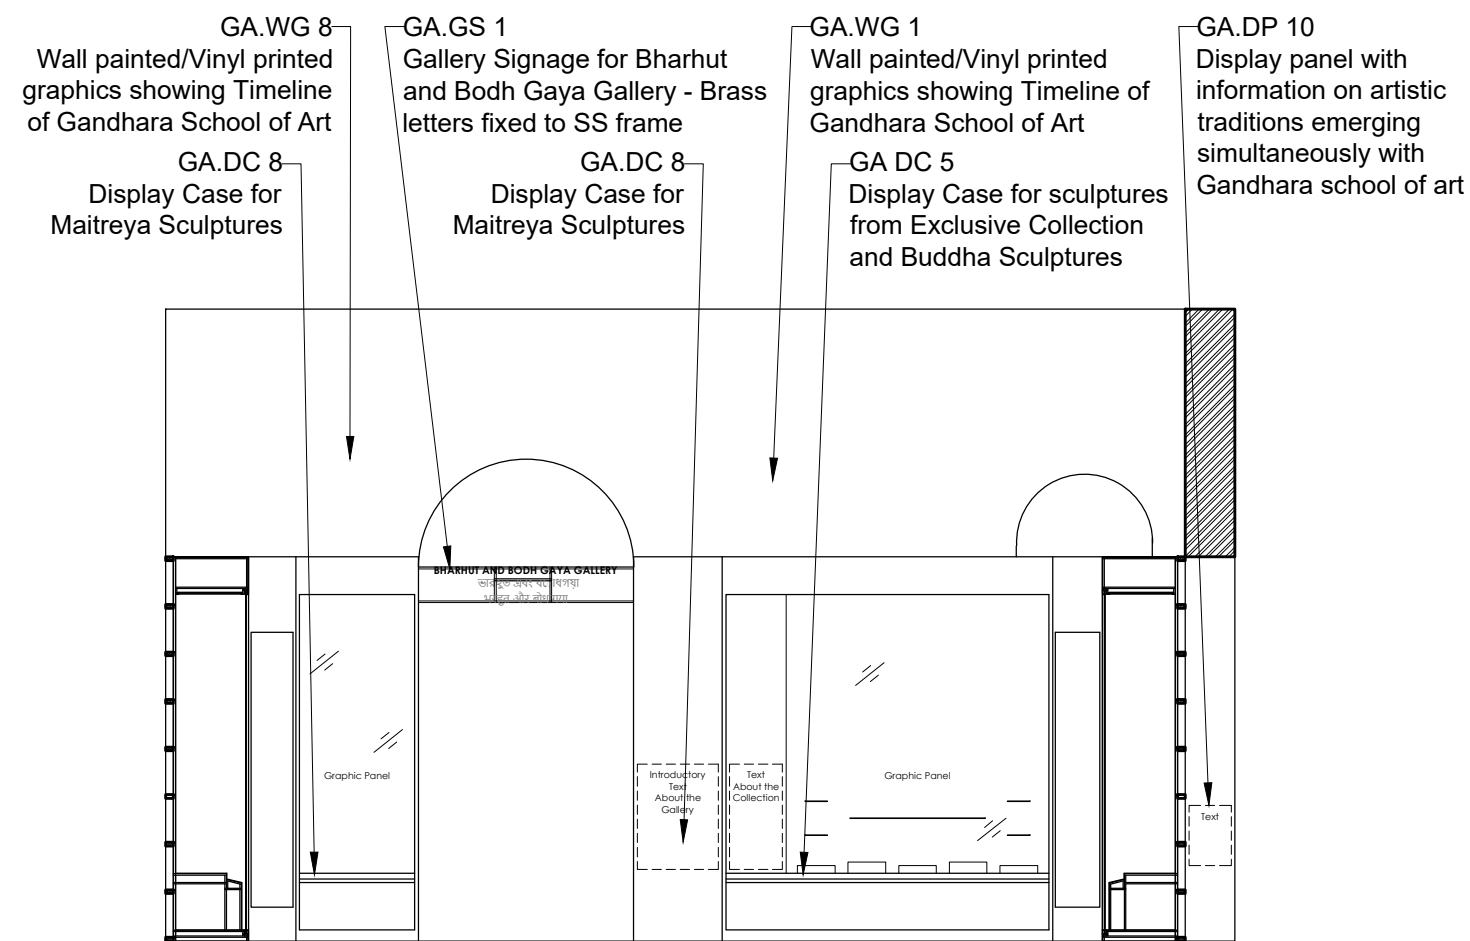


ELEVATION D

## NOTES:

All dimensions are in millimeters

## KEY PLAN

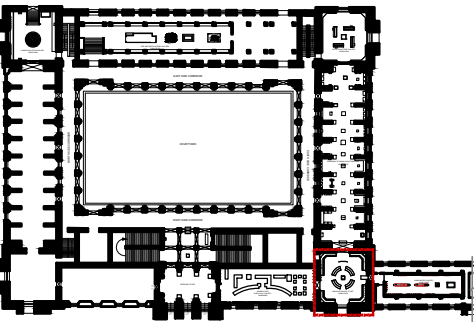

## LEGEND

DP	Display Panel
DC	Display Case
DS	Display Shelf
PE	Pedestal
WM	Wall Mural
WG	Wall Graphics
CP	Canvas Painting
M	Model
MET	Mock Excavation Trench
CP	Canvas Painting
AV	Audio Visuals
I	Interactive
P	Projection
HP	Holographic Projection
GS	Gallery Signage
DS	Directional Signage
LG	Logo
RT	Reception Table
CC	Crowd Control Barrier

SCALE: 1:100

0 1m 2m



DRAWING NAME: LAYOUT

GANDHARA SCHOOL OF ART

DRAWN BY: Sohini Pyne

CHECKED BY: Shikha Jain

DRAWING NUMBER: IMK/GF/GA/02

SERIES: Tender Drawings

## PROJECT:

PLANNING, CONTENT DEVELOPMENT, DESIGNING, RETROFITTING AND CURATORIAL WORK FOR THE INDIAN MUSEUM, KOLKATA

## CLIENT:


INDIAN MUSEUM, KOLKATA

## CONSULTANT:

**DRONAH**  
DEVELOPMENT & RESEARCH  
ORGANISATION FOR NATURE,ARTS  
& HERITAGE

A-258, SOUTH CITY-1  
GURGAON-122001

DETAIL GA.DC 5-8

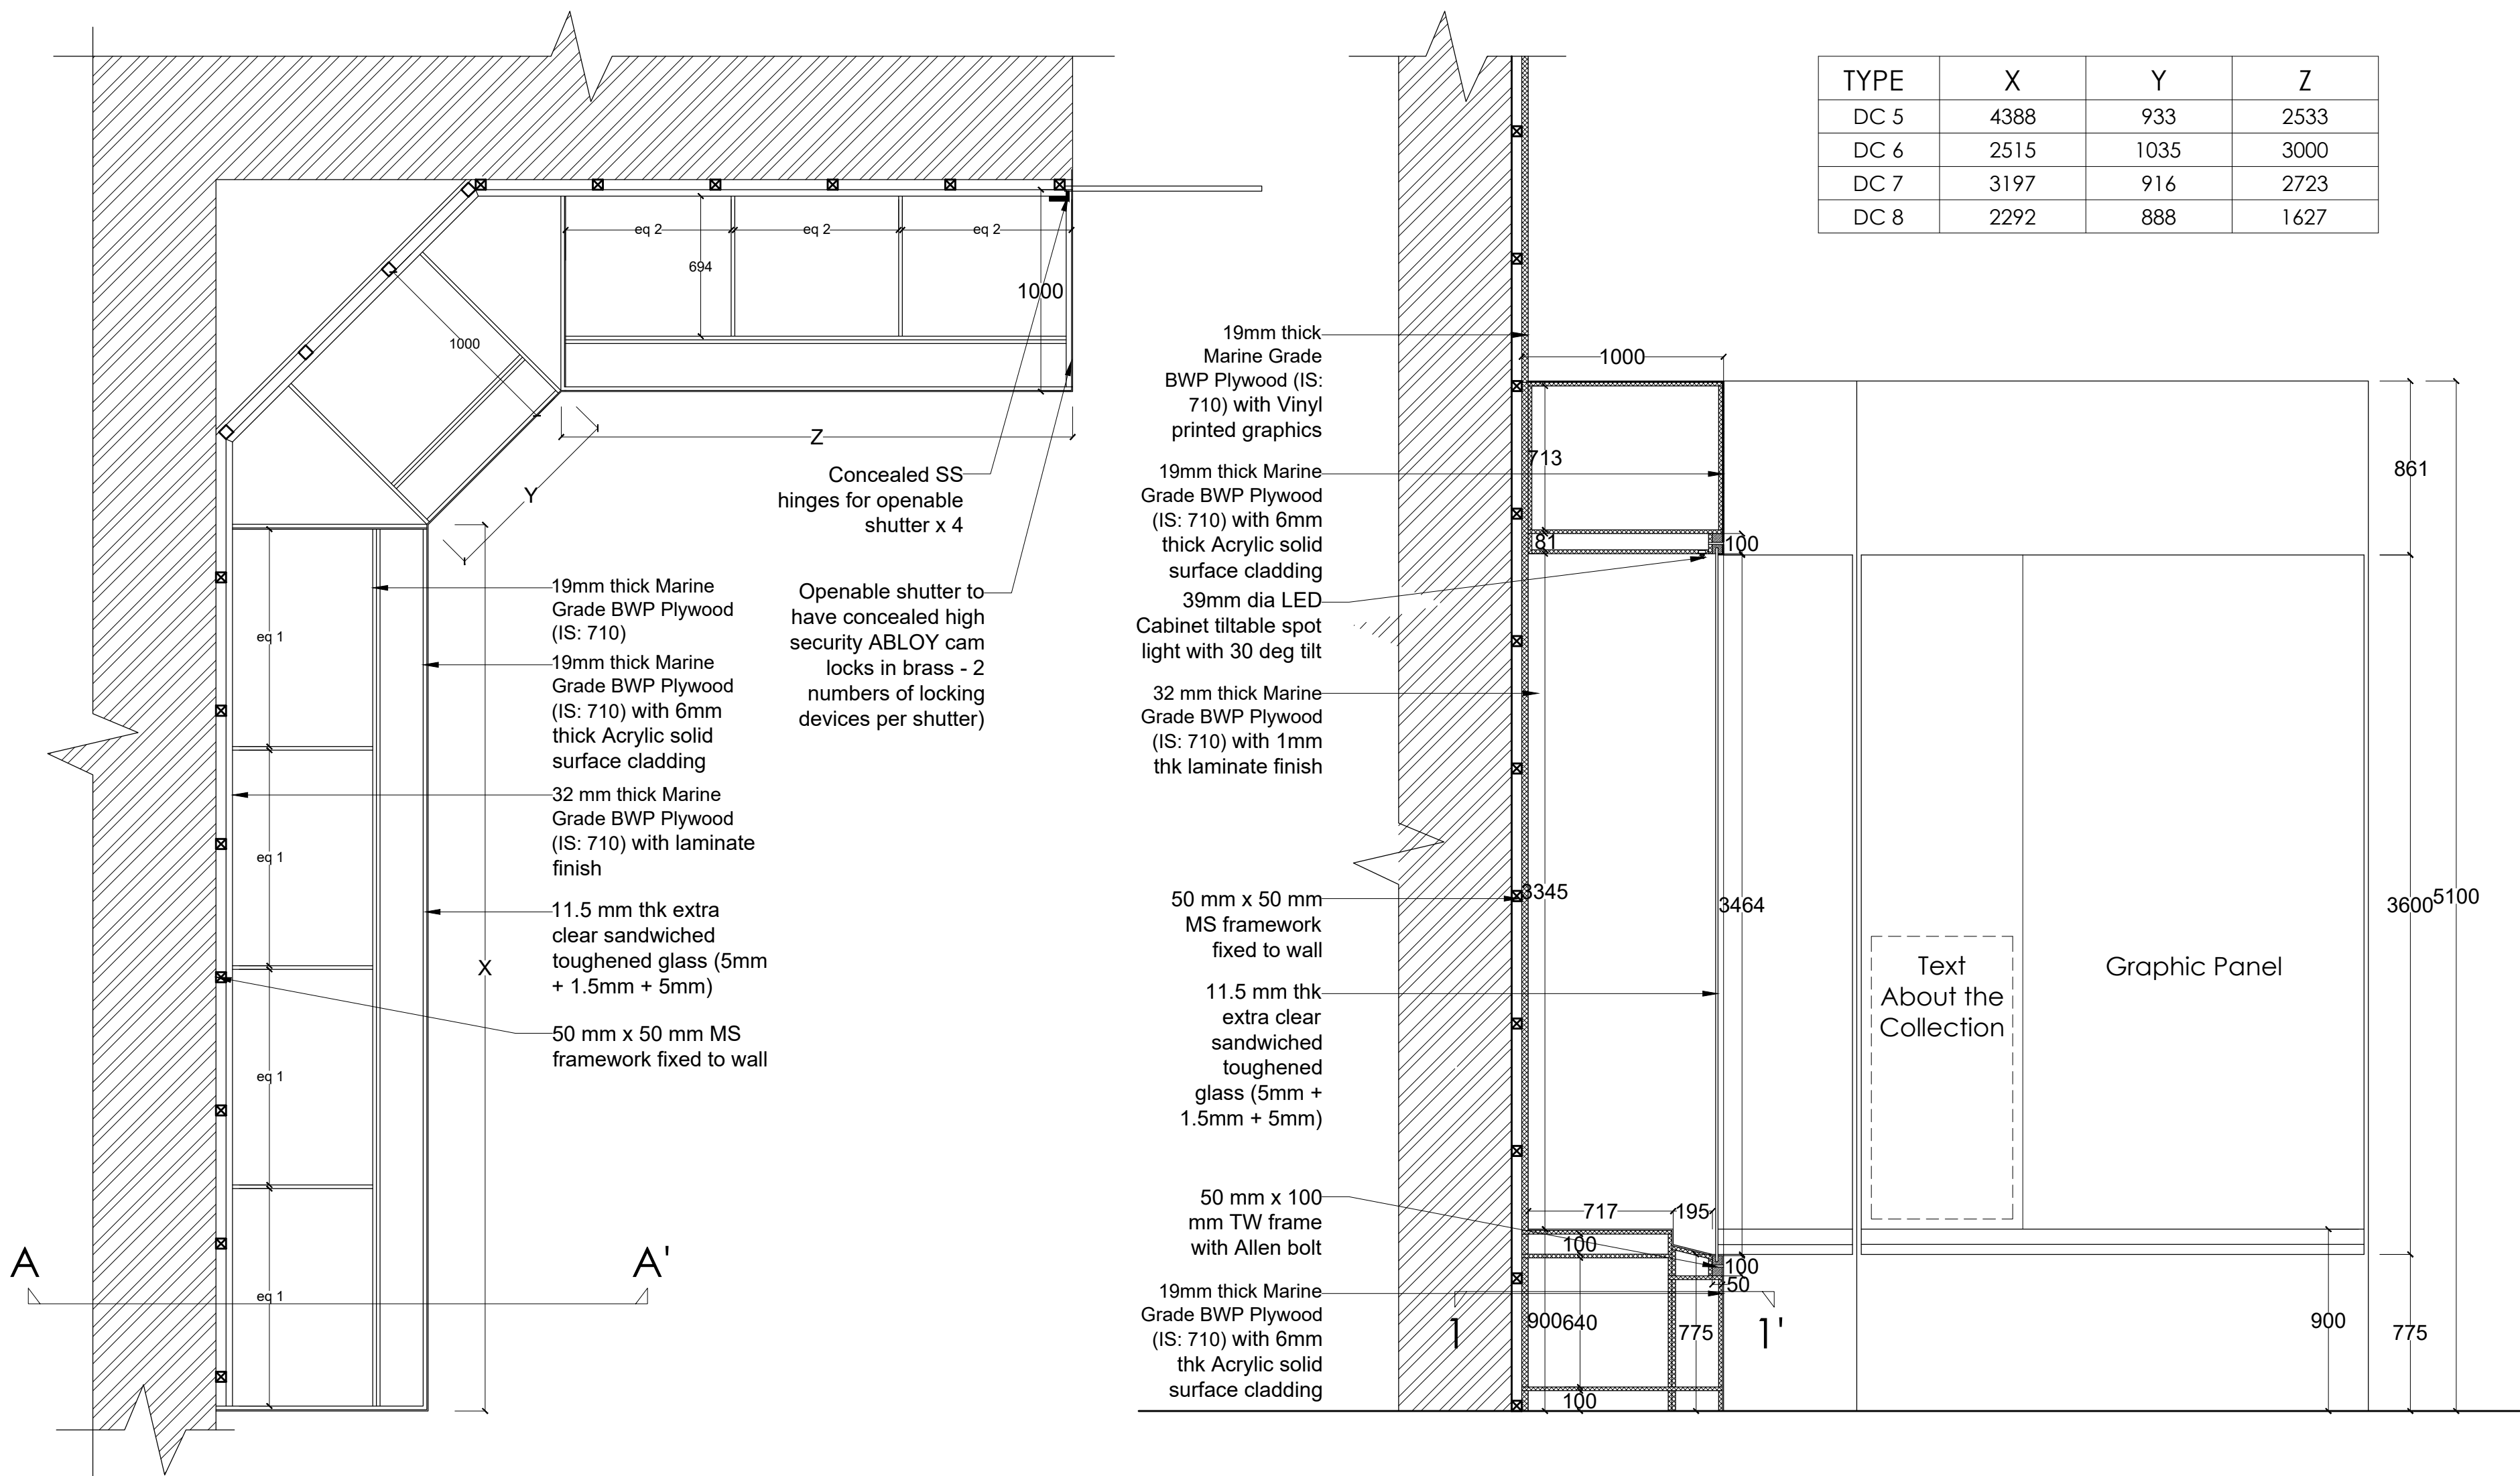


Note:  
Refer **Table 1** for X and Y

NOTES:

All dimensions are in millimeters

KEY PLAN

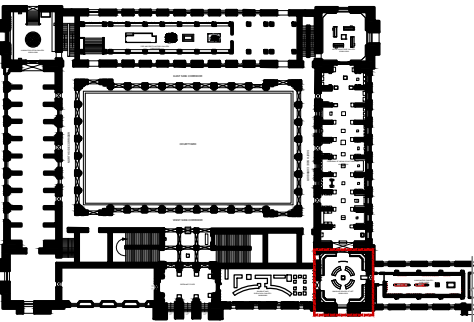

LEGEND

DP	Display Panel
DC	Display Case
DS	Display Shelf
PE	Pedestal
WM	Wall Mural
WG	Wall Graphics
CP	Canvas Painting
M	Model
MET	Mock Excavation Trench
CP	Canvas Painting
AV	Audio Visuals
I	Interactive
P	Projection
HP	Holographic Projection
GS	Gallery Signage
DS	Directional Signage
LG	Logo
RT	Reception Table
CC	Crowd Control Barrier

SCALE: 1:25

0 1m 2m



DRAWING NAME: LAYOUT

GANDHARA SCHOOL OF ART

DRAWN BY: Sohini Pyne

CHECKED BY: Shikha Jain

DRAWING NUMBER: IMK/GF/GA/03

SERIES: Tender Drawings

PROJECT:

PLANNING, CONTENT DEVELOPMENT, DESIGNING, RETROFITTING AND CURATORIAL WORK FOR THE INDIAN MUSEUM, KOLKATA

CLIENT:



INDIAN MUSEUM, KOLKATA

CONSULTANT:

**DRONAH**  
DEVELOPMENT & RESEARCH  
ORGANISATION FOR NATURE,ARTS  
& HERITAGE



A-258, SOUTH CITY-1  
GURGAON-122001

DETAIL DC 1- 4

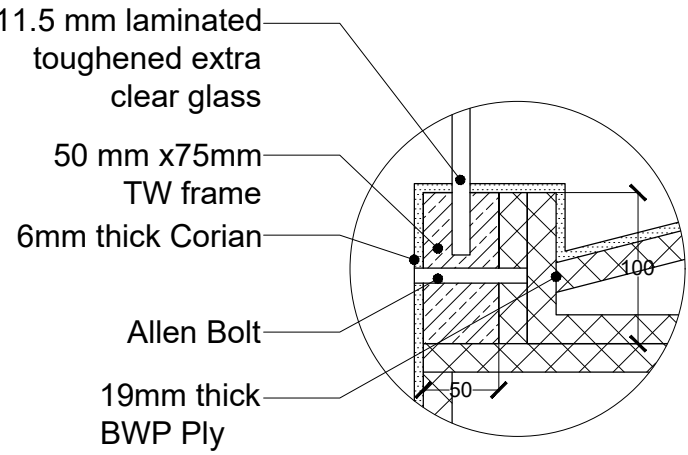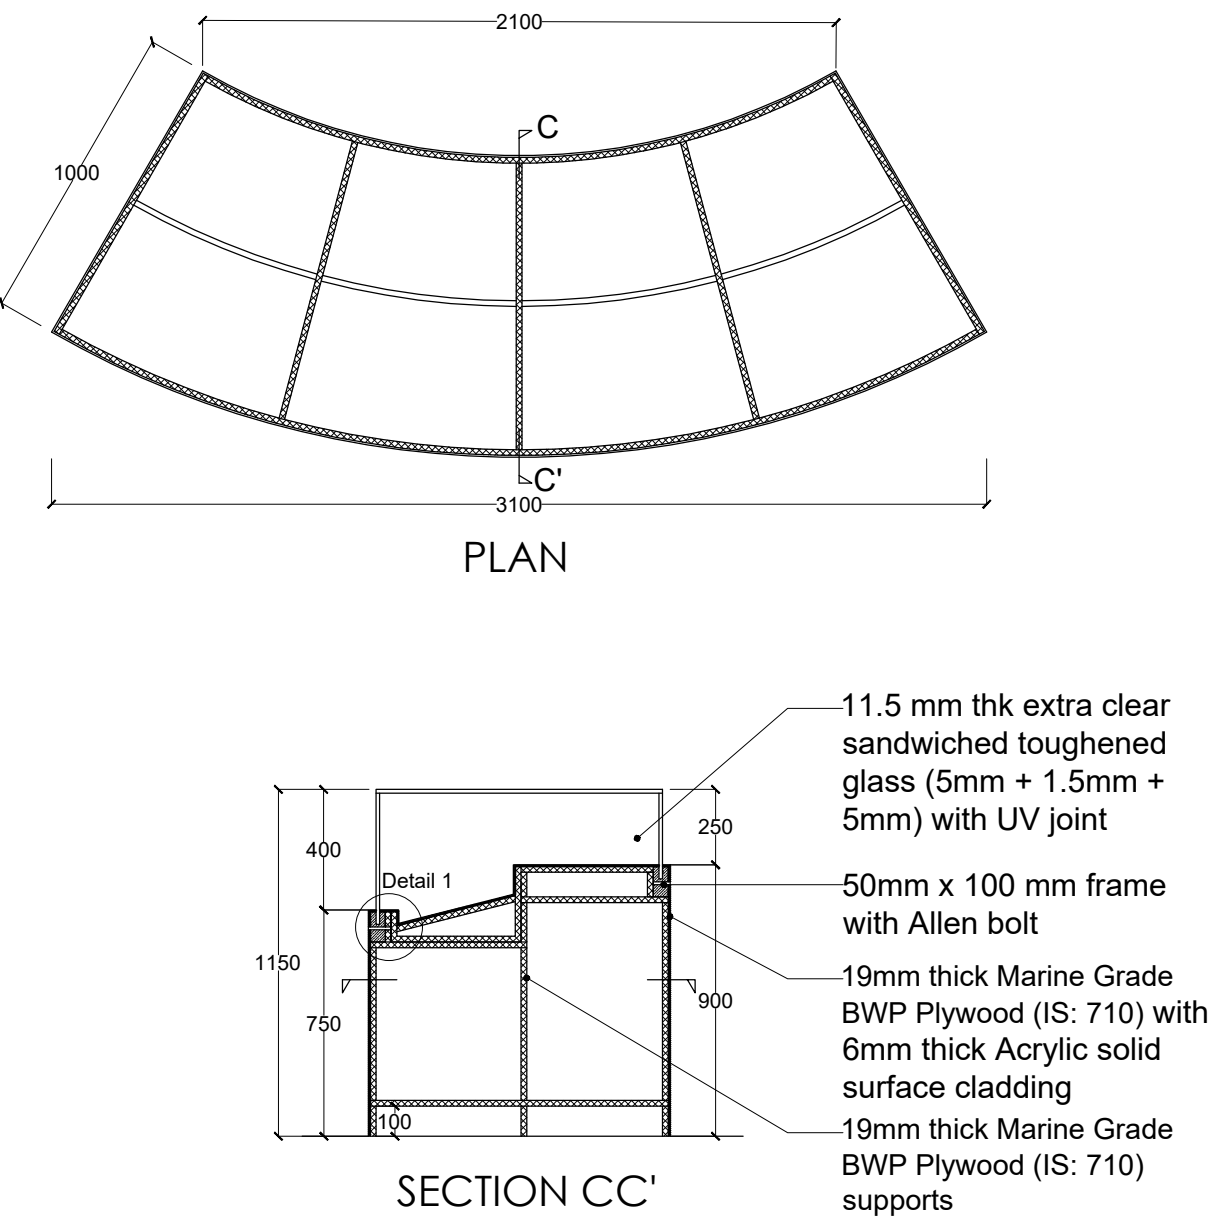

DETAIL 1  
SCALE 1:5


DETAIL DC 3

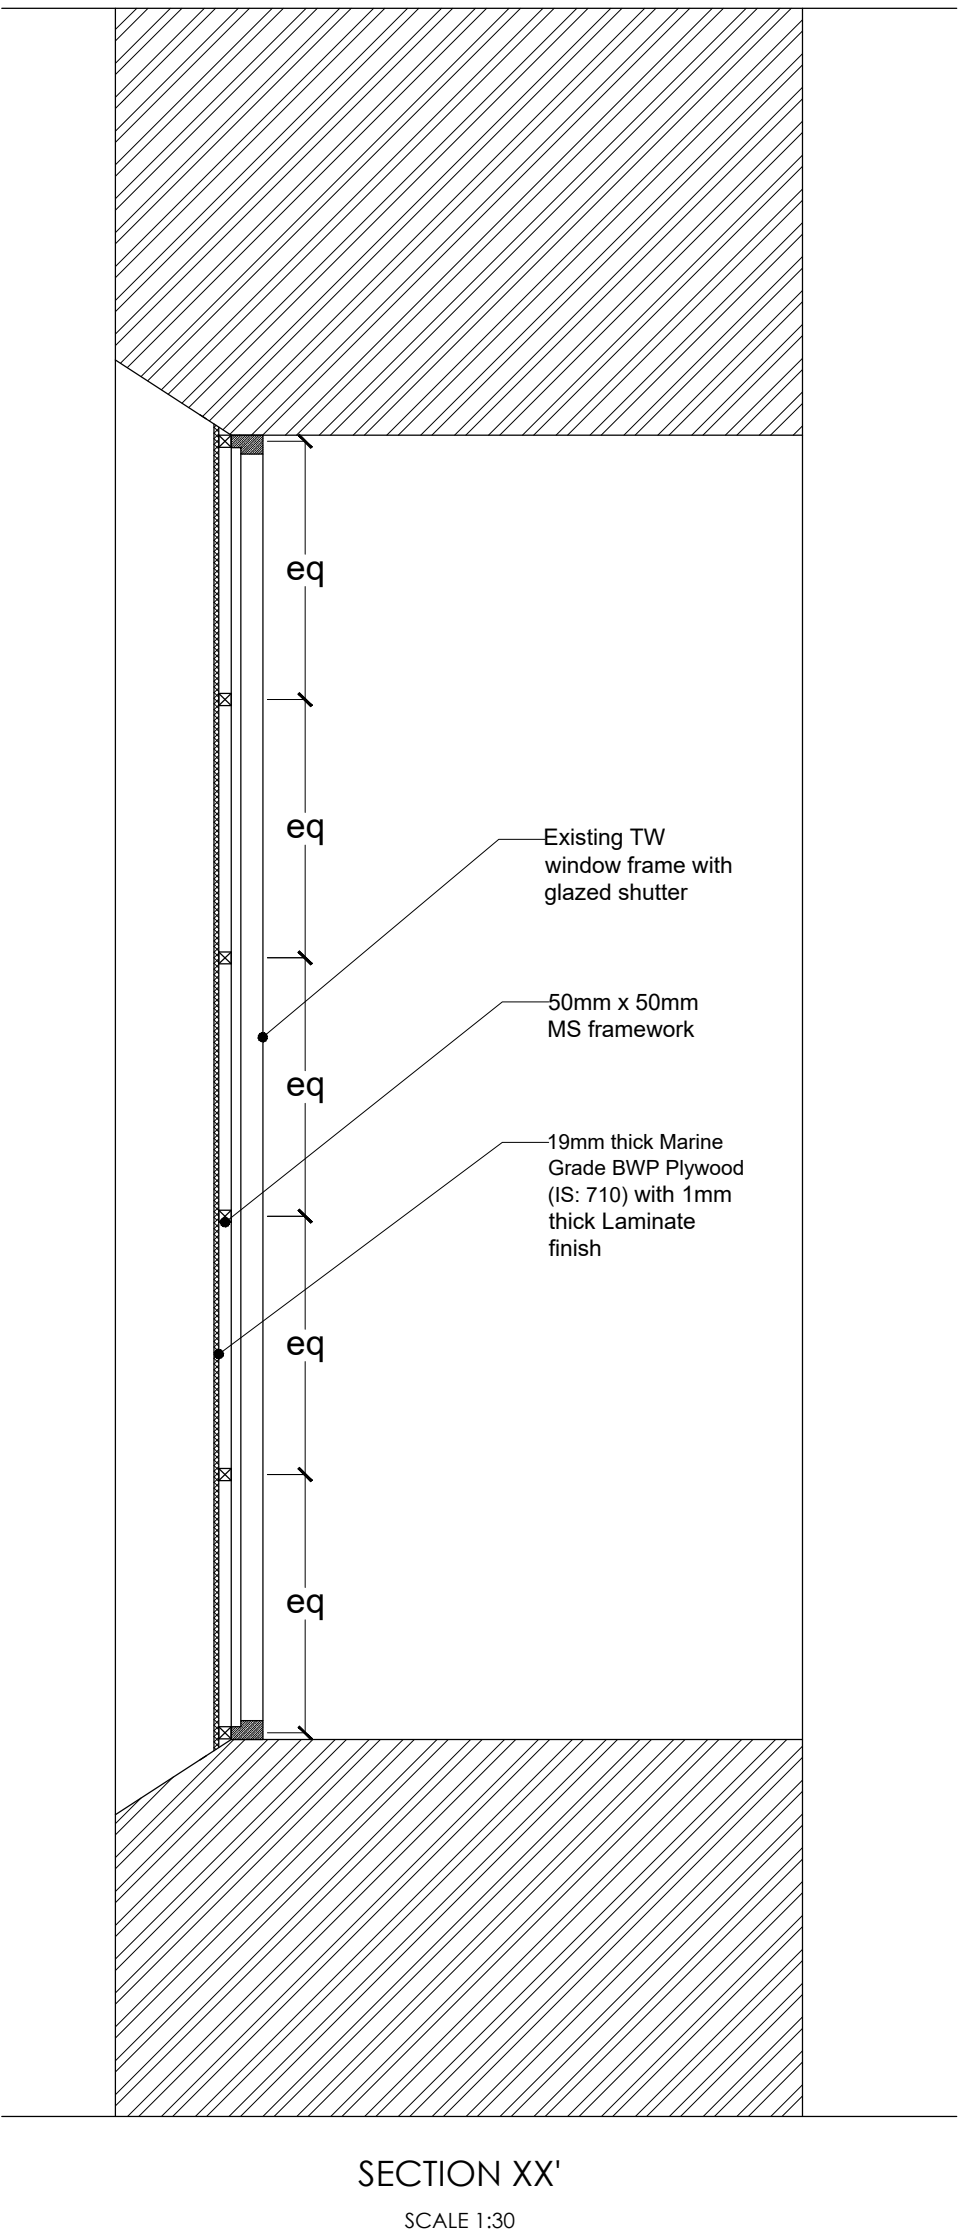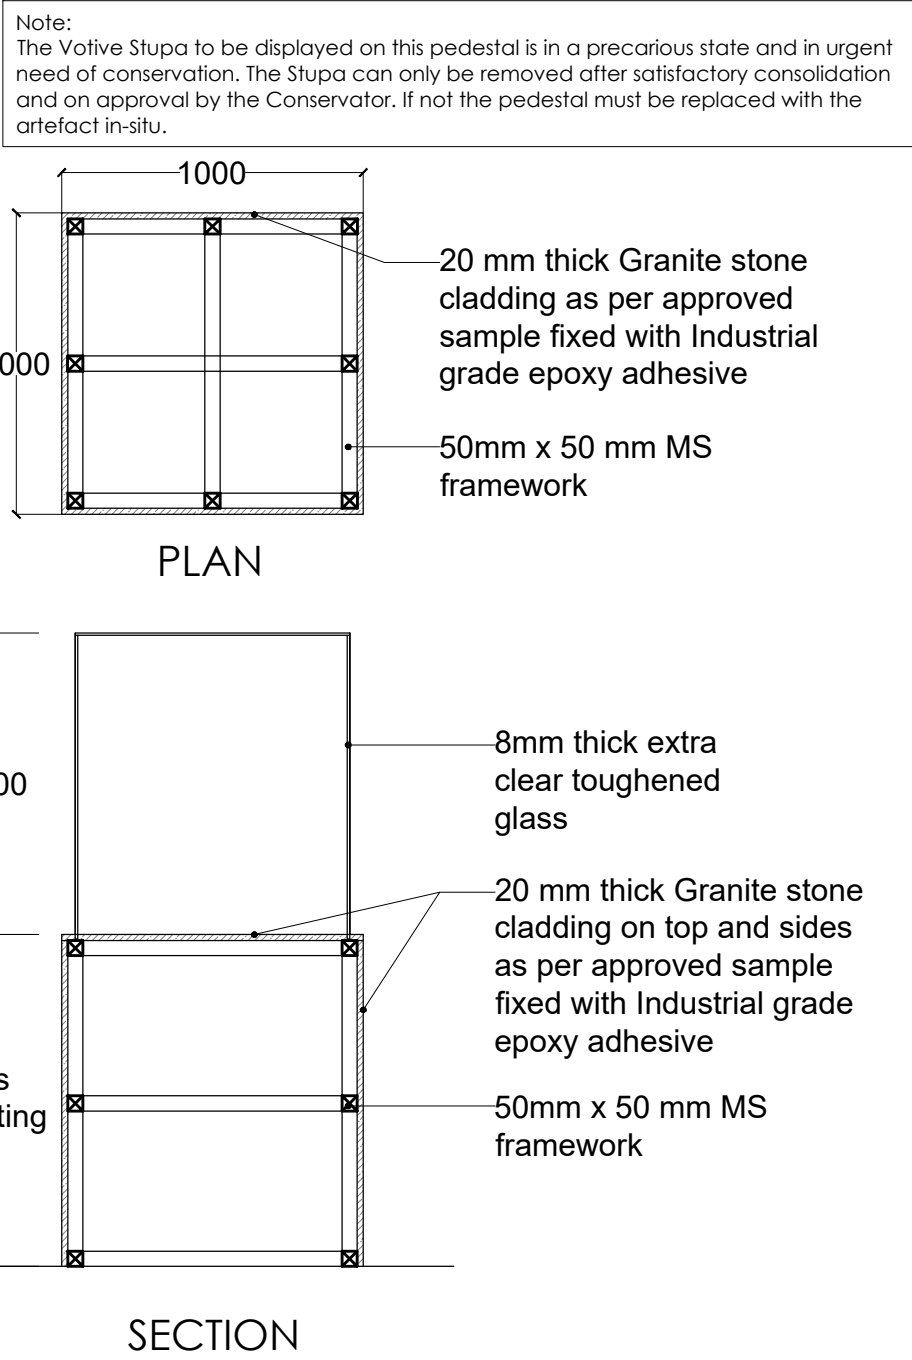

NOTES:

All dimensions are in millimeters

KEY PLAN

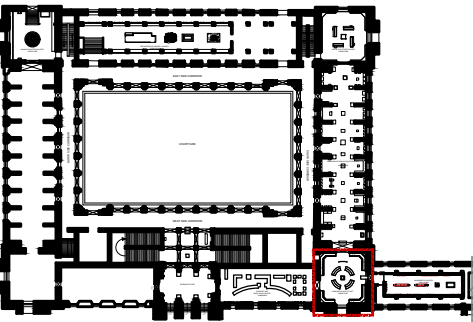

LEGEND

DP	Display Panel
DC	Display Case
DS	Display Shelf
PE	Pedestal
WM	Wall Mural
WG	Wall Graphics
CP	Canvas Painting
M	Model
MET	Mock Excavation Trench
CP	Canvas Painting
AV	Audio Visuals
I	Interactive
P	Projection
HP	Holographic Projection
GS	Gallery Signage
DS	Directional Signage
LG	Logo
RT	Reception Table
CC	Crowd Control Barrier

SCALE: 1:25

0 1m 2m



NORTH

DRAWING NAME: LAYOUT

GANDHARA SCHOOL OF ART

DRAWN BY: Sohini Pyne

CHECKED BY: Shikha Jain

DRAWING NUMBER: IMK/GF/GA/04

SERIES: Tender Drawings

PROJECT:

PLANNING, CONTENT DEVELOPMENT, DESIGNING, RETROFITTING AND CURATORIAL WORK FOR THE INDIAN MUSEUM, KOLKATA

CLIENT:


INDIAN MUSEUM, KOLKATA

CONSULTANT:

**DRONAH**  
DEVELOPMENT & RESEARCH ORGANISATION FOR NATURE,ARTS & HERITAGE

A-258, SOUTH CITY-1  
GURGAON-122001



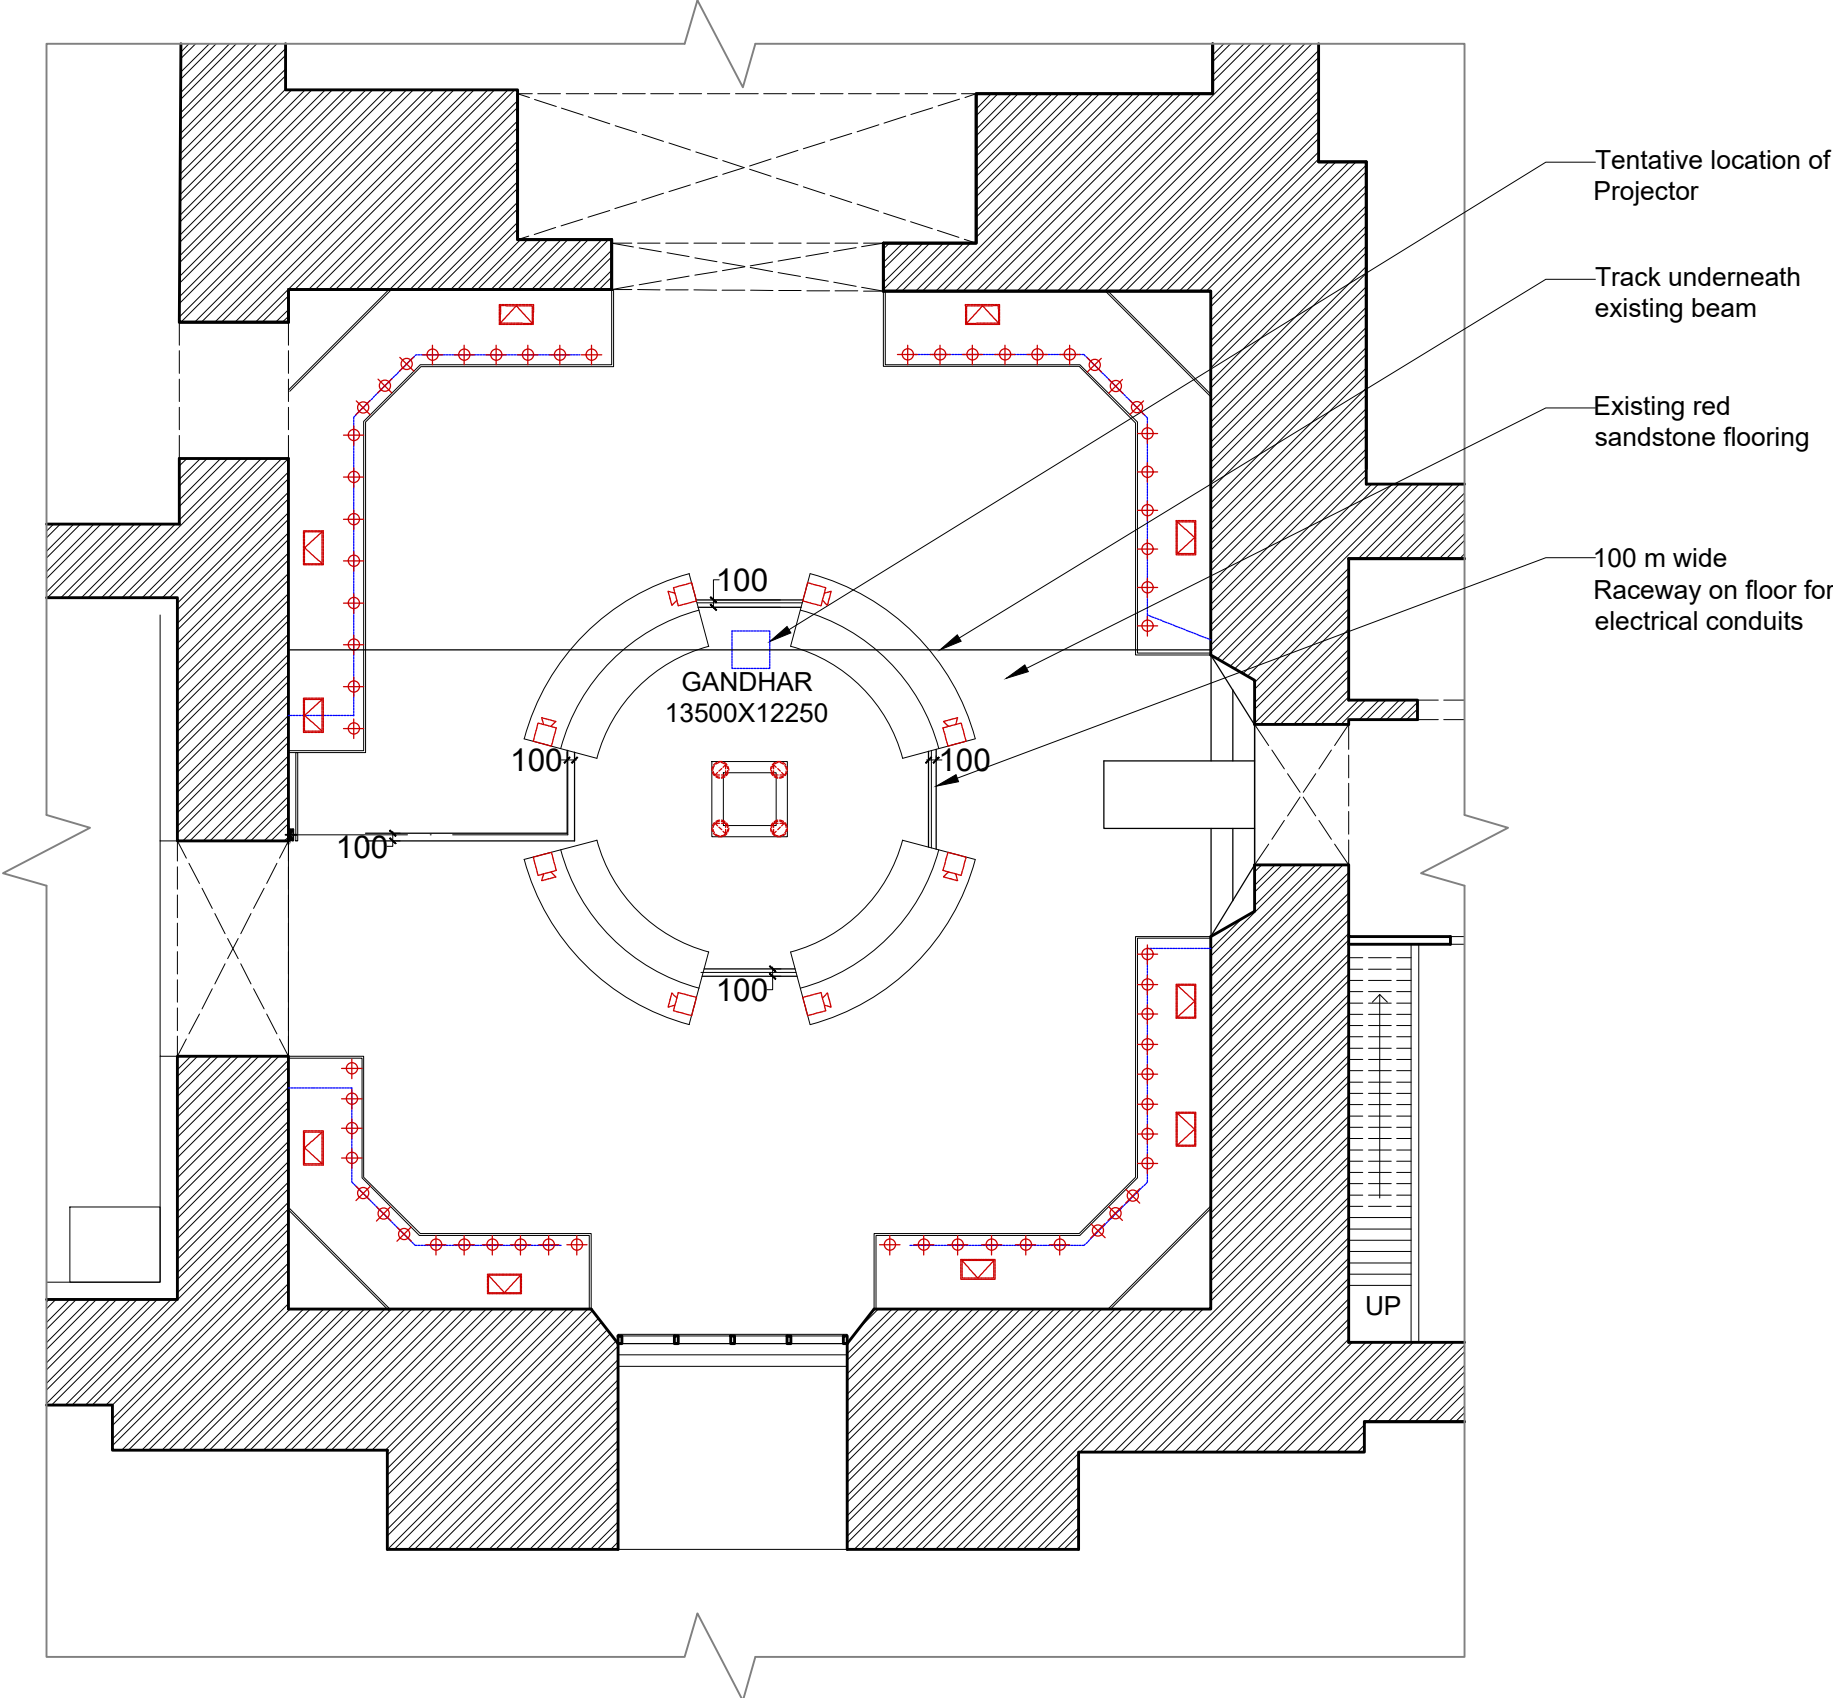


Sym	Type
	Mini cabinet tiltable spot light
	LED Pole/stand mounted cabinet lights
	LED Wall washer uplight 980 mm length (for wall graphics)
	Ceiling Light Conduit
	Floor Light conduit

NOTES:

All dimensions are in millimeters

KEY PLAN

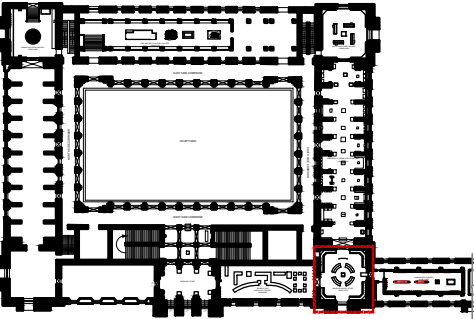

SCALE: 1:100	NORTH
0 1m 2m	

DRAWING: LIGHTING LAYOUT

GANDHARA SCHOOL OF ART

DRAWN BY: Sohini Pyne

CHECKED BY: Shikha Jain

DRAWING NUMBER: IMK/GF/GA/05

SERIES: Tender Drawings

PROJECT:

PLANNING, CONTENT DEVELOPMENT, DESIGNING, RETROFITTING AND CURATORIAL WORK FOR THE INDIAN MUSEUM, KOLKATA

CLIENT:

INDIAN MUSEUM, KOLKATA

CONSULTANT:

**DRONAH**  
DEVELOPMENT & RESEARCH  
ORGANISATION FOR NATURE,ARTS  
& HERITAGE


A-258, SOUTH CITY-1  
GURGAON-122001



NOTES:

All dimensions are in millimeters

KEY PLAN

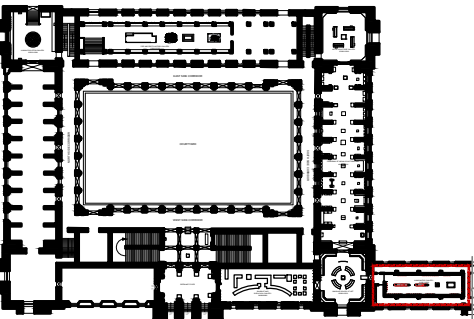

LEGEND

DP	Display Panel
DC	Display Case
DS	Display Shelf
PE	Pedestal
WM	Wall Mural
WG	Wall Graphics
CP	Canvas Painting
M	Model
MET	Mock Excavation Trench
CP	Canvas Painting
AV	Audio Visuals
I	Interactive
P	Projection
HP	Holographic Projection
GS	Gallery Signage
DS	Directional Signage
LG	Logo
RT	Reception Table
CC	Crowd Control Barrier

SCALE: 1:100

0 1m 2m



DRAWING NAME: LAYOUT

NUMISMATICS

DRAWN BY: Sohini Pyne

CHECKED BY: Shikha Jain

DRAWING NUMBER: IMK/GF/NU/01

SERIES: Tender Drawings

PROJECT:

PLANNING, CONTENT DEVELOPMENT, DESIGNING, RETROFITTING AND CURATORIAL WORK FOR THE INDIAN MUSEUM, KOLKATA


CLIENT:


INDIAN MUSEUM, KOLKATA

CONSULTANT:


**DRONAH**  
DEVELOPMENT & RESEARCH ORGANISATION FOR NATURE,ARTS & HERITAGE

A-258, SOUTH CITY-1  
GURGAON-122001

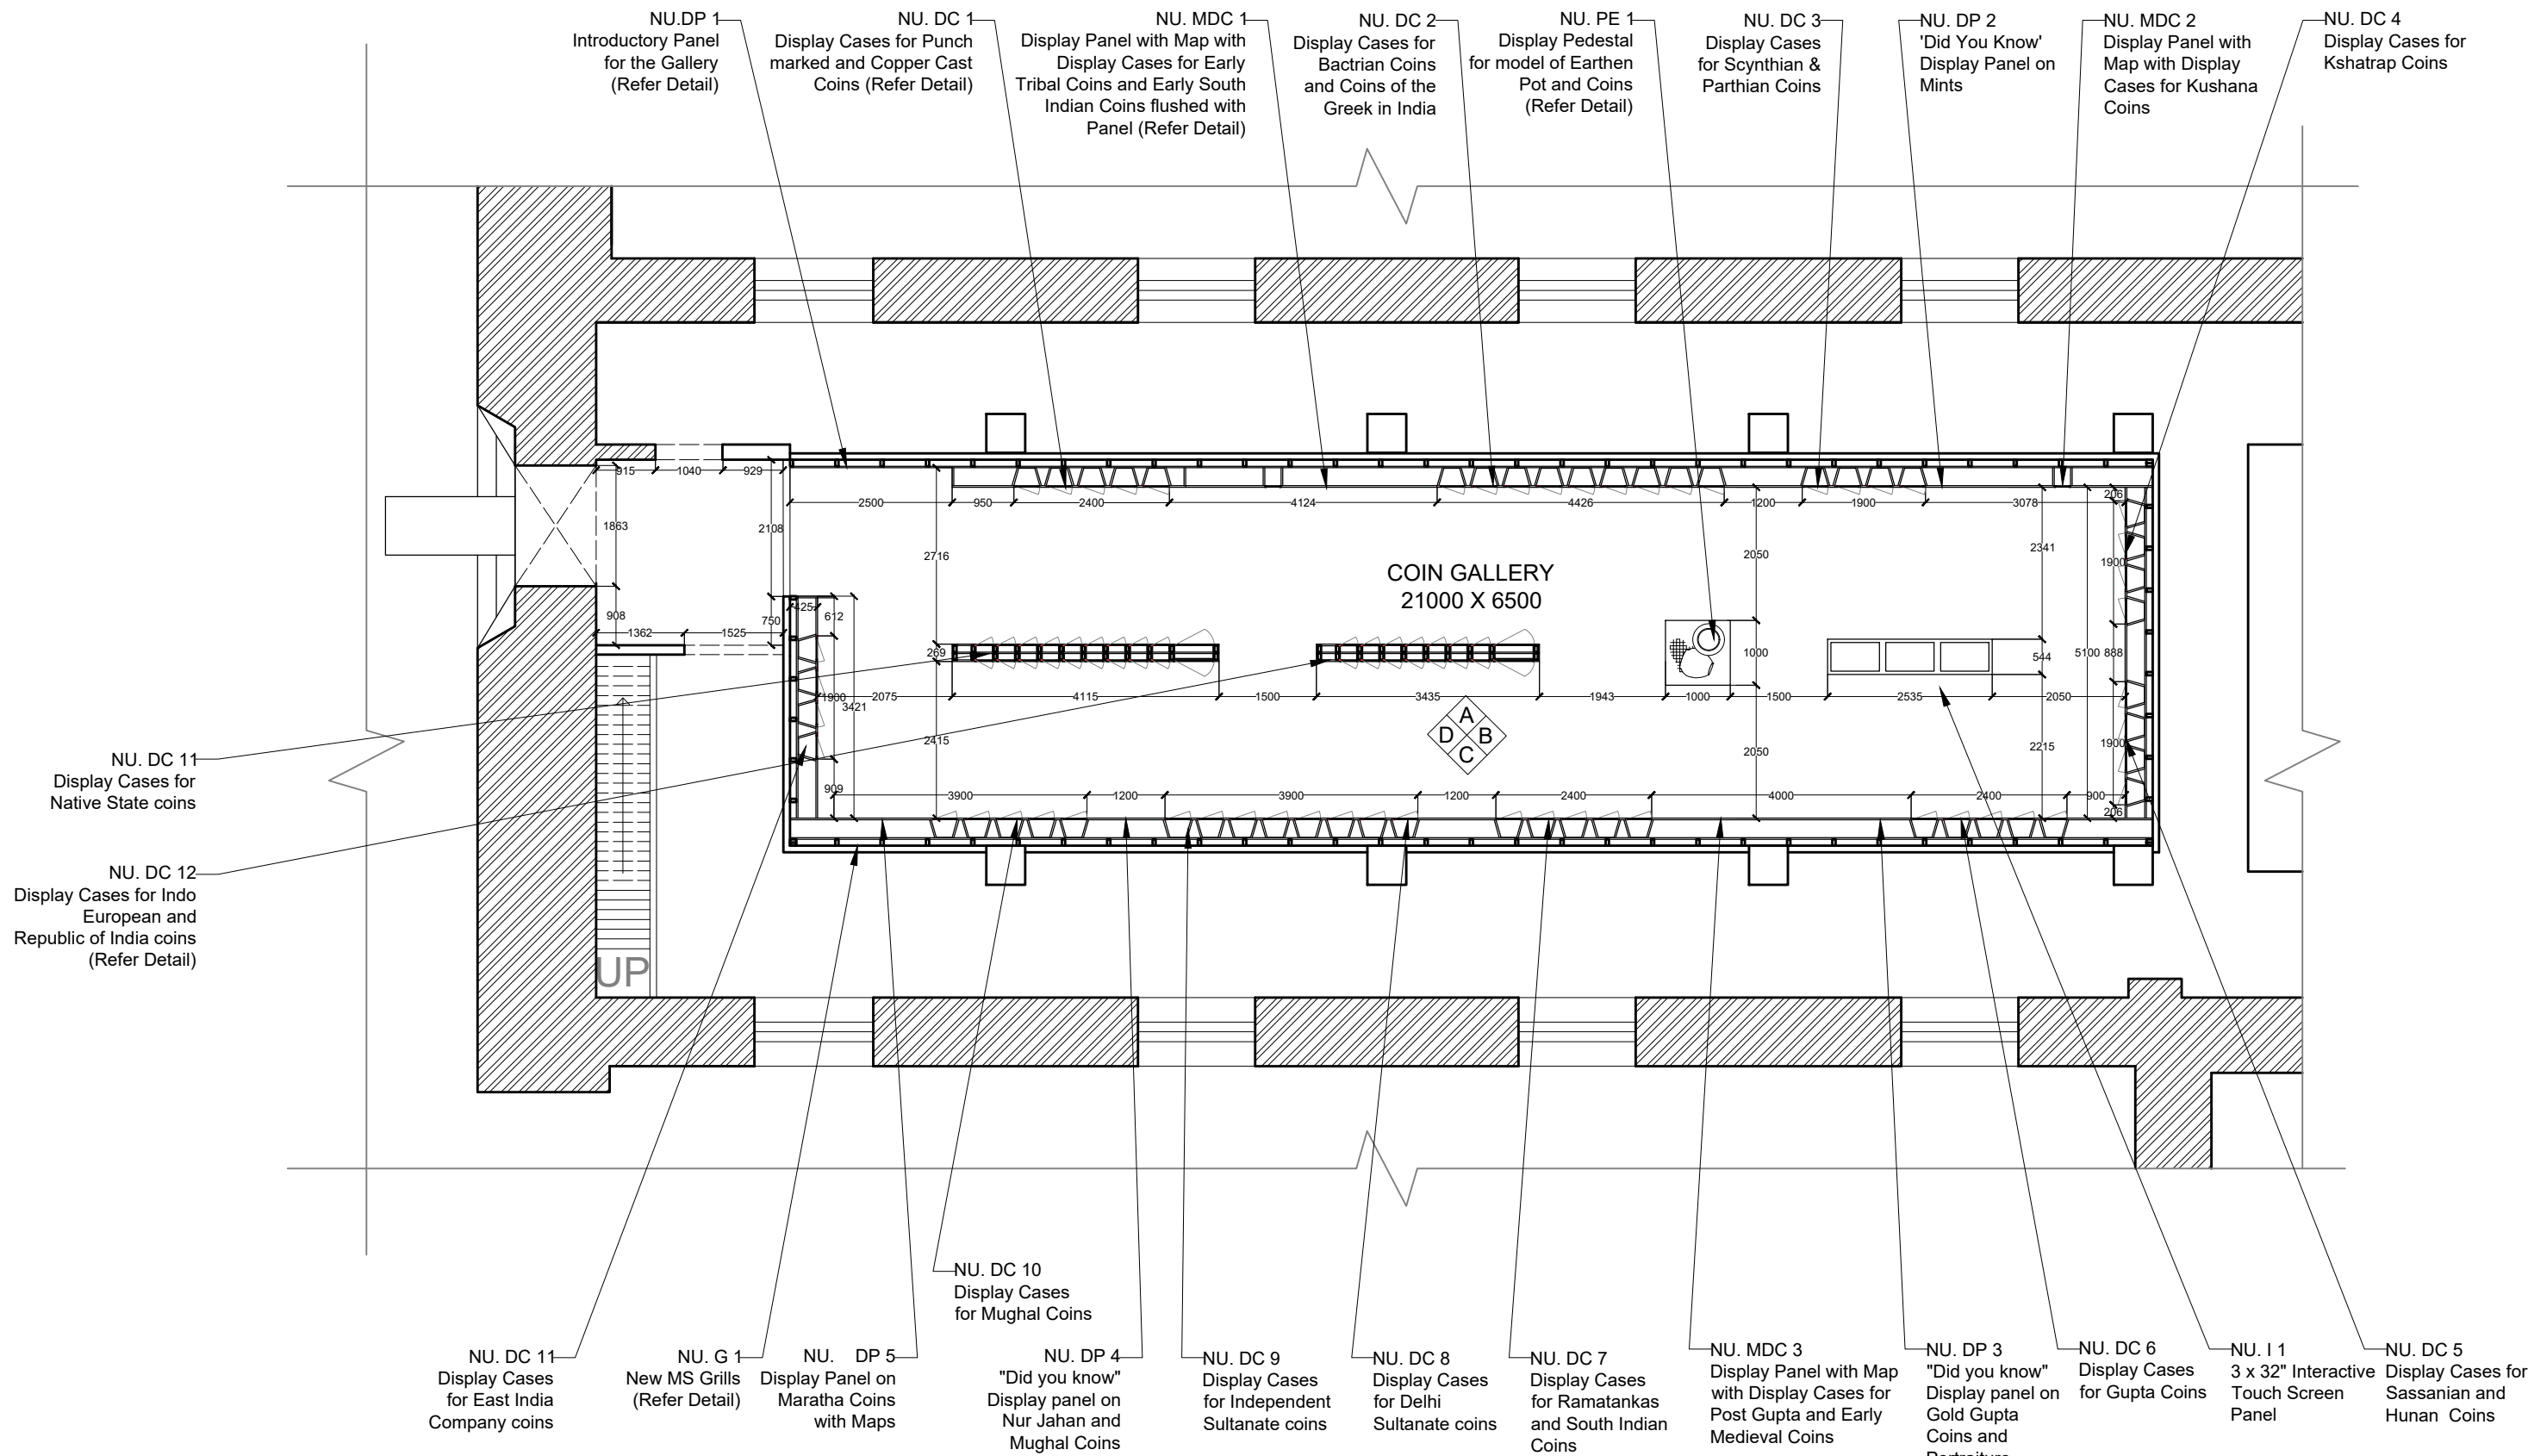


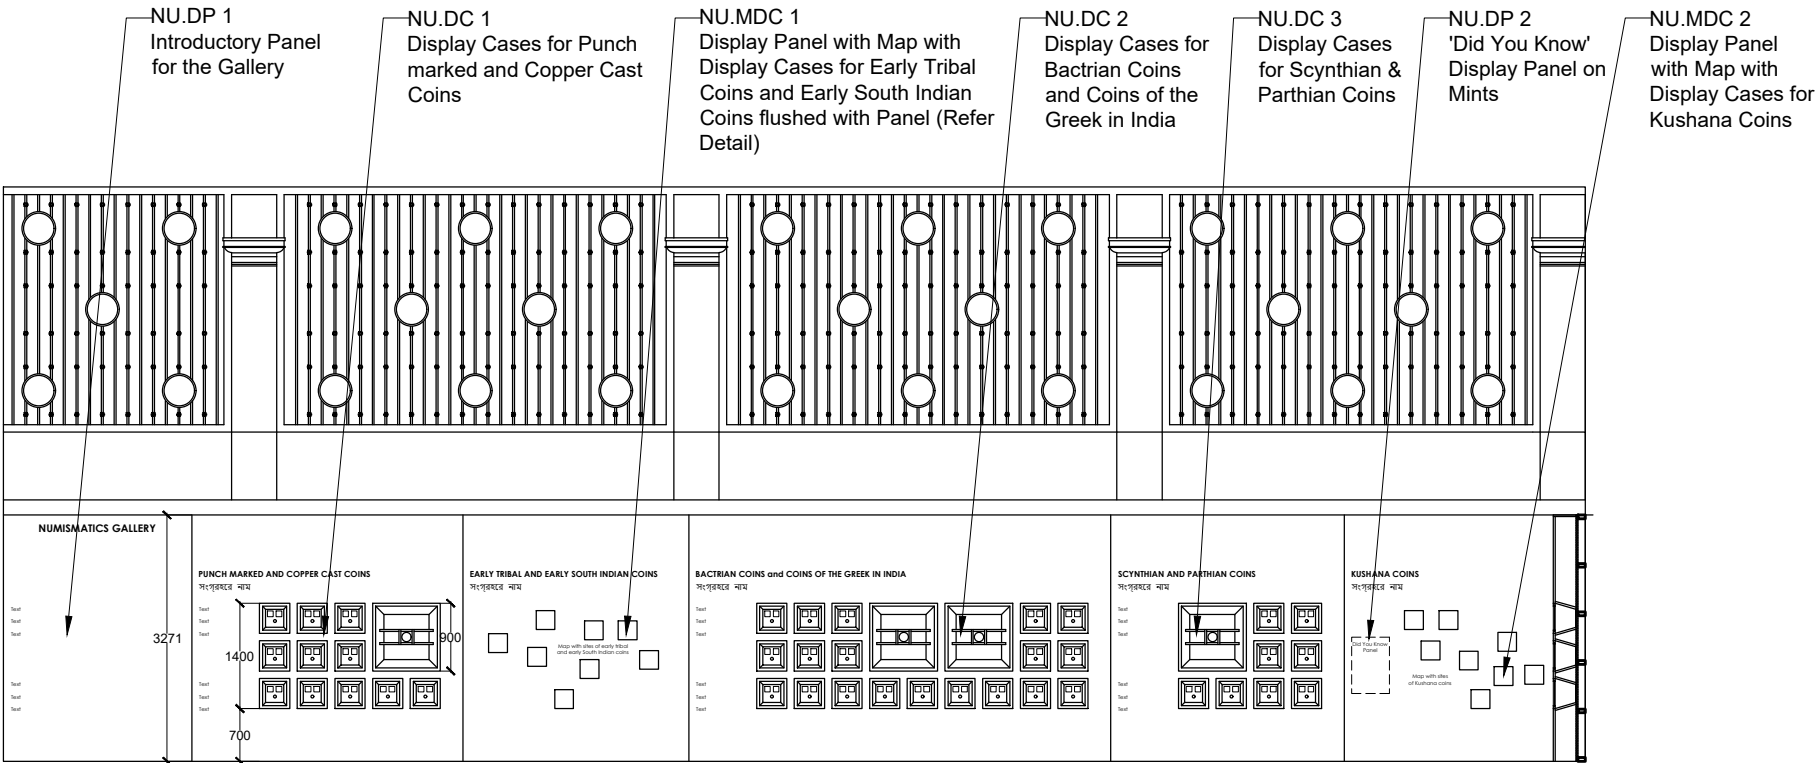


ELEVATION A

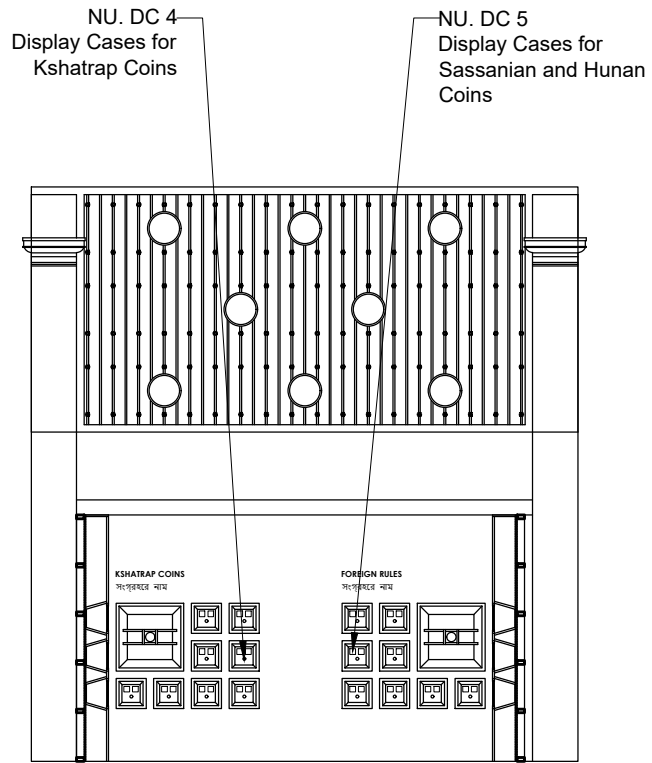

ELEVATION B

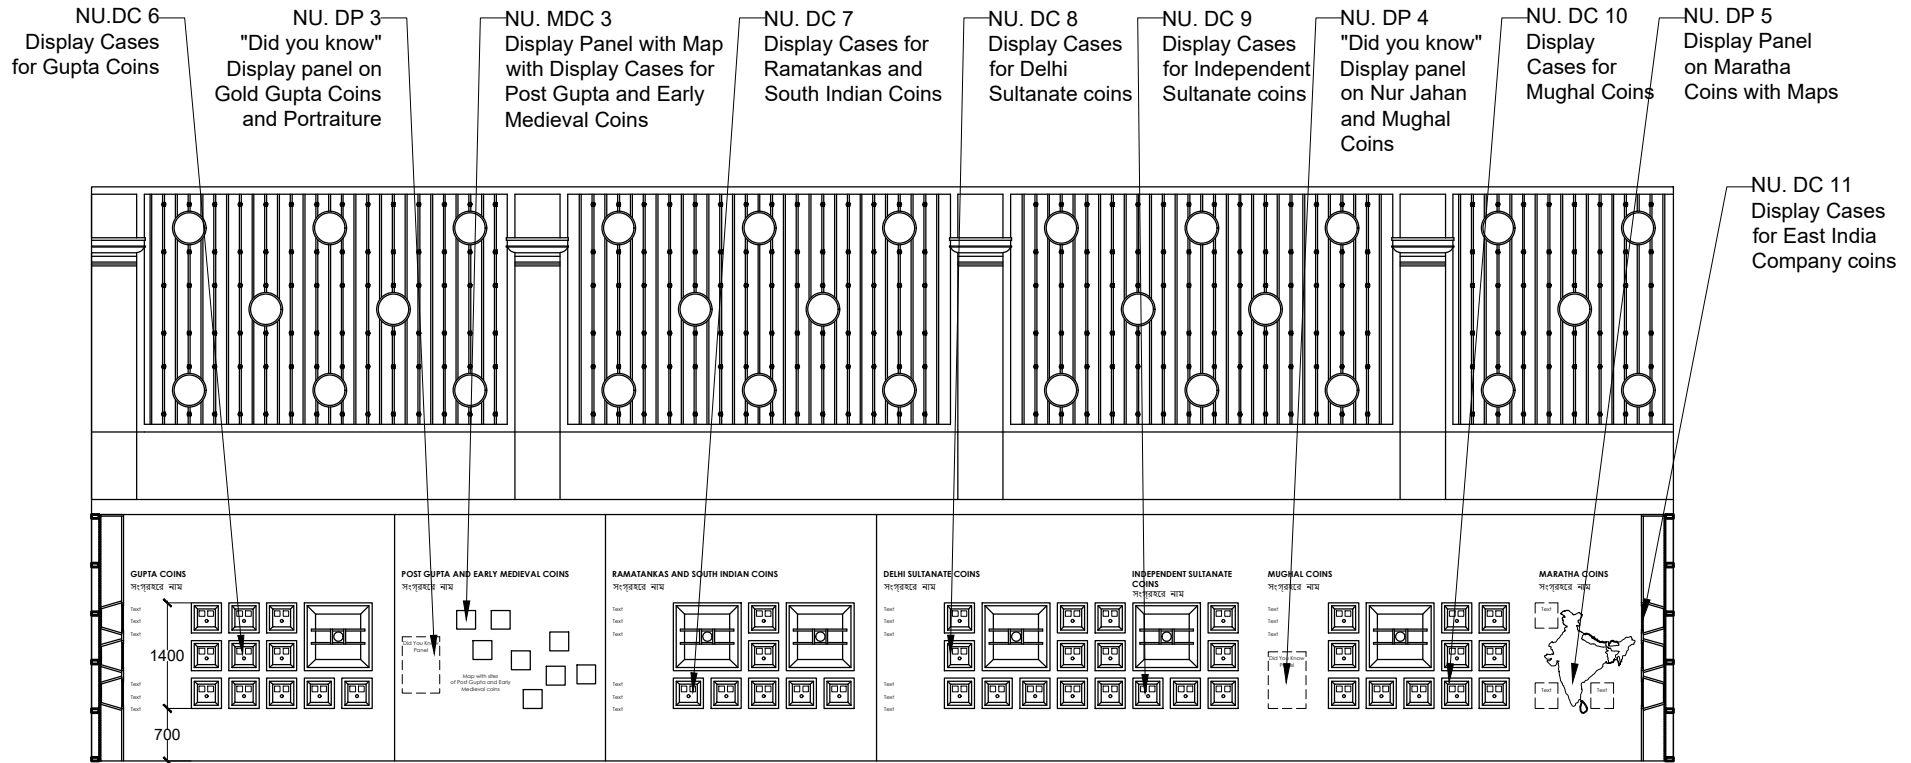

ELEVATION C

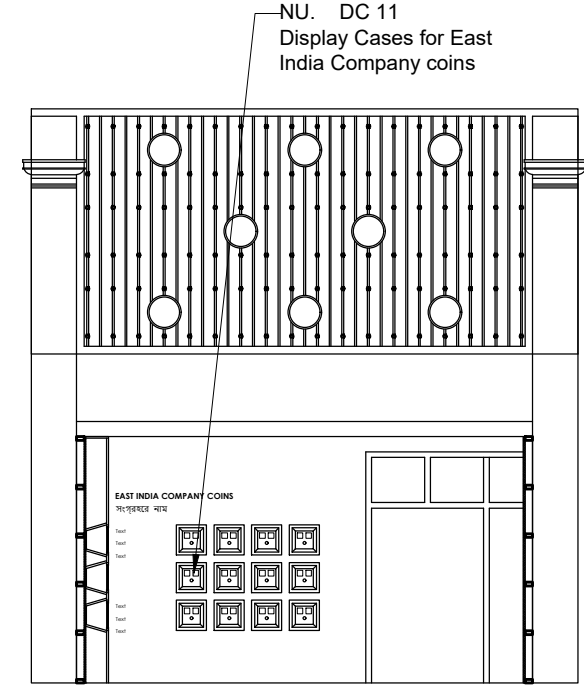

ELEVATION D


**NOTES:**


All dimensions are in millimeters

**KEY PLAN**


**LEGEND**

DP	Display Panel
DC	Display Case
DS	Display Shelf
PE	Pedestal
WM	Wall Mural
WG	Wall Graphics
CP	Canvas Painting
M	Model
MET	Mock Excavation Trench
CP	Canvas Painting
AV	Audio Visuals
I	Interactive
P	Projection
HP	Holographic Projection
GS	Gallery Signage
DS	Directional Signage
LG	Logo
RT	Reception Table
CC	Crowd Control Barrier


<b>SCALE:</b> 1:100	 <b>NORTH</b>
0 1m 2m	
<b>DRAWING NAME:</b> LAYOUT	
<b>NUMISMATICS</b>	
<b>DRAWN BY:</b> Sohini Pyne	
<b>CHECKED BY:</b> Shikha Jain	
<b>DRAWING NUMBER:</b> IMK/GF/NU/02	
<b>SERIES:</b> Tender Drawings	
<b>PROJECT:</b>	
PLANNING, CONTENT DEVELOPMENT, DESIGNING, RETROFITTING AND CURATORIAL WORK FOR THE INDIAN MUSEUM, KOLKATA	
<b>CLIENT:</b>	
INDIAN MUSEUM, KOLKATA	
<b>CONSULTANT:</b>	
<b>DRONAH</b> DEVELOPMENT & RESEARCH ORGANISATION FOR NATURE,ARTS & HERITAGE	
A-258, SOUTH CITY-1 GURGAON-122001	

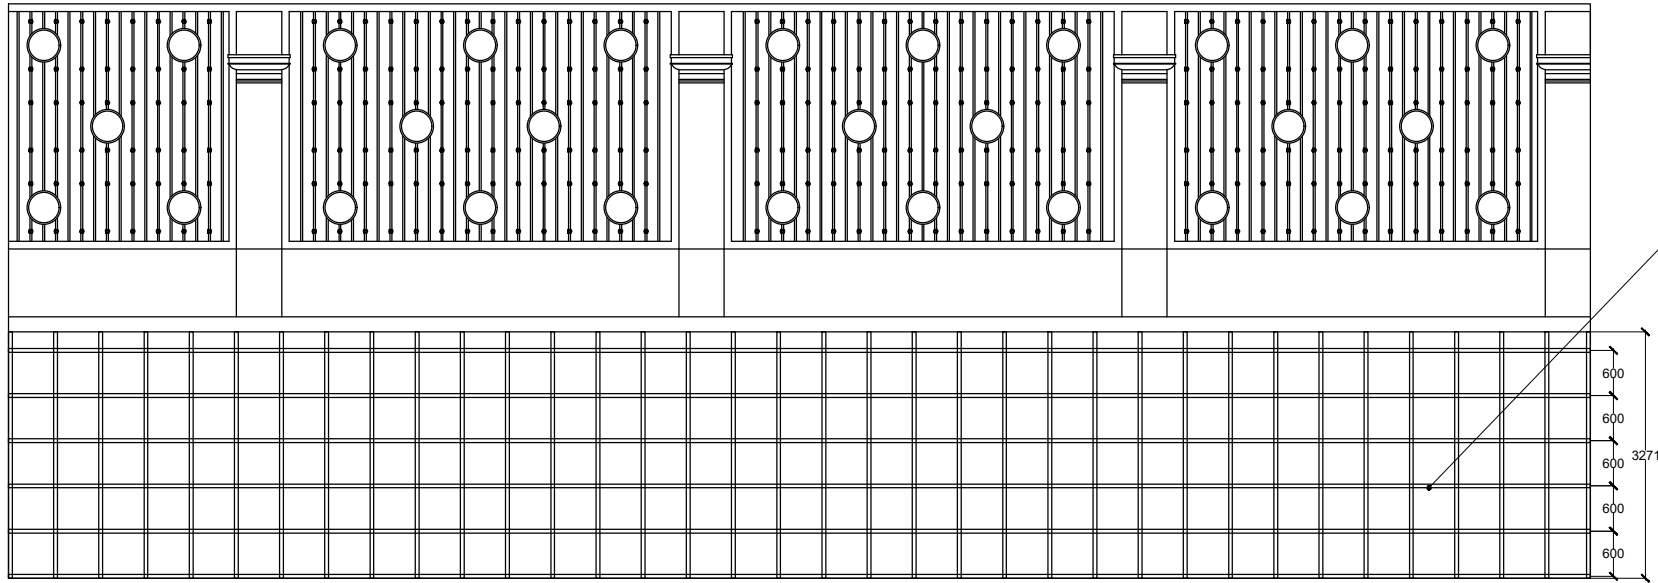


ELEVATION A

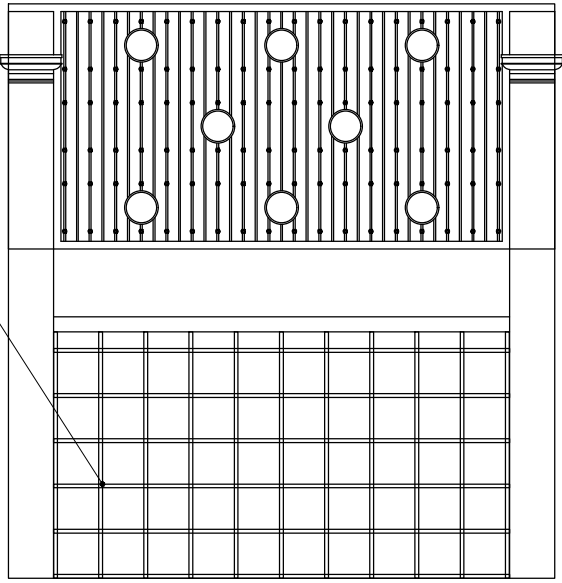

ELEVATION B

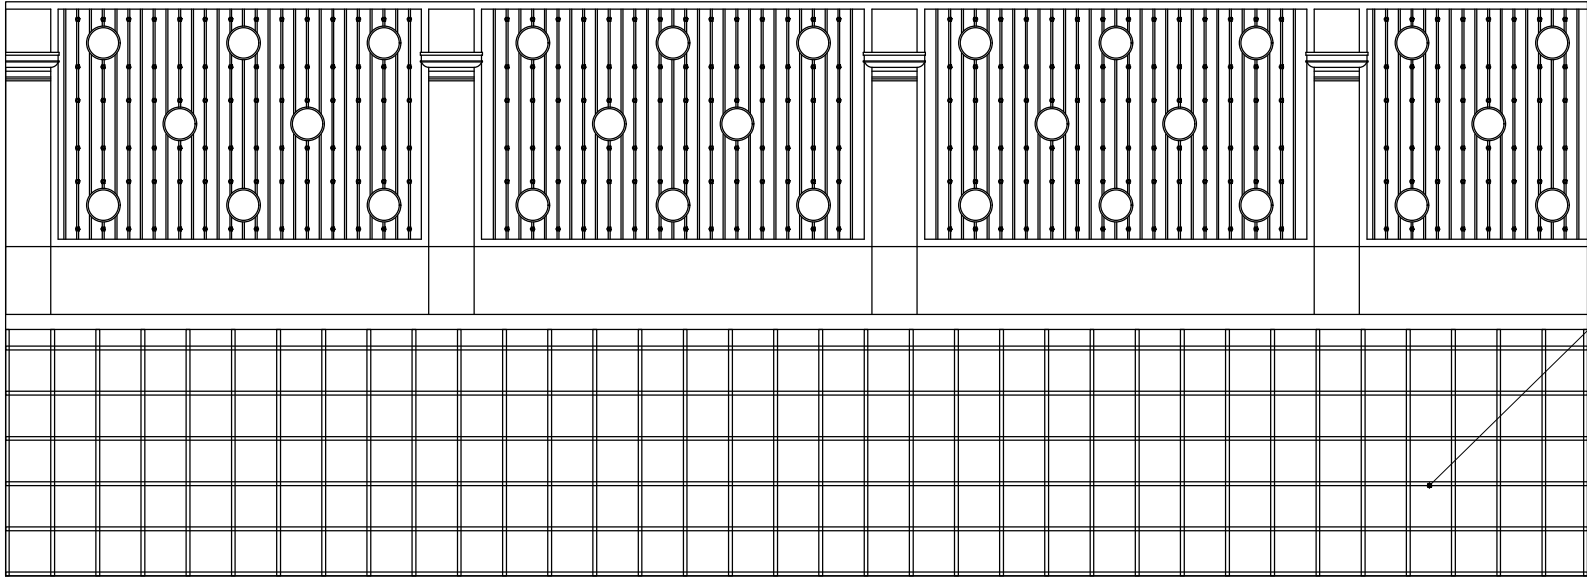

ELEVATION C

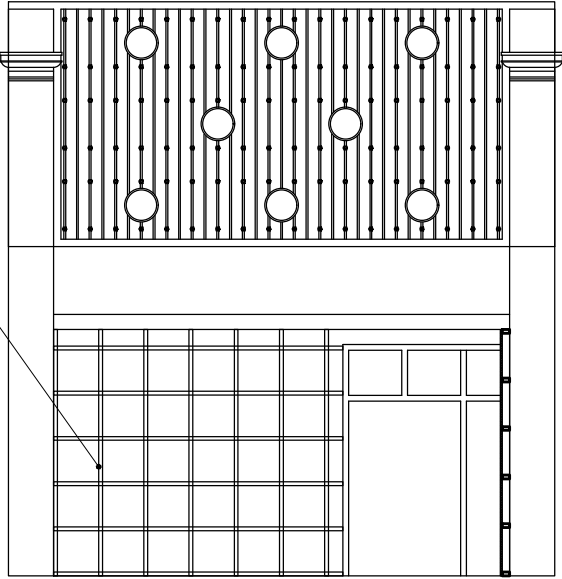


ELEVATION D

NOTES:

All dimensions are in millimeters

KEY PLAN

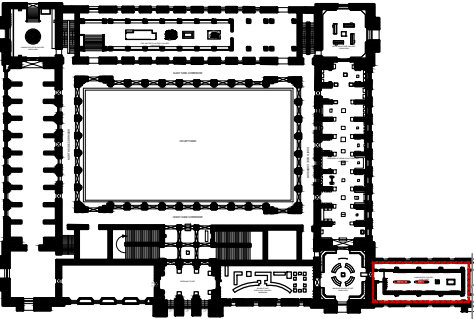

LEGEND

DP	Display Panel
DC	Display Case
DS	Display Shelf
PE	Pedestal
WM	Wall Mural
WG	Wall Graphics
CP	Canvas Painting
M	Model
MET	Mock Excavation Trench
CP	Canvas Painting
AV	Audio Visuals
I	Interactive
P	Projection
HP	Holographic Projection
GS	Gallery Signage
DS	Directional Signage
LG	Logo
RT	Reception Table
CC	Crowd Control Barrier

SCALE: 1:100

0 1m 2m



DRAWING NAME: LAYOUT

NUMISMATICS

DRAWN BY: Sohini Pyne

CHECKED BY: Shikha Jain

DRAWING NUMBER: IMK/GF/NU/03

SERIES: Tender Drawings

PROJECT:

PLANNING, CONTENT  
DEVELOPMENT, DESIGNING,  
RETROFITTING AND CURATORIAL  
WORK FOR THE INDIAN MUSEUM,  
KOLKATA

CLIENT:

INDIAN MUSEUM, KOLKATA


CONSULTANT:

**DRONAH**  
DEVELOPMENT & RESEARCH  
ORGANISATION FOR NATURE,ARTS  
& HERITAGE


A-258, SOUTH CITY-1  
GURGAON-122001



DETAIL NU. DP 1

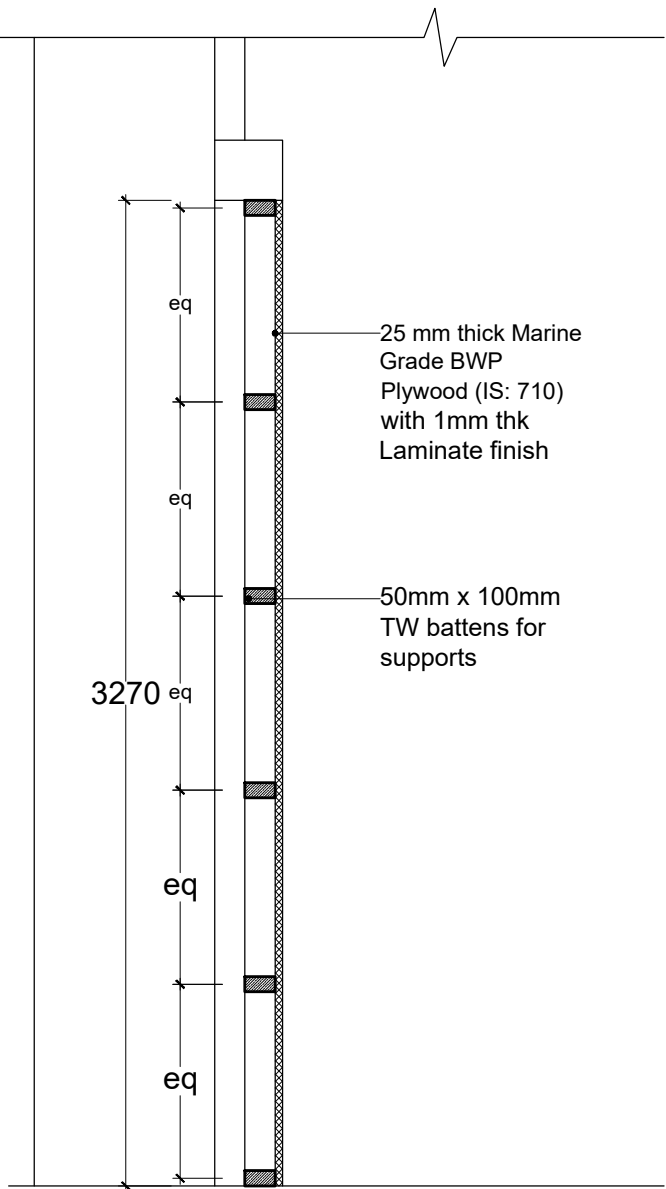


DETAIL NU. DC 1

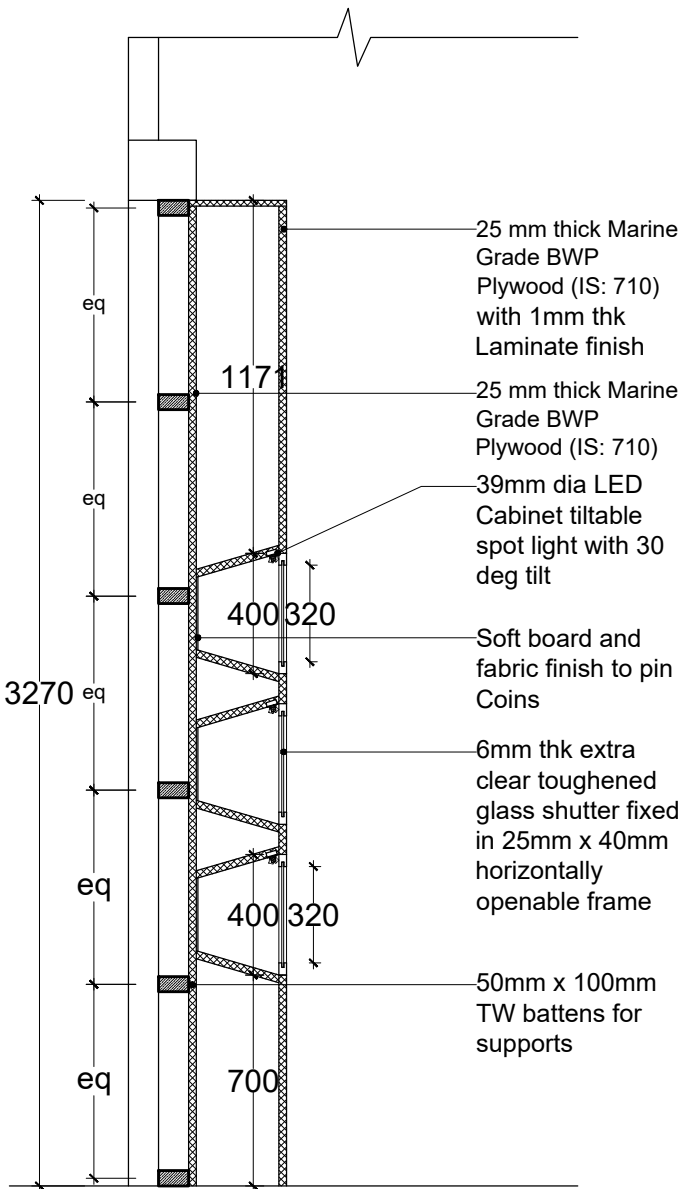


SECTION

PUNCH MARKED AND COPPER CAST COINS  
PUNCH MARKED AND COPPER CAST COINS

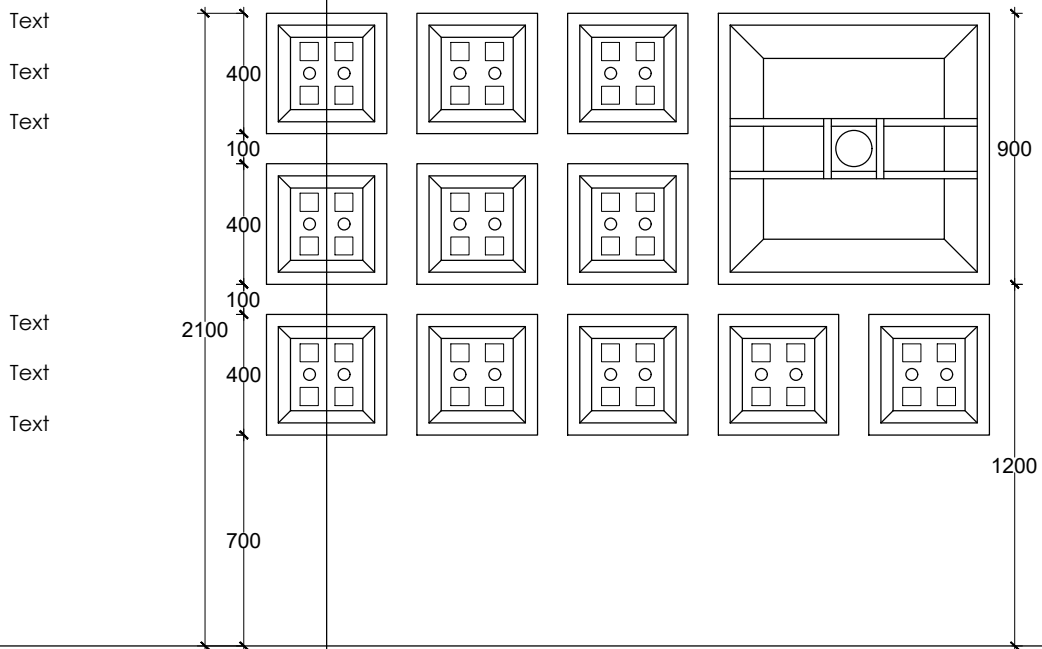

ELEVATION

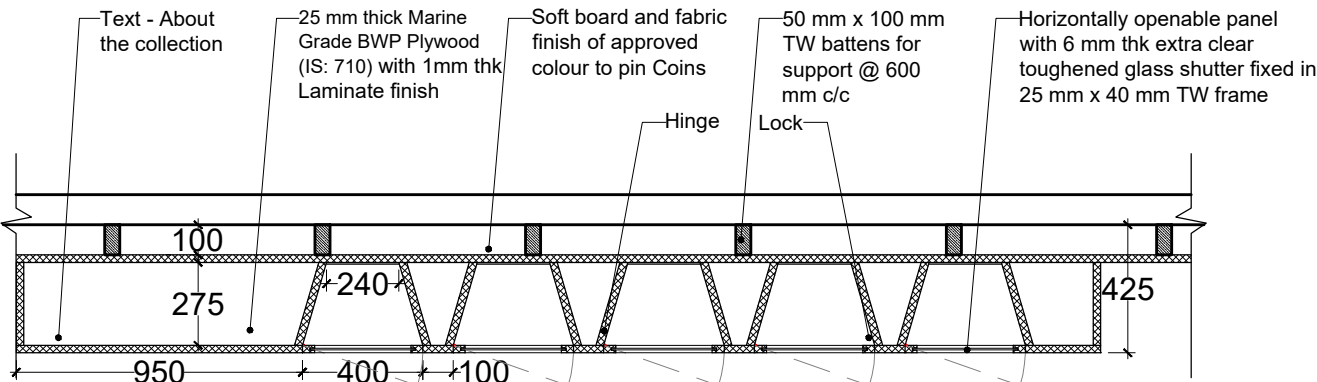


PLAN

NOTES:

All dimensions are in millimeters

KEY PLAN

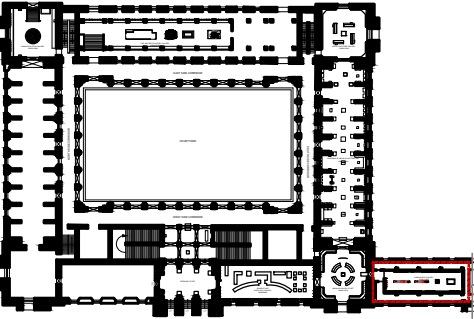

LEGEND

DP	Display Panel
DC	Display Case
DS	Display Shelf
PE	Pedestal
WM	Wall Mural
WG	Wall Graphics
CP	Canvas Painting
M	Model
MET	Mock Excavation Trench
CP	Canvas Painting
AV	Audio Visuals
I	Interactive
P	Projection
HP	Holographic Projection
GS	Gallery Signage
DS	Directional Signage
LG	Logo
RT	Reception Table
CC	Crowd Control Barrier

SCALE: 1:25

0 1m 2m



NORTH

DRAWING NAME: LAYOUT

NUMISMATICS

DRAWN BY: Sohini Pyne

CHECKED BY: Shikha Jain

DRAWING NUMBER: IMK/GF/NU/04

SERIES: Tender Drawings

PROJECT:

PLANNING, CONTENT DEVELOPMENT, DESIGNING, RETROFITTING AND CURATORIAL WORK FOR THE INDIAN MUSEUM, KOLKATA

CLIENT:


INDIAN MUSEUM, KOLKATA

CONSULTANT:



**DRONAH**  
DEVELOPMENT & RESEARCH ORGANISATION FOR NATURE,ARTS & HERITAGE

A-258, SOUTH CITY-1  
GURGAON-122001

DETAIL NU. MDC 1-3

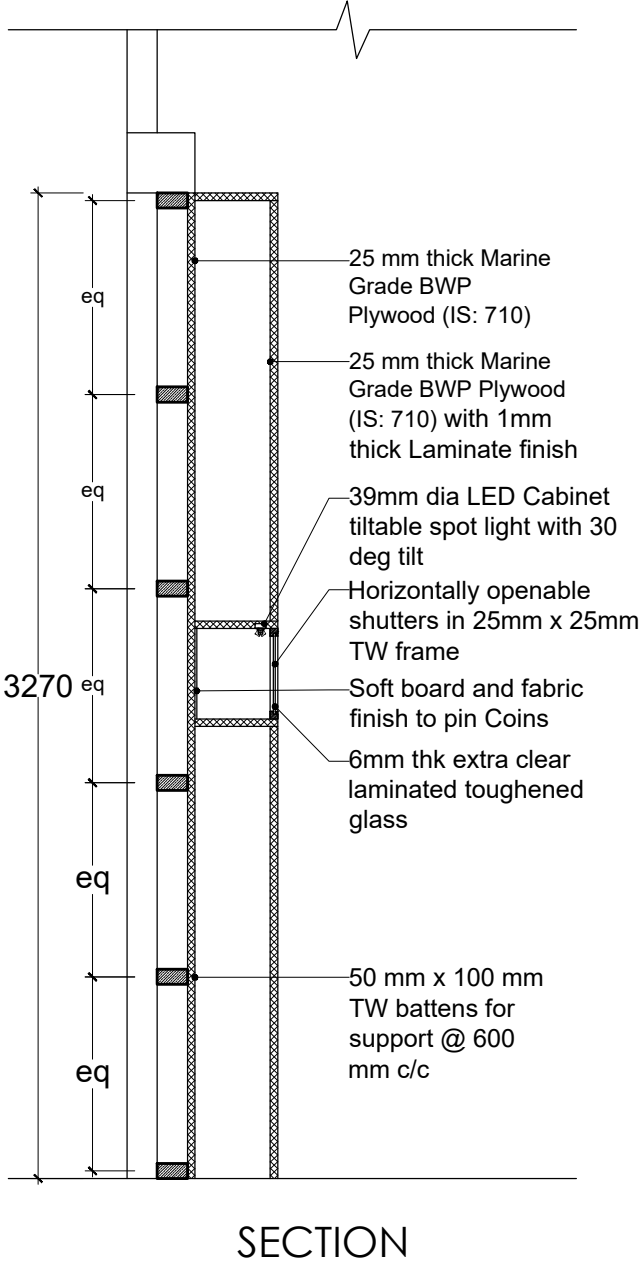


DETAIL NU. DC 11 - 12

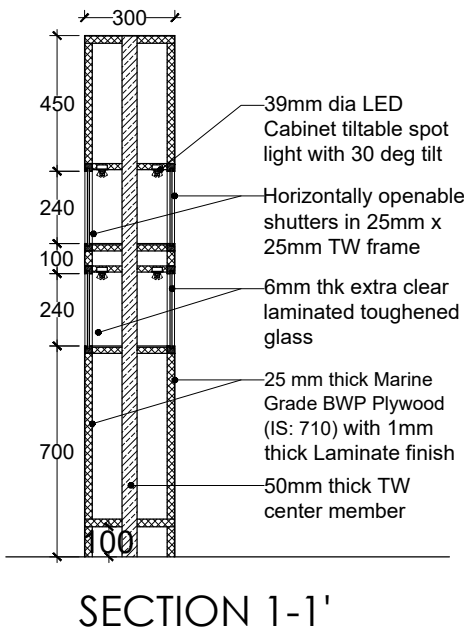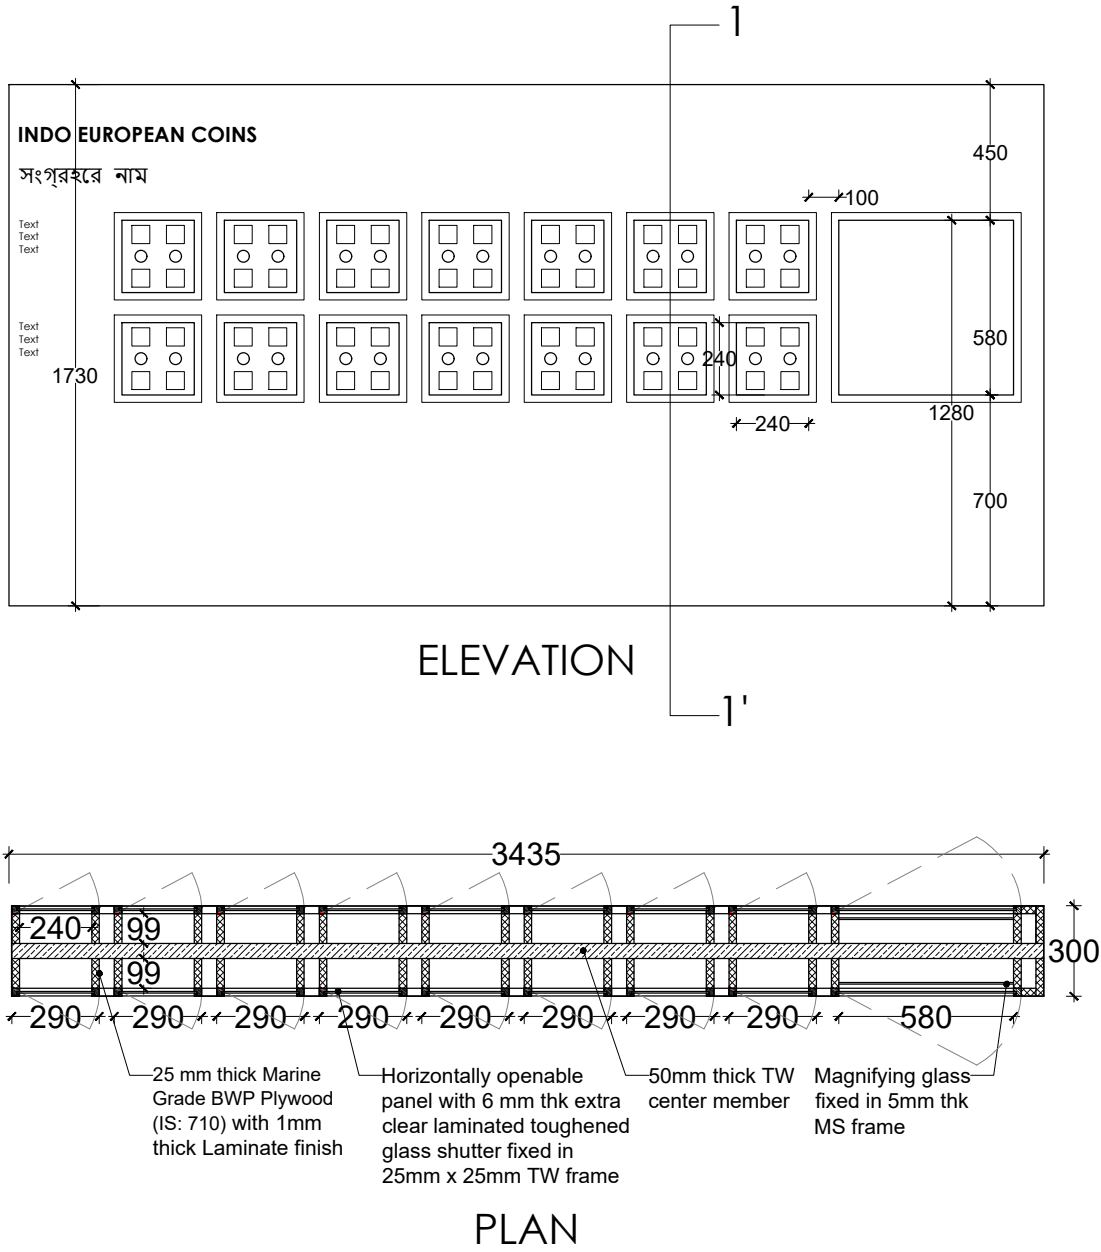

TYPE	Length
DC 11	4388
DC 12	3435


DETAIL NU. PE 1

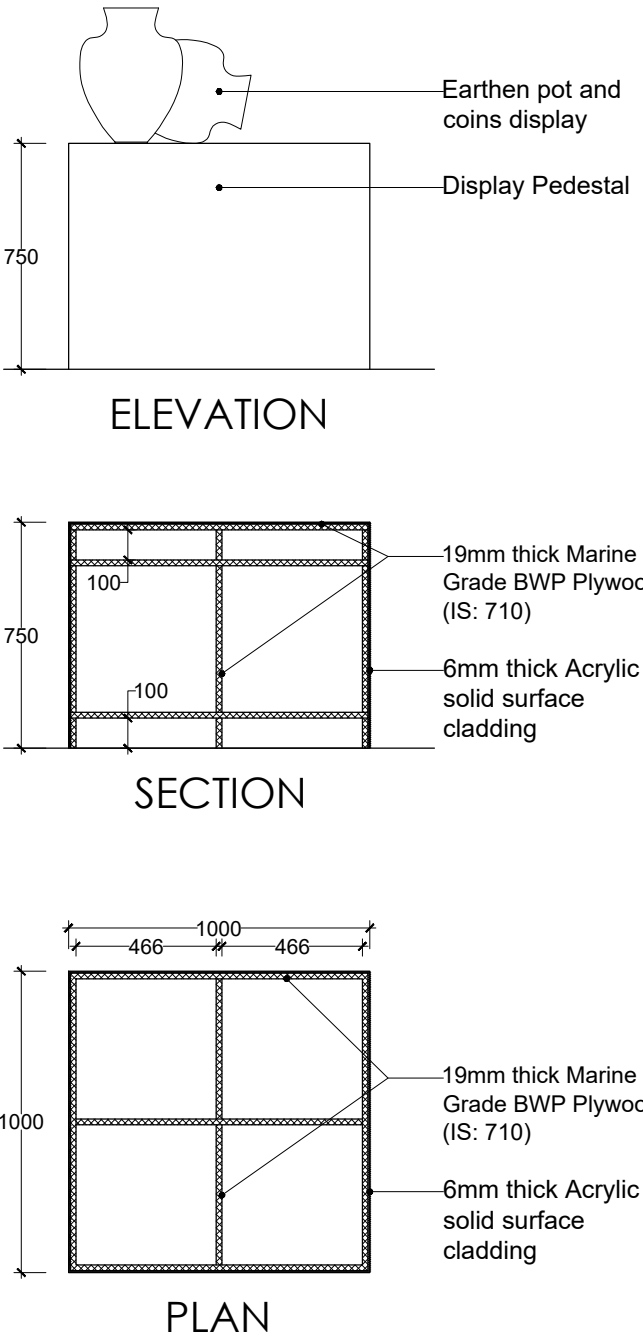

NOTES:

All dimensions are in millimeters

KEY PLAN

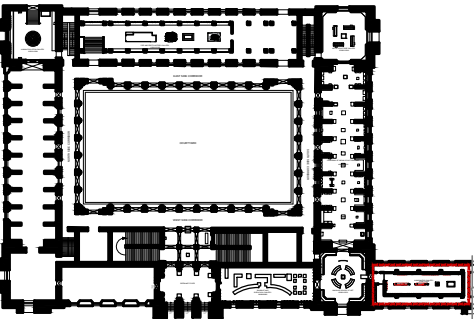

LEGEND

DP	Display Panel
DC	Display Case
DS	Display Shelf
PE	Pedestal
WM	Wall Mural
WG	Wall Graphics
CP	Canvas Painting
M	Model
MET	Mock Excavation Trench
CP	Canvas Painting
AV	Audio Visuals
I	Interactive
P	Projection
HP	Holographic Projection
GS	Gallery Signage
DS	Directional Signage
LG	Logo
RT	Reception Table
CC	Crowd Control Barrier

SCALE: 1:25

0 1m 2m



DRAWING NAME: LAYOUT

NUMISMATICS

DRAWN BY: Sohini Pyne

CHECKED BY: Shikha Jain

DRAWING NUMBER: IMK/GF/NU/05

SERIES: Tender Drawings

PROJECT:

PLANNING, CONTENT DEVELOPMENT, DESIGNING, RETROFITTING AND CURATORIAL WORK FOR THE INDIAN MUSEUM, KOLKATA

CLIENT:


INDIAN MUSEUM, KOLKATA

CONSULTANT:

**DRONAH**  
DEVELOPMENT & RESEARCH ORGANISATION FOR NATURE,ARTS & HERITAGE


A-258, SOUTH CITY-1  
GURGAON-122001

DETAIL NU. G 1

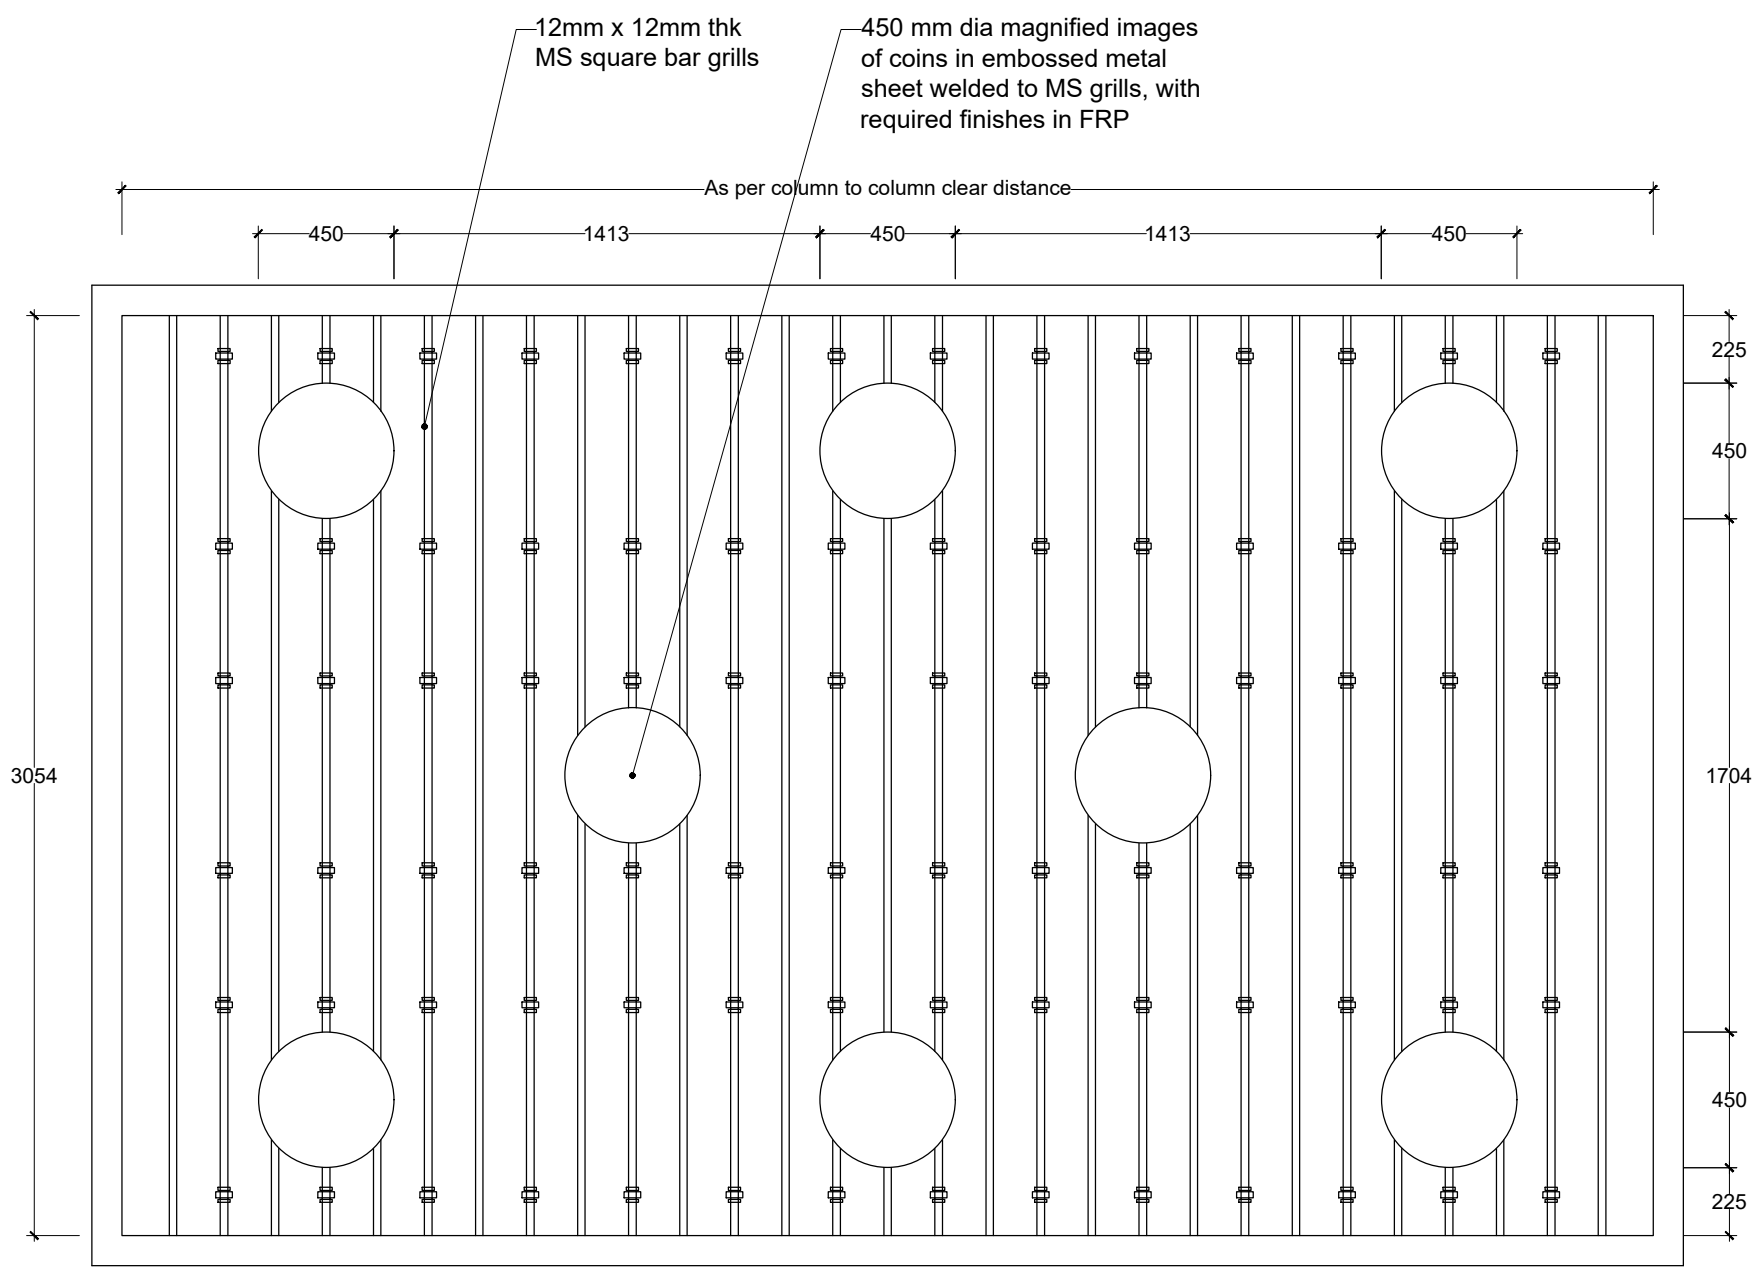

DETAIL F

DETAIL NU. I 1

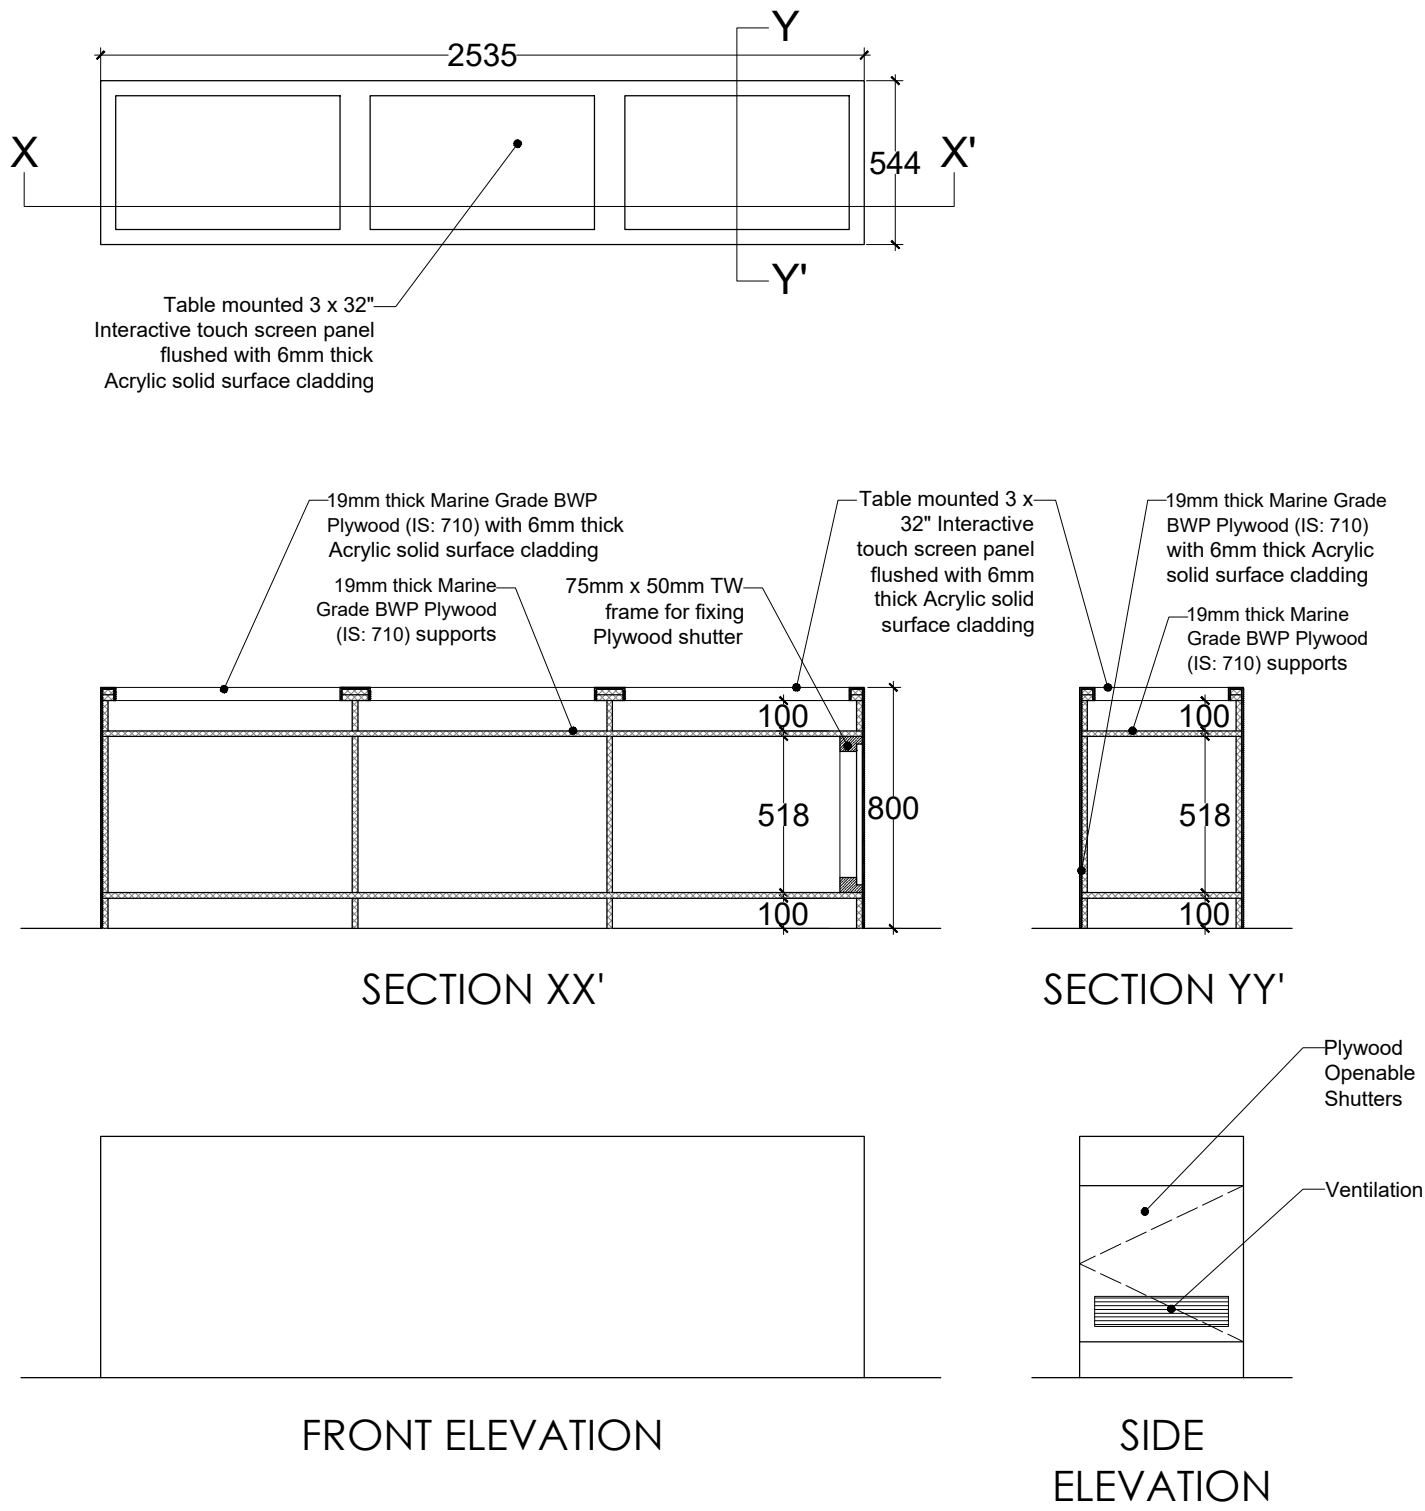


FRONT ELEVATION

SIDE ELEVATION

NOTES:

All dimensions are in millimeters

KEY PLAN

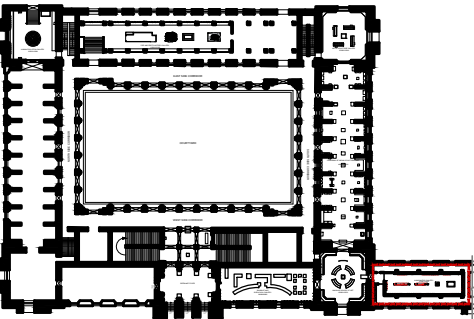

LEGEND

DP	Display Panel
DC	Display Case
DS	Display Shelf
PE	Pedestal
WM	Wall Mural
WG	Wall Graphics
CP	Canvas Painting
M	Model
MET	Mock Excavation Trench
CP	Canvas Painting
AV	Audio Visuals
I	Interactive
P	Projection
HP	Holographic Projection
GS	Gallery Signage
DS	Directional Signage
LG	Logo
RT	Reception Table
CC	Crowd Control Barrier

SCALE: 1:25

0 1m 2m



DRAWING NAME: LAYOUT

NUMISMATICS

DRAWN BY: Sohini Pyne

CHECKED BY: Shikha Jain

DRAWING NUMBER: IMK/GF/NU/06

SERIES: Tender Drawings

PROJECT:

PLANNING, CONTENT DEVELOPMENT, DESIGNING, RETROFITTING AND CURATORIAL WORK FOR THE INDIAN MUSEUM, KOLKATA


CLIENT:

INDIAN MUSEUM, KOLKATA

CONSULTANT:

**DRONAH**  
DEVELOPMENT & RESEARCH  
ORGANISATION FOR NATURE,ARTS  
& HERITAGE

A-258, SOUTH CITY-1  
GURGAON-122001

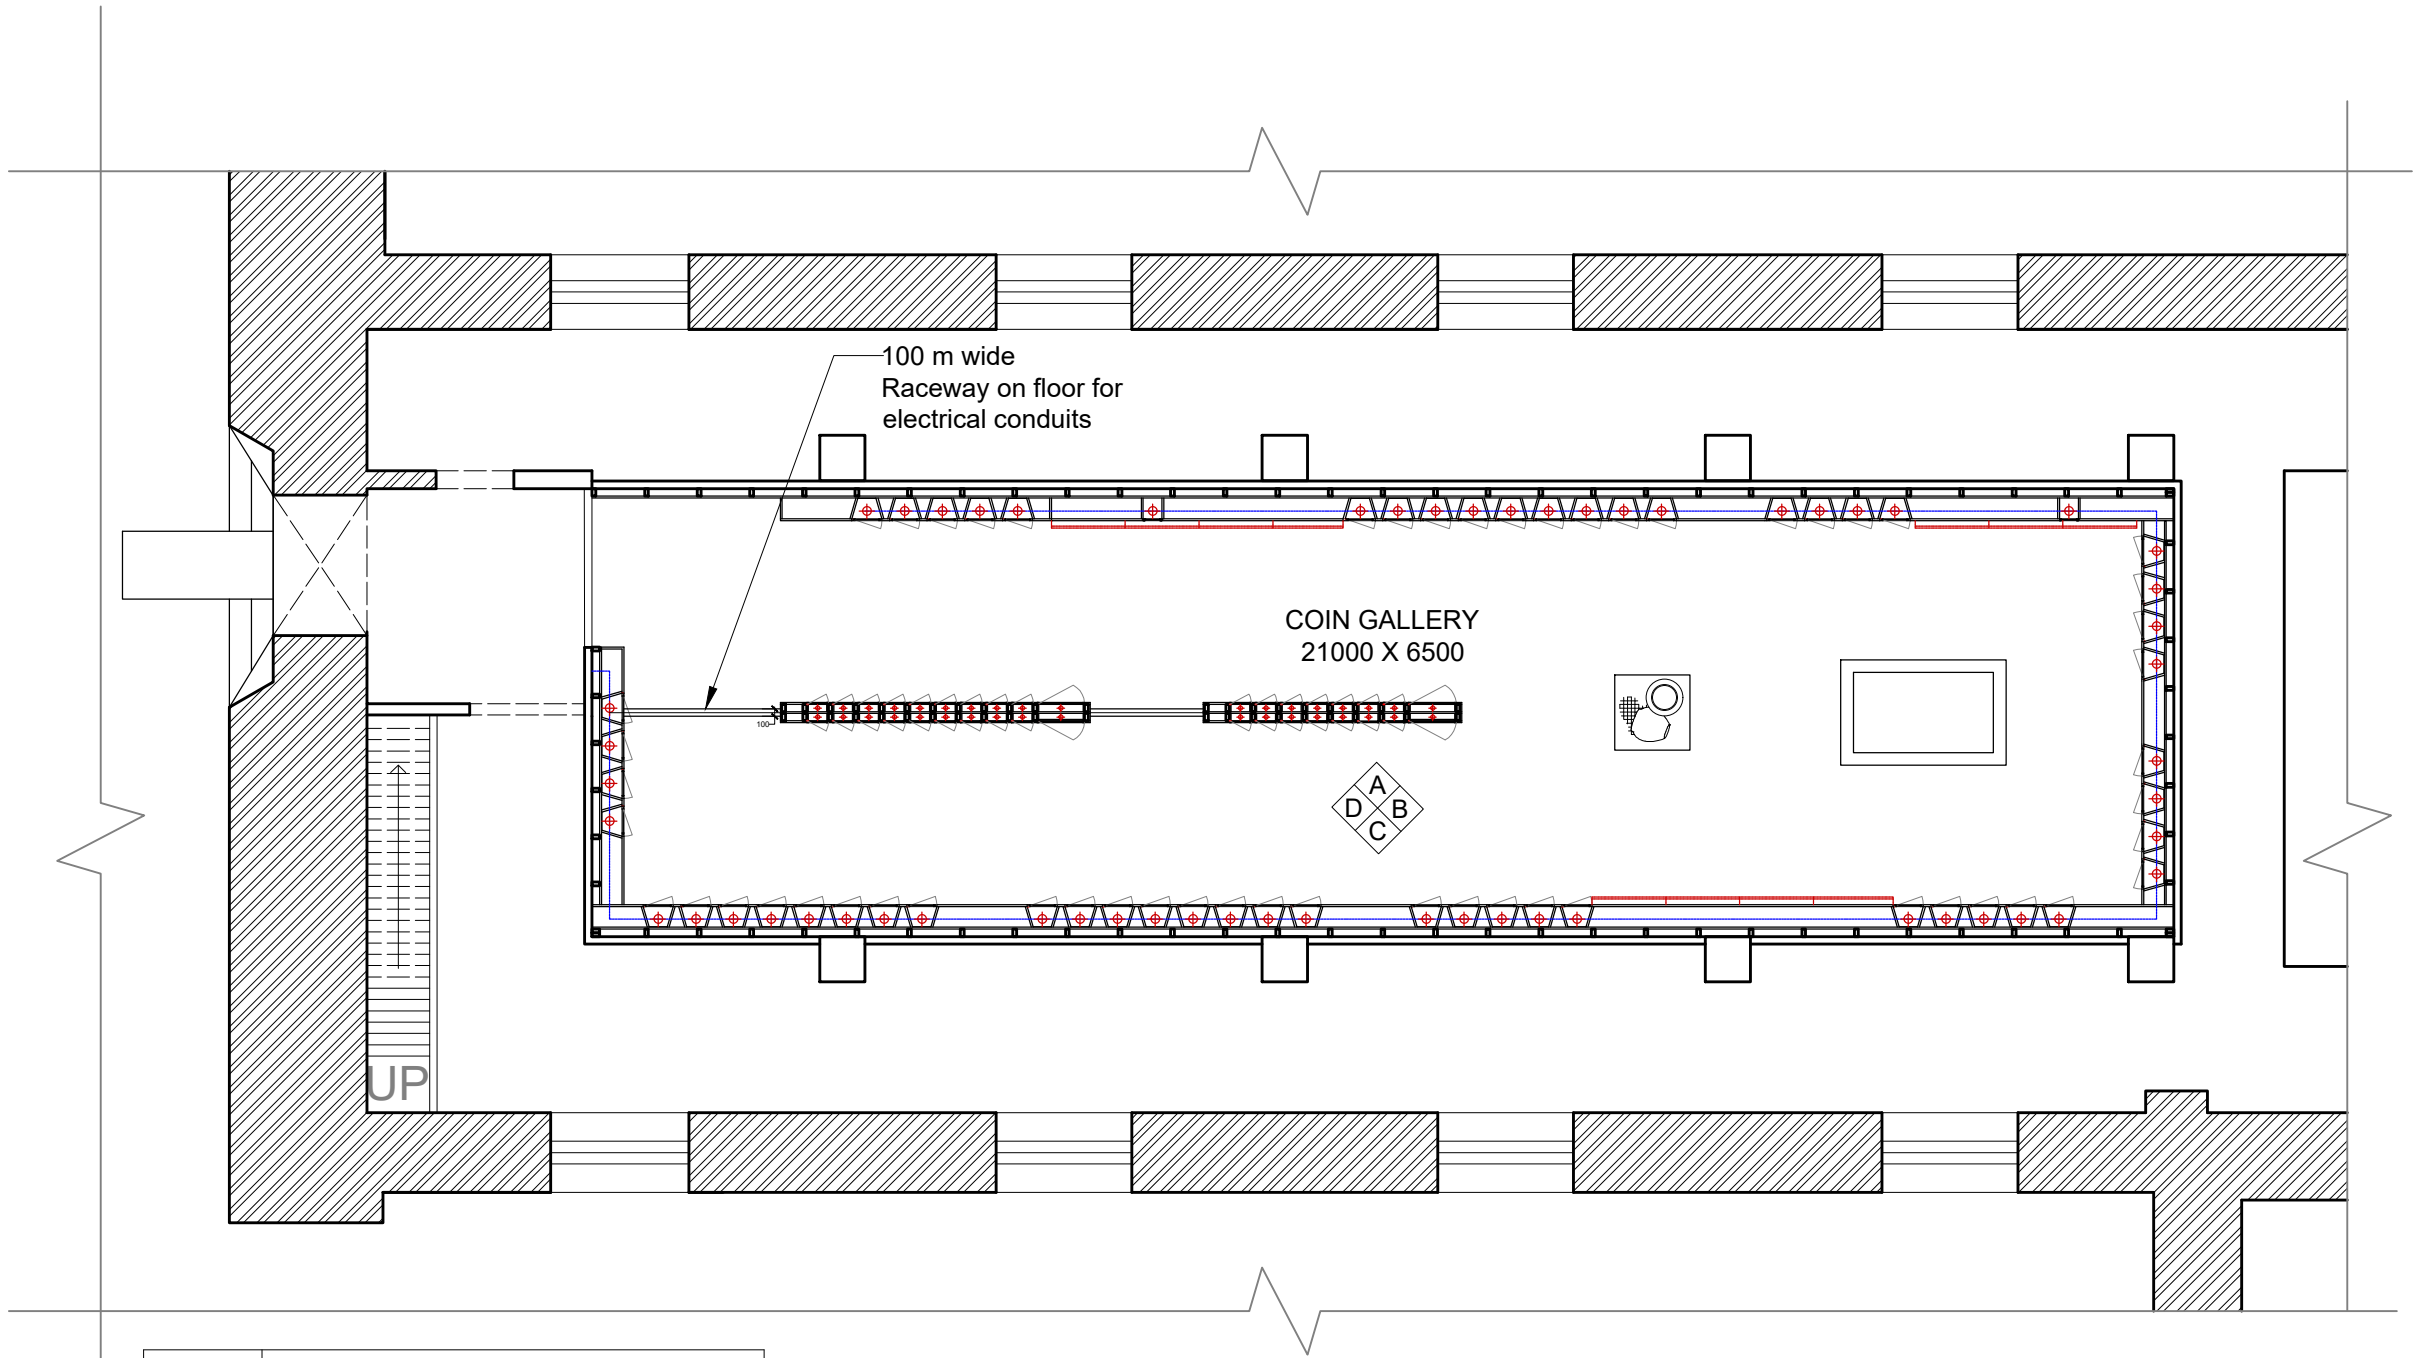


Sym	Type
	Mini cabinet tiltable spot light
	Linear wall grazer (980 mm length)
	Ceiling Light Conduit
	Floor Light conduit

NOTES:

All dimensions are in millimeters

KEY PLAN

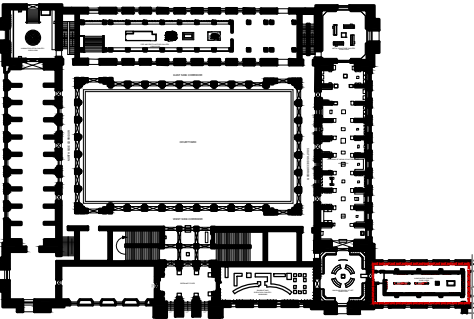

SCALE: 1:100

0 1m 2m



DRAWING: LIGHTING LAYOUT

NUMISMATICS

DRAWN BY: Sohini Pyne

CHECKED BY: Shikha Jain

DRAWING NUMBER: IMK/GF/NU/07

SERIES: Tender Drawings

PROJECT:

PLANNING, CONTENT DEVELOPMENT, DESIGNING, RETROFITTING AND CURATORIAL WORK FOR THE INDIAN MUSEUM, KOLKATA

CLIENT:

INDIAN MUSEUM, KOLKATA


CONSULTANT:

**DRONAH**  
DEVELOPMENT & RESEARCH  
ORGANISATION FOR NATURE,ARTS  
& HERITAGE

A-258, SOUTH CITY-1  
GURGAON-122001





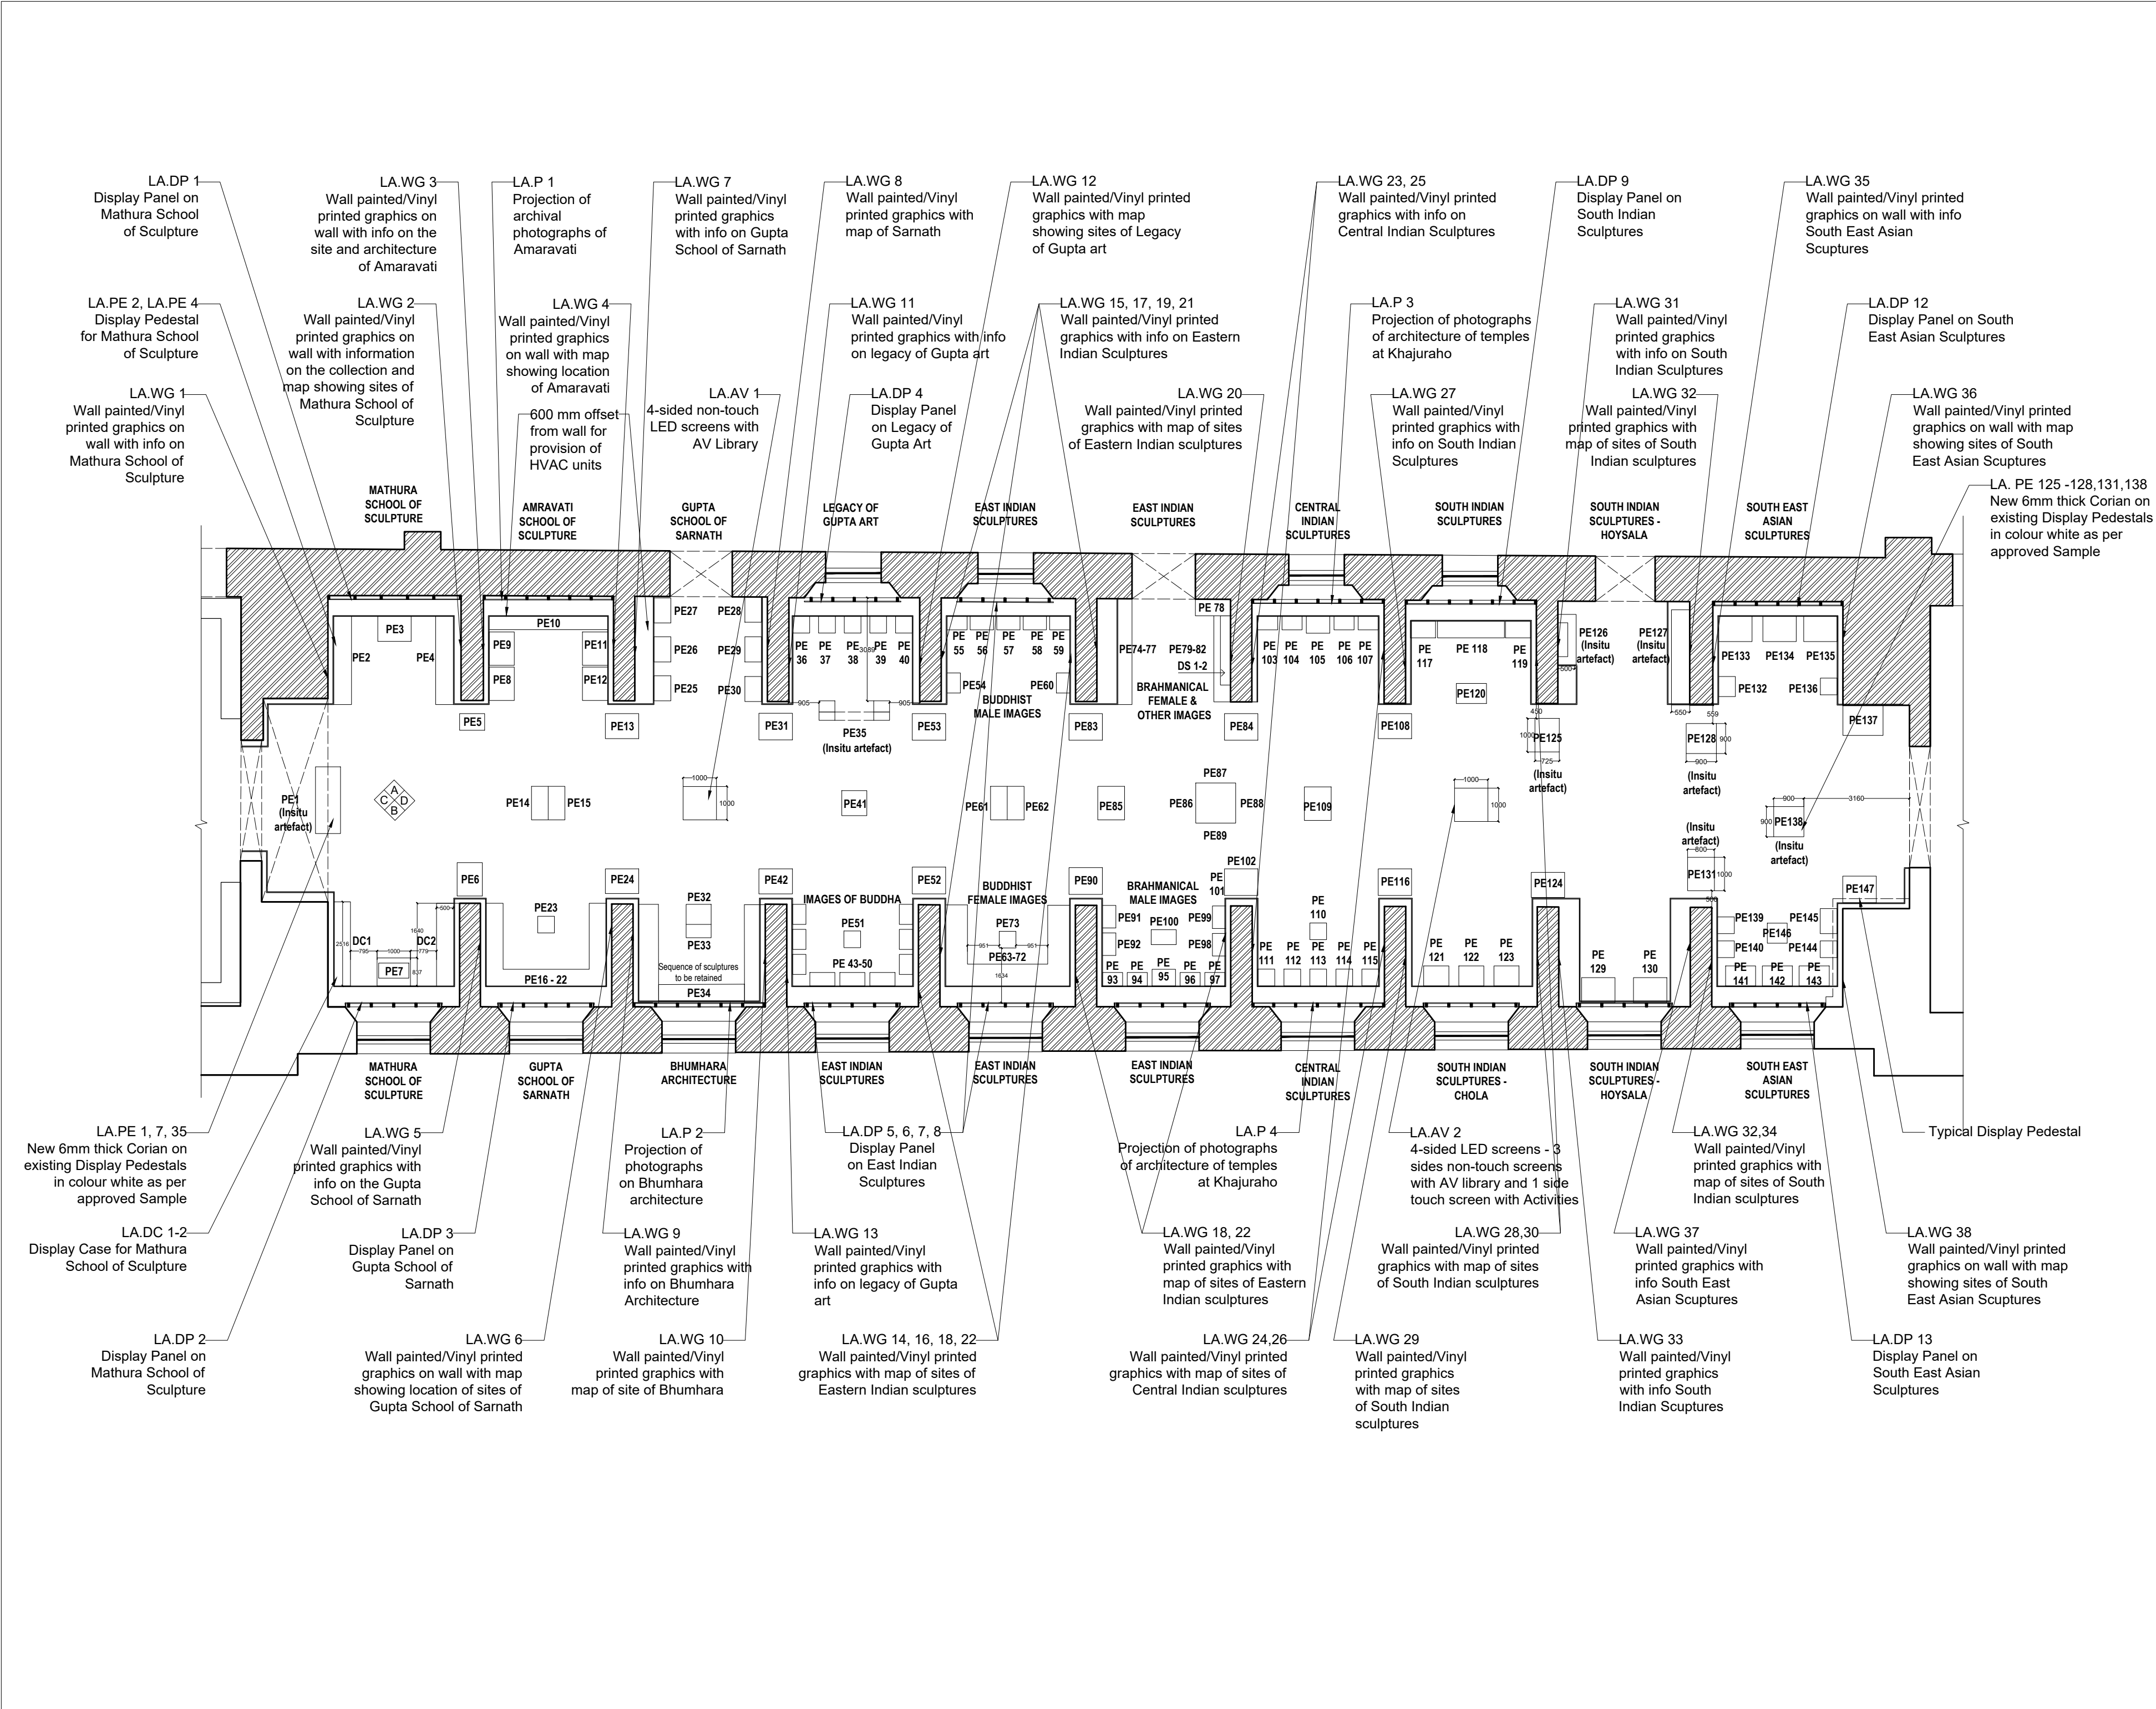

**NOTES:**  
All dimensions are in millimeters

**KEY PLAN**

**LEGEND**

DP	Display Panel
DC	Display Case
DS	Display Shelf
PE	Pedestal
WM	Wall Mural
WG	Wall Graphics
CP	Canvas Painting
M	Model
MET	Mock Excavation Trench
CP	Canvas Painting
AV	Audio Visuals
I	Interactive
P	Projection
HP	Holographic Projection
GS	Gallery Signage
DS	Directional Signage
LG	Logo
RT	Reception Table
CC	Crowd Control Barrier

SCALE: 1:125  
0 1m 2m

**NORTH**

**DRAWING NAME:** LAYOUT

**DRAWN BY:** Sohini Pyne

**CHECKED BY:** Shikha Jain

**DRAWING NUMBER:** IMK/GF/PA/01

**PANORAMA OF INDIAN SCULPTURAL ART**

**SERIES:** Tender Drawings

**PROJECT:**  
PLANNING, CONTENT DEVELOPMENT, DESIGNING, RETROFITTING AND CURATORIAL WORK FOR THE INDIAN MUSEUM, KOLKATA


**CLIENT:**  
INDIAN MUSEUM, KOLKATA

**CONSULTANT:**  
**DRONAH**  
DEVELOPMENT & RESEARCH ORGANISATION FOR NATURE,ARTS & HERITAGE  
  
A-258, SOUTH CITY-1  
GURGAON-122001

NOTES:

All dimensions are in millimeters

KEY PLAN

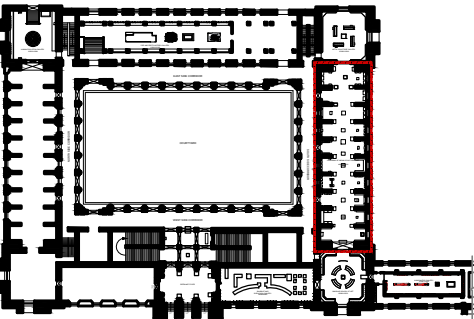

LEGEND

DP	Display Panel
DC	Display Case
DS	Display Shelf
PE	Pedestal
WM	Wall Mural
WG	Wall Graphics
CP	Canvas Painting
M	Model
MET	Mock Excavation Trench
CP	Canvas Painting
AV	Audio Visuals
I	Interactive
P	Projection
HP	Holographic Projection
GS	Gallery Signage
DS	Directional Signage
LG	Logo
RT	Reception Table
CC	Crowd Control Barrier

SCALE: 1:100

0 1m 2m



DRAWING NAME: LAYOUT

DRAWN BY: Sohini Pyne

CHECKED BY: Shikha Jain

DRAWING NUMBER: IMK/GF/PA/02

SERIES: Tender Drawings

PANORAMA OF INDIAN SCULPTURAL ART

PROJECT:

PLANNING, CONTENT DEVELOPMENT, DESIGNING, RETROFITTING AND CURATORIAL WORK FOR THE INDIAN MUSEUM, KOLKATA


CLIENT:

INDIAN MUSEUM, KOLKATA


CONSULTANT:

**DRONAH**  
DEVELOPMENT & RESEARCH  
ORGANISATION FOR NATURE,ARTS  
& HERITAGE


A-258, SOUTH CITY-1  
GURGAON-122001

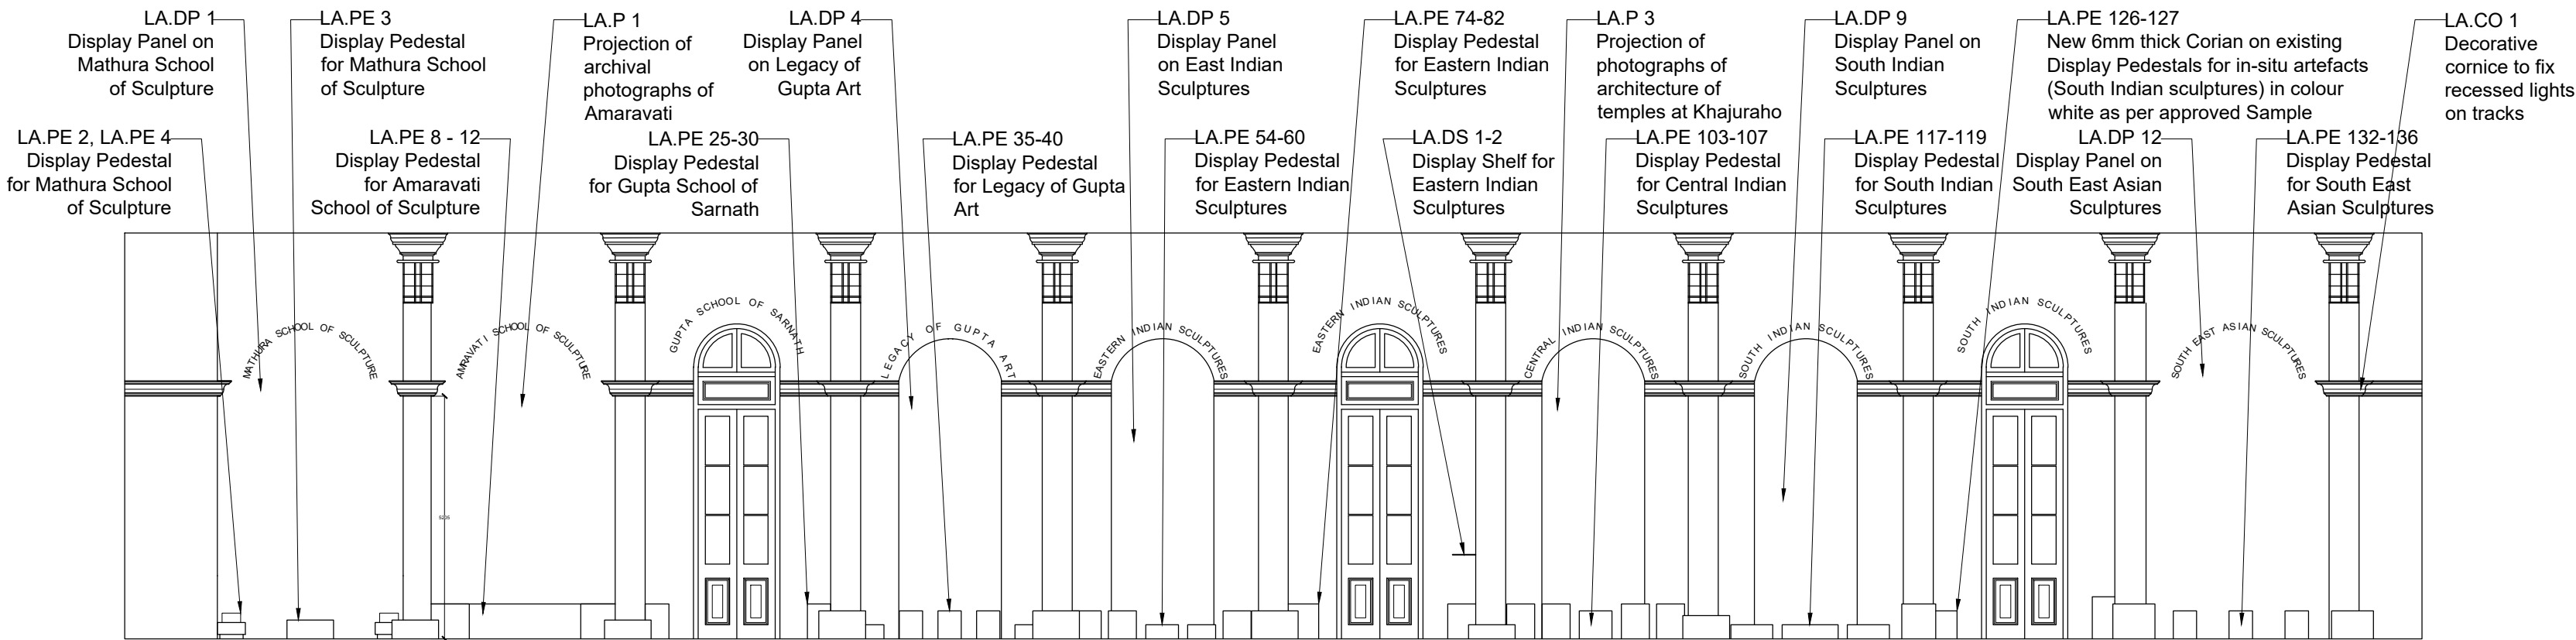


ELEVATION A

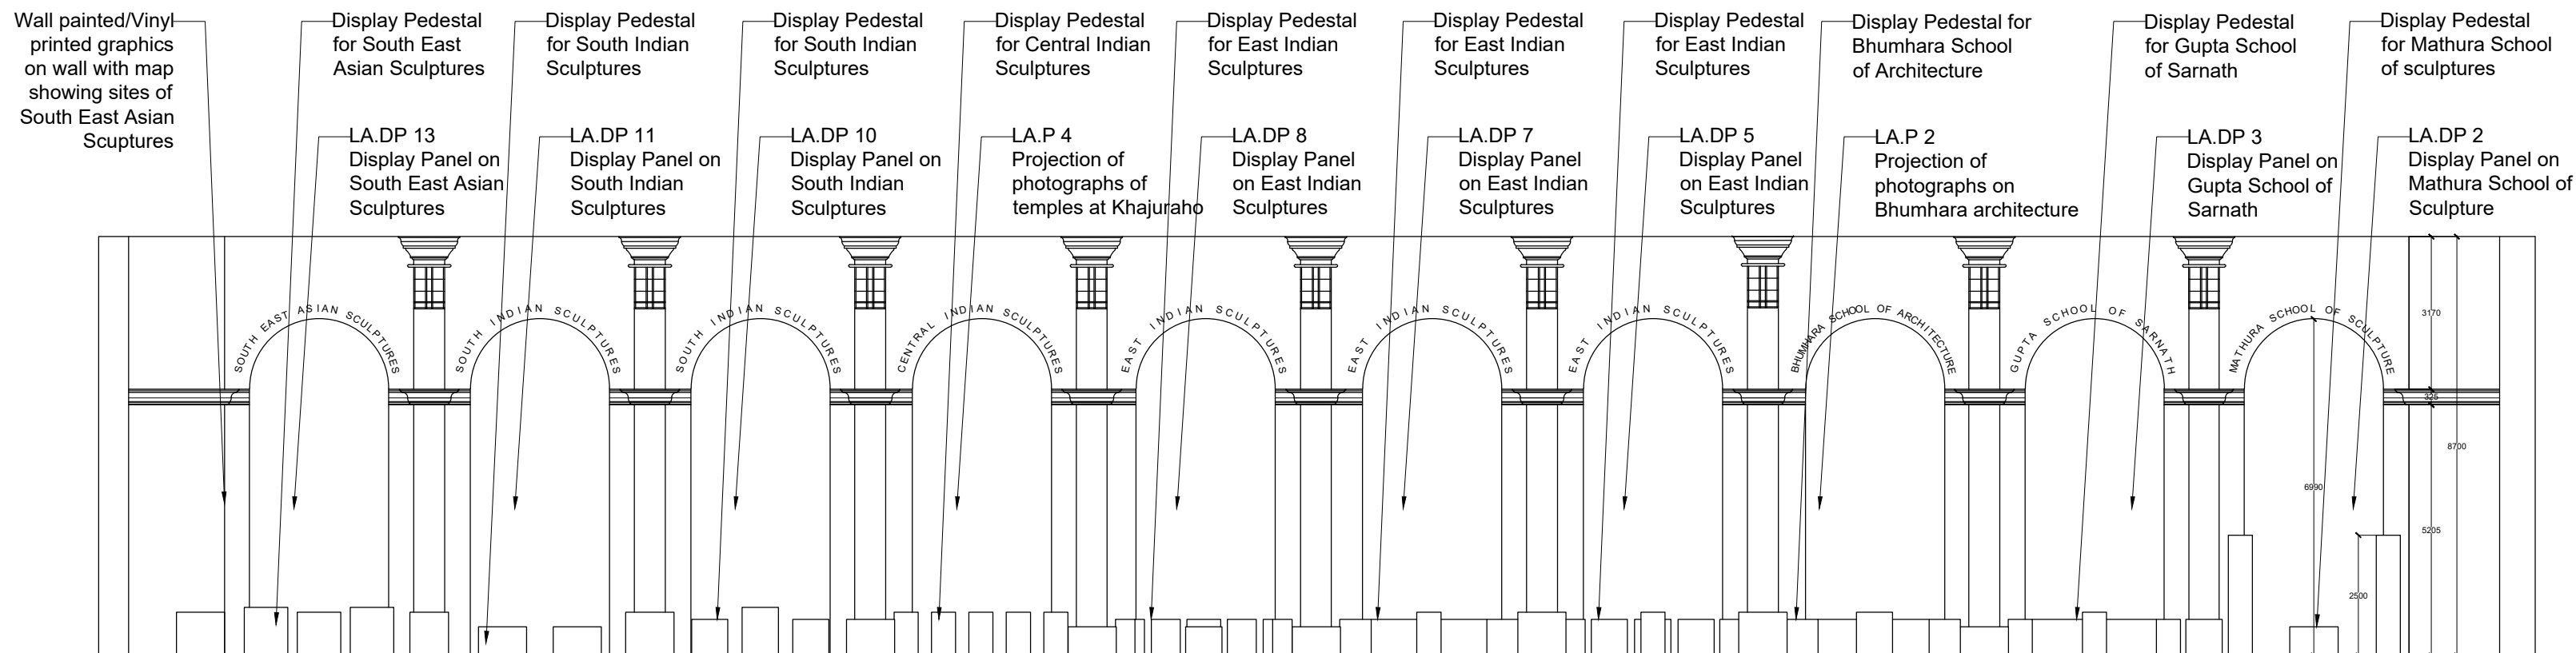

ELEVATION B

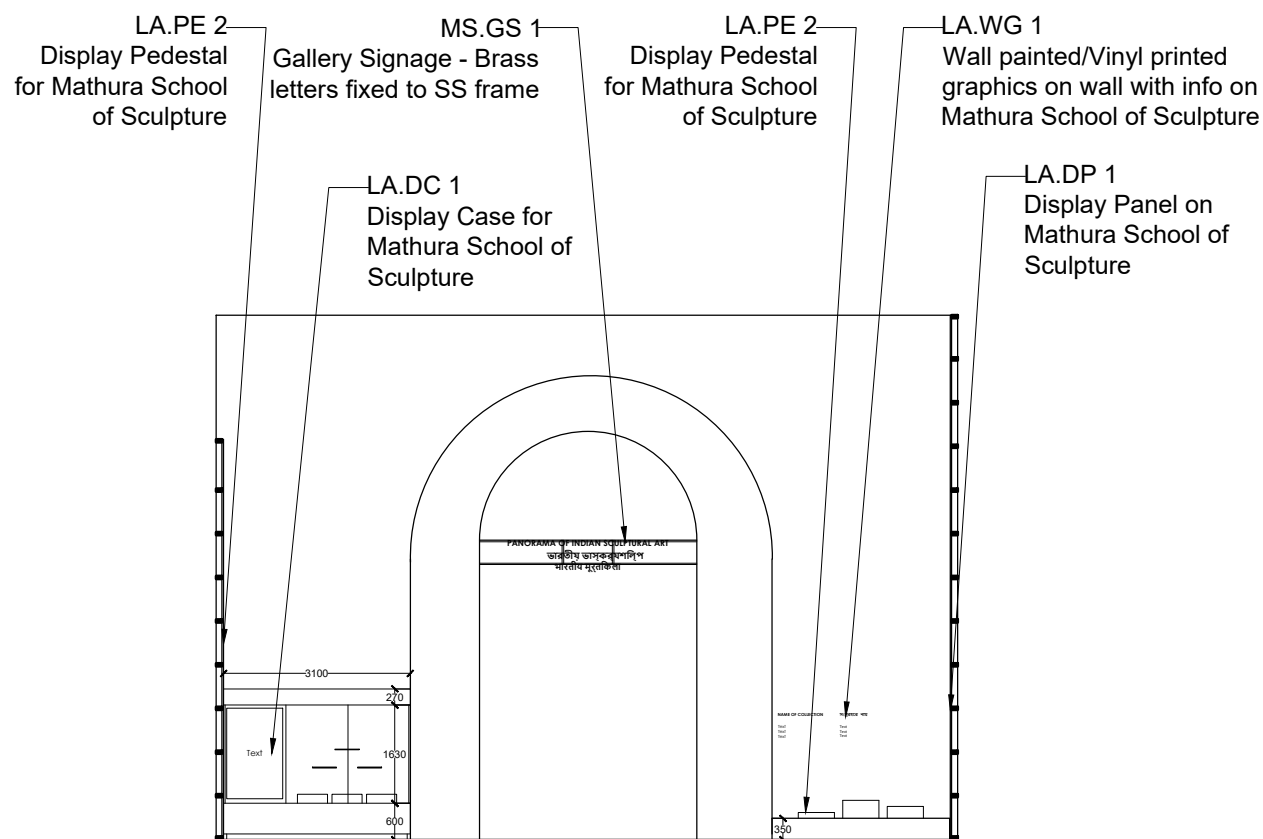


ELEVATION C

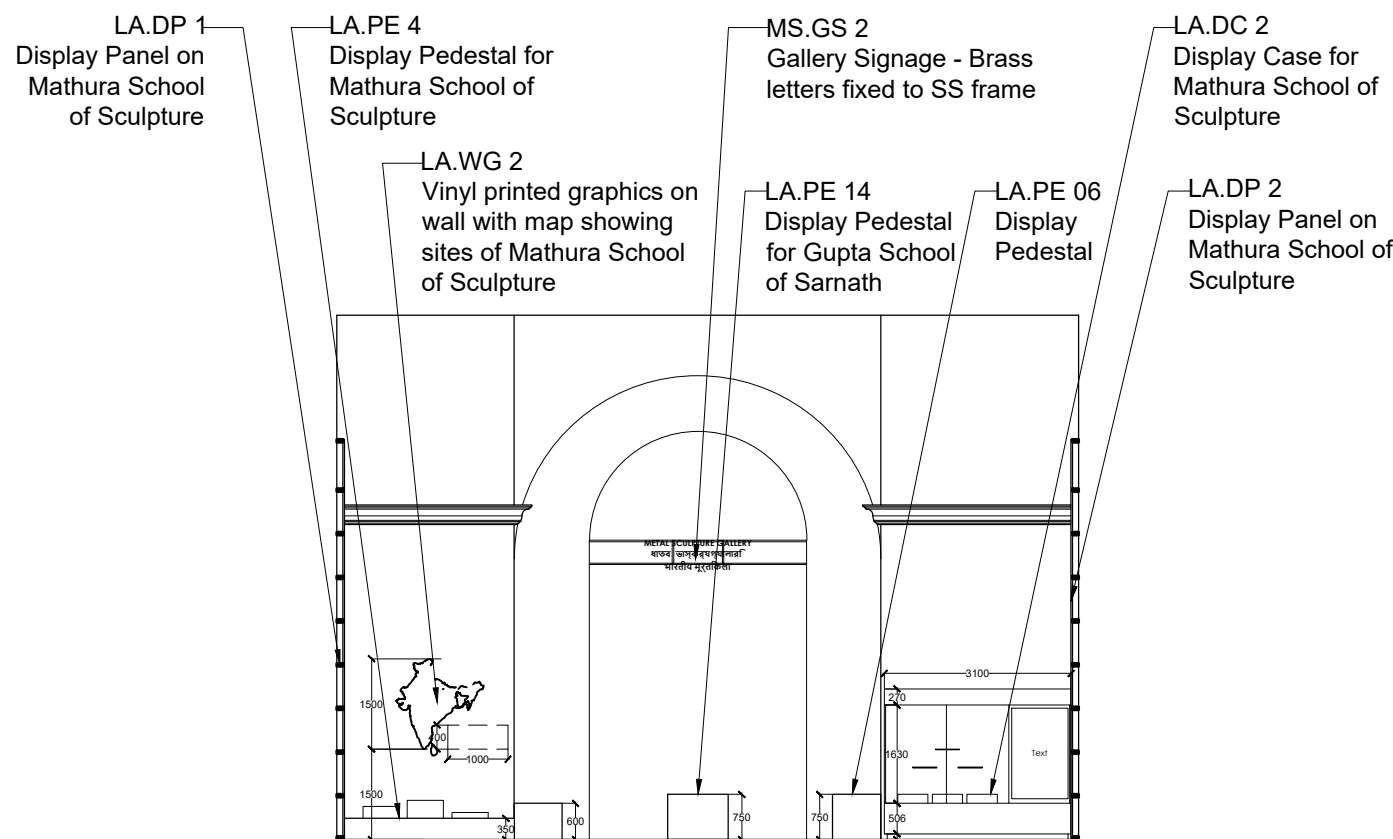


ELEVATION D




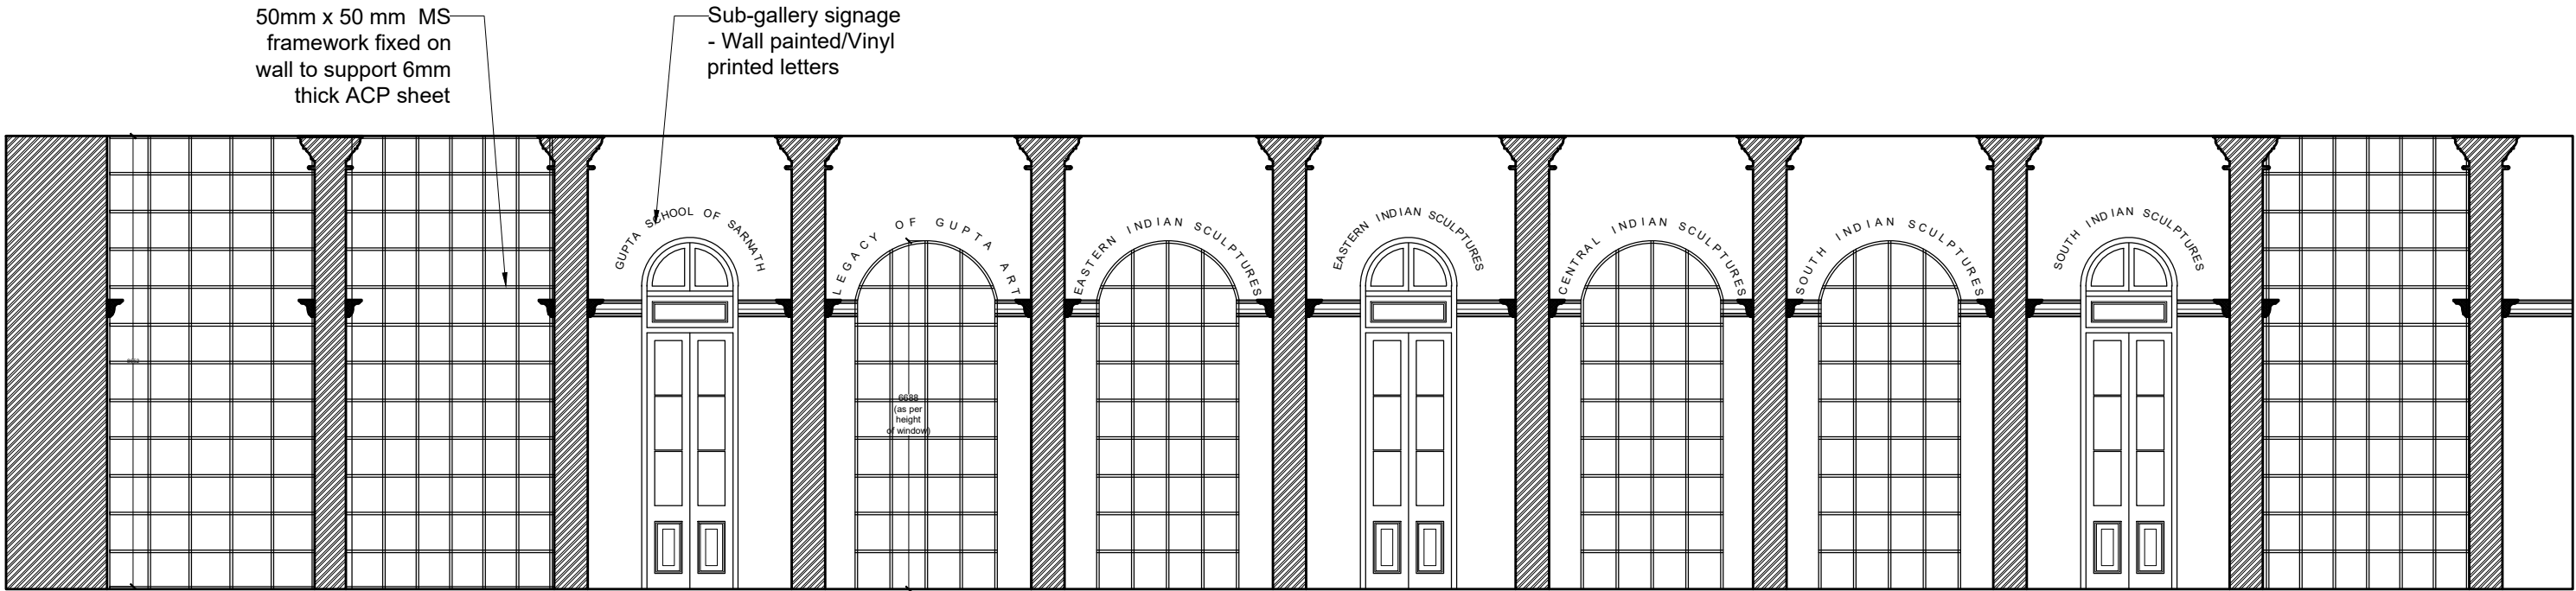

INTERNAL ELEVATION A

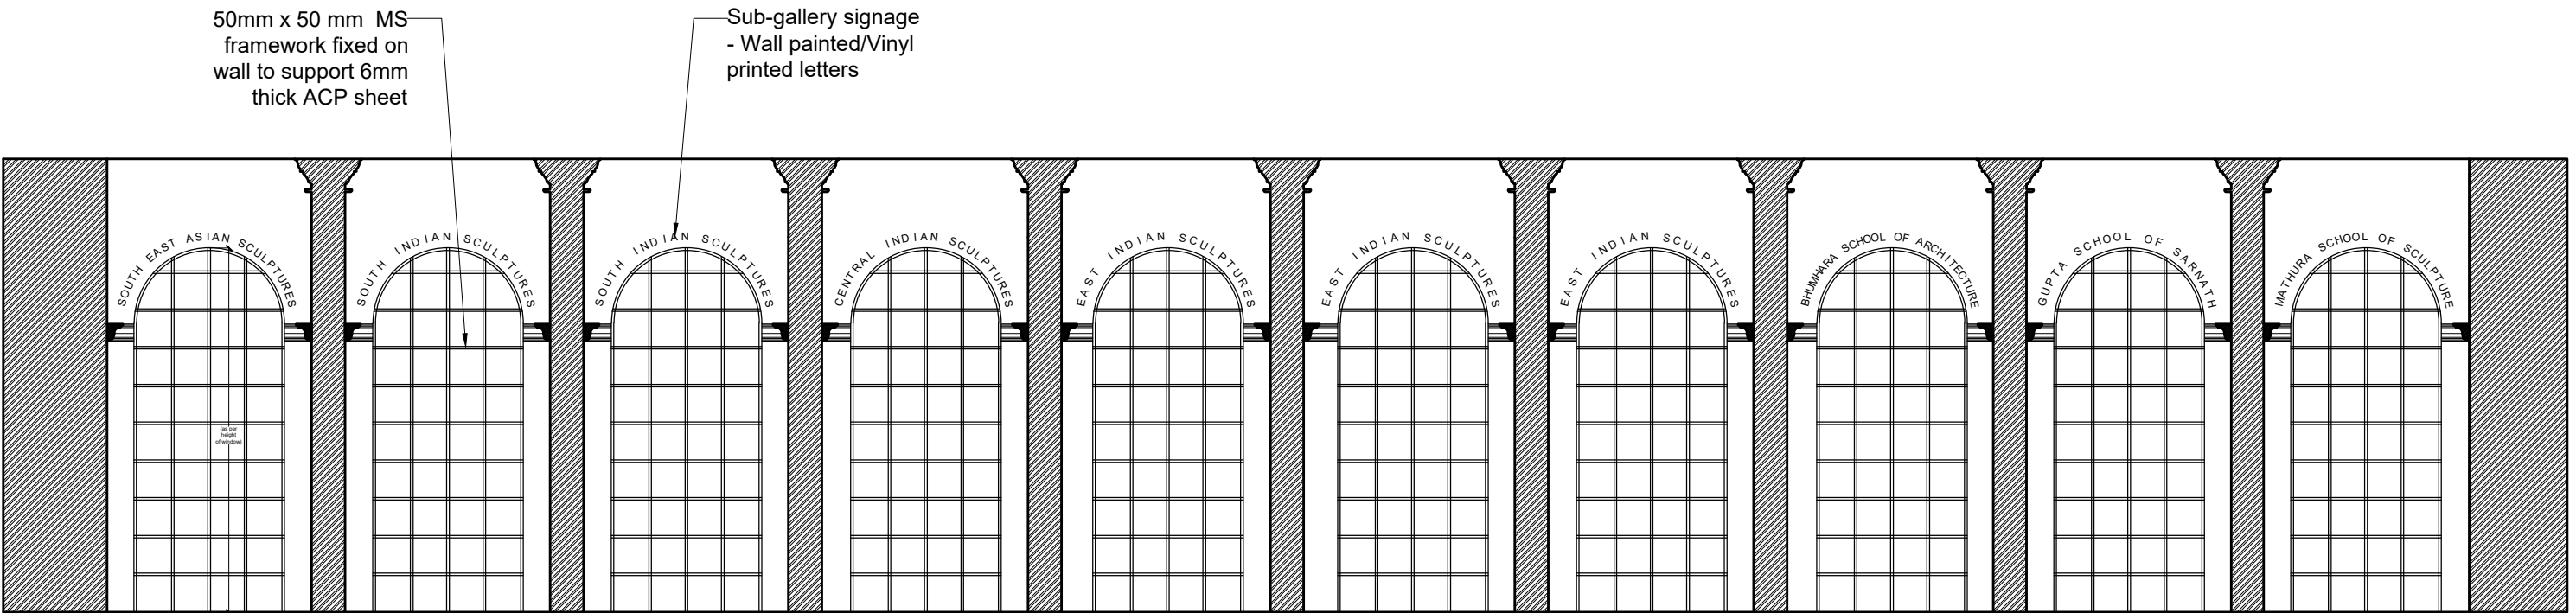

INTERNAL ELEVATION B

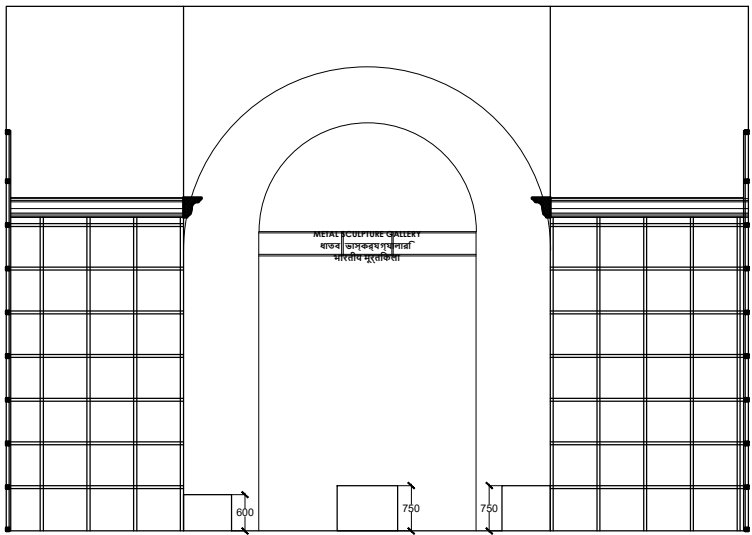


INTERIOR ELEVATION D

NOTES:

All dimensions are in millimeters

KEY PLAN

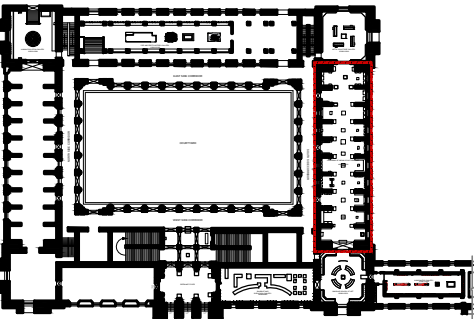

LEGEND

DP	Display Panel
DC	Display Case
DS	Display Shelf
PE	Pedestal
WM	Wall Mural
WG	Wall Graphics
CP	Canvas Painting
M	Model
MET	Mock Excavation Trench
CP	Canvas Painting
AV	Audio Visuals
I	Interactive
P	Projection
HP	Holographic Projection
GS	Gallery Signage
DS	Directional Signage
LG	Logo
RT	Reception Table
CC	Crowd Control Barrier

SCALE: 1:100

0 1m 2m



DRAWING NAME: LAYOUT

DRAWN BY: Sohini Pyne

CHECKED BY: Shikha Jain

DRAWING NUMBER: IMK/GF/PA/03

SERIES: Tender Drawings

PANORAMA OF INDIAN SCULPTURAL ART

PROJECT:

PLANNING, CONTENT DEVELOPMENT, DESIGNING, RETROFITTING AND CURATORIAL WORK FOR THE INDIAN MUSEUM, KOLKATA

CLIENT:

INDIAN MUSEUM, KOLKATA


CONSULTANT:

**DRONAH**  
DEVELOPMENT & RESEARCH  
ORGANISATION FOR NATURE,ARTS  
& HERITAGE






A-258, SOUTH CITY-1  
GURGAON-122001



LA. PE 2,4

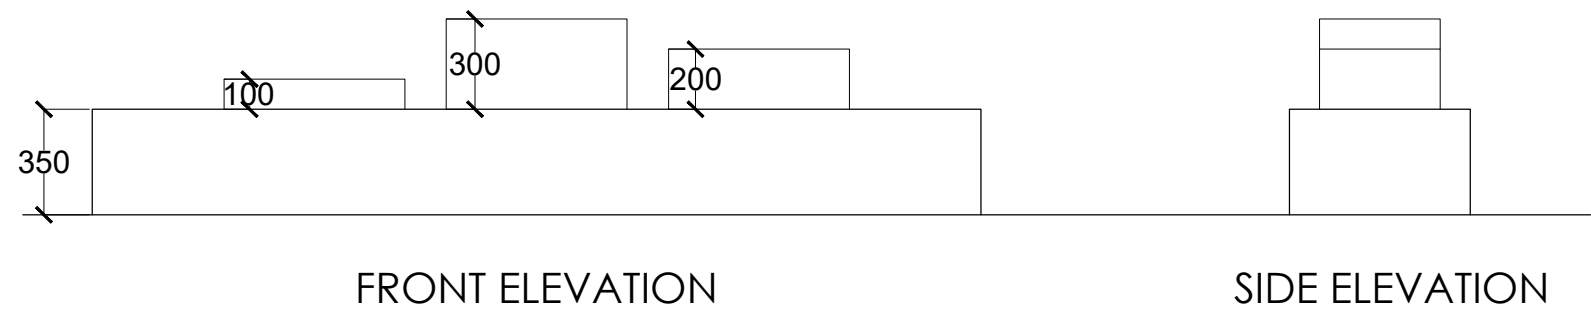


TYPICAL DISPLAY PEDESTAL FOR LA. PE 1 - 147

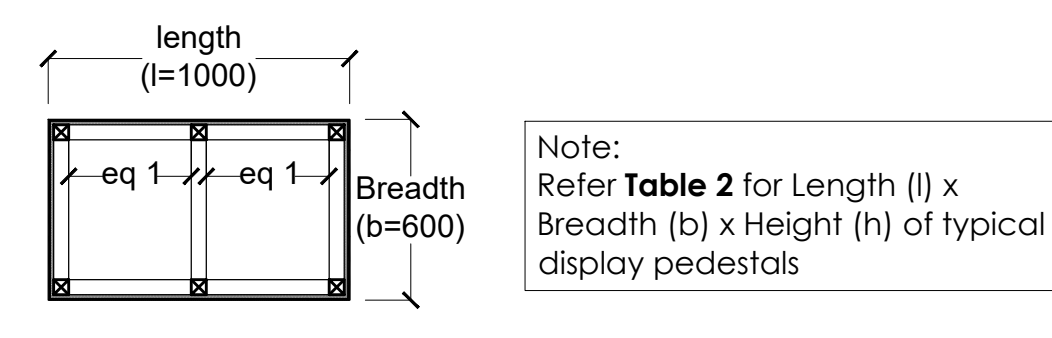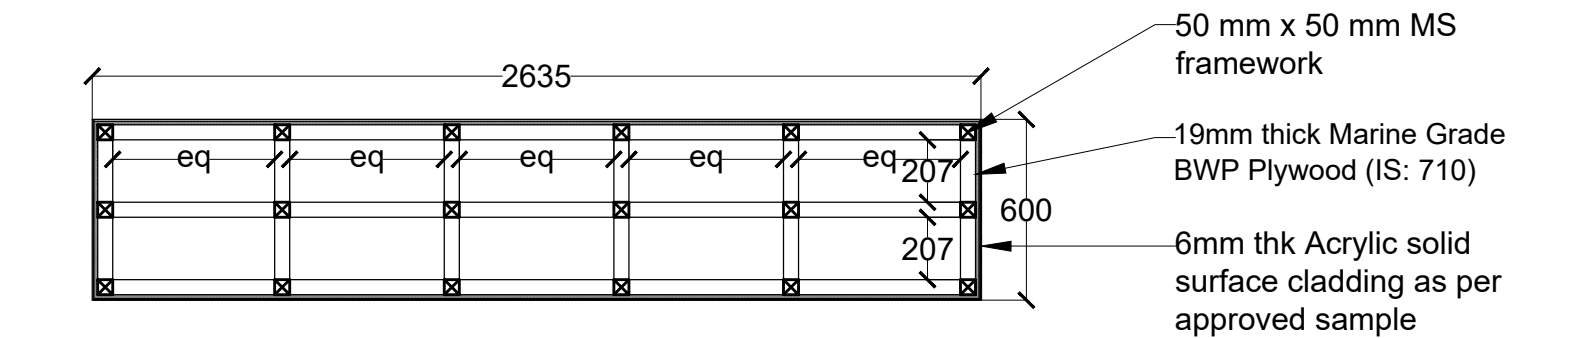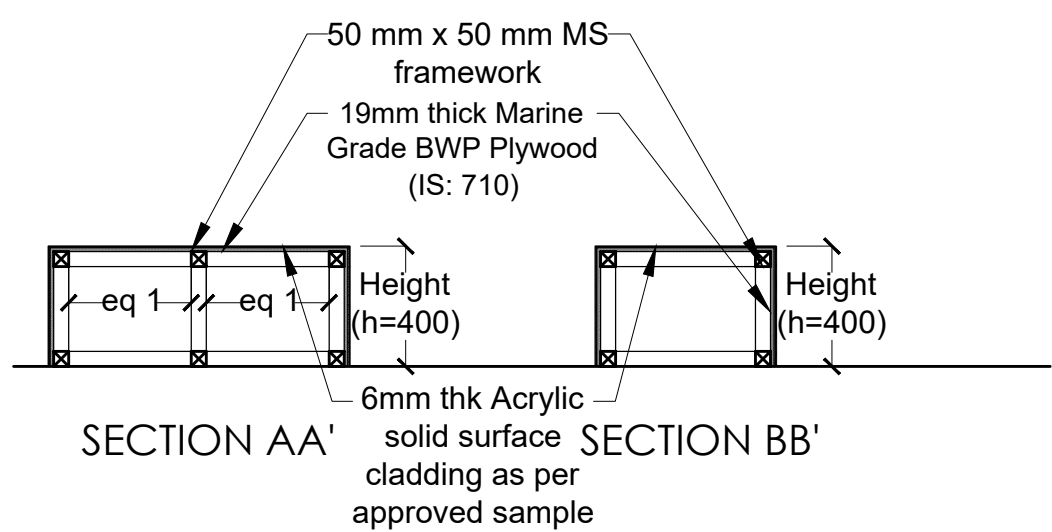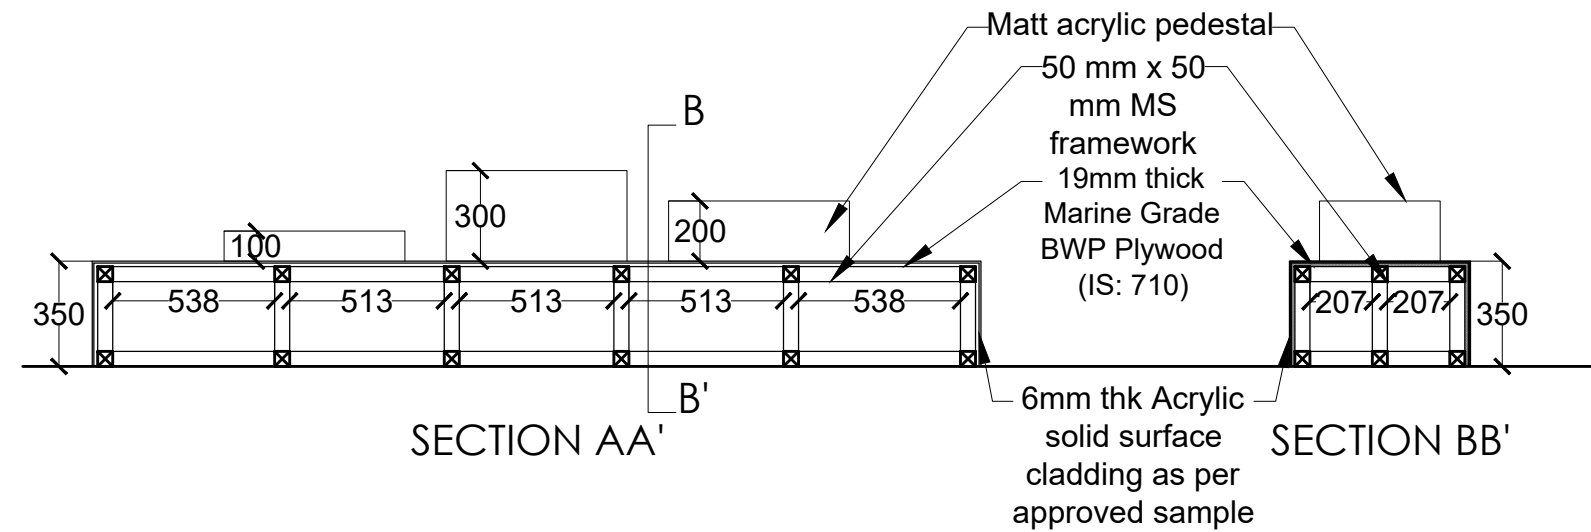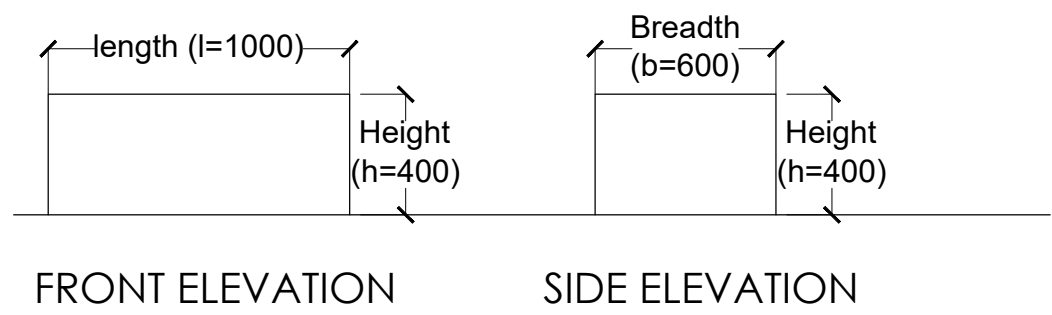

NOTES:

All dimensions are in millimeters

KEY PLAN

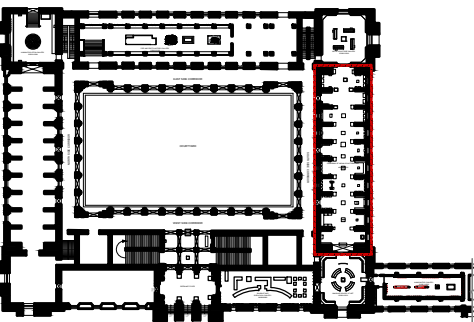

LEGEND

DP	Display Panel
DC	Display Case
DS	Display Shelf
PE	Pedestal
WM	Wall Mural
WG	Wall Graphics
CP	Canvas Painting
M	Model
MET	Mock Excavation Trench
CP	Canvas Painting
AV	Audio Visuals
I	Interactive
P	Projection
HP	Holographic Projection
GS	Gallery Signage
DS	Directional Signage
LG	Logo
RT	Reception Table
CC	Crowd Control Barrier

LEGEND																				
SR. NO.	NAME	SIZE OF PEDESTAL /CASE l x b x h	SR. NO.	NAME	SIZE OF PEDESTAL /CASE l x b x h	SR. NO.	NAME	SIZE OF PEDESTAL /CASE l x b x h	SR. NO.	NAME	SIZE OF PEDESTAL /CASE l x b x h	SR. NO.	NAME	SIZE OF PEDESTAL /CASE l x b x h	SR. NO.	NAME	SIZE OF PEDESTAL /CASE l x b x h			
MATHURA SCHOOL OF SCULPTURE			AMRAVATI SCHOOL OF SCULPTURE			LEGACY OF GUPTA ART			PE 63	Marichi	Refer drawing	PE 98	Male Brahmanical - Sadashiva	600x400x750	SOUTH INDIAN SCULPTURES		SOUTH EAST ASIAN SCULPTURES			
PE 1	Yakshi on a Panel	as existing	PE 8	Cross bar with Medallion	1000x750x750	PE 35	Door Jambis - Key Artefacts	as existing	PE 64	Vajjiswari		PE 99	Male Brahmanical -	600x400x750	PE 117	Vibhadra	750x500x900	PE 132	Lokeshwara (refer detail)	500x500x900
PE 2	Headless Parvati	2950x600x350	PE 9	Cross bar with Medallion	1000x750x750	PE 36	Gangavatar	500x500x900	PE 65	Tara		PE 100	Male Brahmanical - Varaha	750x450x600	PE 118	Holi	2000x500x1000	PE 133	Buddha	1000x750x1000
	Yakshi		PE 10	Coping Stone	3543x400x900	PE 37	Three Headed Brahma	500x500x900	PE 66	Tara		PE 101	Male Brahmanical - Ganesha	1000x800x600	PE 119	Brahma	750x500x900	PE 134	Seated Tara	1000x750x750
	Standing Buddha	1000x600x400	PE 11	Pillar Base	1000x750x750	PE 38	Bust of Door Attendant	500x500x900	PE 67	Tara		PE 102	Male Brahmanical - Vishnu with Garuda		PE 120	Saraswati	1000x600x750	PE 135	Buddha	1000x750x1000
PE 3	Seated Bodhisatva		PE 12	Ayaka Pillar	1000x750x750	PE 39	Standing Male	500x500x900	PE 68	Tara		CENTRAL INDIAN SCULPTURES		PE 121	Vishnu	750x600x750	PE 136	Prajna Paramita (refer detail)	500x500x900	
PE 4	Standing Shiv Parvati	2950x600x350	PE 13	Vase of Prosperity	1000x750x750	PE 40	Kiratanuja Scene	500x500x900	PE 69	Tara		PE 103	Vrishabha	600x400x1000	PE 122	Surya	750x600x1000	PE 137	Punchangan Inscription of King Airlangga	1200x800x600
	Lower Part of a Lady		PE 14	Standing Tara	1000x1000x750	GUPTA SCHOOL OF SARNATH			EAST INDIAN SCULPTURES			PE 70	Tara	PE 123	Vaishnavi	750x600x750	PE 138	Garuda	as existing	
	Offering protection	PE 15	Preaching Buddha	PE 41		Buddha protected by Muchilinda	750x750x900	PE 71	Ushnisha Vijaya	PE 105		Naga Couple	700x500x750	PE 124	Subrahmaniya	1000x750x900	PE 139	Brahma (refer detail)	500x500x900	
	Amorous Couple	PE 16	Buddha	PE 42		Buddha taming Nalgiri	1000x750x900	PE 72	Vasudhara	PE 106		Narasimhi	600x400x1000	PE 125	Cornor Pillar	as existing	PE 140	Vishnu (refer detail)	500x500x900	
PE 5	Ekmukhi Linga	750x500x350	PE 17	Preaching Buddha		PE 43	Buddha	600x400x750	PE 73	Votive Stupa	500x500x900	PE 107	Nagini	600x400x1000	PE 126	Shiva	as existing	PE 141	Ganesha	1000x600x1000
PE 6	Bacchanalian Scene and Couple	1000x750x750	PE 18	Buddha	PE 44	Buddha	600x400x900	PE 74	Female Brahmanical - Seated Devi	2575x500x750	PE 108	Uma Maheshwari	1000x750x1000	PE 127	Lintel with Venugopal	as existing	PE 142	Shiva	1000x600x900	
PE 7	Colossal Standing Bodhisatva	as existing	PE 19	Buddha Head	PE 45	Buddha	600x400x750	PE 75	Female Brahmanical - Parvati		PE 109	Varha	1000x750x1000	PE 128	Carved Corner Pillar	as existing	PE 143	Ganesha	1000x600x1000	
DC 1	Female bust	3100x500x2500	PE 20	Tara	PE 46	Buddha	600x400x750	PE 76	Female Brahmanical - Seated Devi		PE 110	Darpanika	1000x750x1000	PE 129	Space for additional sculpture	1000x750x600	PE 144	Mahishasurmardini	500x500x900	
	Jina Head		PE 21	Miracles of Saraswati	PE 47	Buddha	600x400x750	PE 77	Sadyajato		PE 111	Shailitavasana	500x500x900	PE 130	Surya	1000x750x600	PE 145	Bull	750x600x1000	
	Maitreya	3100x500x2500	PE 22	Preaching Buddha	PE 48	Seated Buddha	600x400x750	PE 78	Female Brahmanical - Seated Devi with Child	PE 112	Sardulavya	500x500x900	PE 131	Devi and Dancing Shiva	as existing	PE 146	Chaturmukha Linga	600x600x1000		
	Seated Bodhisatva		PE 23	Ganesh and Kartik	500x500x900	PE 49	Buddha	600x400x750	PE 79	Female Brahmanical - Chamunda	PE 113	Patralekha	500x500x900				PE 147	Inscription of Budhagupta (Refer detail)	600x400x900	
	Head of Bodhisatva	3100x500x2500	PE 24	Buddha offering protection	1000x750x600	PE 50	Buddha	600x400x750	PE 80	Couple - Uma Linga Maheshwari	PE 114	Sardulavya	500x500x900							
	Head of Buddha		PE 25	Buddha	750x500x900	PE 51	Crowned Buddha (refer drawing)	500x500x900	PE 81	Couple - Naga Couple	PE 115	Mother with Child	500x500x900							
	Bust of Yakshi	3100x500x2500	PE 26	Avalokiteshwar	750x500x900	PE 52	Buddha taming Nalgiri	1000x750x900	PE 82	Couple - Uma Maheshwar	PE 116	Sarvamangala	1000x750x750							
DC 2	Standing Male		PE 27	Avakiteshwar	1000x750x900	PE 53	Avakiteshwar	1000x750x600	DS 1	Lintel	2072 x 300									
	Vaishravana	PE 28	Crowned Buddha	750x500x900	PE 54	Vajrapani	600x400x900	DS 2	Navagraha Panel (15mm thk glass)											
	Conch blower	3100x500x2500	PE 29	Life Scenes of Buddha	750x500x900	PE 55	Avakiteshwara (refer drawing)	600x400x900	PE 83	Female Brahmanical - Ashtabhuja Devi	1000x750x600									
	Serpent King		PE 30	Life Scenes of Buddha	750x500x900	PE 56	Manjusree	600x400x750	PE 84	Female Brahmanical - Mahishasurmardini	1000x750x600									
	Naga	3100x500x2500	PE 31	Life Scenes of Buddha	750x500x900	PE 57	Padmapani Avalokiteshwar	600x400x750	PE 85	Jain Images - Parassvanath	1000x750x600									
	Surya		PE 32	Four Planets	1000x750x900	PE 58	Mahapari Nirvana	600x400x900	PE 86	Jain Images - Risabhnath										
	Surya	3100x500x2500	BHUMHARA ARCHITECTURE			PE 59	Vajardham Lokeshwara (refer dwg)	600x400x900	PE 87	Jain Images - Santinath	1200x1200x500									
	Hariti and Panchika		PE 33	Male Torso	1000x750x750	PE 60	Maitreya	600x400x900	PE 88	Jain Images - Chandraprabha										
		3100x500x2500	PE 34	Ganesha	500x500x600	PE 61	Seated Avalokiteshwar	1000x1000x750	PE 89	Jain Images - Mahavira										
			PE 35	3 Door Jambis, 8 Carved Dadas and 2 Clothes	Refer drawing	PE 62	Avalokiteshwar													

SCALE: 1:25

0 1m 2m



DRAWING NAME: LAYOUT

PANORAMA OF INDIAN SCULPTURAL ART

DRAWN BY: Sohini Pyne

CHECKED BY: Shikha Jain

DRAWING NUMBER: IMK/GF/PA/04

SERIES: Tender Drawings

PROJECT:

PLANNING, CONTENT DEVELOPMENT, DESIGNING, RETROFITTING AND CURATORIAL WORK FOR THE INDIAN MUSEUM, KOLKATA

CLIENT:


INDIAN MUSEUM, KOLKATA

CONSULTANT:


DRONAH DEVELOPMENT & RESEARCH ORGANISATION FOR NATURE,ARTS & HERITAGE

A-258, SOUTH CITY-1 GURGAON-122001



LA. PE 51, 132, 136, 139, 140, 144

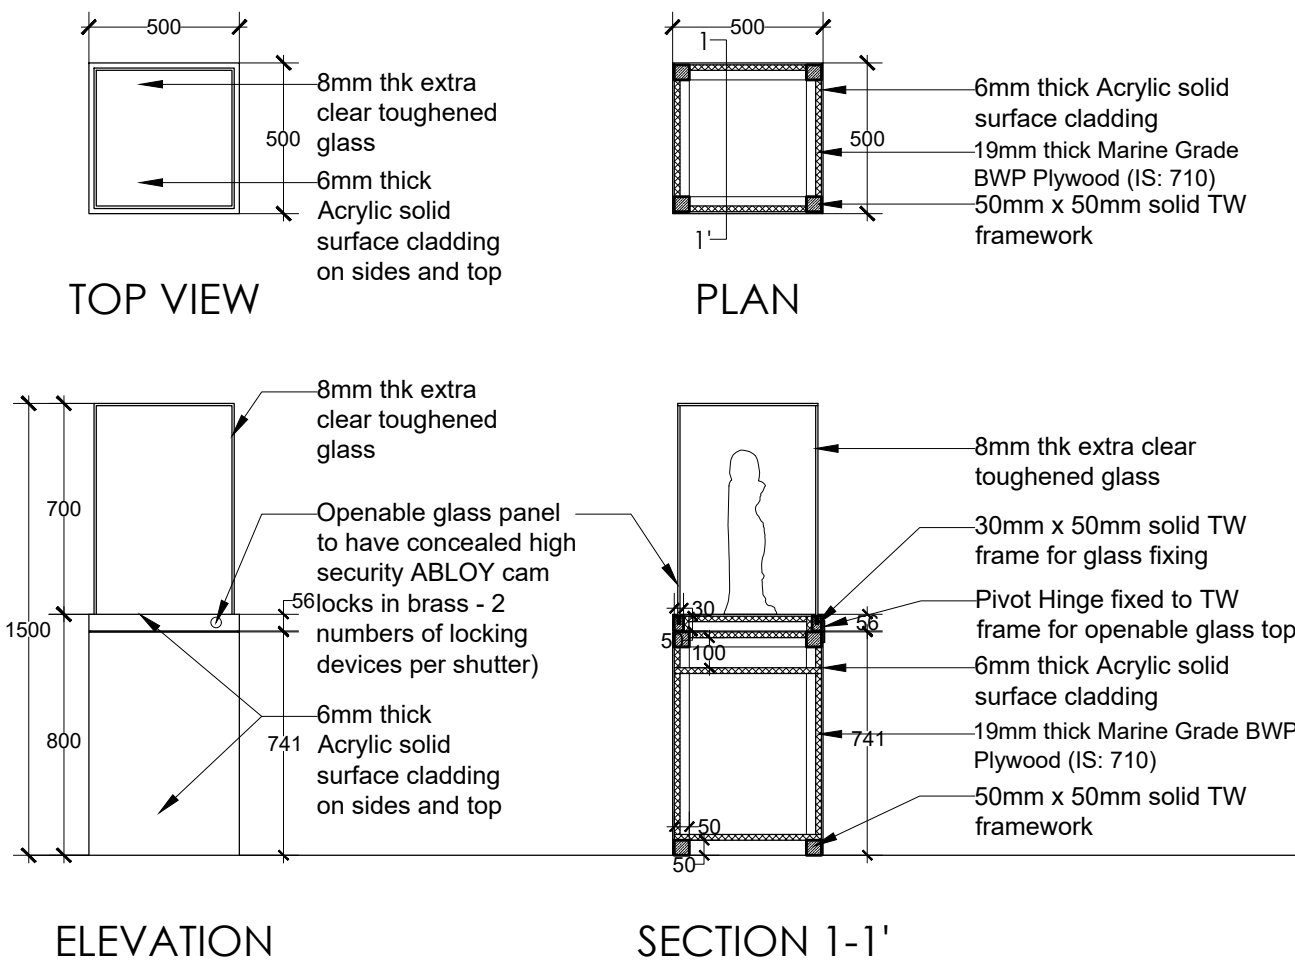

LA. PE 55, 59, 147

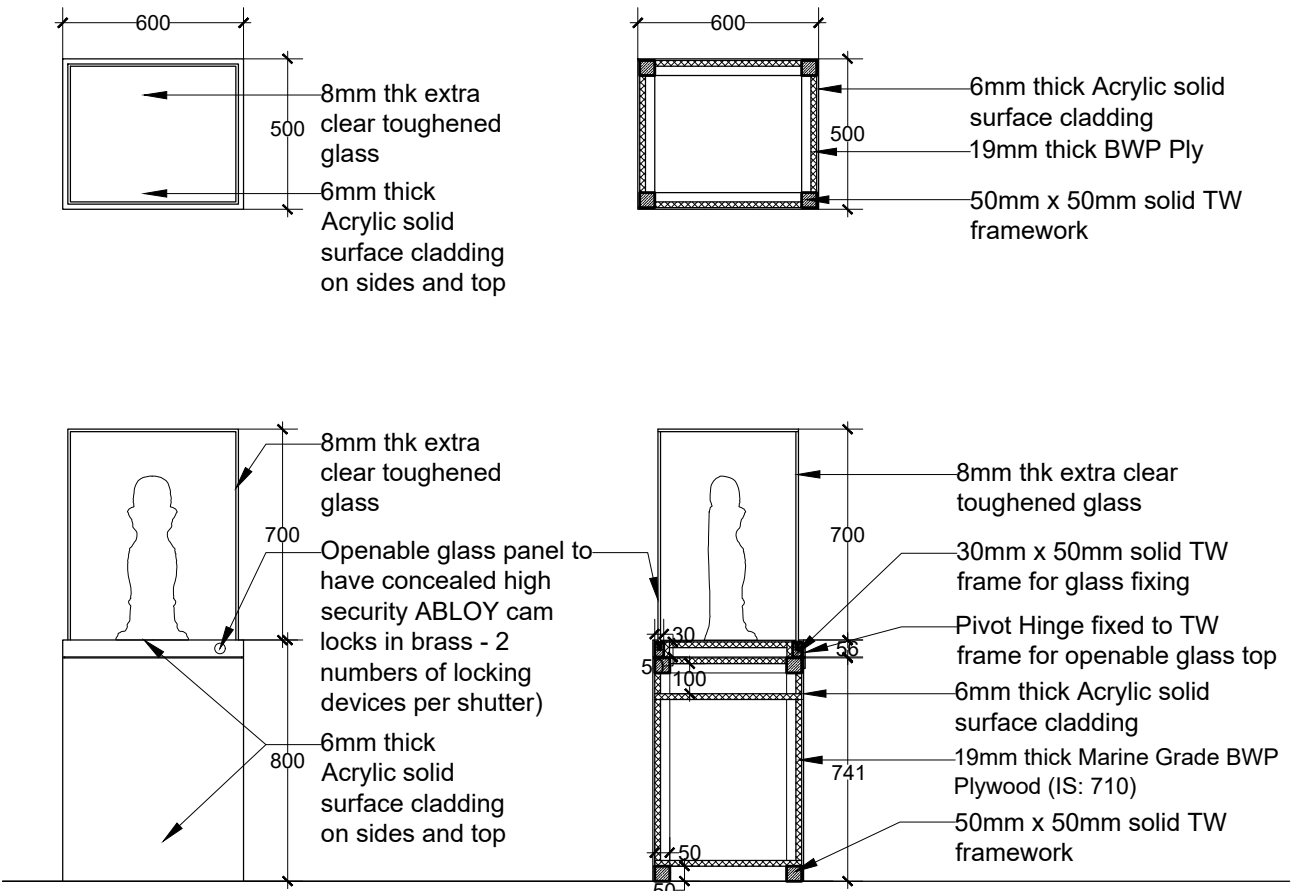


LA. DC 1-2

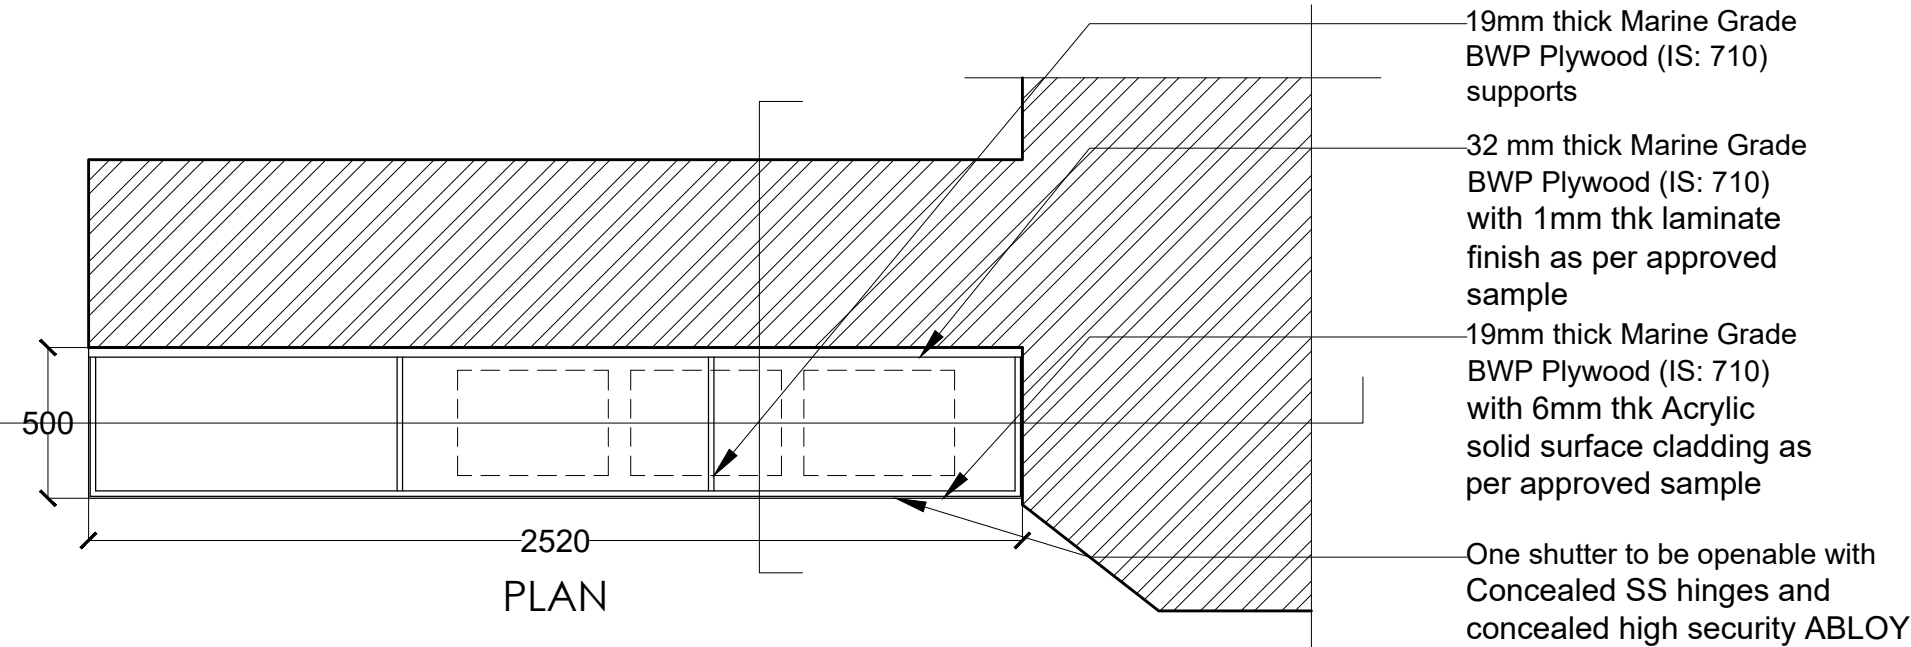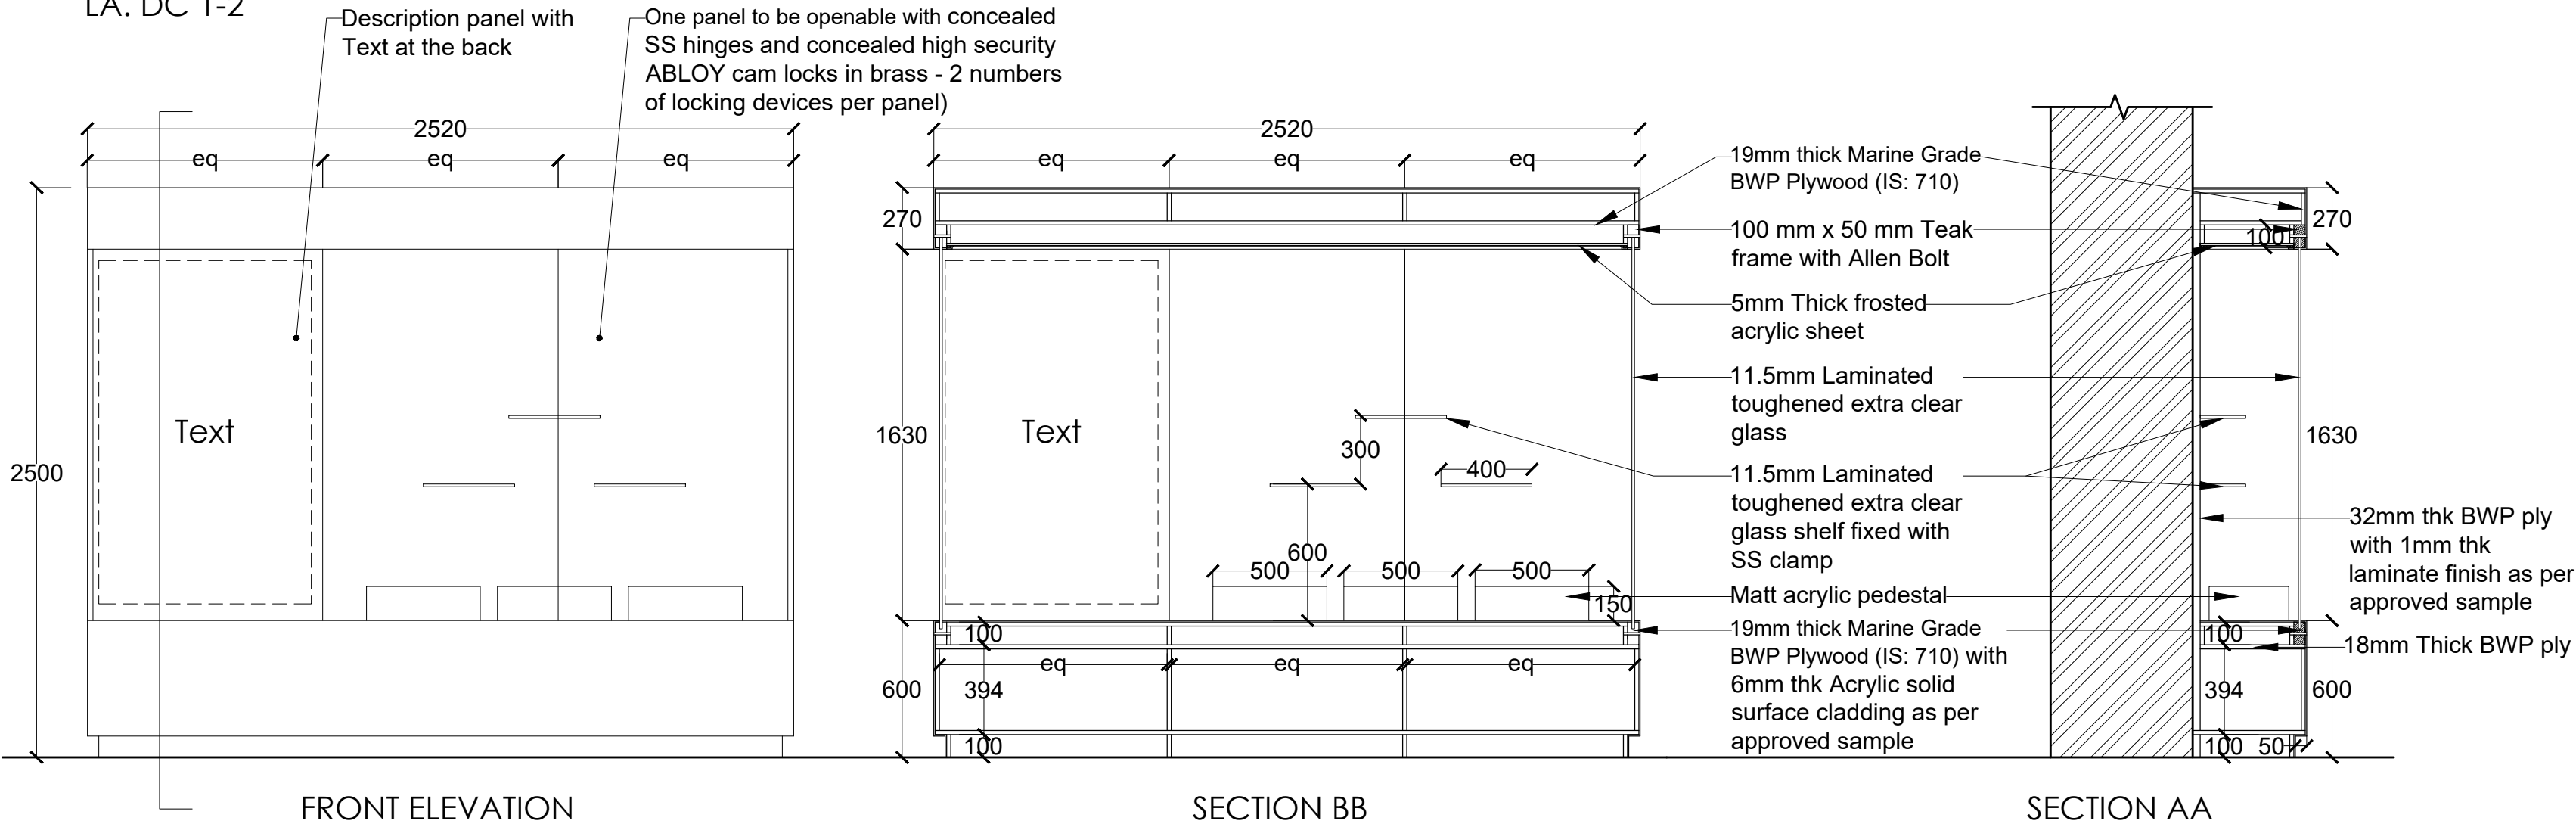

NOTES:

All dimensions are in millimeters

KEY PLAN

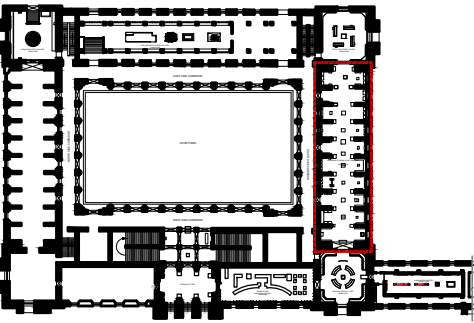

LEGEND

DP	Display Panel
DC	Display Case
DS	Display Shelf
PE	Pedestal
WM	Wall Mural
WG	Wall Graphics
CP	Canvas Painting
M	Model
MET	Mock Excavation Trench
CP	Canvas Painting
AV	Audio Visuals
I	Interactive
P	Projection
HP	Holographic Projection
GS	Gallery Signage
DS	Directional Signage
LG	Logo
RT	Reception Table
CC	Crowd Control Barrier

SCALE: 1:25

0 1m 2m



DRAWING NAME: LAYOUT

PANORAMA OF INDIAN SCULPTURAL ART

DRAWN BY: Sohini Pyne

CHECKED BY: Shikha Jain

DRAWING NUMBER: IMK/GF/PA/05

SERIES: Tender Drawings

PROJECT:

PLANNING, CONTENT DEVELOPMENT, DESIGNING, RETROFITTING AND CURATORIAL WORK FOR THE INDIAN MUSEUM, KOLKATA

CLIENT:

INDIAN MUSEUM, KOLKATA


CONSULTANT:

DRONAH DEVELOPMENT & RESEARCH ORGANISATION FOR NATURE,ARTS & HERITAGE


A-258, SOUTH CITY-1 GURGAON-122001




LA. PE 16-22 , LA. PE 34, LA. PE 63-72

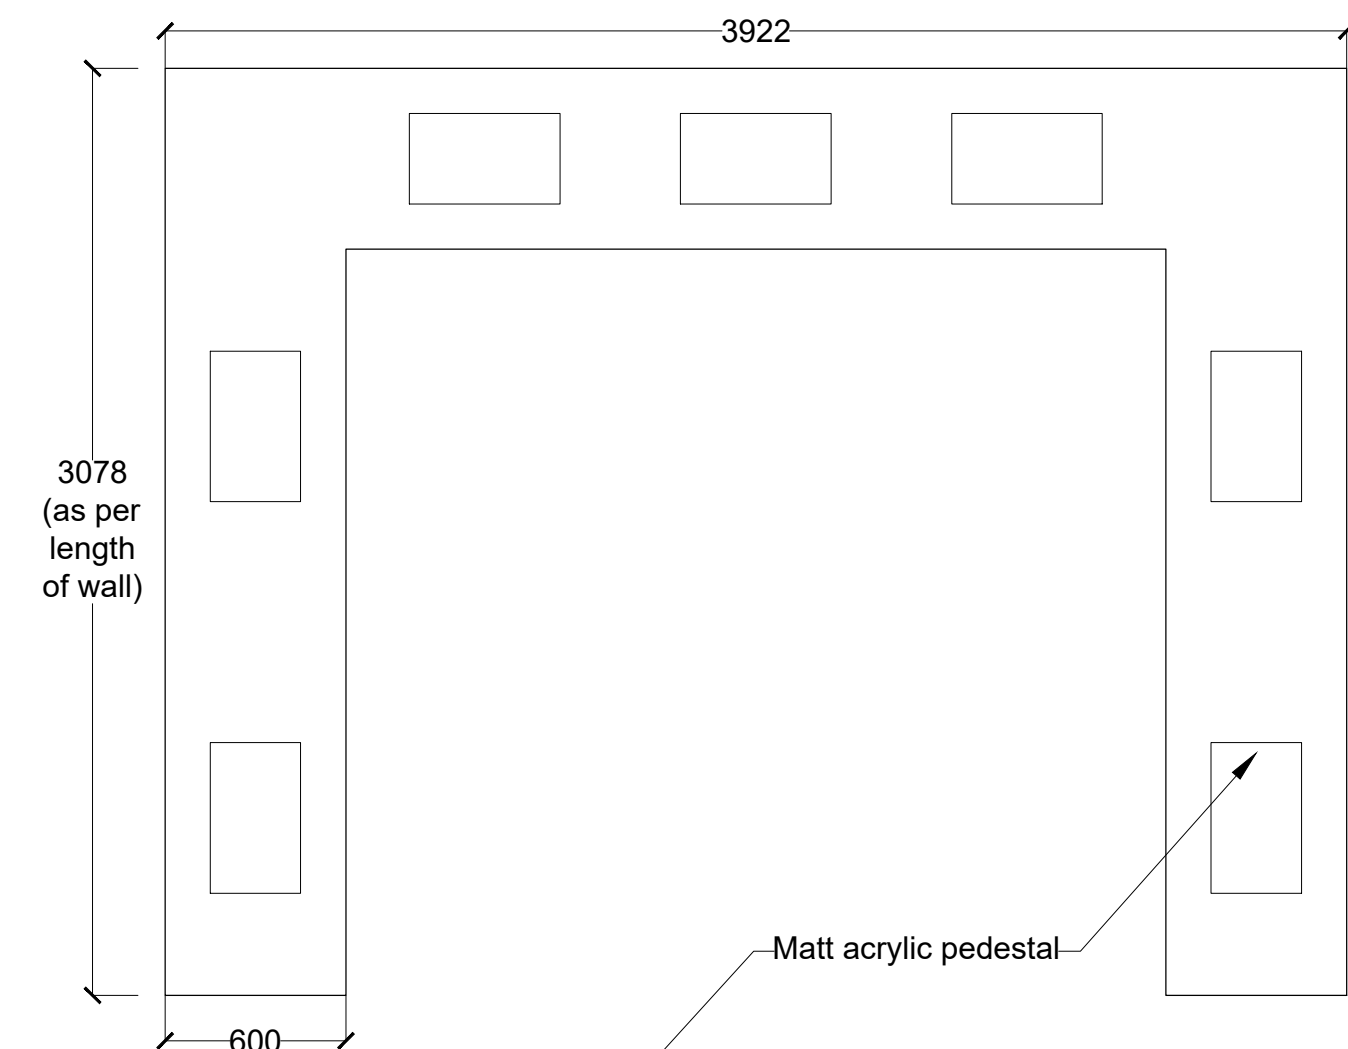


TOP VIEW

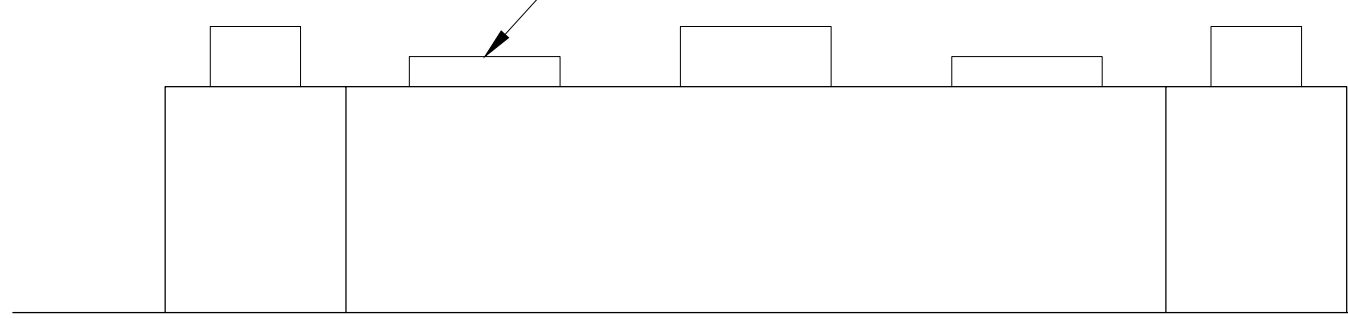

ELEVATION

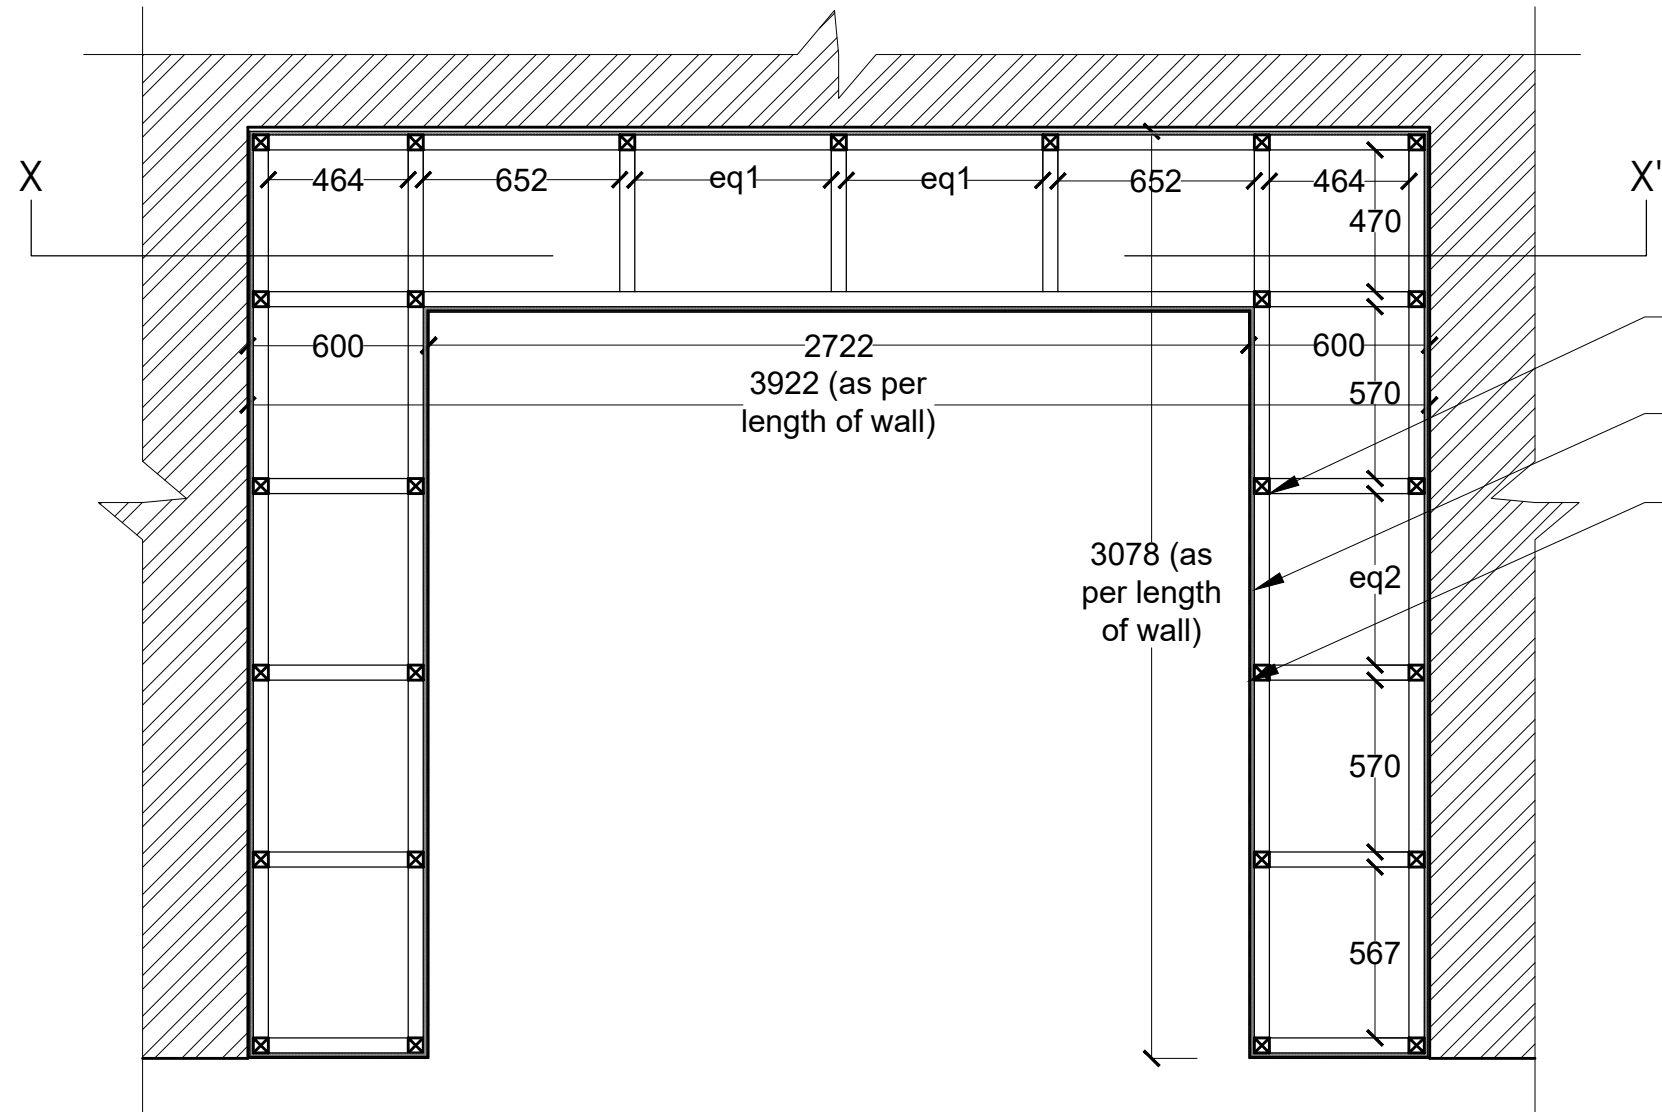

PLAN

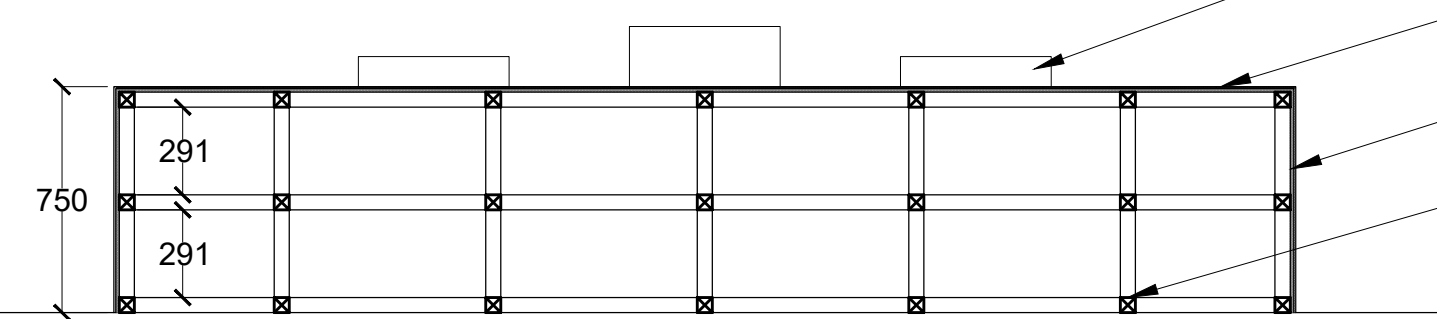


SECTION XX'


- 50 mm x 50 mm MS framework
- 19mm thick Marine Grade BWP Plywood (IS: 710)
- 6mm thk Acrylic solid surface cladding

- Matt acrylic pedestal
- 6mm thk Acrylic solid surface cladding
- 19mm thick Marine Grade BWP Plywood (IS: 710)
- 50 mm x 50 mm MS framework

LA. CM 1

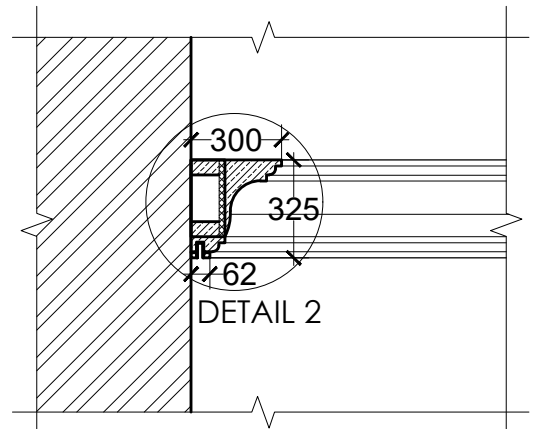

DETAIL 1

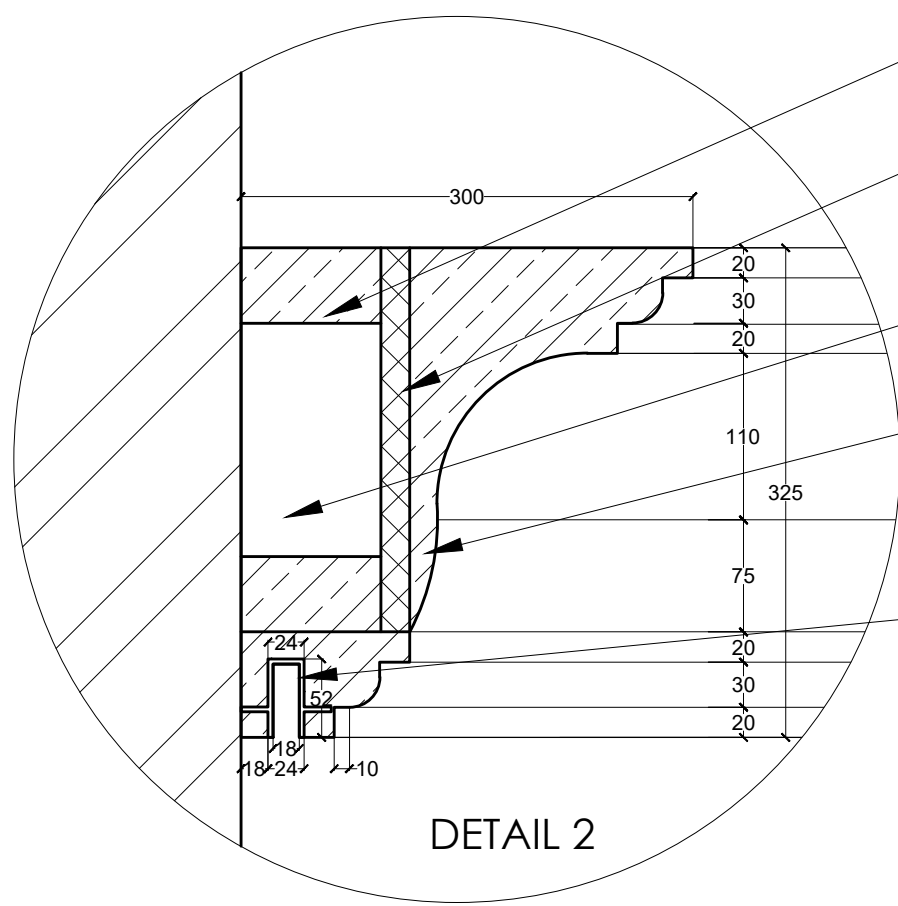


DETAIL 2


- 50mm x 90mm thk TW frame
- 19mm thick Marine Grade BWP Plywood (IS: 710)
- Hollow Space for Electrical Conduiting
- Ornamental cornice in solid Wood finished with Melamine polish.
- 52 mm x 24mm Cove for recessed electromechanical track for lighting

SCALE 1:5

LA. AV 1,2

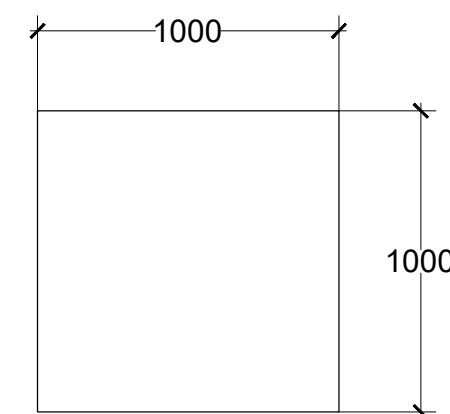

TOP VIEW

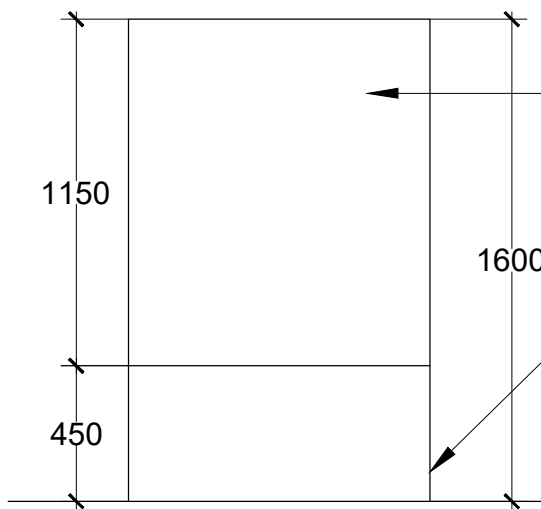


ELEVATION

- Custom 4-sided LED display. Screen size 1000 mm x 1300 mm with minimum pixel pitch of 6mm and seamless 90 deg edges
- Pedestal with 19mm thick Marine Grade BWP Plywood (IS: 710) with 6mm thk Acrylic solid surface cladding as per approved sample

NOTES:

All dimensions are in millimeters

KEY PLAN

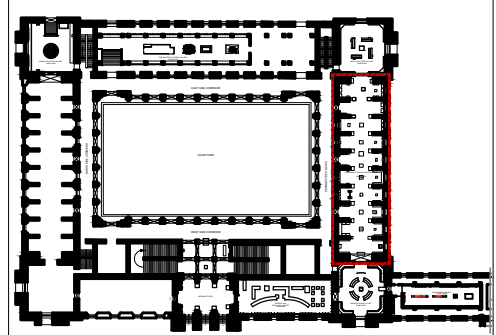

LEGEND

DP	Display Panel
DC	Display Case
DS	Display Shelf
PE	Pedestal
WM	Wall Mural
WG	Wall Graphics
CP	Canvas Painting
M	Model
MET	Mock Excavation Trench
CP	Canvas Painting
AV	Audio Visuals
I	Interactive
P	Projection
HP	Holographic Projection
GS	Gallery Signage
DS	Directional Signage
LG	Logo
RT	Reception Table
CC	Crowd Control Barrier

SCALE: 1:25

0 1m 2m



DRAWING NAME: LAYOUT

PANORAMA OF INDIAN SCULPTURAL ART

DRAWN BY: Sohini Pyne

CHECKED BY: Shikha Jain

DRAWING NUMBER: IMK/GF/PA/06

SERIES: Tender Drawings

PROJECT:

PLANNING, CONTENT DEVELOPMENT, DESIGNING, RETROFITTING AND CURATORIAL WORK FOR THE INDIAN MUSEUM, KOLKATA

CLIENT:

INDIAN MUSEUM, KOLKATA

CONSULTANT:


DRONAH DEVELOPMENT & RESEARCH ORGANISATION FOR NATURE,ARTS & HERITAGE

A-258, SOUTH CITY-1 GURGAON-122001

NOTES:

All dimensions are in millimeters

KEY PLAN

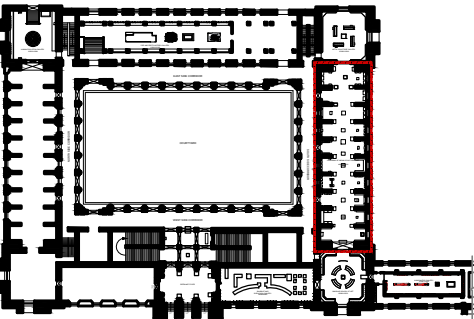

SCALE: 1:125

0 1m 2m



DRAWING : LIGHTING LAYOUT

PANORAMA OF INDIAN SCULPTURAL ART

DRAWN BY: Sohini Pyne

CHECKED BY: Shikha Jain

DRAWING NUMBER: IMK/GF/PA/07

SERIES: Tender Drawings

PROJECT:

PLANNING, CONTENT  
DEVELOPMENT, DESIGNING,  
RETROFITTING AND CURATORIAL  
WORK FOR THE INDIAN MUSEUM,  
KOLKATA


CLIENT:

INDIAN MUSEUM, KOLKATA

CONSULTANT:

**DRONAH**  
DEVELOPMENT & RESEARCH  
ORGANISATION FOR NATURE,ARTS  
& HERITAGE


A-258, SOUTH CITY-1  
GURGAON-122001

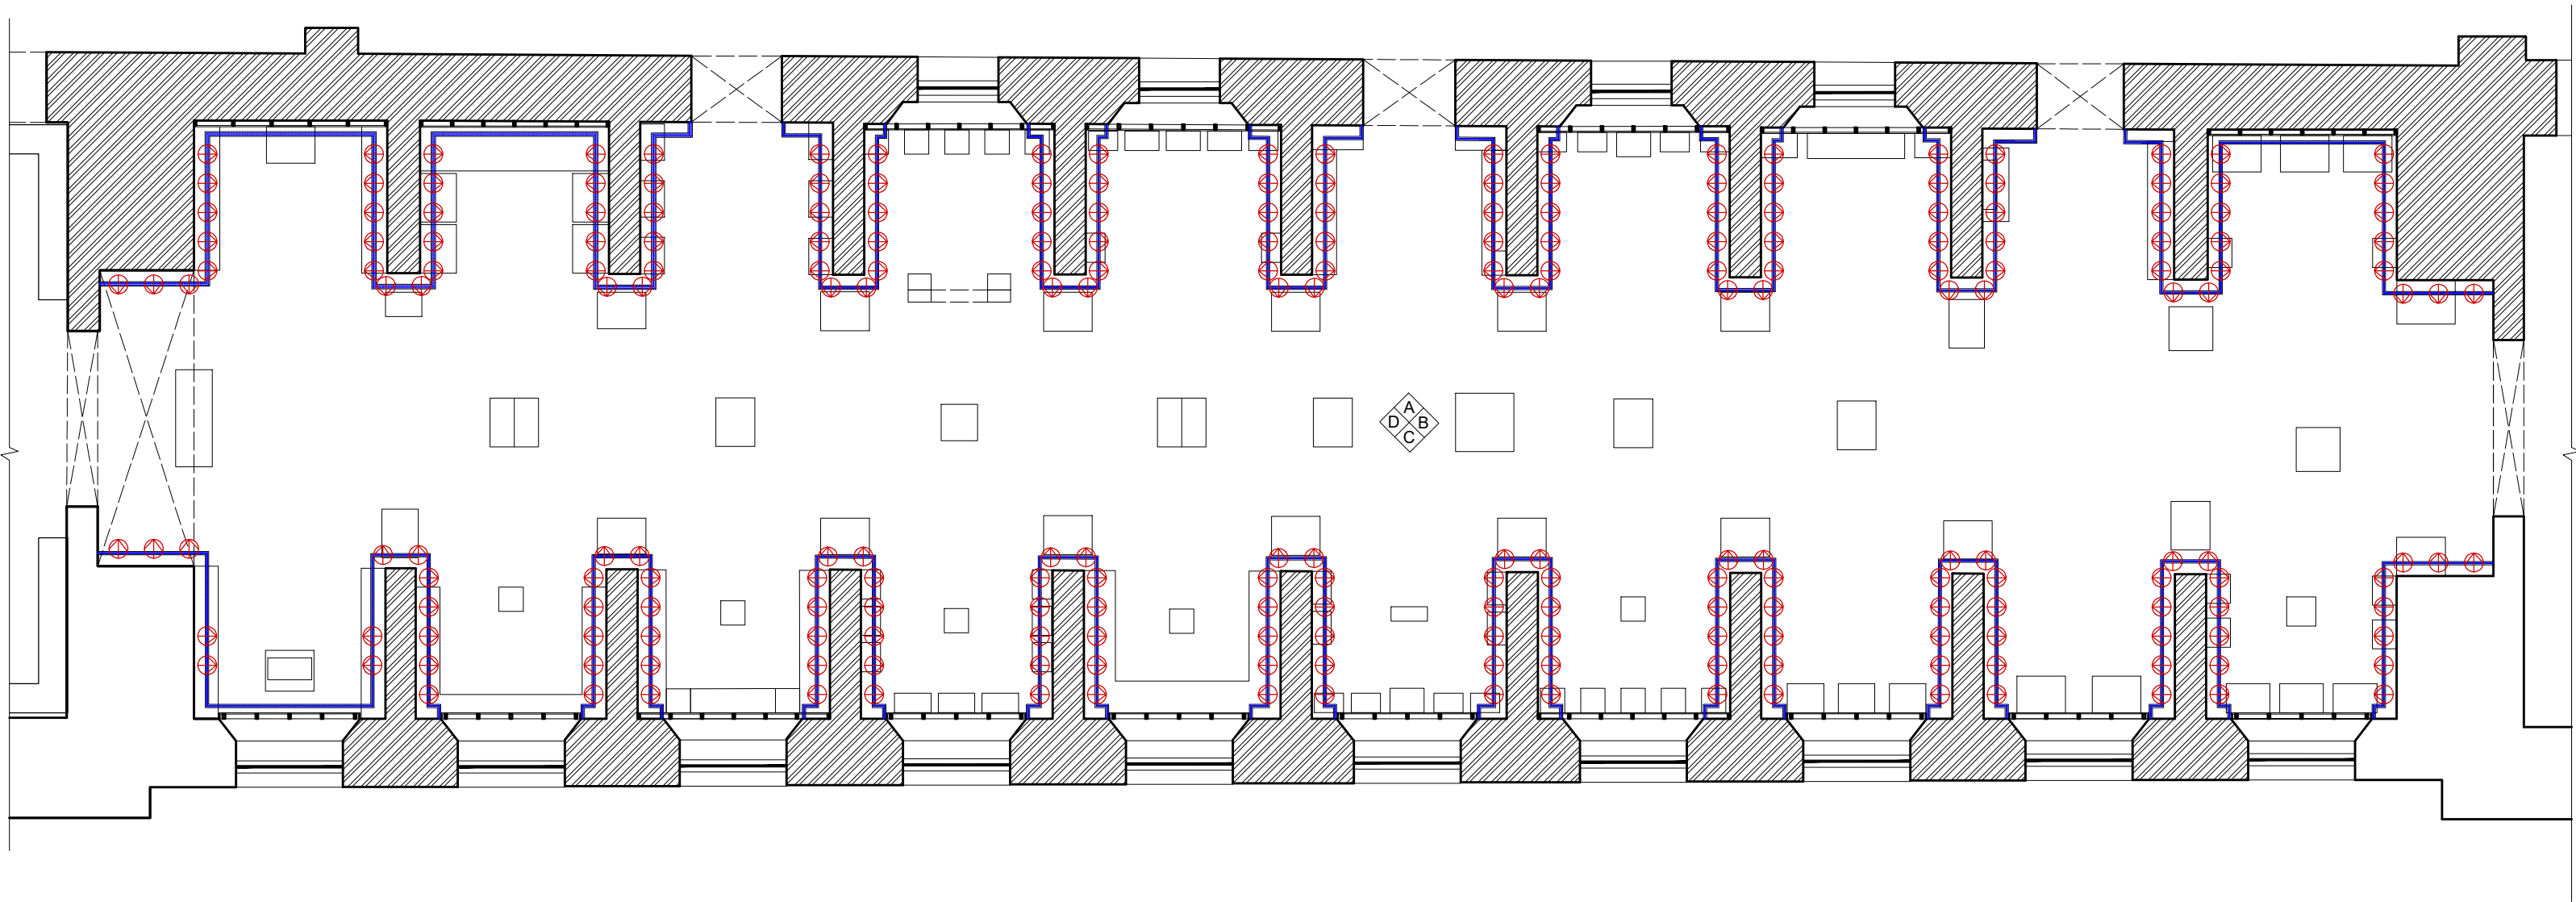

Sym	Type
	Track light (recessed with Cornice)
	LED strip light
	Ceiling Light Conduit

GALLERY 6  
**METAL SCULPTURE GALLERY**




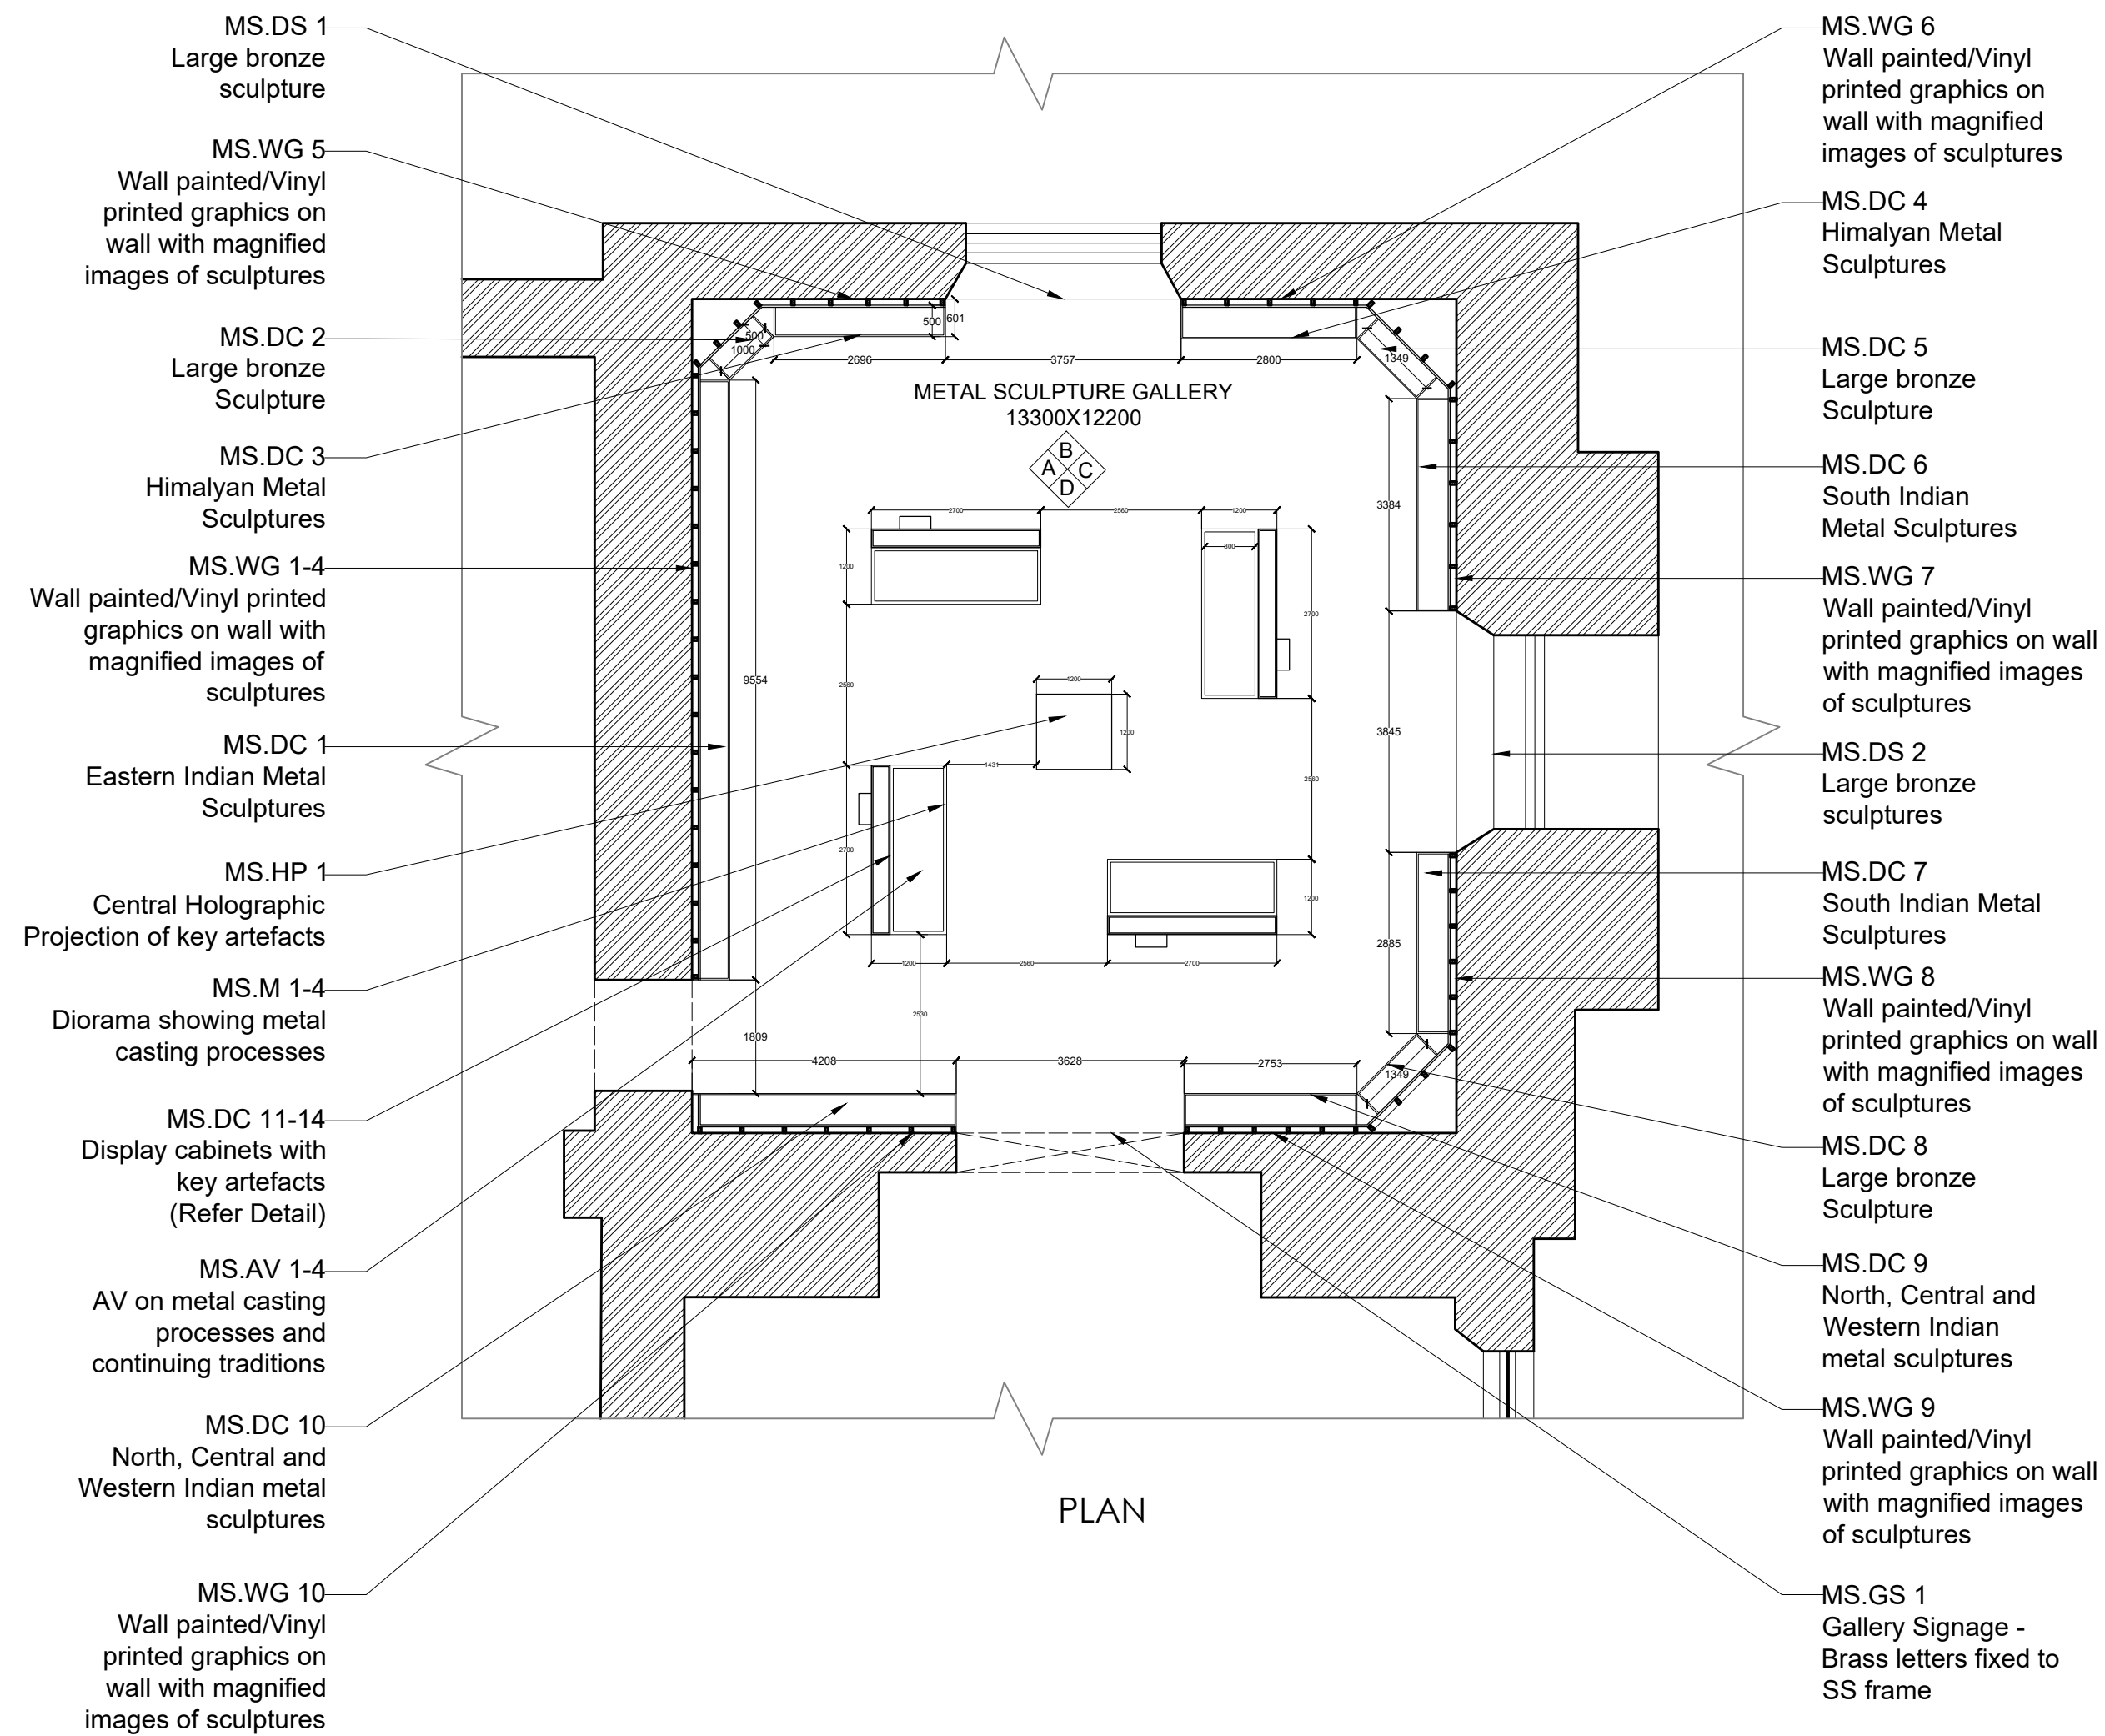

NOTES:

All dimensions are in millimeters

KEY PLAN

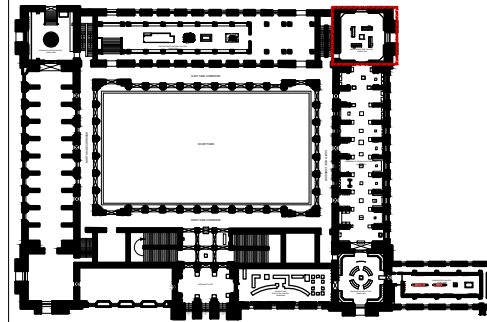

LEGEND

DP	Display Panel
DC	Display Case
DS	Display Shelf
PE	Pedestal
WM	Wall Mural
WG	Wall Graphics
CP	Canvas Painting
M	Model
MET	Mock Excavation Trench
CP	Canvas Painting
AV	Audio Visuals
I	Interactive
P	Projection
HP	Holographic Projection
GS	Gallery Signage
DS	Directional Signage
LG	Logo
RT	Reception Table
CC	Crowd Control Barrier

SCALE: 1:100

0 1m 2m



NORTH

DRAWING NAME: LAYOUT

METAL SCULPTURE GALLERY

DRAWN BY: Sohini Pyne

CHECKED BY: Shikha Jain

DRAWING NUMBER: IMK/GF/MS/01

SERIES: Tender Drawings

PROJECT:

PLANNING, CONTENT DEVELOPMENT, DESIGNING, RETROFITTING AND CURATORIAL WORK FOR THE INDIAN MUSEUM, KOLKATA


CLIENT:

INDIAN MUSEUM, KOLKATA


CONSULTANT:

**DRONAH**  
DEVELOPMENT & RESEARCH ORGANISATION FOR NATURE,ARTS & HERITAGE


A-258, SOUTH CITY-1  
GURGAON-122001

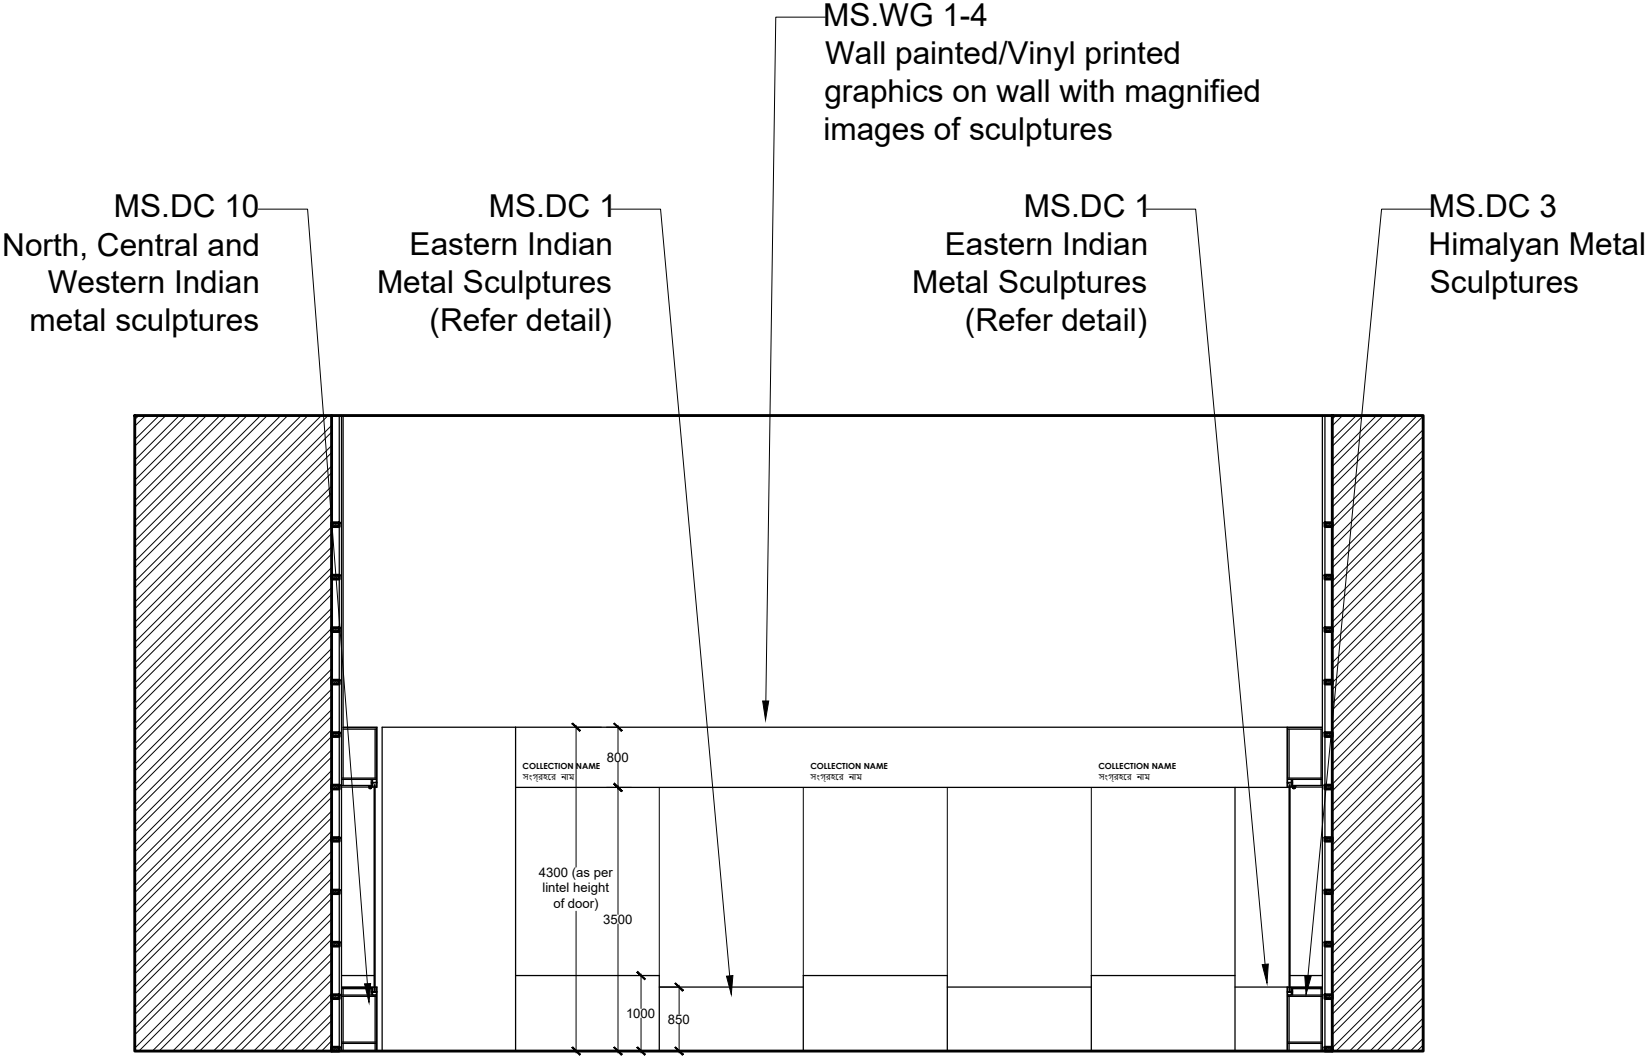


ELEVATION A

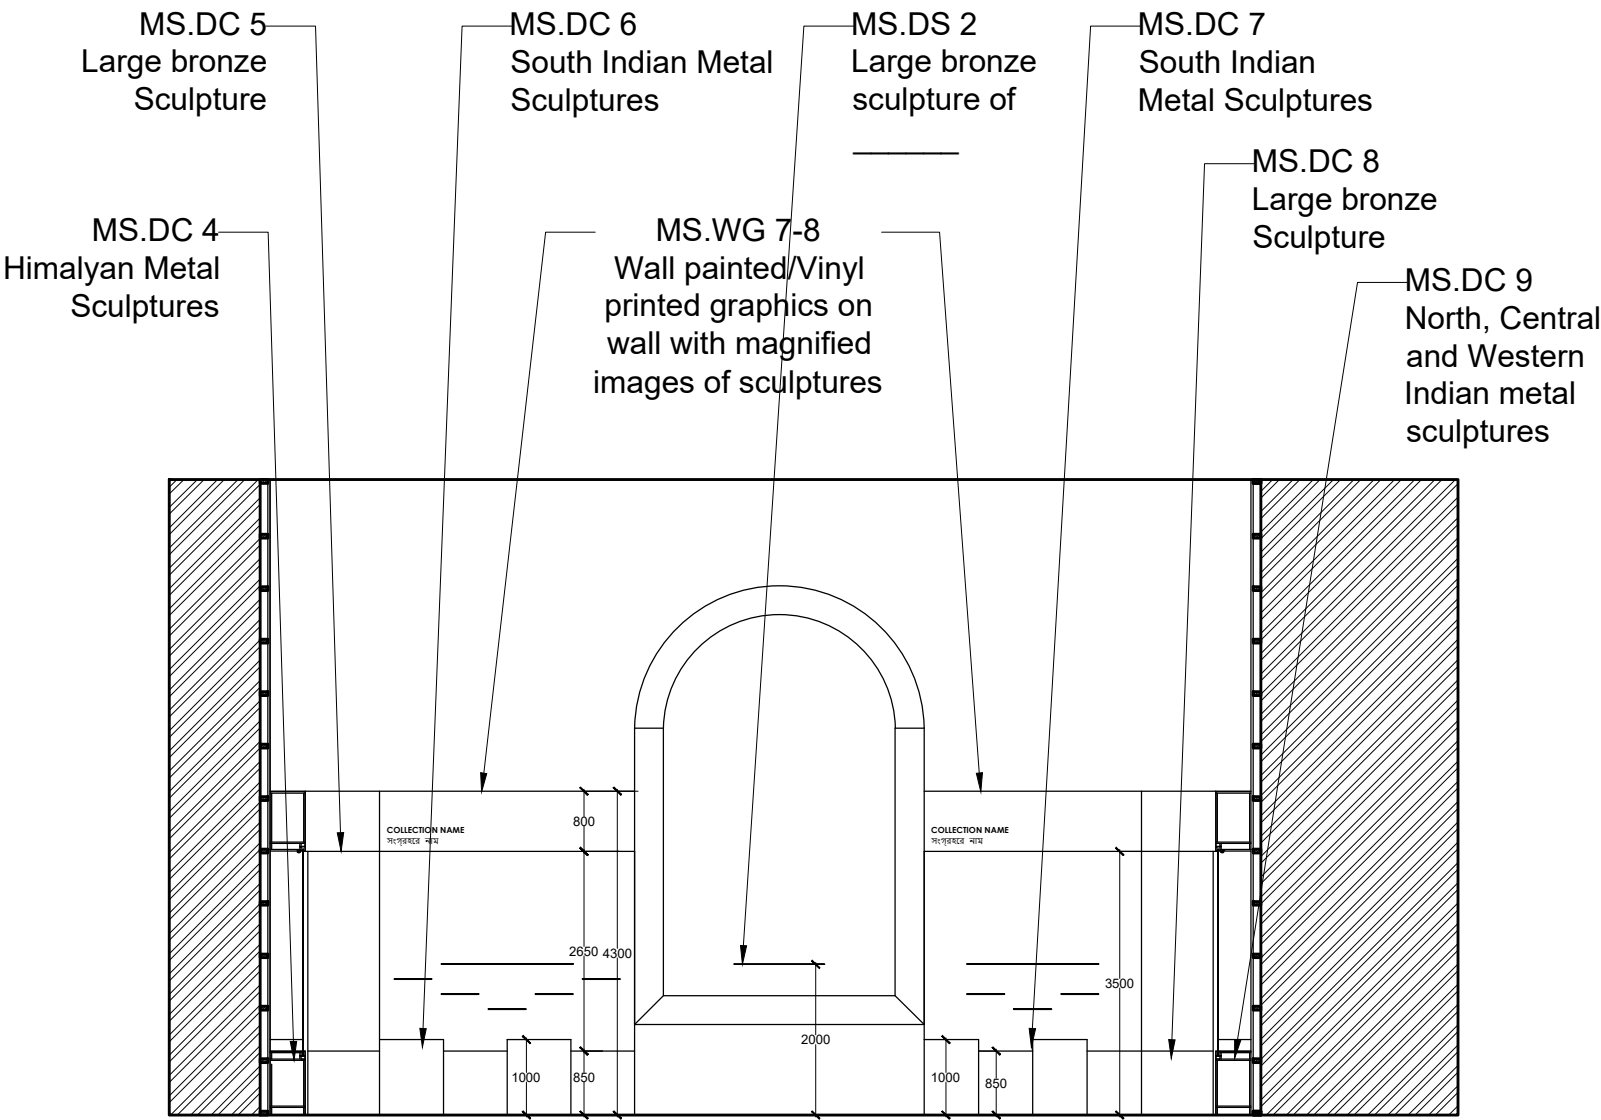

ELEVATION C

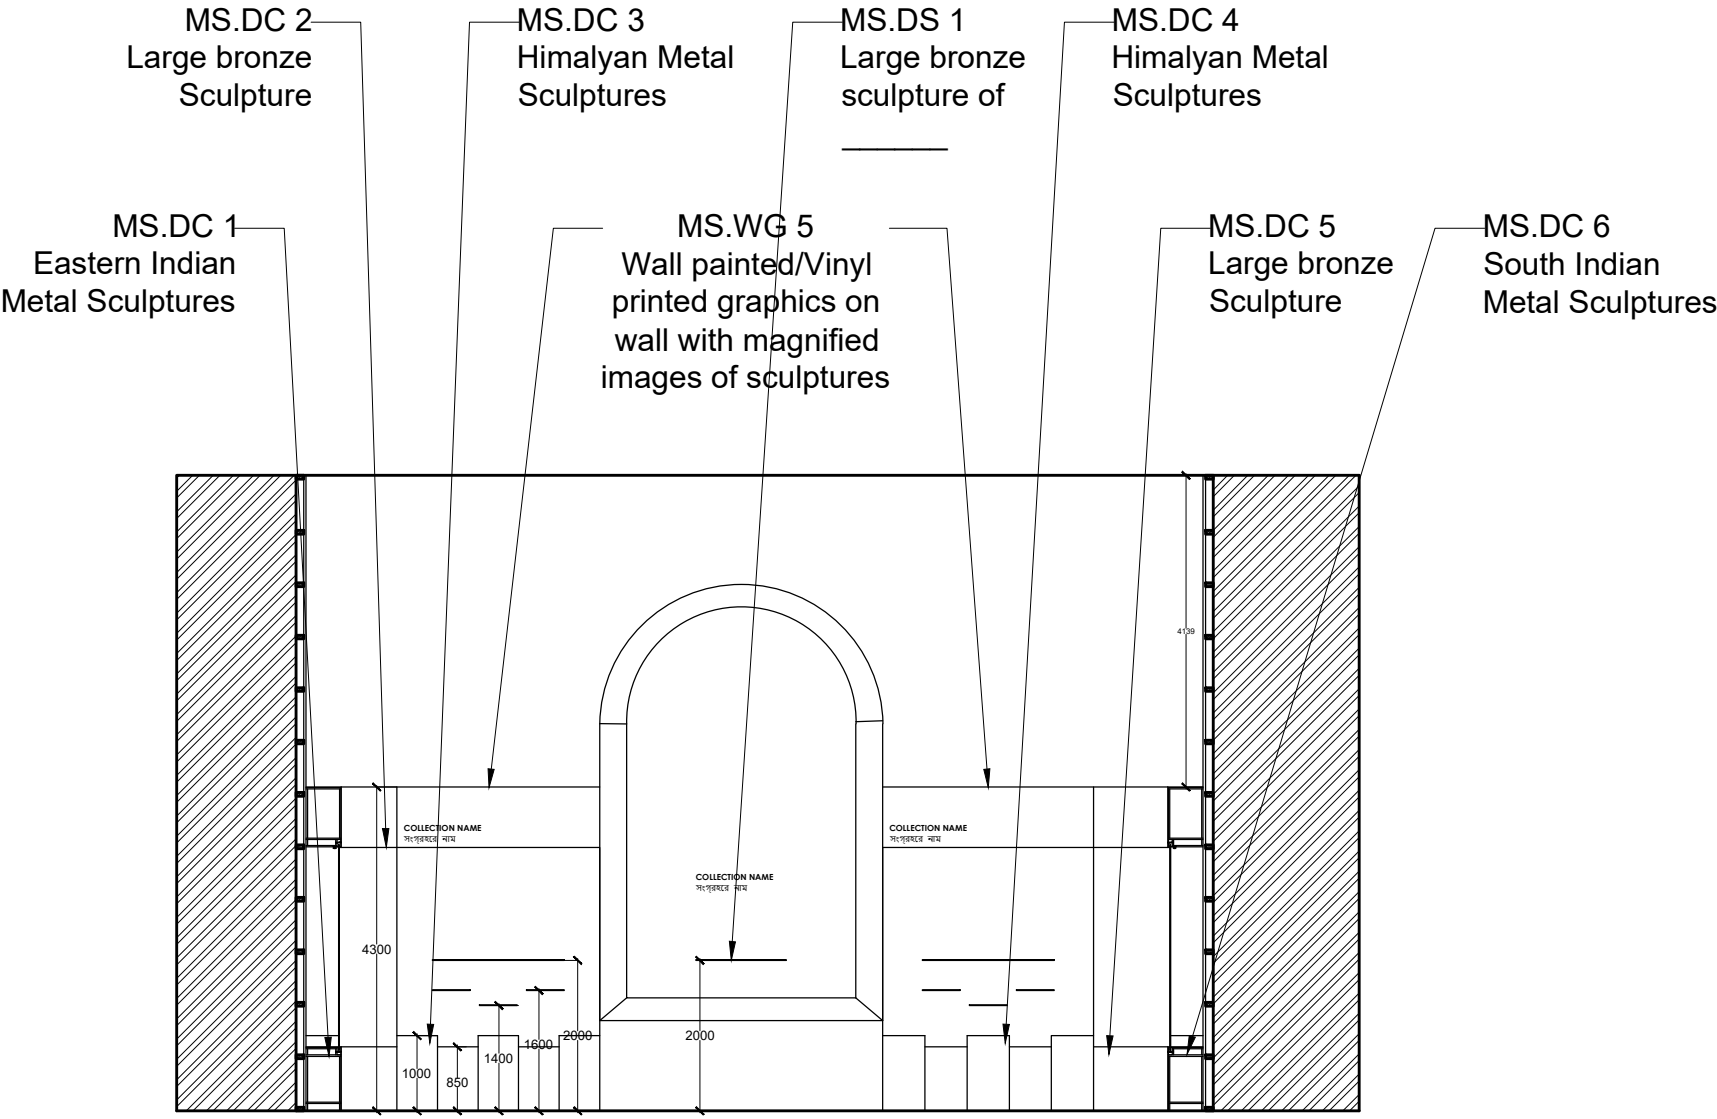

ELEVATION B

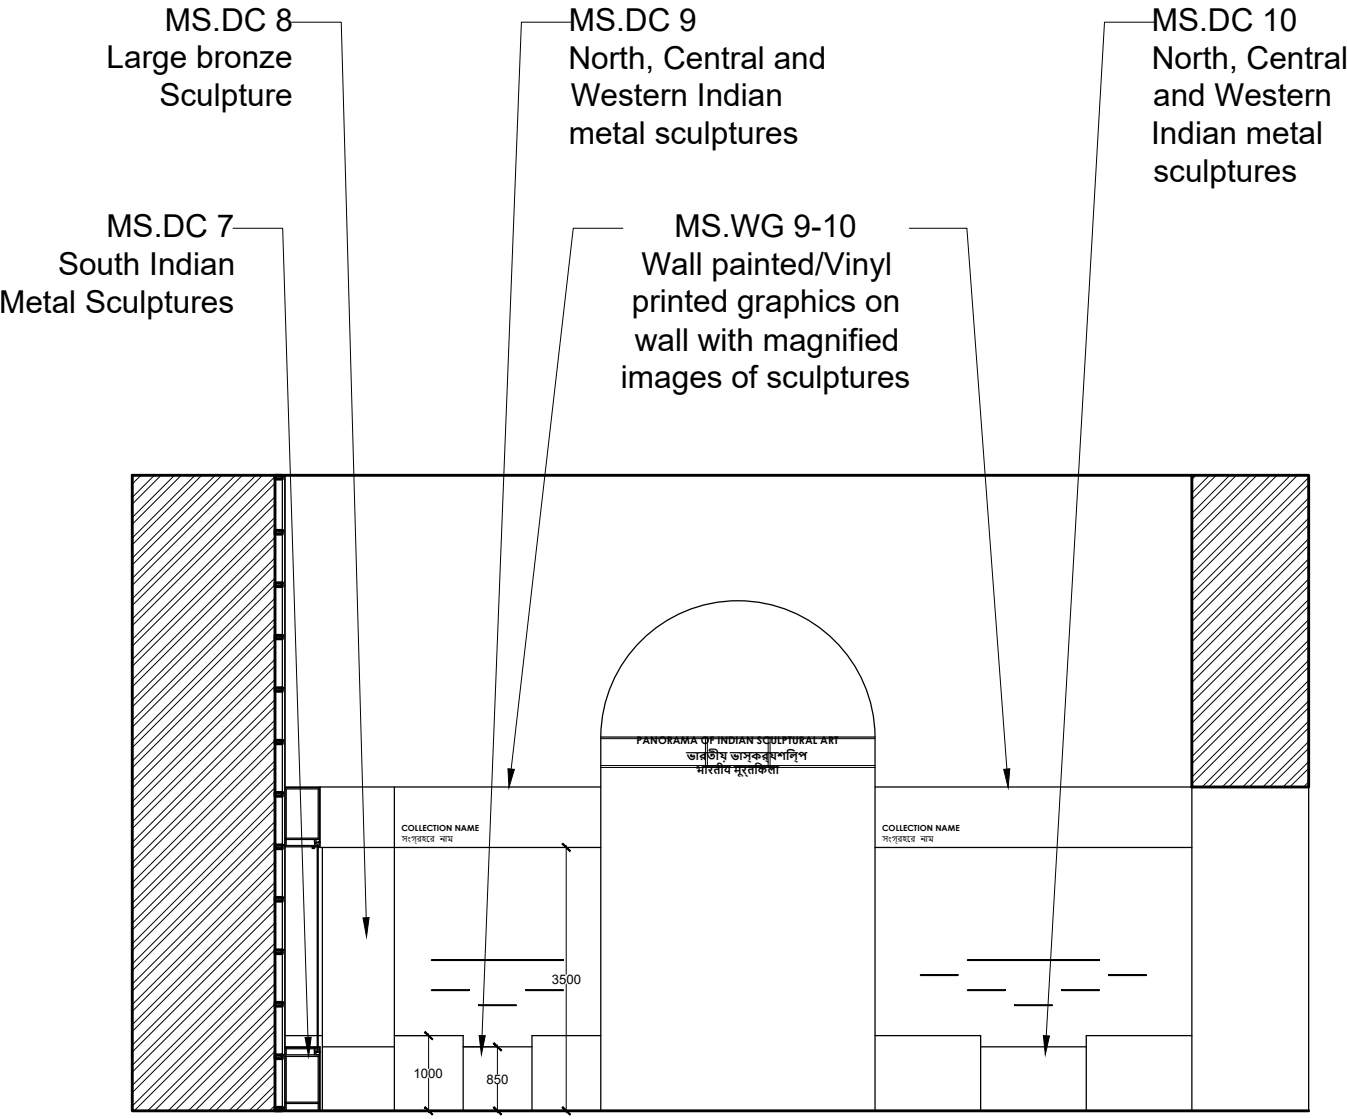


ELEVATION D

NOTES:

All dimensions are in millimeters

KEY PLAN

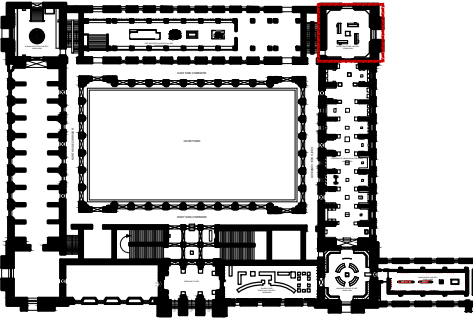

LEGEND

DP	Display Panel
DC	Display Case
DS	Display Shelf
PE	Pedestal
WM	Wall Mural
WG	Wall Graphics
CP	Canvas Painting
M	Model
MET	Mock Excavation Trench
CP	Canvas Painting
AV	Audio Visuals
I	Interactive
P	Projection
HP	Holographic Projection
GS	Gallery Signage
DS	Directional Signage
LG	Logo
RT	Reception Table
CC	Crowd Control Barrier

SCALE: 1:100

0 1m 2m



DRAWING NAME: LAYOUT

METAL SCULPTURE GALLERY

DRAWN BY: Sohini Pyne

CHECKED BY: Shikha Jain

DRAWING NUMBER: IMK/GF/MS/02

SERIES: Tender Drawings

PROJECT:

PLANNING, CONTENT  
DEVELOPMENT, DESIGNING,  
RETROFITTING AND CURATORIAL  
WORK FOR THE INDIAN MUSEUM,  
KOLKATA

CLIENT:


INDIAN MUSEUM, KOLKATA

CONSULTANT:



**DRONAH**  
DEVELOPMENT & RESEARCH  
ORGANISATION FOR NATURE,ARTS  
& HERITAGE

A-258, SOUTH CITY-1  
GURGAON-122001

DETAIL MS. DC 1, 3, 4, 6, 7, 9, 10

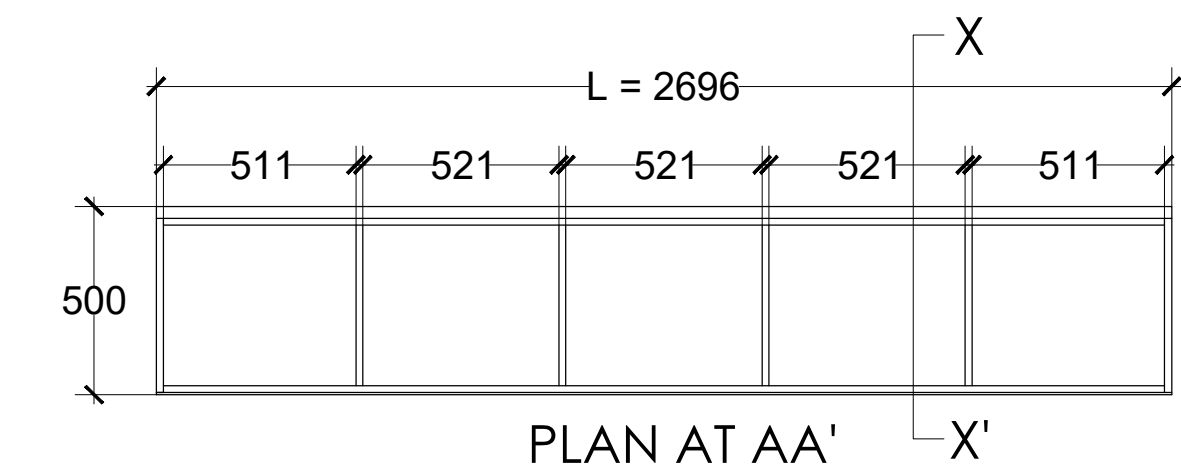


TYPE	LENGTH	BREADTH
DC 1	9554	500
DC 3	2696	500
DC 4	2800	500
DC 6	3384	500
DC 7	2845	500
DC 9	2752	500
DC 10	4208	500

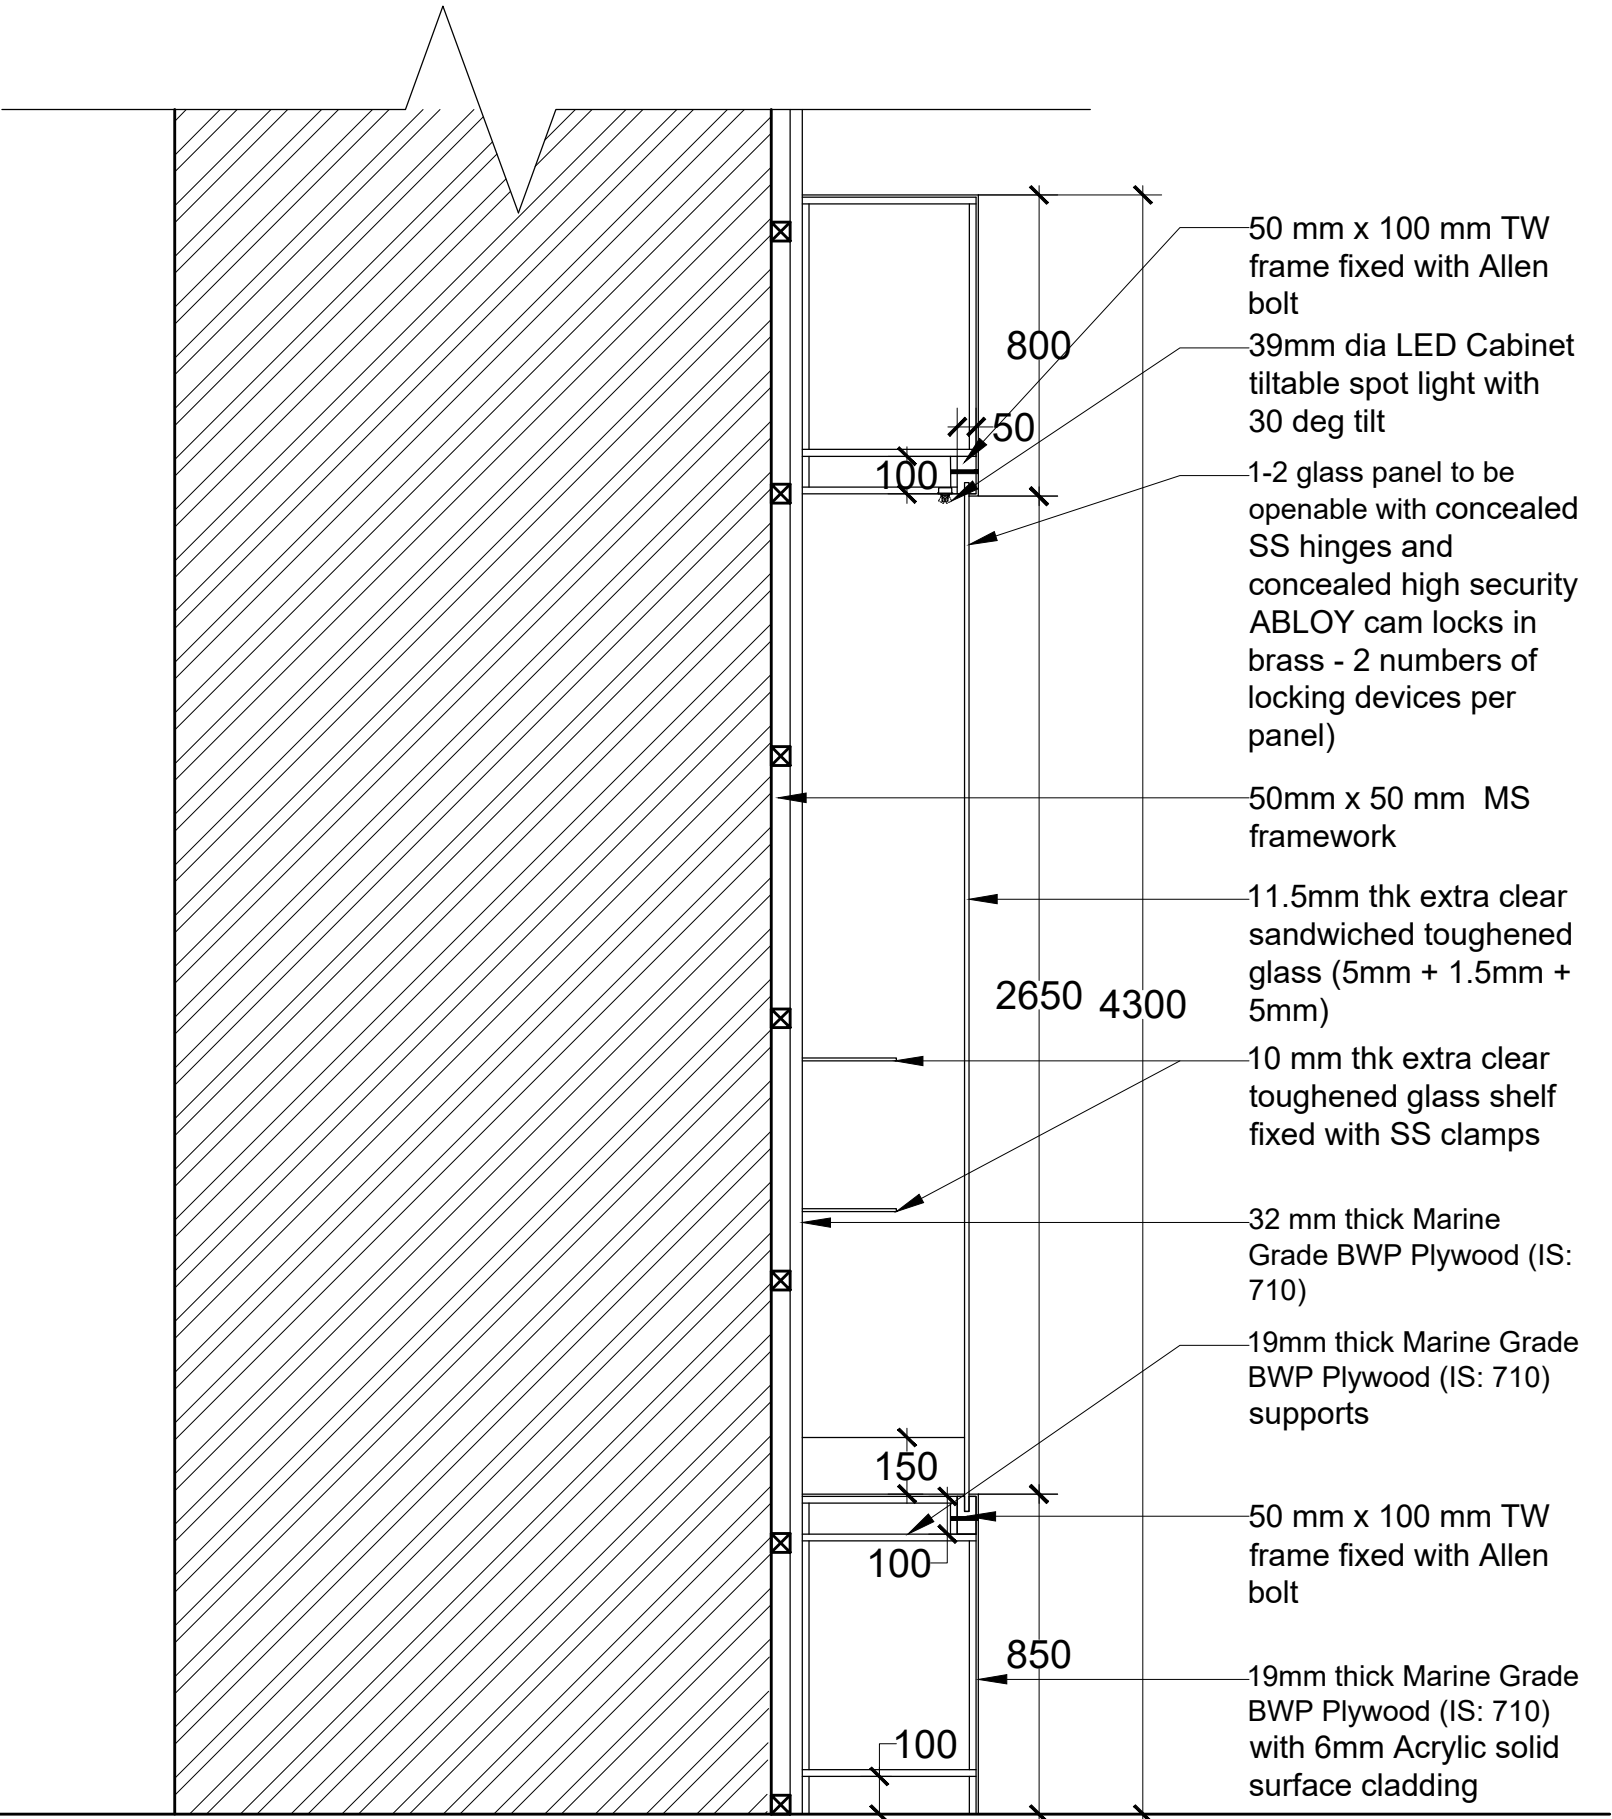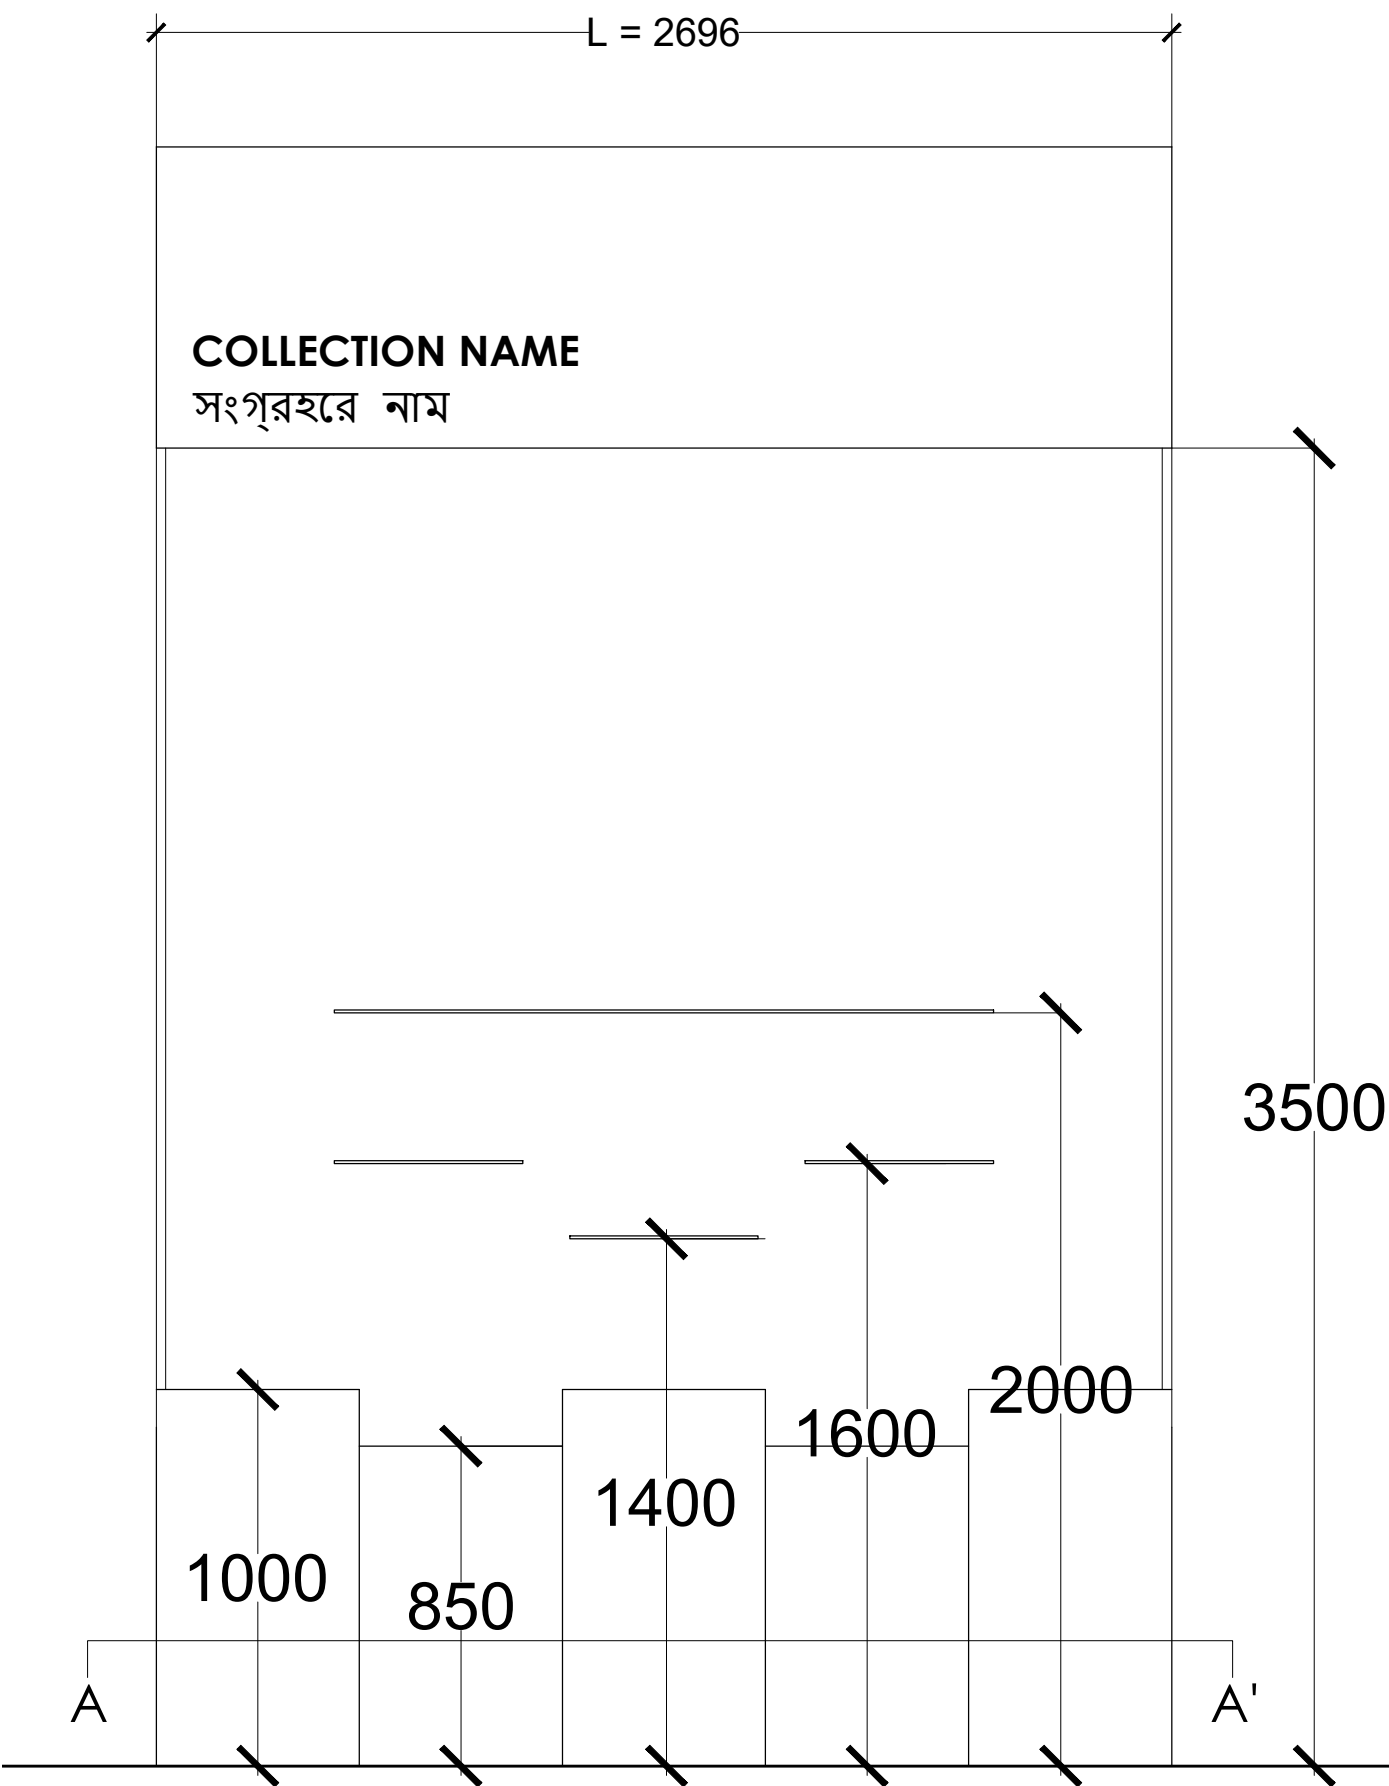

NOTES:

All dimensions are in millimeters

KEY PLAN

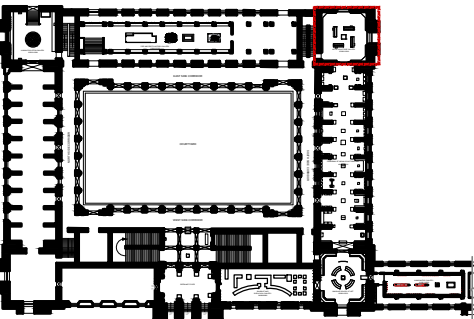

LEGEND

DP	Display Panel
DC	Display Case
DS	Display Shelf
PE	Pedestal
WM	Wall Mural
WG	Wall Graphics
CP	Canvas Painting
M	Model
MET	Mock Excavation Trench
CP	Canvas Painting
AV	Audio Visuals
I	Interactive
P	Projection
HP	Holographic Projection
GS	Gallery Signage
DS	Directional Signage
LG	Logo
RT	Reception Table
CC	Crowd Control Barrier

SCALE: 1:20

0 1m 2m



DRAWING NAME: LAYOUT

METAL SCULPTURE GALLERY

DRAWN BY: Sohini Pyne

CHECKED BY: Shikha Jain

DRAWING NUMBER: IMK/GF/MS/03

SERIES: Tender Drawings

PROJECT:

PLANNING, CONTENT DEVELOPMENT, DESIGNING, RETROFITTING AND CURATORIAL WORK FOR THE INDIAN MUSEUM, KOLKATA

CLIENT:

INDIAN MUSEUM, KOLKATA


CONSULTANT:

**DRONAH**  
DEVELOPMENT & RESEARCH ORGANISATION FOR NATURE,ARTS & HERITAGE

A-258, SOUTH CITY-1  
GURGAON-122001




DETAIL MS. DC 2

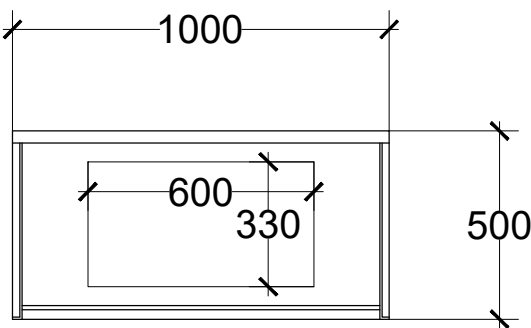


PLAN AT AA'


DETAIL MS. DC 5, 8

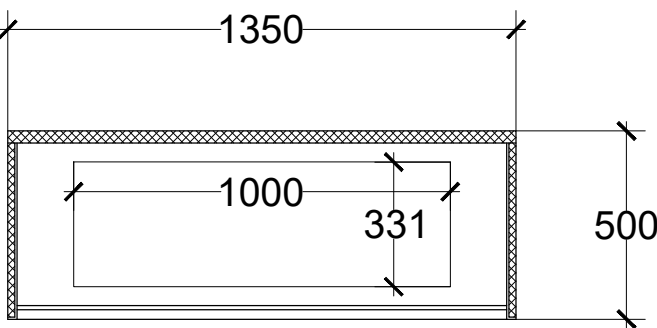

PLAN AT CC'

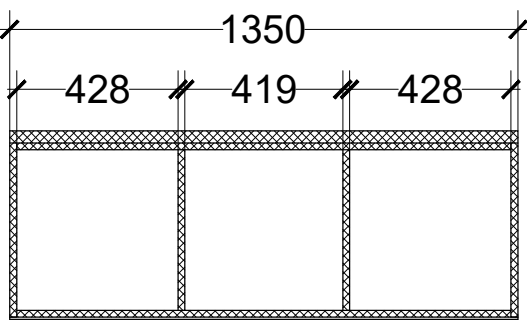


PLAN AT DD'

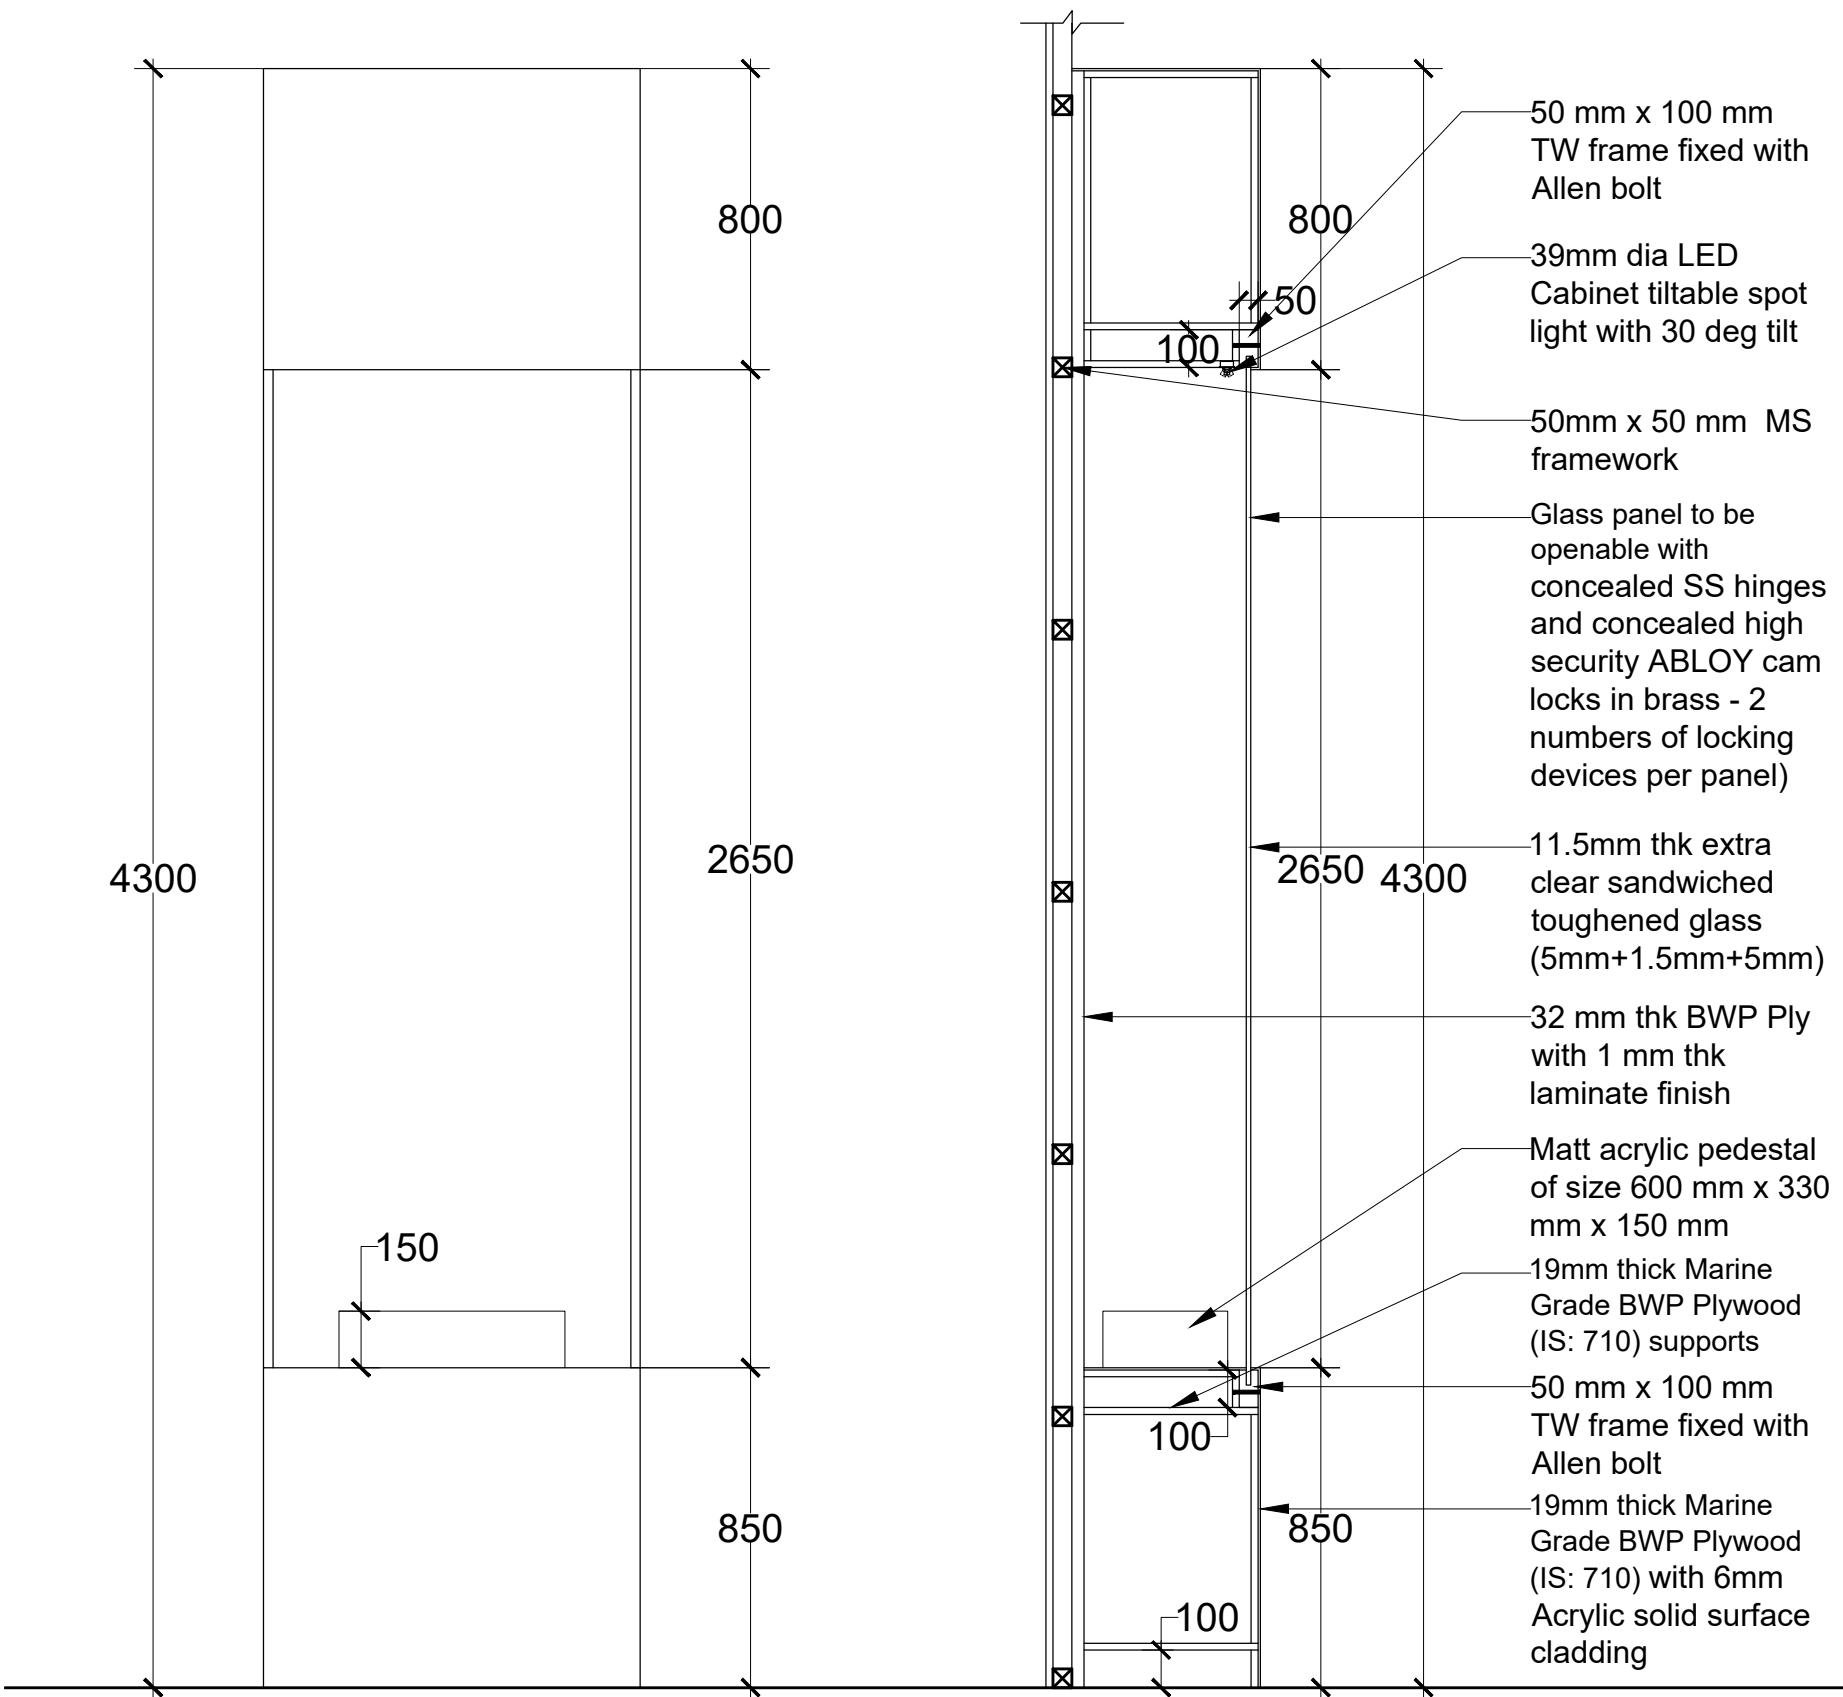

ELEVATION

SECTION PP'

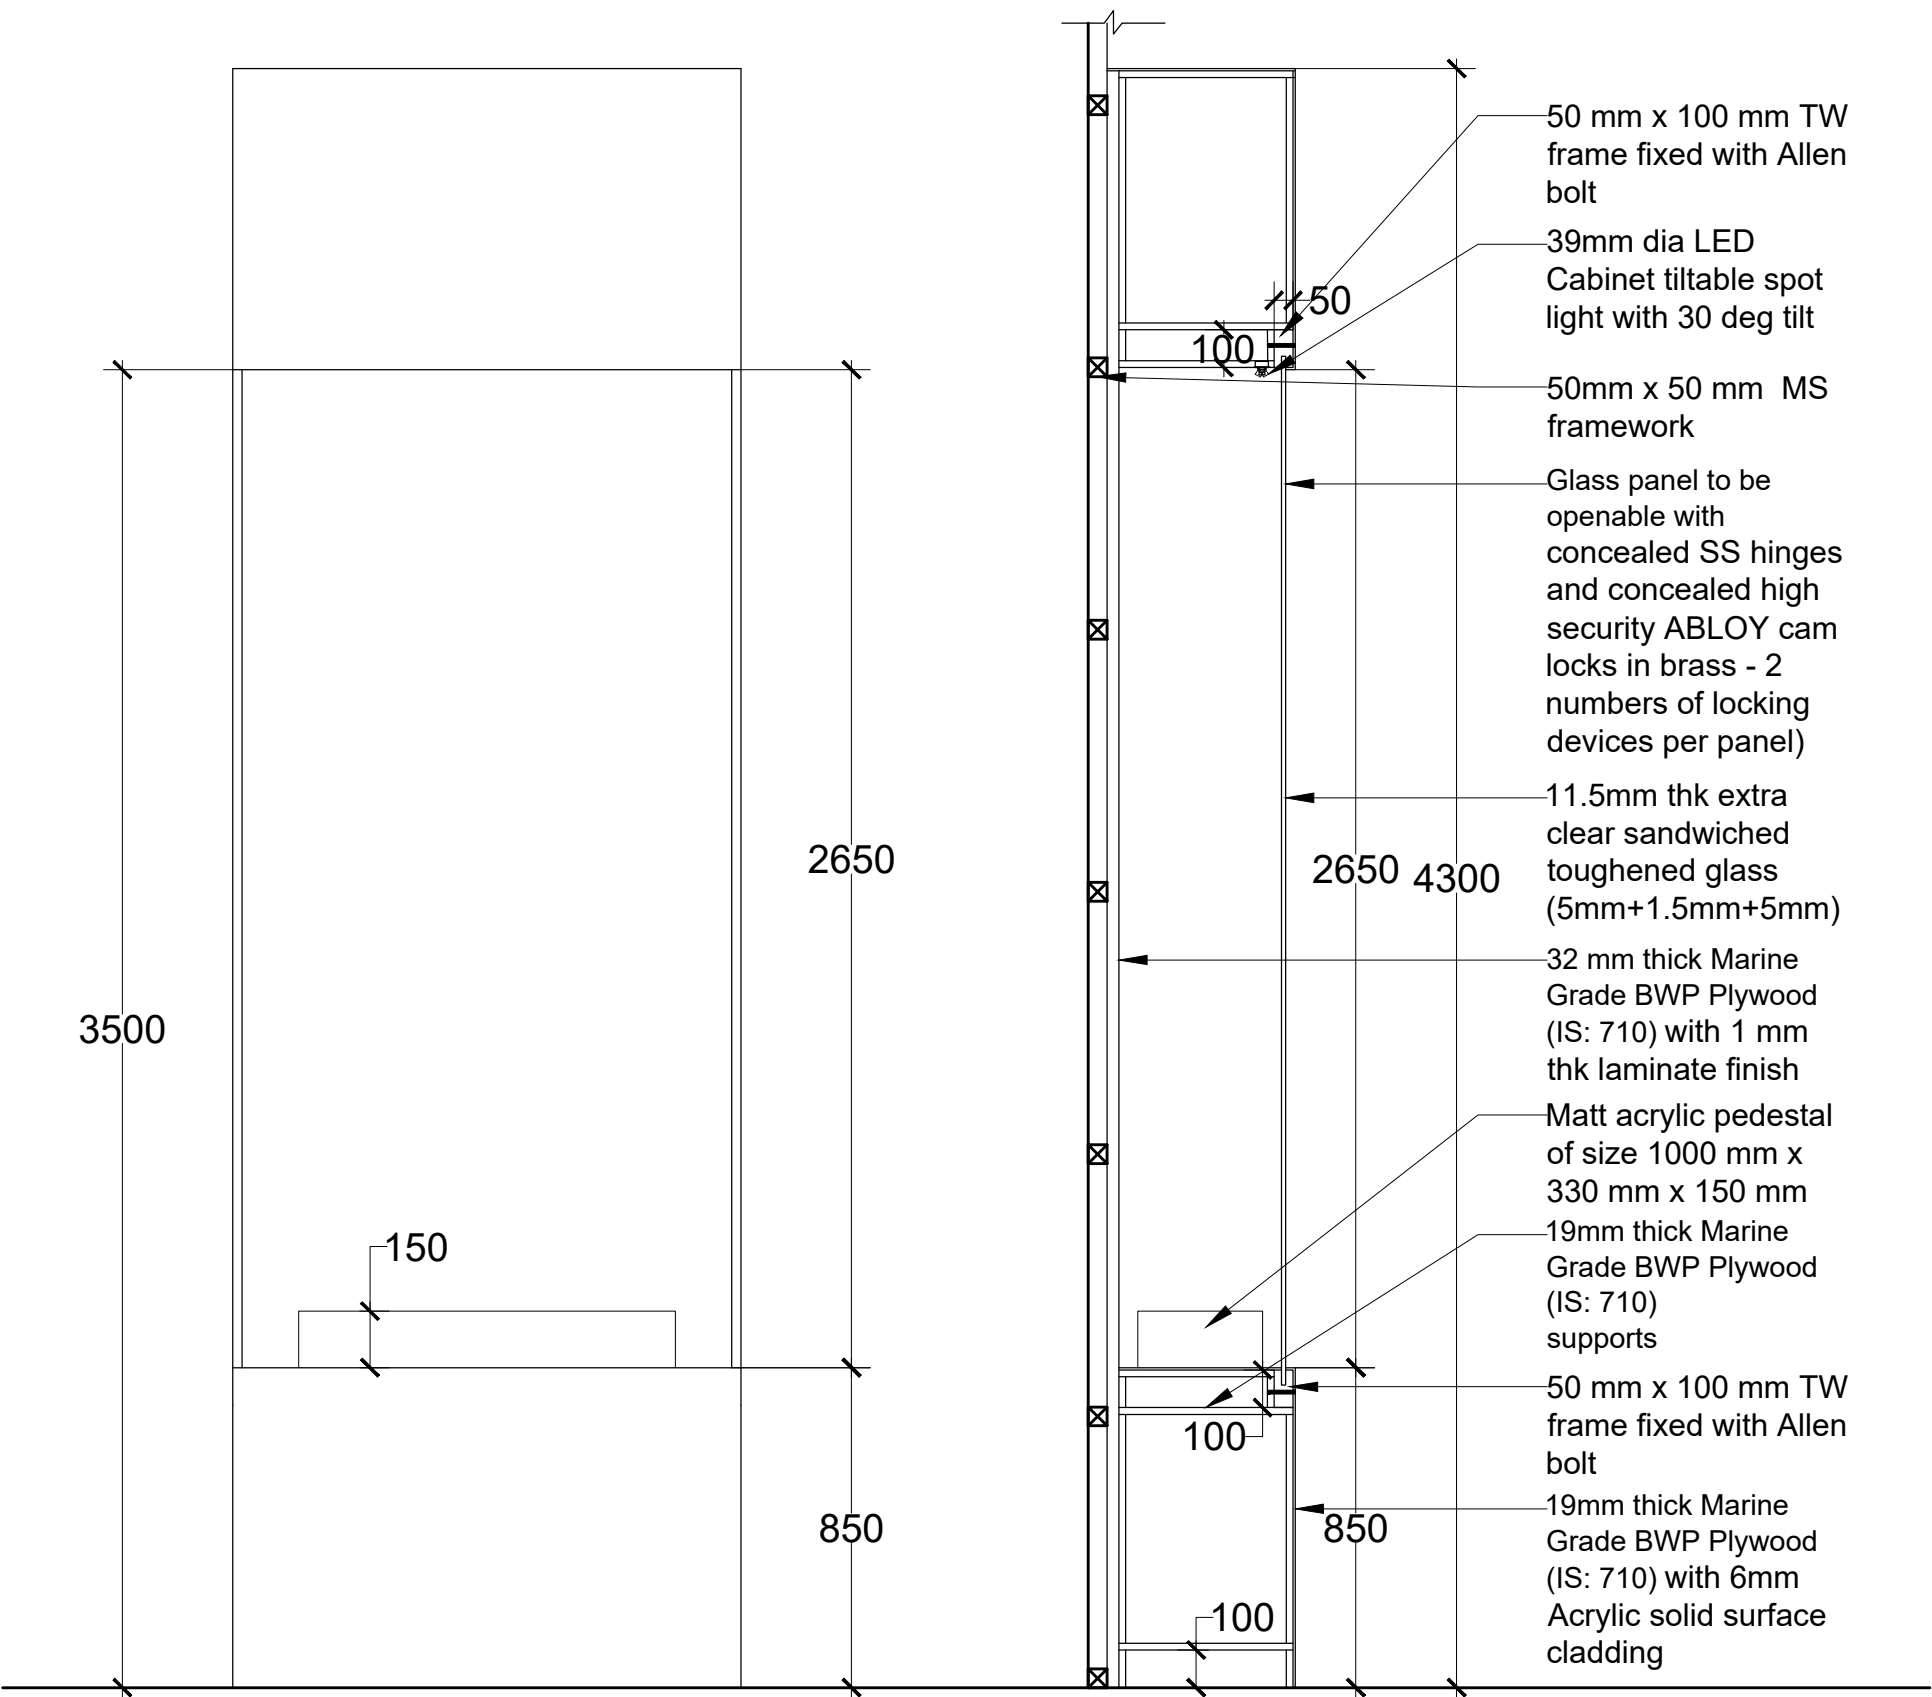


ELEVATION

SECTION QQ'

NOTES:

All dimensions are in millimeters

KEY PLAN

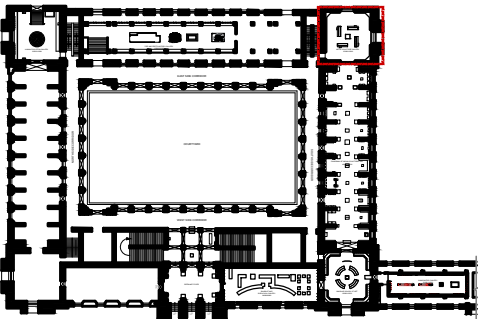

LEGEND

DP	Display Panel
DC	Display Case
DS	Display Shelf
PE	Pedestal
WM	Wall Mural
WG	Wall Graphics
CP	Canvas Painting
M	Model
MET	Mock Excavation Trench
CP	Canvas Painting
AV	Audio Visuals
I	Interactive
P	Projection
HP	Holographic Projection
GS	Gallery Signage
DS	Directional Signage
LG	Logo
RT	Reception Table
CC	Crowd Control Barrier

SCALE: 1:20

0 1m 2m



NORTH

DRAWING NAME: LAYOUT

METAL SCULPTURE GALLERY

DRAWN BY: Sohini Pyne

CHECKED BY: Shikha Jain

DRAWING NUMBER: IMK/GF/MS/04

SERIES: Tender Drawings

PROJECT:

PLANNING, CONTENT DEVELOPMENT, DESIGNING, RETROFITTING AND CURATORIAL WORK FOR THE INDIAN MUSEUM, KOLKATA

CLIENT:


INDIAN MUSEUM, KOLKATA

CONSULTANT:


**DRONAH**  
DEVELOPMENT & RESEARCH  
ORGANISATION FOR NATURE,ARTS  
& HERITAGE

A-258, SOUTH CITY-1  
GURGAON-122001


DETAIL MS. DC 11-14

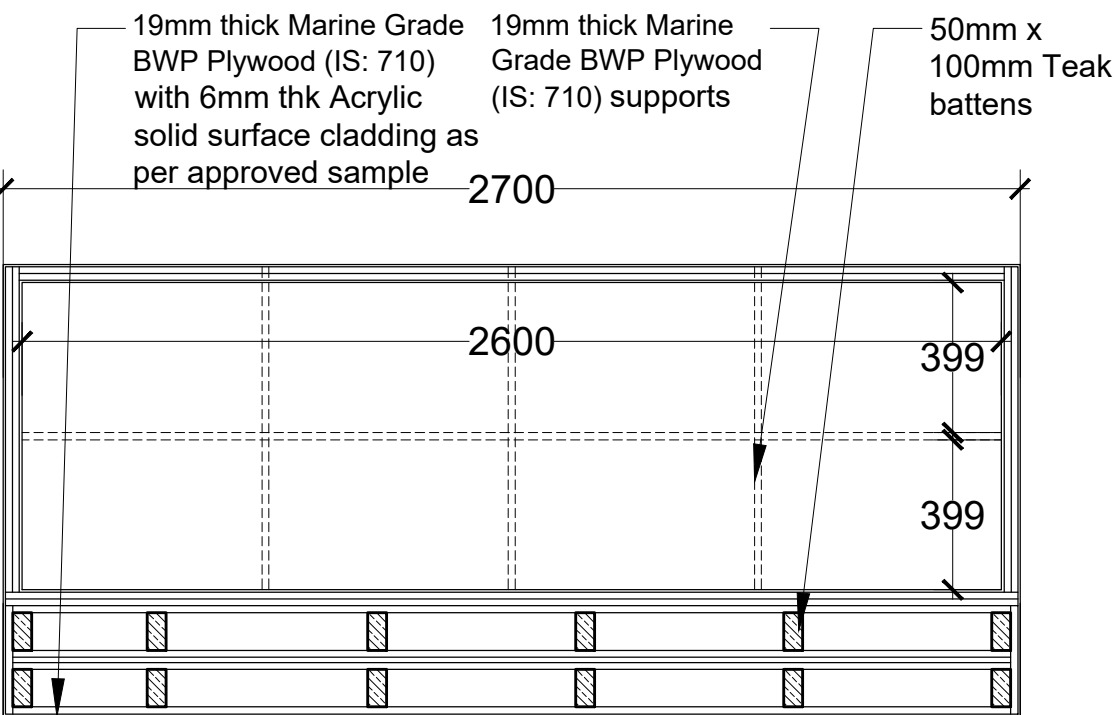


PLAN @ AA'

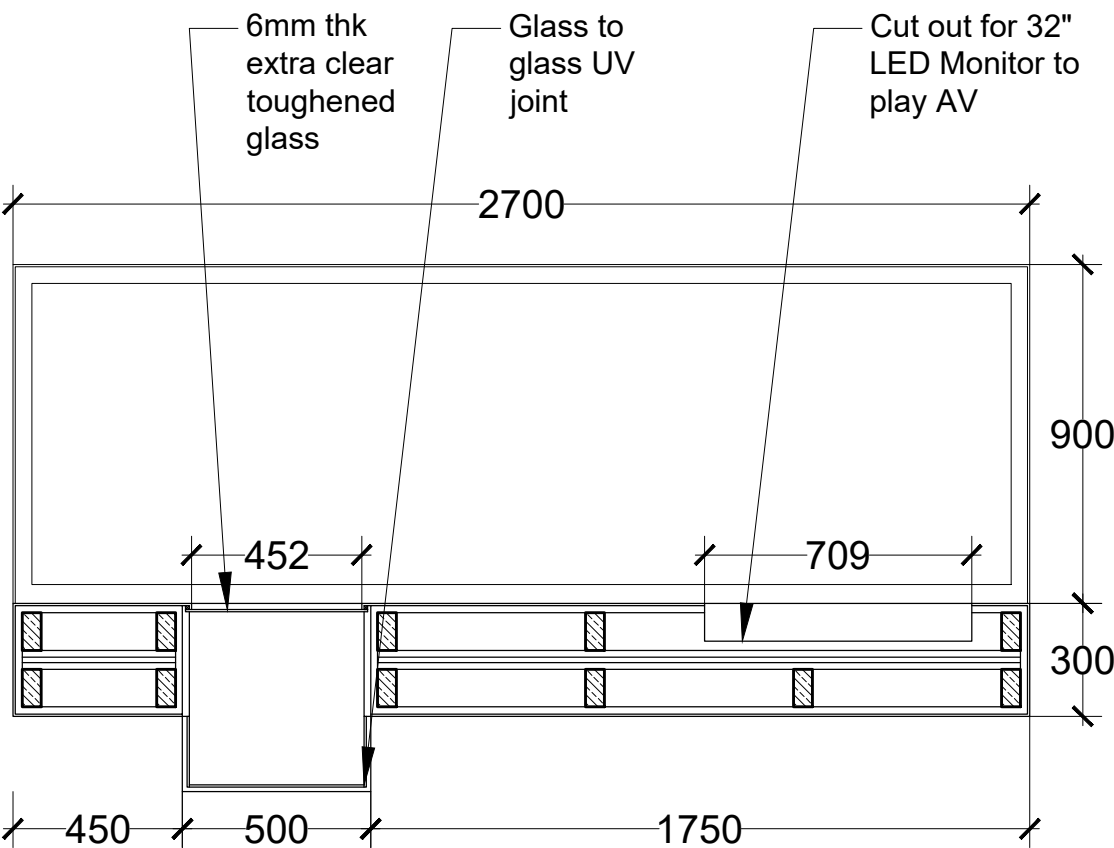


PLAN @ BB'

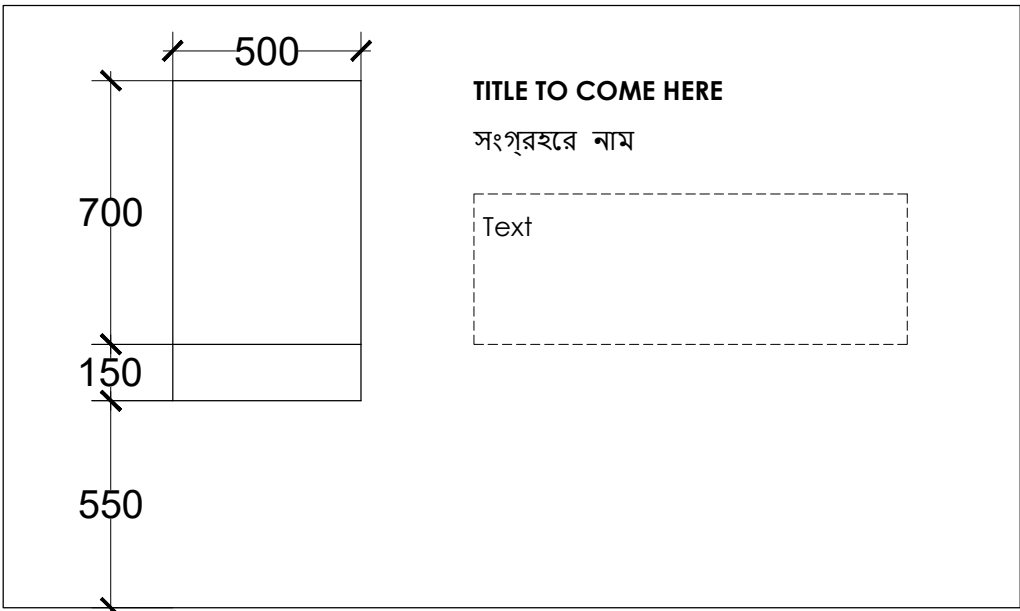

FRONT ELEVATION

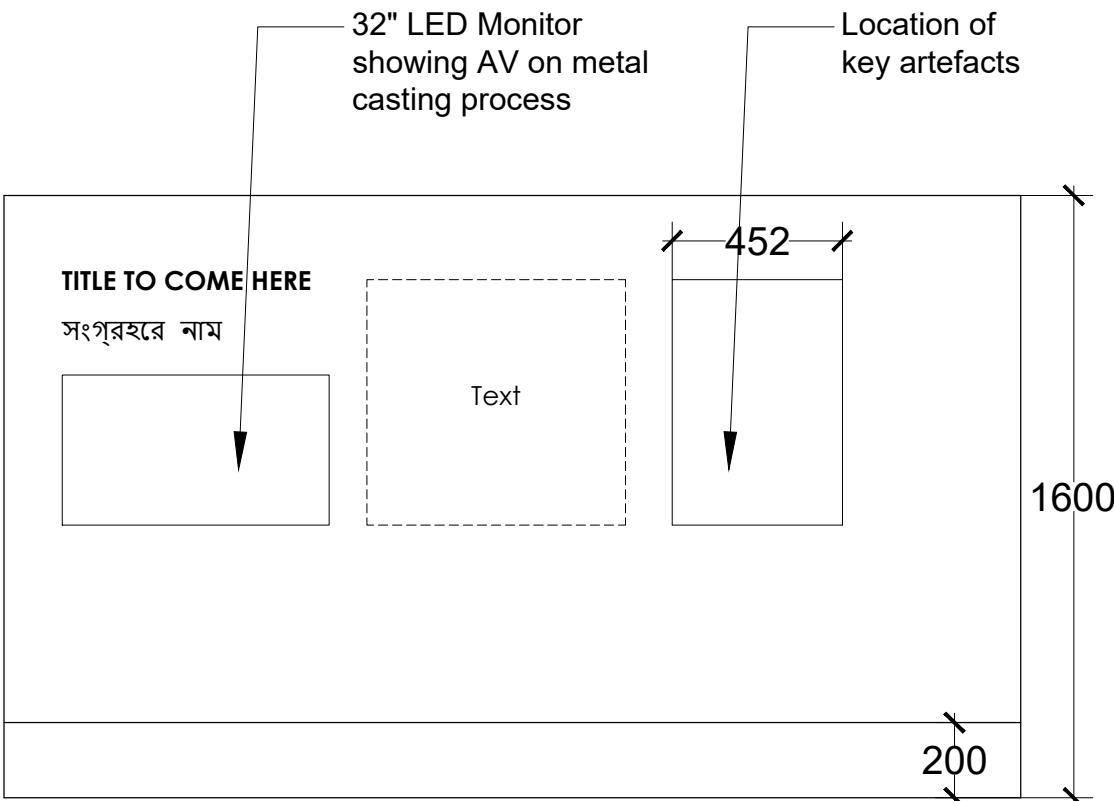

REAR ELEVATION

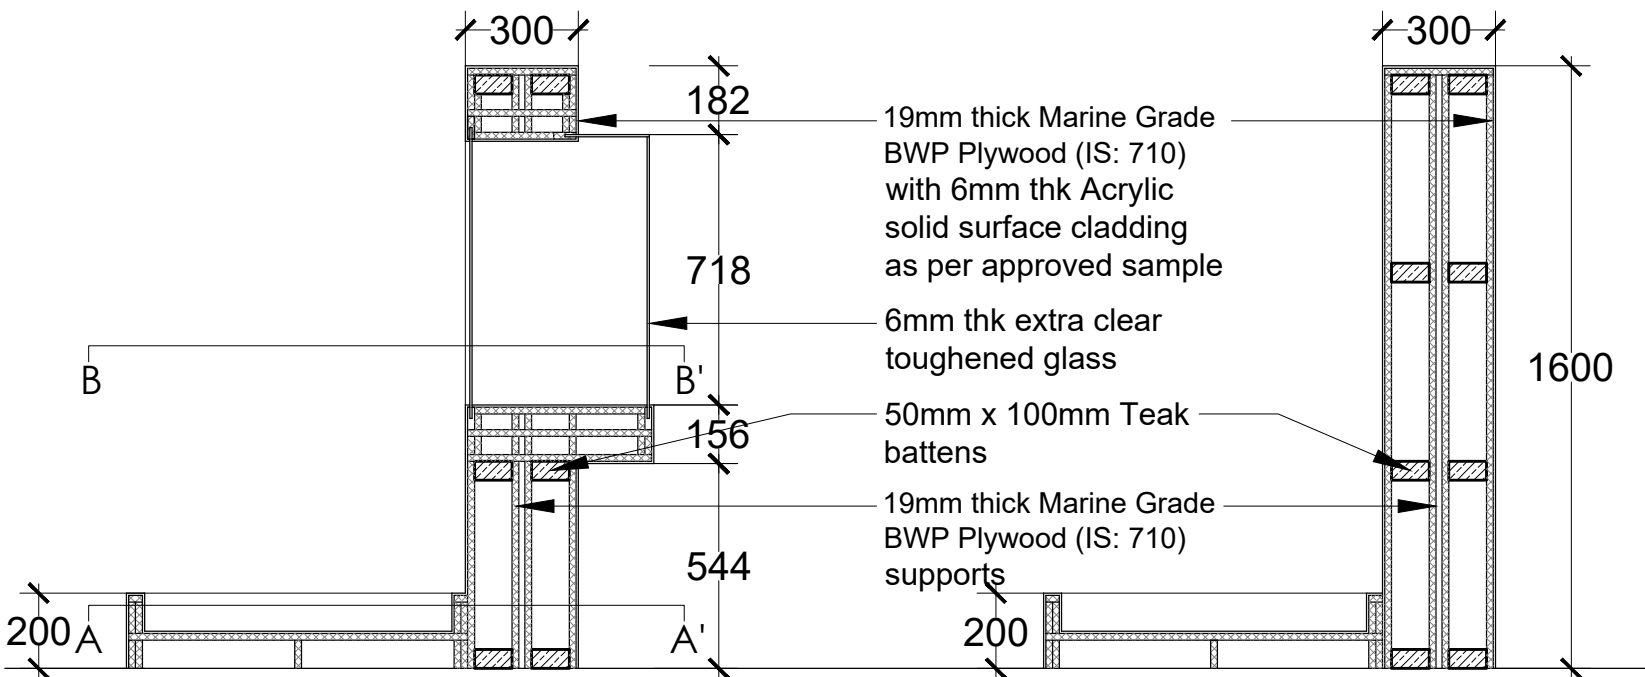


SECTION XX'

SECTION YY'

NOTES:

All dimensions are in millimeters

KEY PLAN

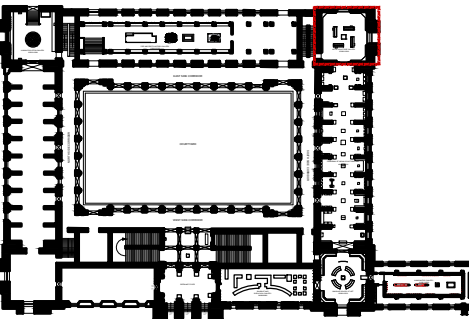

LEGEND

DP	Display Panel
DC	Display Case
DS	Display Shelf
PE	Pedestal
WM	Wall Mural
WG	Wall Graphics
CP	Canvas Painting
M	Model
MET	Mock Excavation Trench
CP	Canvas Painting
AV	Audio Visuals
I	Interactive
P	Projection
HP	Holographic Projection
GS	Gallery Signage
DS	Directional Signage
LG	Logo
RT	Reception Table
CC	Crowd Control Barrier

SCALE: 1:20

0 1m 2m



NORTH

DRAWING NAME: LAYOUT

METAL SCULPTURE GALLERY

DRAWN BY: Sohini Pyne

CHECKED BY: Shikha Jain

DRAWING NUMBER: IMK/GF/MS/05

SERIES: Tender Drawings

PROJECT:

PLANNING, CONTENT DEVELOPMENT, DESIGNING, RETROFITTING AND CURATORIAL WORK FOR THE INDIAN MUSEUM, KOLKATA

CLIENT:


INDIAN MUSEUM, KOLKATA

CONSULTANT:

**DRONAH**  
DEVELOPMENT & RESEARCH  
ORGANISATION FOR NATURE,ARTS  
& HERITAGE

A-258, SOUTH CITY-1  
GURGAON-122001



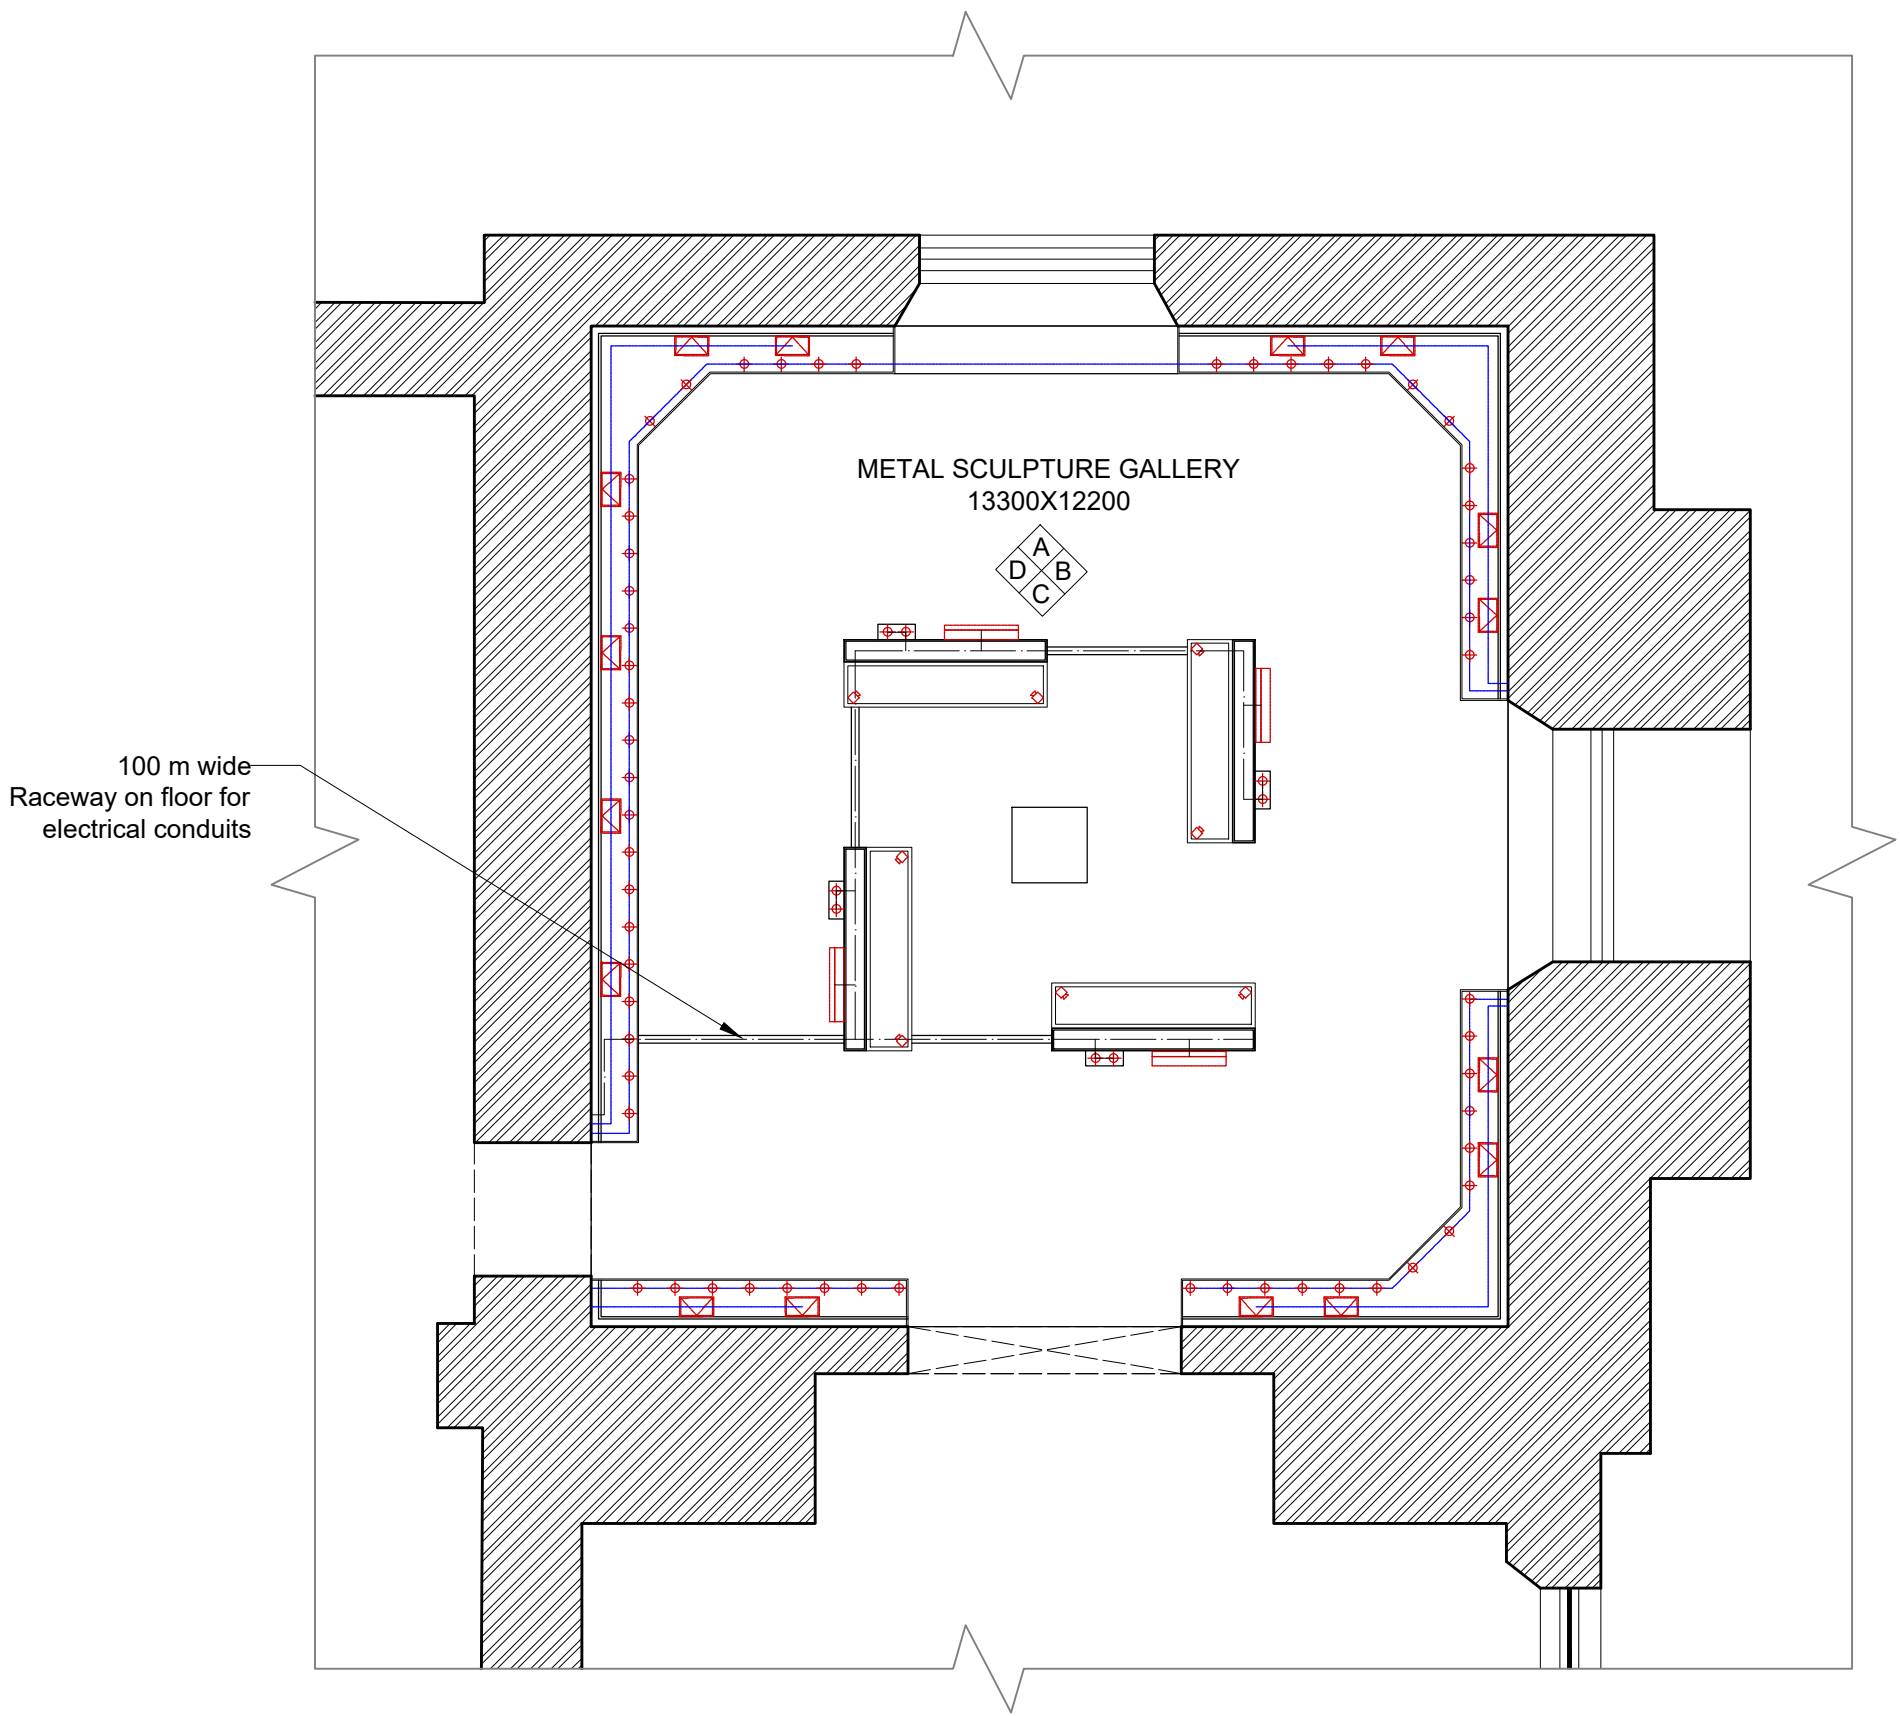


Sym	Type
	Cabinet light with rotatable head
	Wall washer uplight at ht 4300 mm
	Linear wall grazer (980 mm length)
	LED Pole/stand mounted cabinet lights
	Ceiling Light Conduit
	Floor Light conduit

NOTES:

All dimensions are in millimeters

KEY PLAN

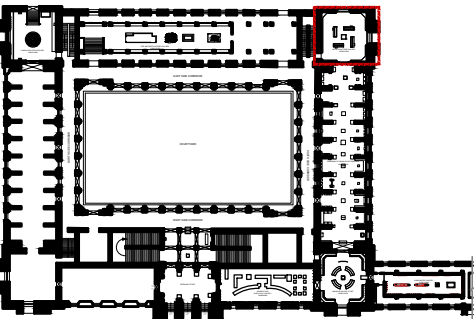

SCALE: 1:100	NORTH
0 1m 2m	

DRAWING: LIGHTING LAYOUT  
METAL SCULPTURE GALLERY

DRAWN BY: Sohini Pyne

CHECKED BY: Shikha Jain

DRAWING NUMBER: IMK/GF/MS/06


SERIES: Tender Drawings

PROJECT:  
PLANNING, CONTENT  
DEVELOPMENT, DESIGNING,  
RETROFITTING AND CURATORIAL  
WORK FOR THE INDIAN MUSEUM,  
KOLKATA

CLIENT:  
INDIAN MUSEUM, KOLKATA

CONSULTANT:  
**DRONAH**  
DEVELOPMENT & RESEARCH  
ORGANISATION FOR NATURE,ARTS  
& HERITAGE  
A-258, SOUTH CITY-1  
GURGAON-122001


GALLERY 7  
**GALLERY OF STONE AGE SCULPTURES  
AND HARAPPAN CIVILIZATION**

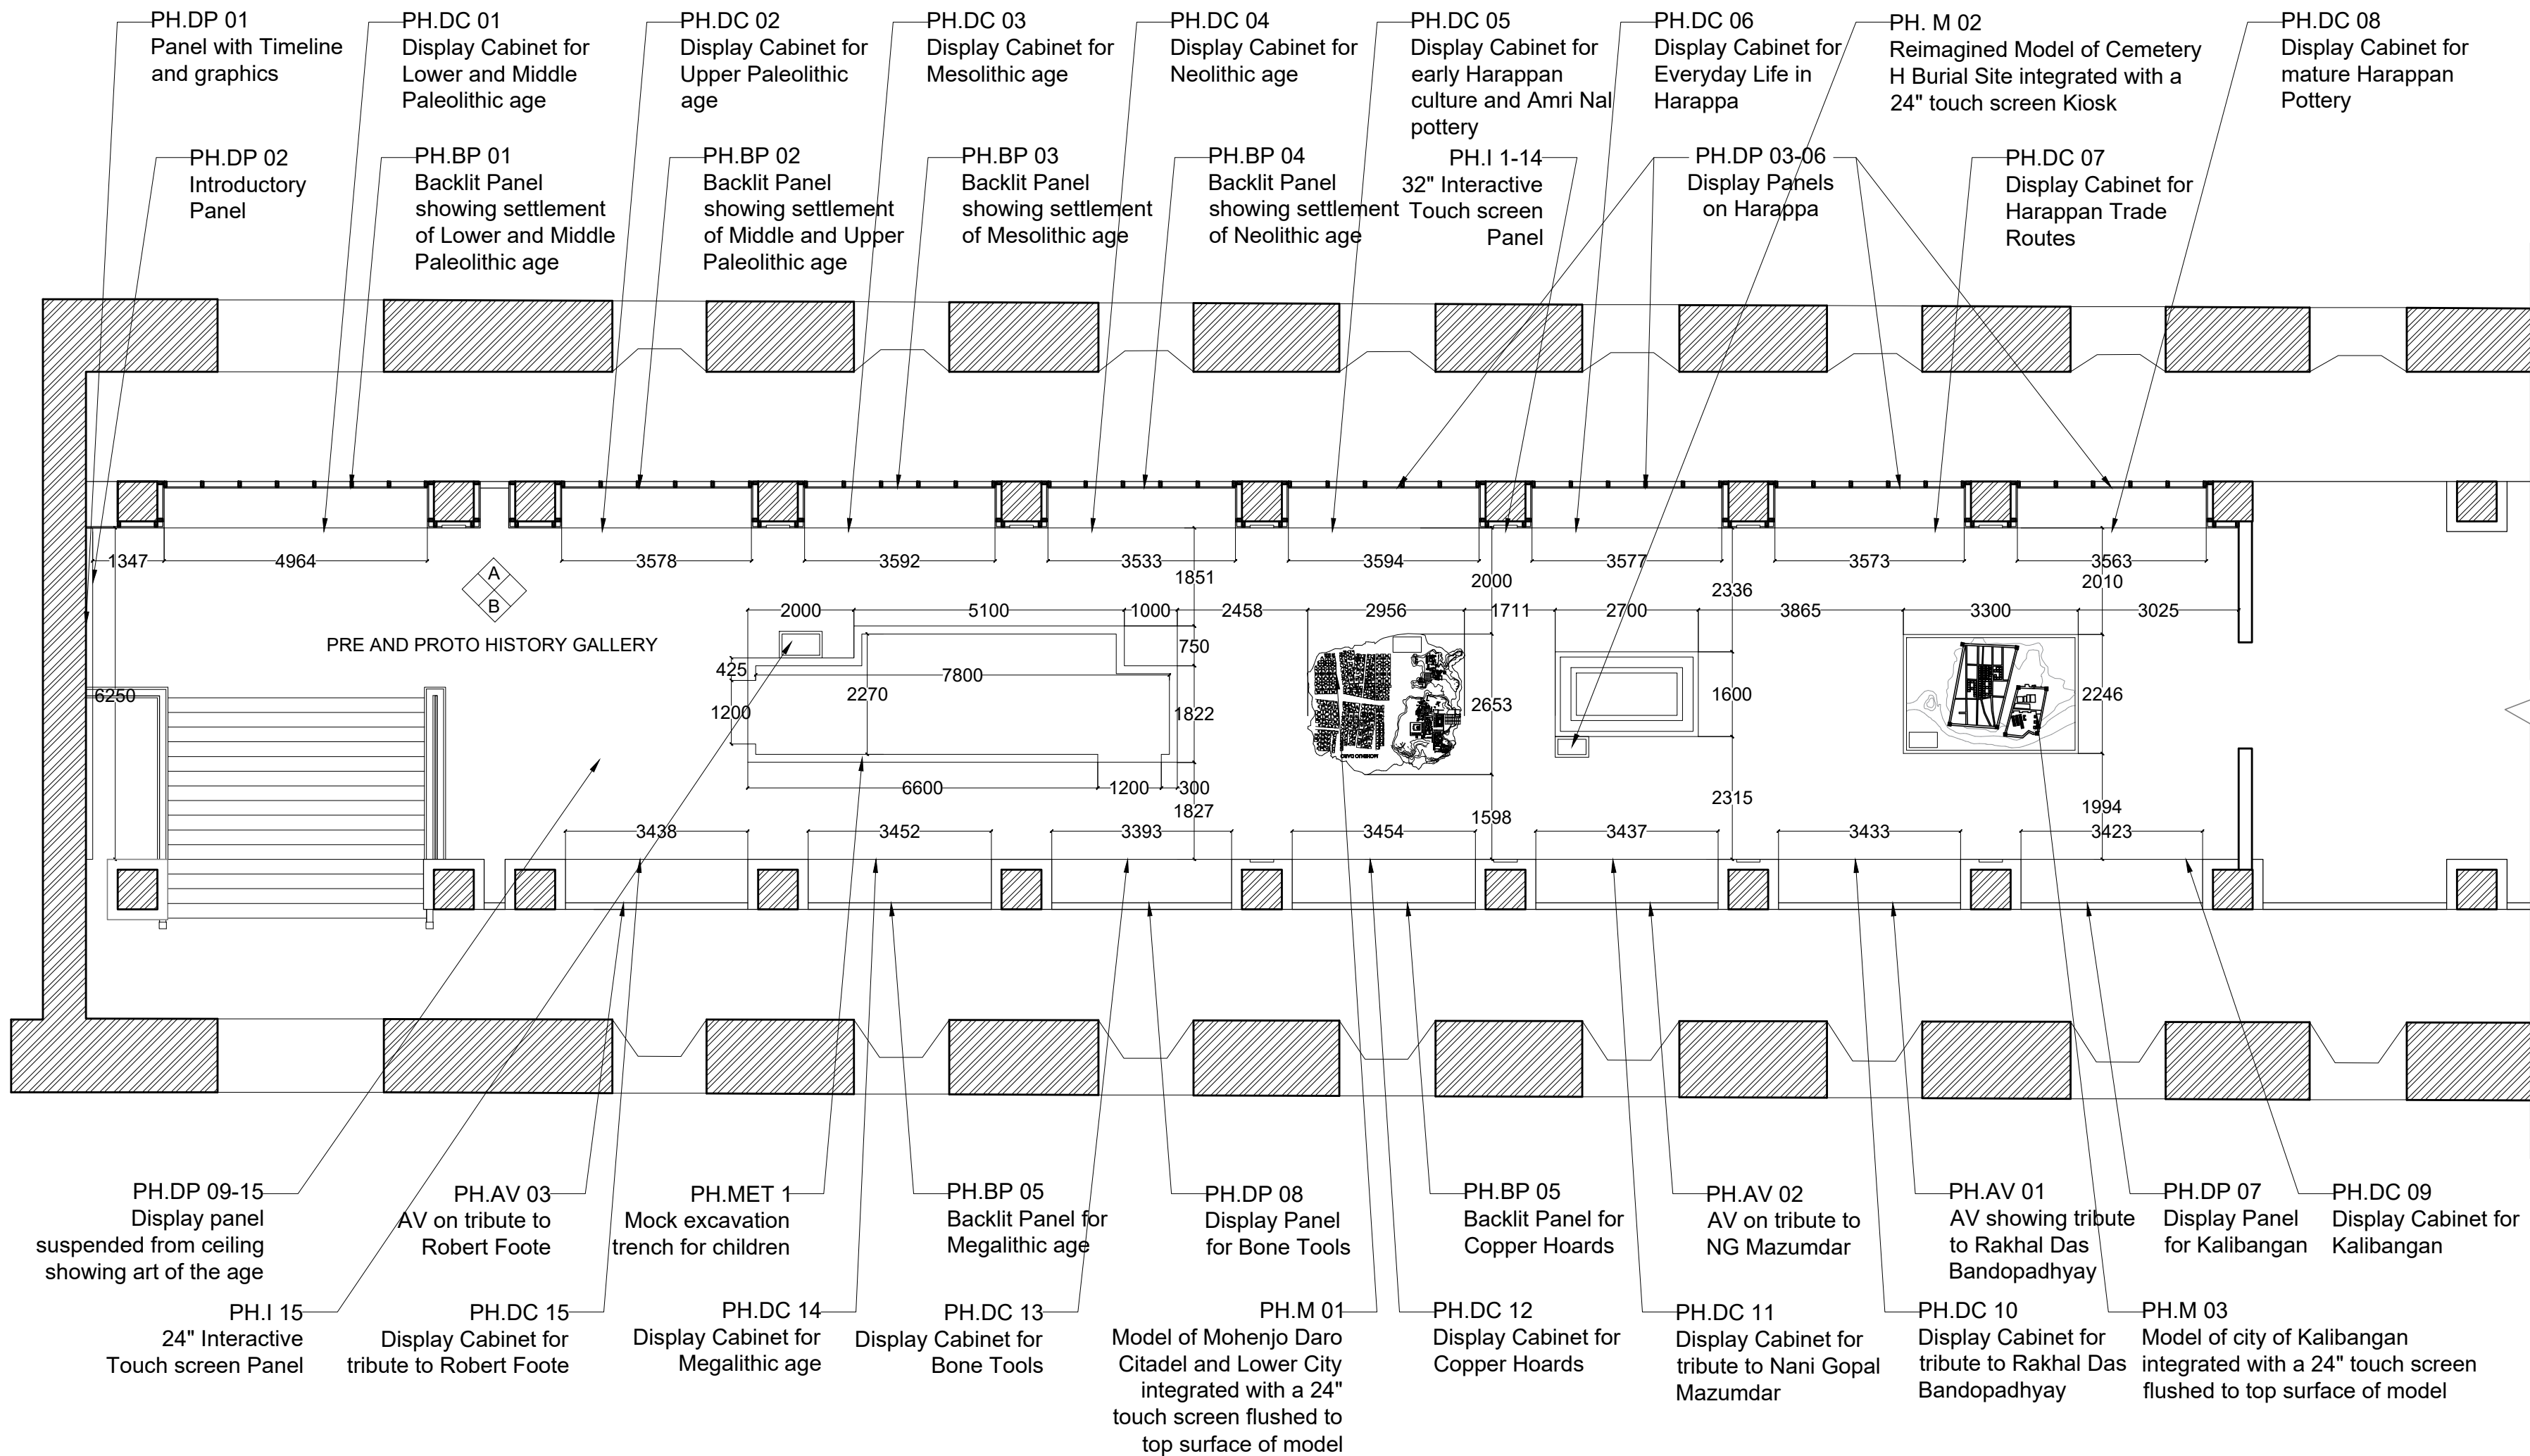

NOTES:

All dimensions are in millimeters

KEY PLAN

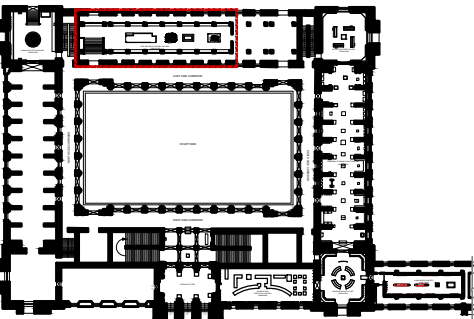

LEGEND

DP	Display Panel
DC	Display Case
DS	Display Shelf
PE	Pedestal
WM	Wall Mural
WG	Wall Graphics
CP	Canvas Painting
M	Model
MET	Mock Excavation Trench
CP	Canvas Painting
AV	Audio Visuals
I	Interactive
P	Projection
HP	Holographic Projection
GS	Gallery Signage
DS	Directional Signage
LG	Logo
RT	Reception Table
CC	Crowd Control Barrier

SCALE: 1:100

0 1m 2m



DRAWING NAME: LAYOUT

GALLERY OF STONE AGE SCULPTURES AND HARAPPAN CIVILIZATION

DRAWN BY: Sohini Pyne

CHECKED BY: Shikha Jain

DRAWING NUMBER: IMK/GF/PH/01

SERIES: Tender Drawings

PROJECT:

PLANNING, CONTENT DEVELOPMENT, DESIGNING, RETROFITTING AND CURATORIAL WORK FOR THE INDIAN MUSEUM, KOLKATA

CLIENT:

INDIAN MUSEUM, KOLKATA

CONSULTANT:


**DRONAH**  
DEVELOPMENT & RESEARCH  
ORGANISATION FOR NATURE,ARTS  
& HERITAGE

A-258, SOUTH CITY-1  
GURGAON-122001

NOTES:

All dimensions are in millimeters

KEY PLAN

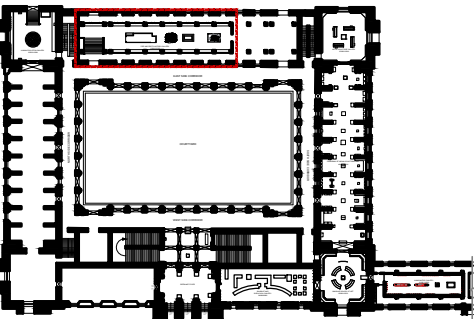

LEGEND

DP	Display Panel
DC	Display Case
DS	Display Shelf
PE	Pedestal
WM	Wall Mural
WG	Wall Graphics
CP	Canvas Painting
M	Model
MET	Mock Excavation Trench
CP	Canvas Painting
AV	Audio Visuals
I	Interactive
P	Projection
HP	Holographic Projection
GS	Gallery Signage
DS	Directional Signage
LG	Logo
RT	Reception Table
CC	Crowd Control Barrier

SCALE: 1:100

0 1m 2m



DRAWING NAME: LAYOUT

GALLERY OF STONE AGE SCULPTURES AND HARAPPAN CIVILIZATION

DRAWN BY: Sohini Pyne

CHECKED BY: Shikha Jain

DRAWING NUMBER: IMK/GF/PH/02

SERIES: Tender Drawings

PROJECT:

PLANNING, CONTENT DEVELOPMENT, DESIGNING, RETROFITTING AND CURATORIAL WORK FOR THE INDIAN MUSEUM, KOLKATA


CLIENT:

INDIAN MUSEUM, KOLKATA


CONSULTANT:

**DRONAH**  
DEVELOPMENT & RESEARCH  
ORGANISATION FOR NATURE,ARTS  
& HERITAGE

A-258, SOUTH CITY-1  
GURGAON-122001

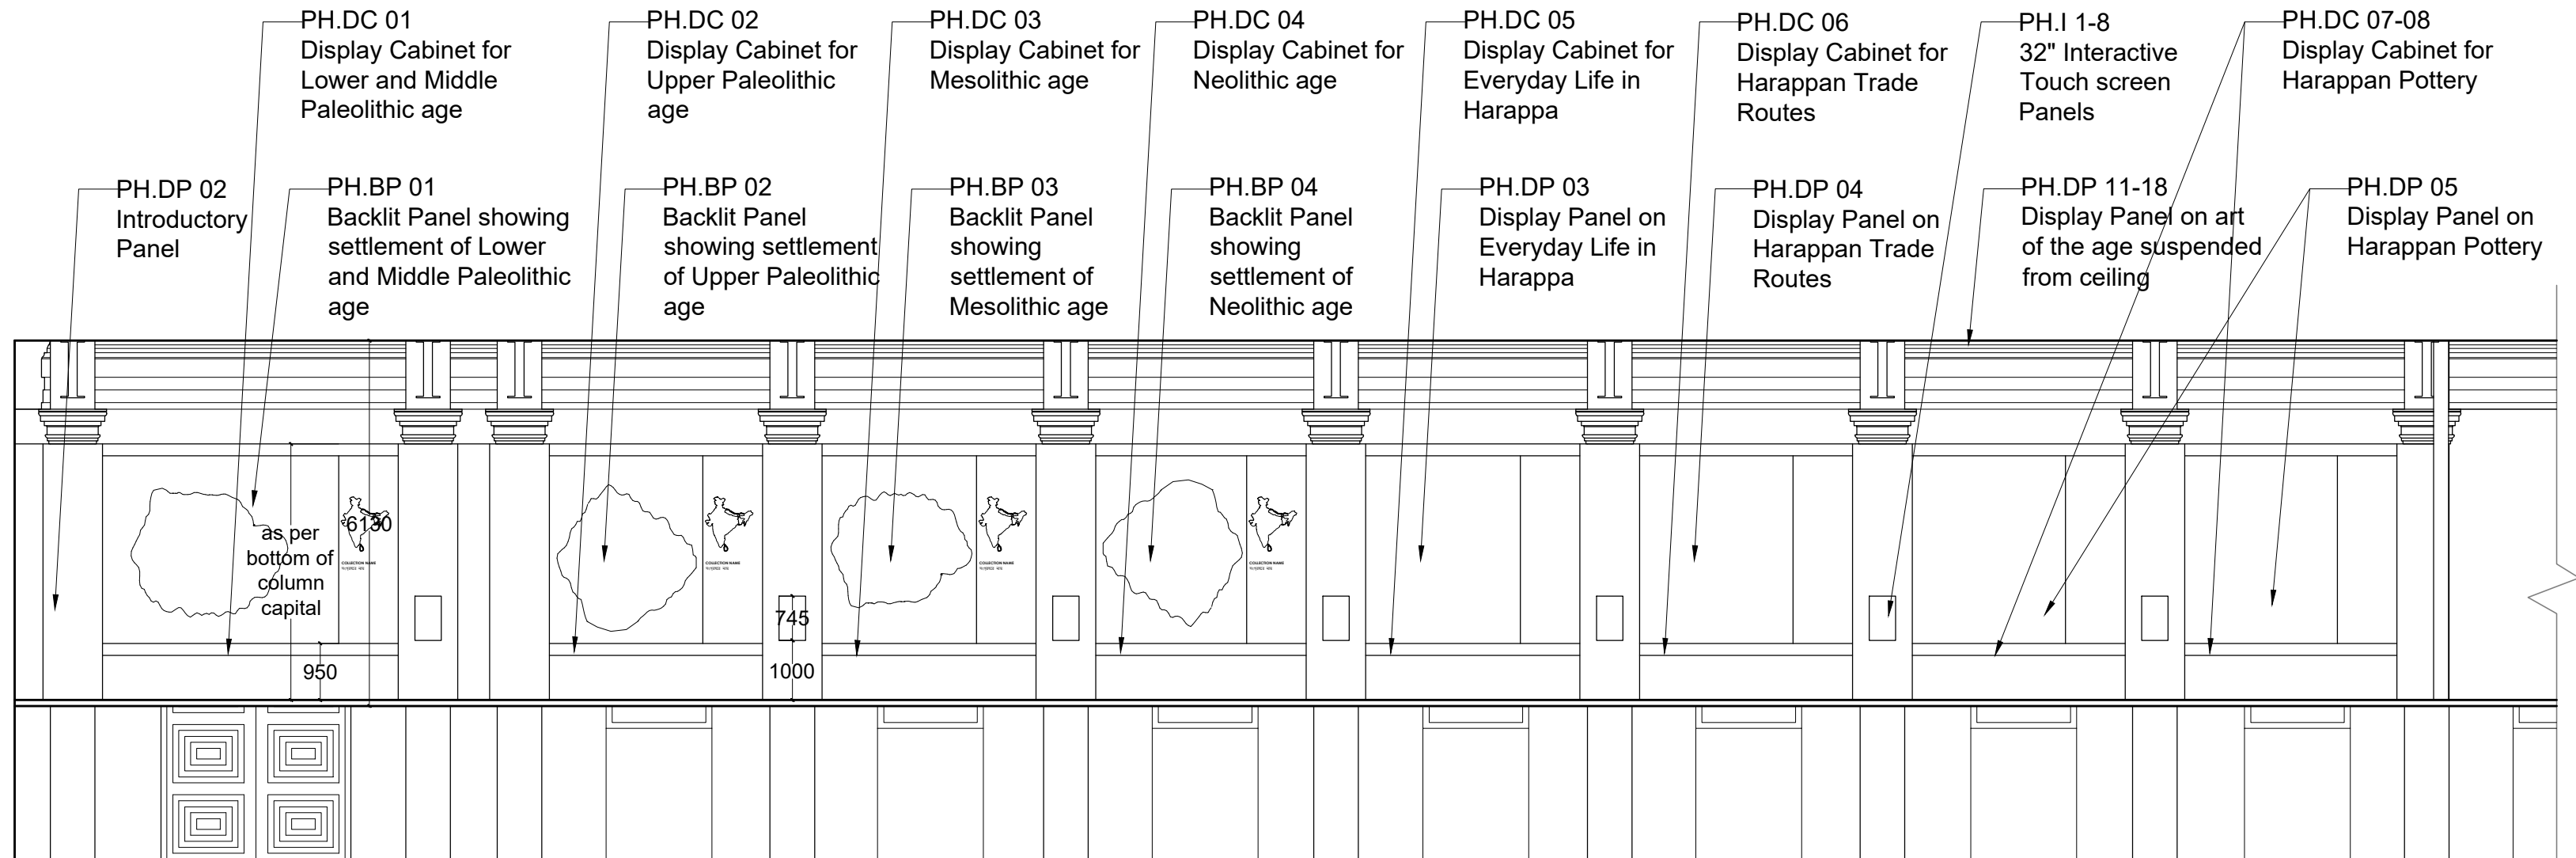


ELEVATION A

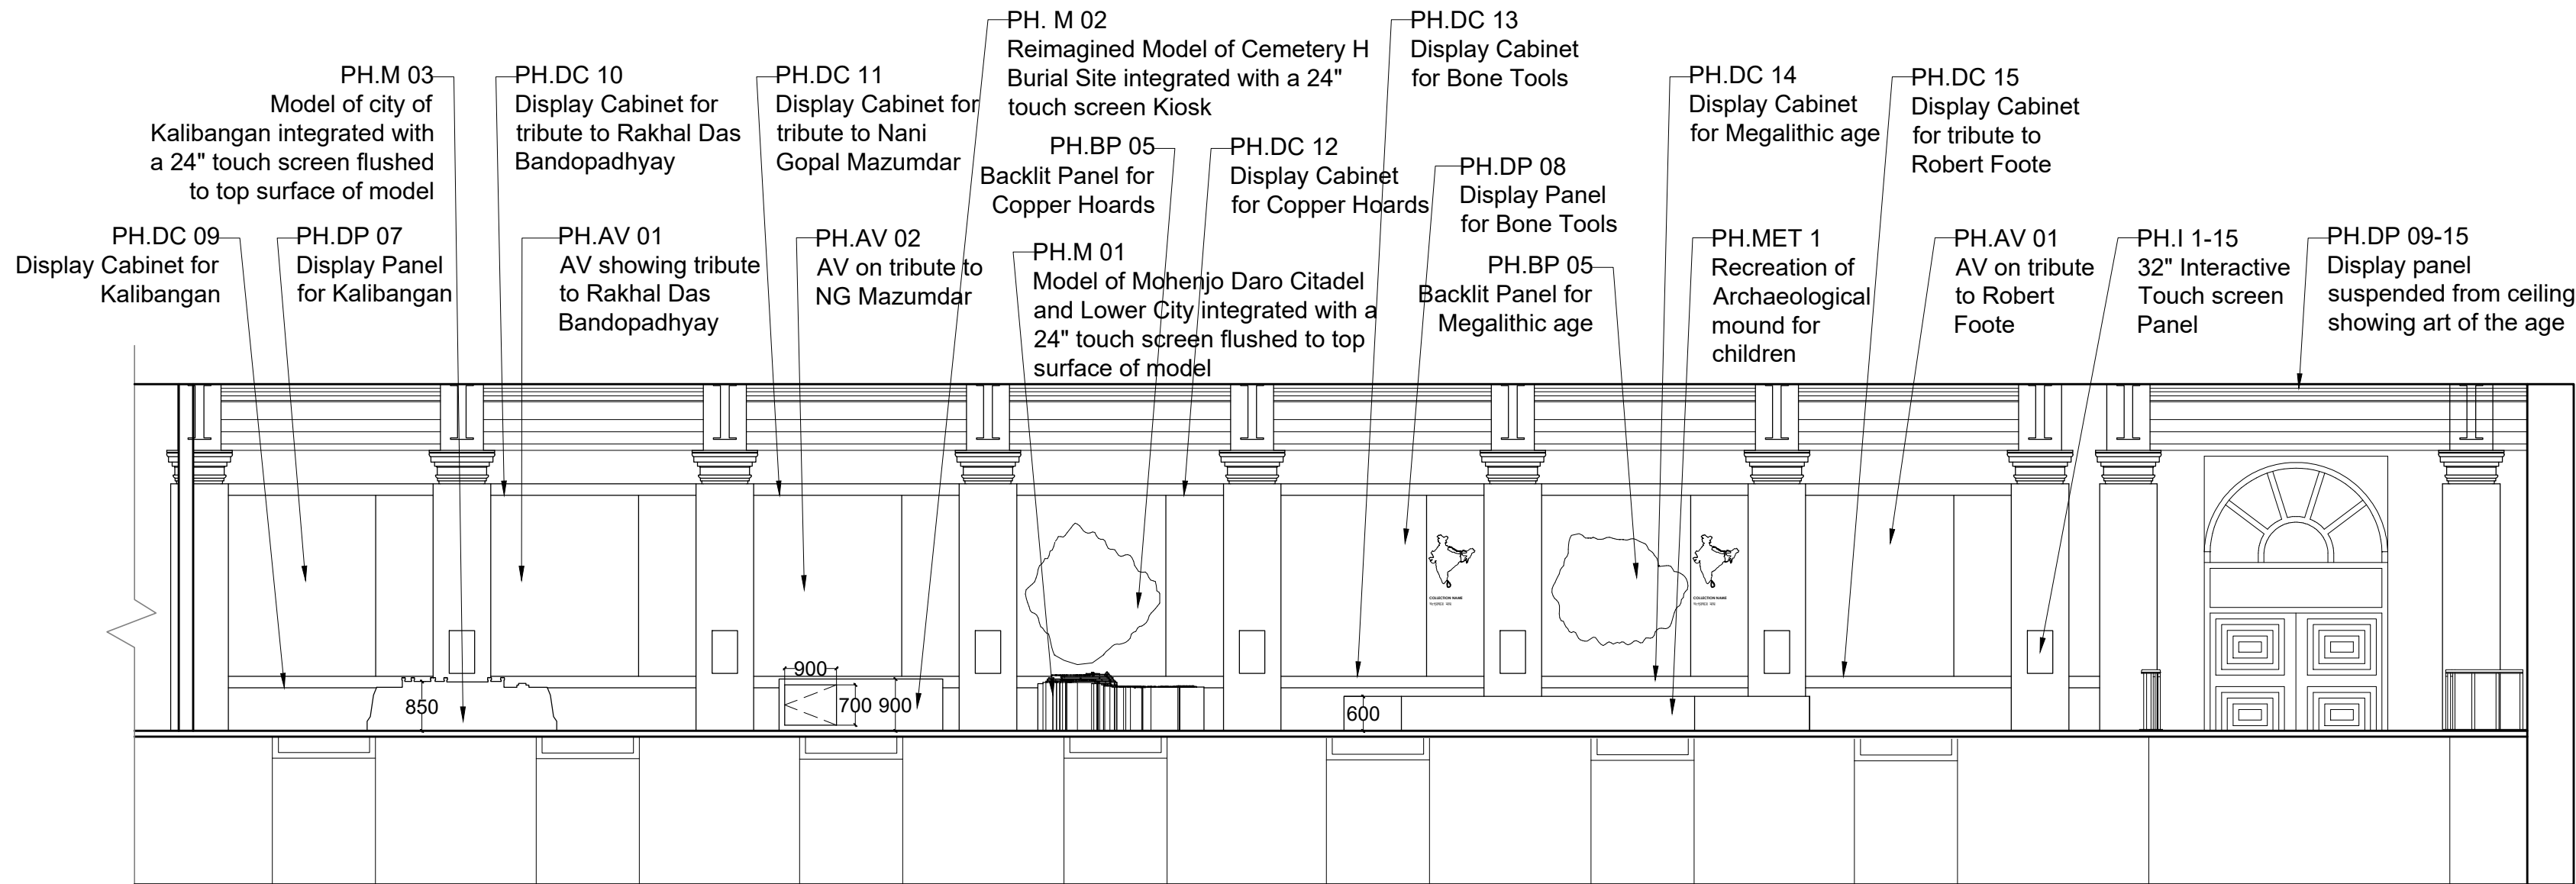


ELEVATION B



DETAIL MS. DC 5-9, 13, 15

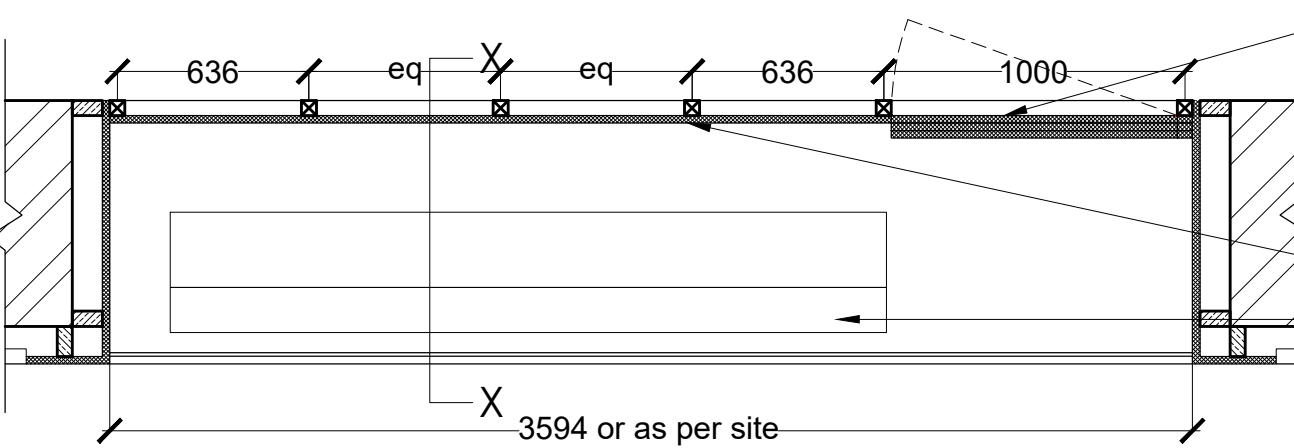

PLAN @ AA'

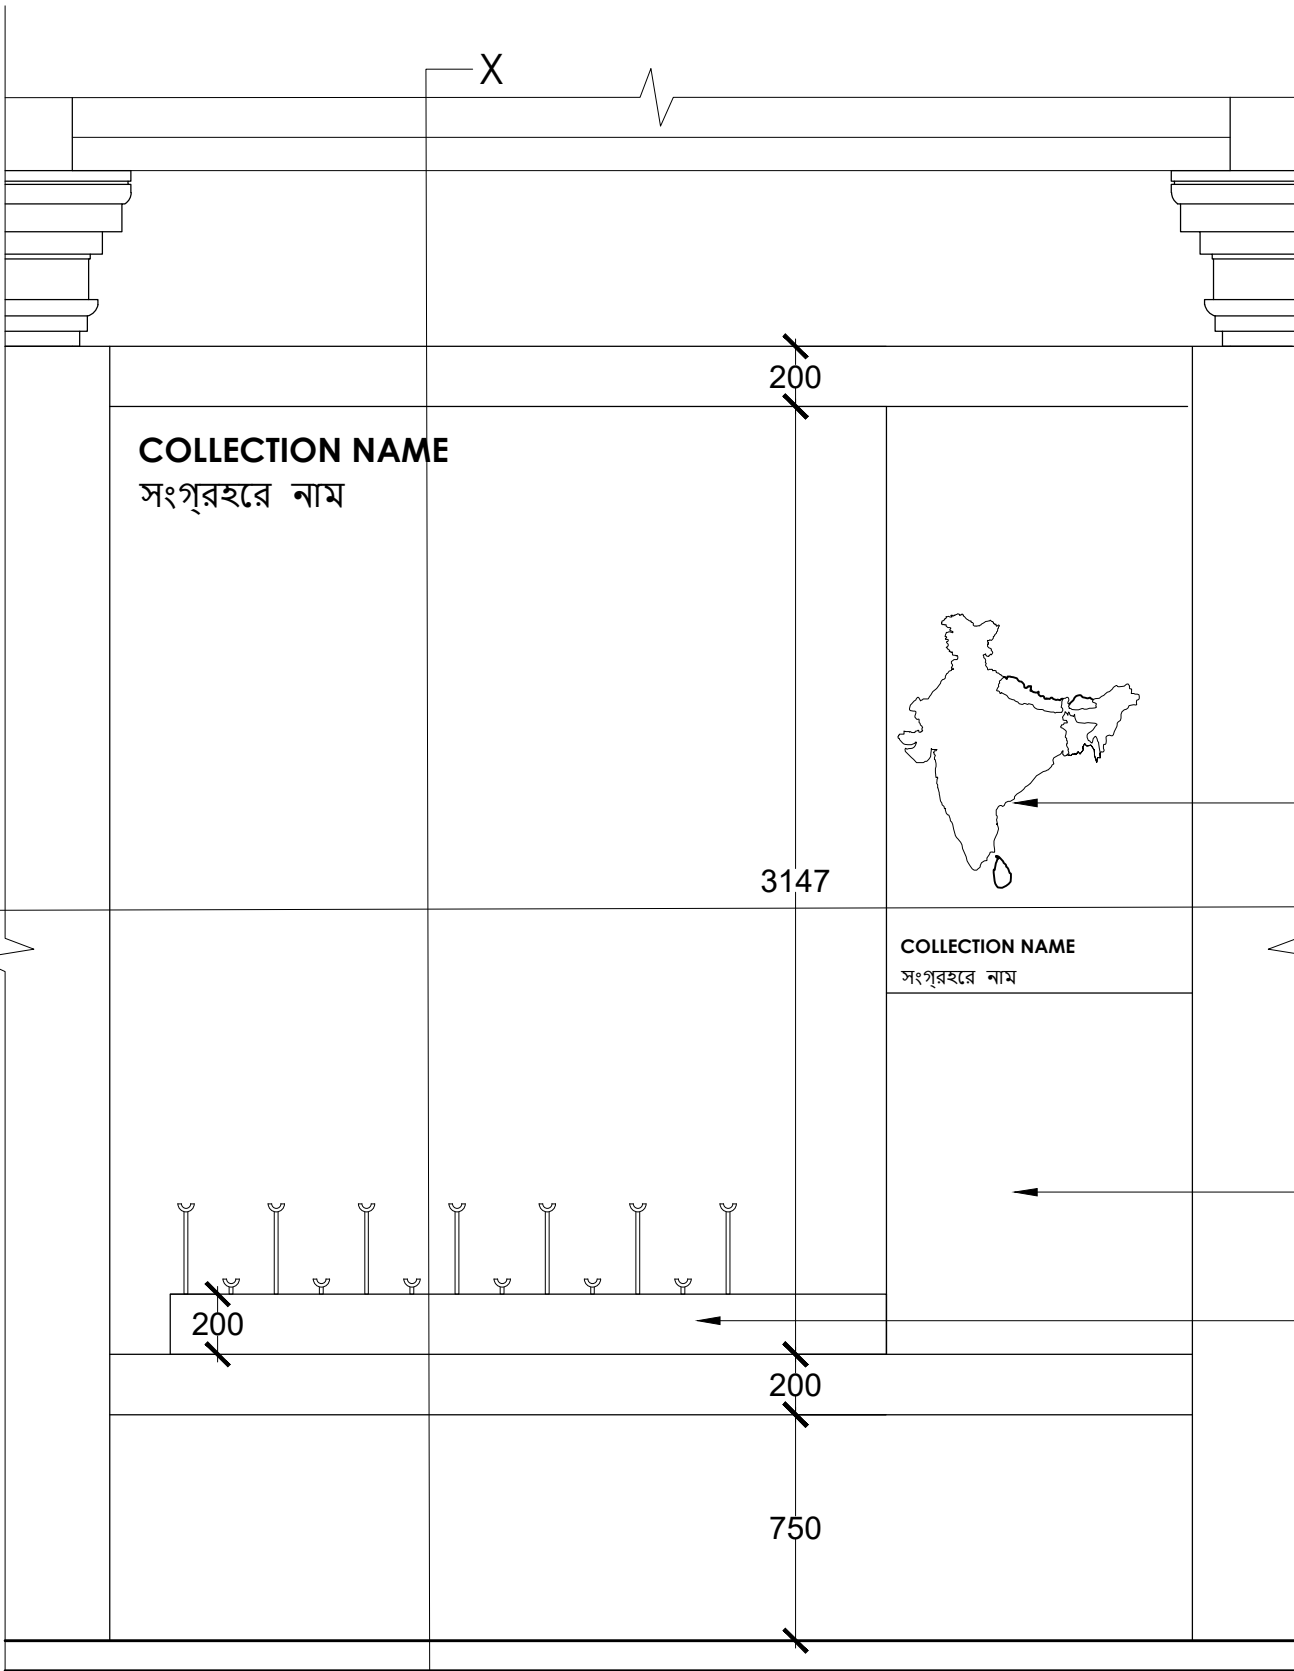

FRONT ELEVATION


COLLECTION NAME  
সংগ্রহের নাম



COLLECTION NAME  
সংগ্রহের নাম

Vinyl printed  
text and  
graphics

Horizontally  
openable  
panel  
Matt acrylic  
pedestal

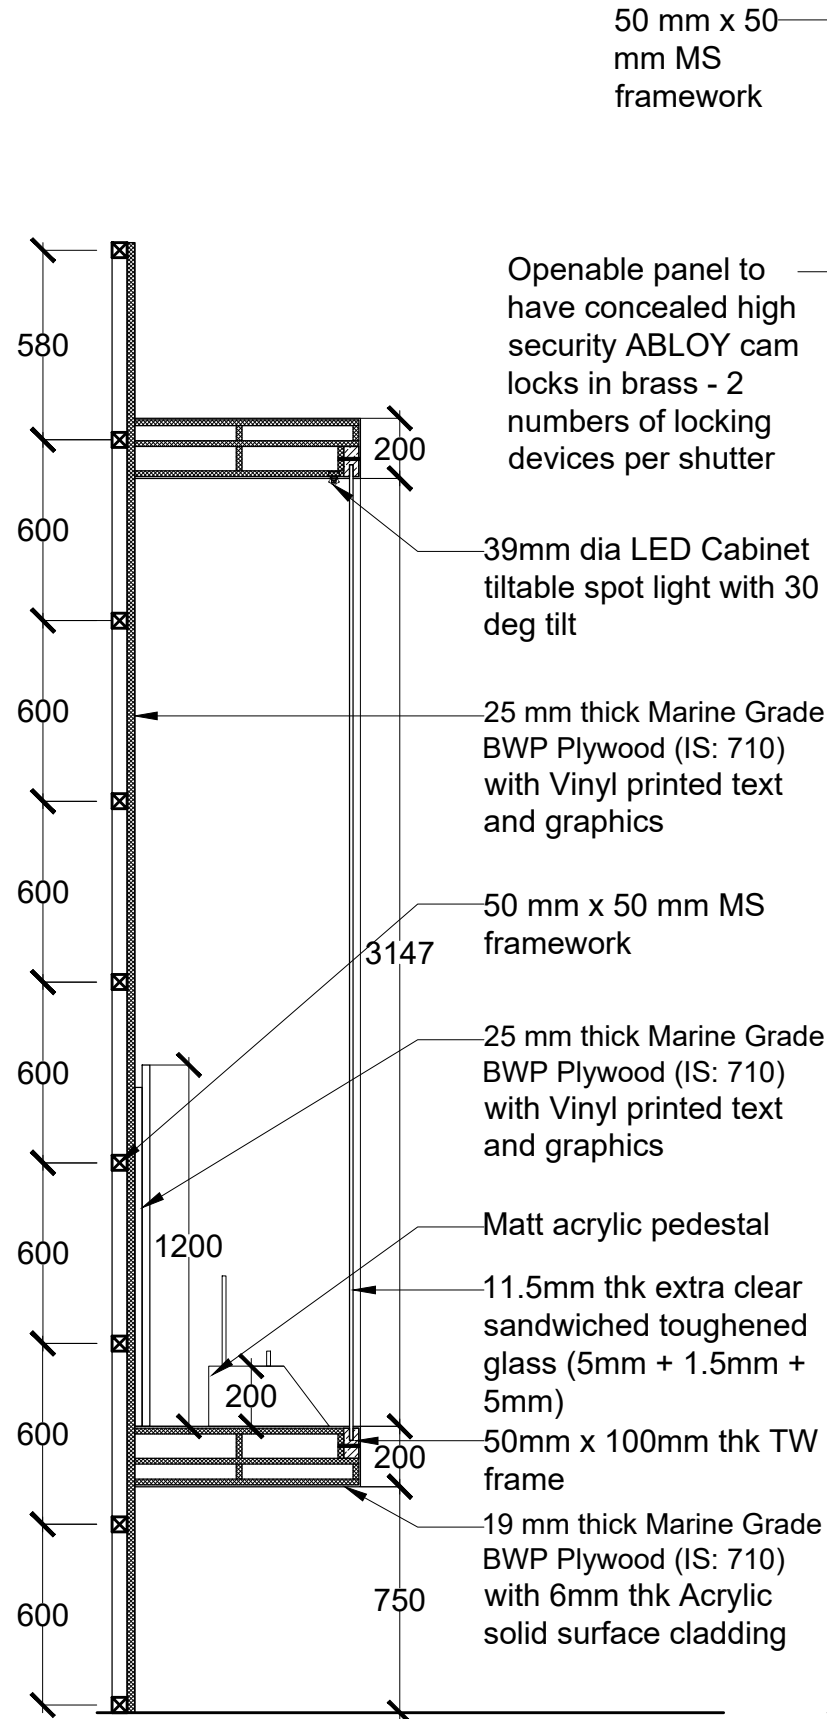

SECTION XX'

50 mm x 50  
mm MS  
framework

Openable panel to  
have concealed high  
security ABLOY cam  
locks in brass - 2  
numbers of locking  
devices per shutter

39mm dia LED Cabinet  
tiltable spot light with 30  
deg tilt

25 mm thick Marine Grade  
BWP Plywood (IS: 710)  
with Vinyl printed text  
and graphics

50 mm x 50 mm MS  
framework


25 mm thick Marine Grade  
BWP Plywood (IS: 710)  
with Vinyl printed text  
and graphics

Matt acrylic pedestal

11.5mm thk extra clear  
sandwiched toughened  
glass (5mm + 1.5mm +  
5mm)

50mm x 100mm thk TW  
frame

19 mm thick Marine Grade  
BWP Plywood (IS: 710)  
with 6mm thk Acrylic  
solid surface cladding

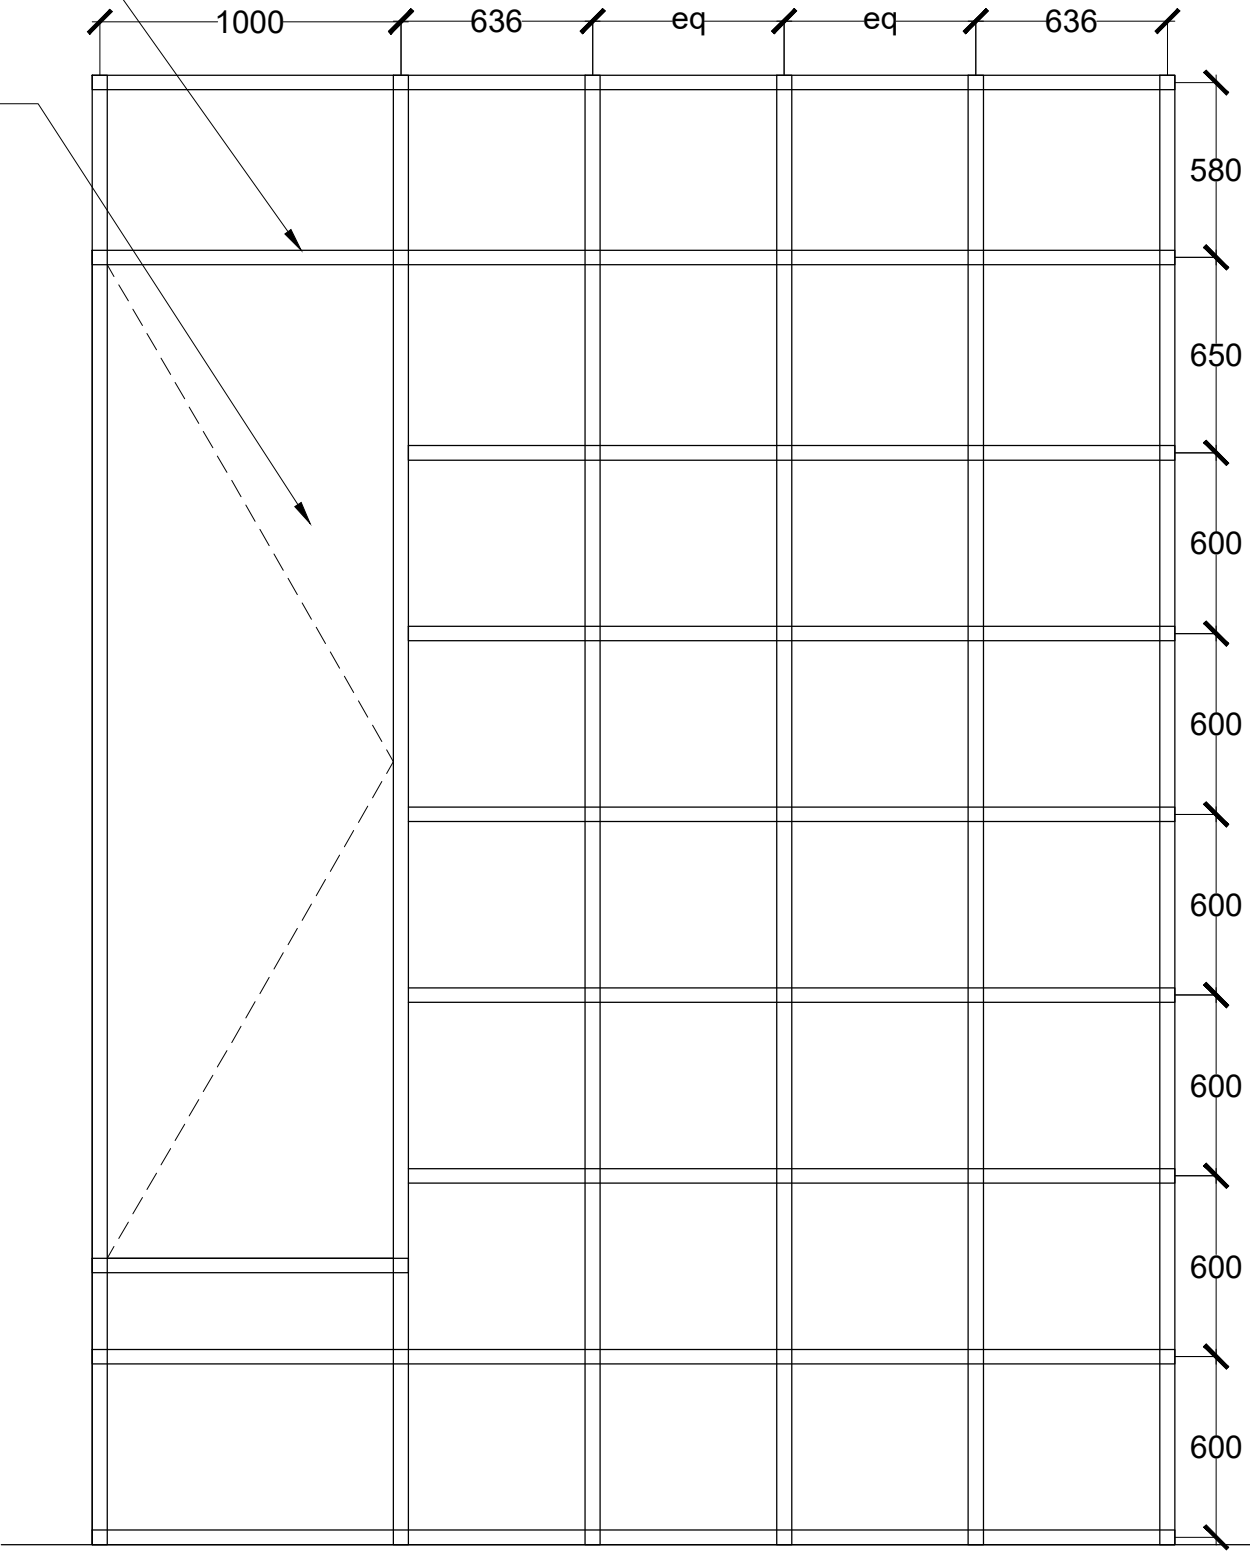


REAR ELEVATION

NOTES:

All dimensions are in millimeters

KEY PLAN

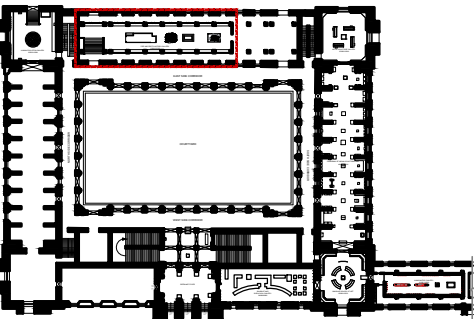

LEGEND

DP	Display Panel
DC	Display Case
DS	Display Shelf
PE	Pedestal
WM	Wall Mural
WG	Wall Graphics
CP	Canvas Painting
M	Model
MET	Mock Excavation Trench
CP	Canvas Painting
AV	Audio Visuals
I	Interactive
P	Projection
HP	Holographic Projection
GS	Gallery Signage
DS	Directional Signage
LG	Logo
RT	Reception Table
CC	Crowd Control Barrier

SCALE: 1:100

0 1m 2m



NORTH

DRAWING NAME: LAYOUT

GALLERY OF STONE AGE SCULPTURES AND  
HARAPPAN CIVILIZATION

DRAWN BY: Sohini Pyne

CHECKED BY: Shikha Jain

DRAWING NUMBER: IMK/GF/PH/03

SERIES: Tender Drawings

PROJECT:

PLANNING, CONTENT  
DEVELOPMENT, DESIGNING,  
RETROFITTING AND CURATORIAL  
WORK FOR THE INDIAN MUSEUM,  
KOLKATA

CLIENT:

INDIAN MUSEUM, KOLKATA

CONSULTANT:

**DRONAH**  
DEVELOPMENT & RESEARCH  
ORGANISATION FOR NATURE,ARTS  
& HERITAGE

A-258, SOUTH CITY-1  
GURGAON-122001



Architectural drawing of a museum gallery layout. The layout includes a large central display area with dimensions 1500 x 2000, a smaller display area with dimensions 200 x 750, and a reception area with dimensions 200 x 200. The drawing also shows a map of India with a red dot indicating the location of the collection, and a scale bar labeled 'X'.

- Openable panel to have concealed high security ABLOY cam locks in brass - 2 numbers of locking devices per shutter
- Backlit acrylic Panel
- Matt acrylic pedestal

50 mm x 50 mm MS framework

Openable panel to have concealed high security ABLOY cam locks in brass - 2 numbers of locking devices per shutter

580

200

600

39mm dia LED Cabinet tiltable spot light with 30 deg tilt

25 mm thick Marine Grade BWP Plywood (IS: 710)

Backlit Fabric light box with LED Light strip faced with printed fabric

3147

19mm thick Marine Grade BWP Plywood (IS: 710) with Vinyl printed text and graphics

Matte acrylic pedestal

11.5mm thk extra clear sandwiched toughened glass (5mm + 1.5mm + 5mm)

50mm x 100mm thk TW frame

19 mm thick BWP Ply with 6mm thk Acrylic solid surface cladding

750

50 mm x 50 mm MS framework

The diagram shows a 10x10 grid. A dashed line starts at the top-left corner (0,0) and ends at the bottom-right corner (9,9). Two arrows point from the top-left corner towards the dashed line, indicating the direction of the path.

<b>DP</b>	Display Panel
<b>DC</b>	Display Case
<b>DS</b>	Display Shelf
<b>PE</b>	Pedestal
<b>WM</b>	Wall Mural
<b>WG</b>	Wall Graphics
<b>CP</b>	Canvas Painting
<b>M</b>	Model
<b>MET</b>	Mock Excavation Trench
<b>CP</b>	Canvas Painting
<b>AV</b>	Audio Visuals
<b>I</b>	Interactive
<b>P</b>	Projection
<b>HP</b>	Holographic Projection
<b>GS</b>	Gallery Signage
<b>DS</b>	Directional Signage
<b>LG</b>	Logo
<b>RT</b>	Reception Table
<b>CC</b>	Crowd Control Barrier




**NORTH**


**DRAWING NUMBER: IMK/GF/PH/04**

A-258, SOUTH CITY-1  
GURGAON-122001


DETAIL MS. DC 10, 11, 15 - DISPLAY CASE WITH PROJECTION SYSTEM

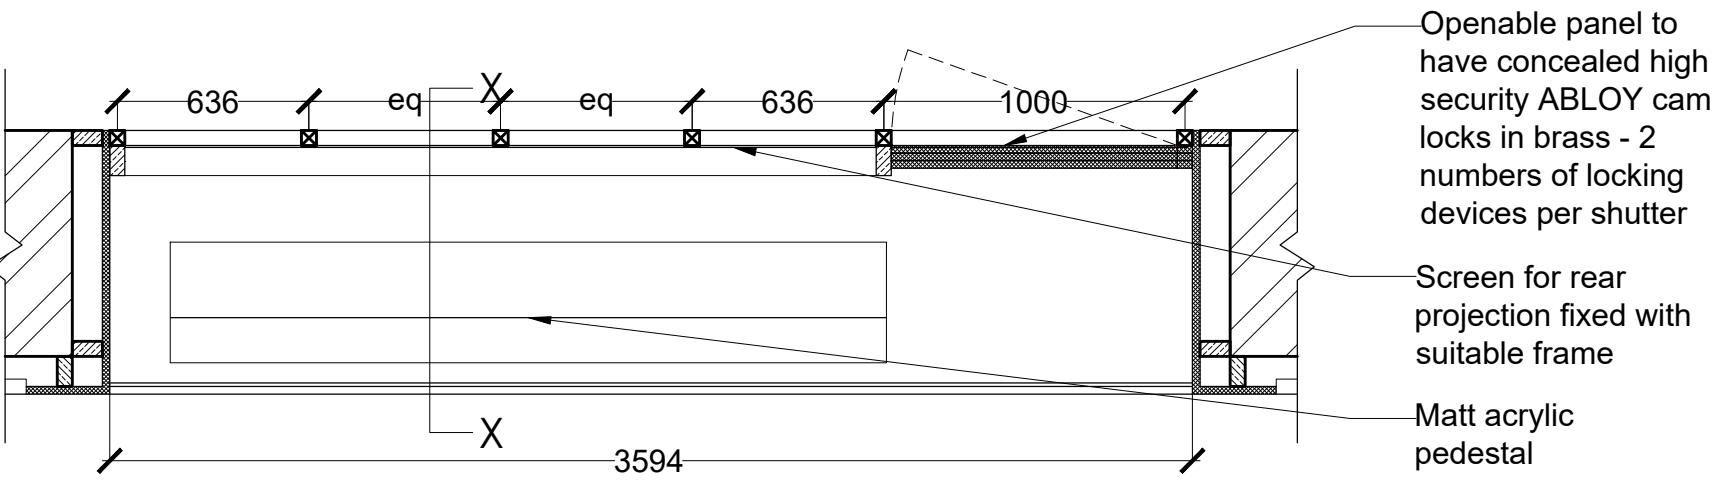


PLAN @ AA'

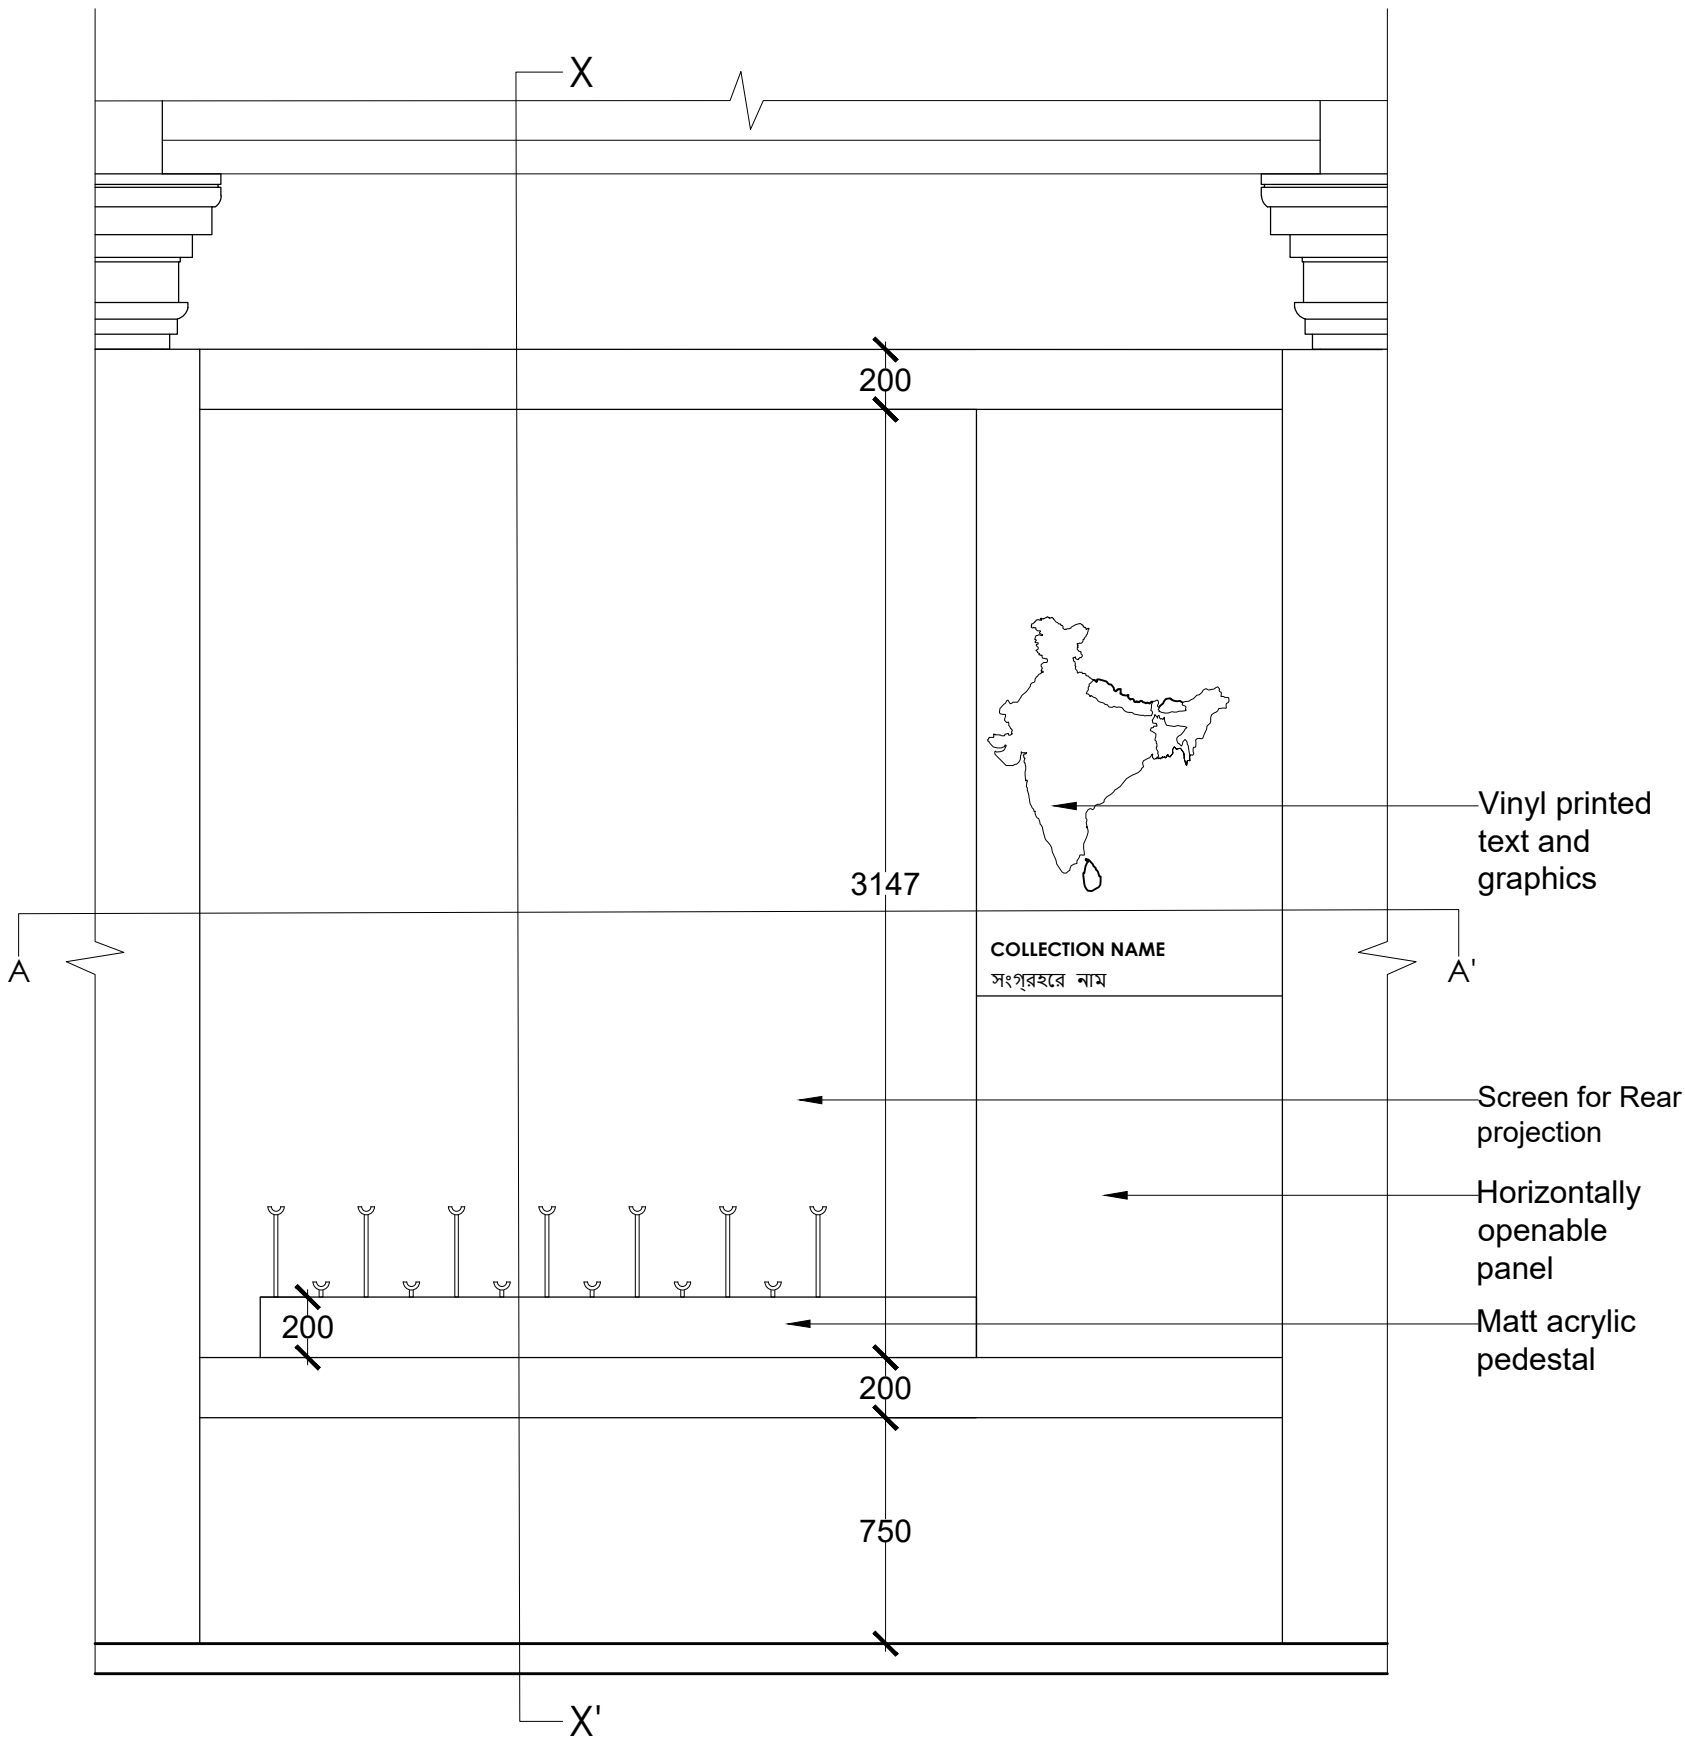

FRONT ELEVATION

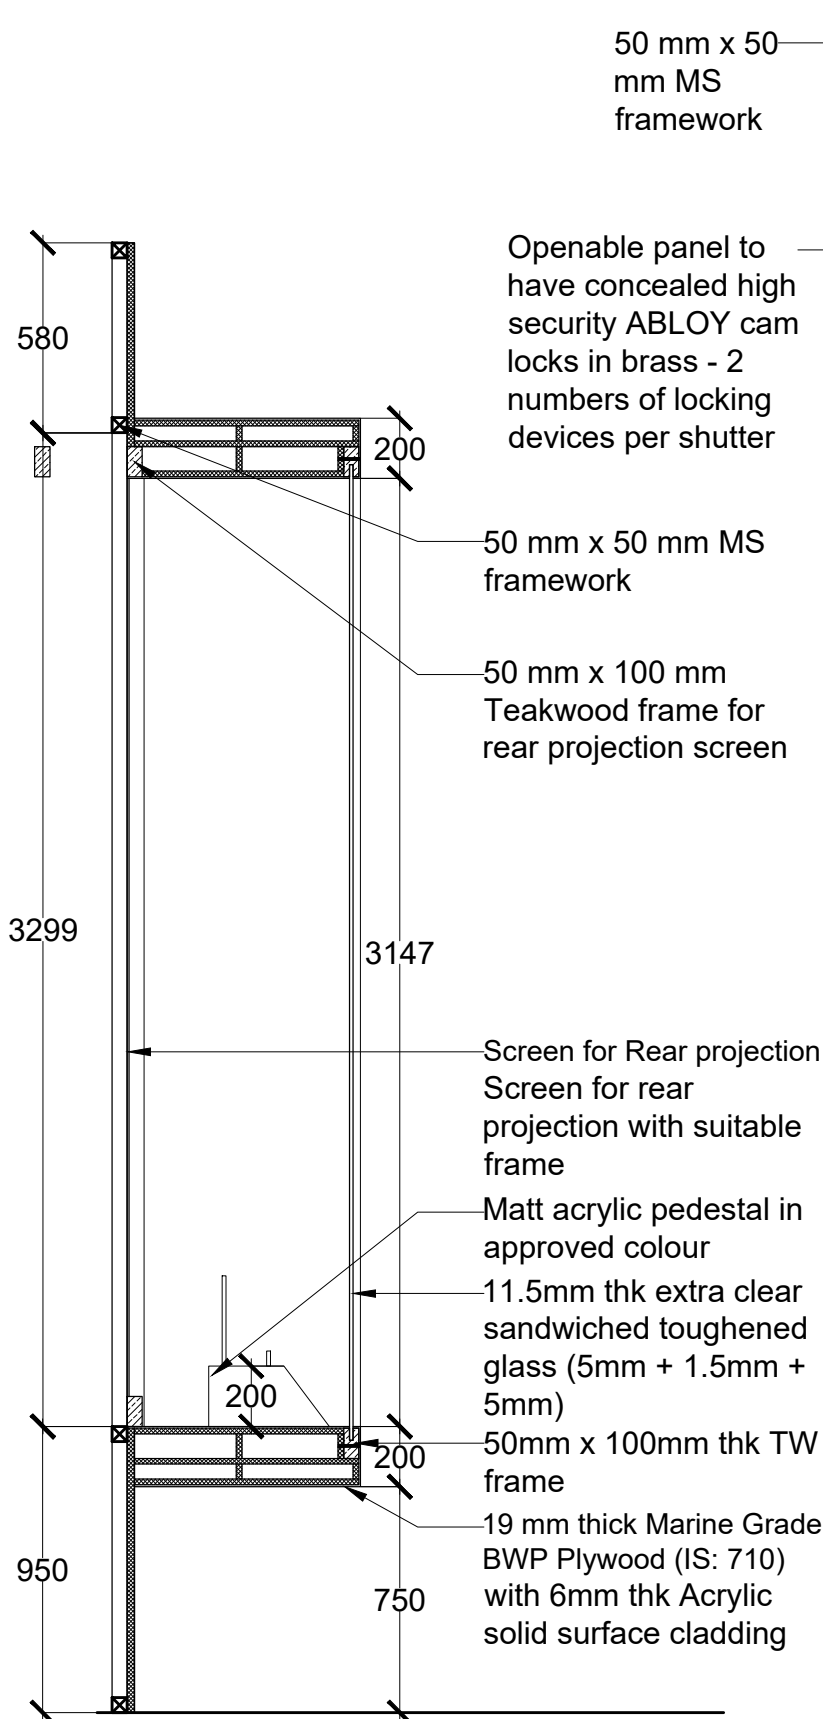

SECTION XX'

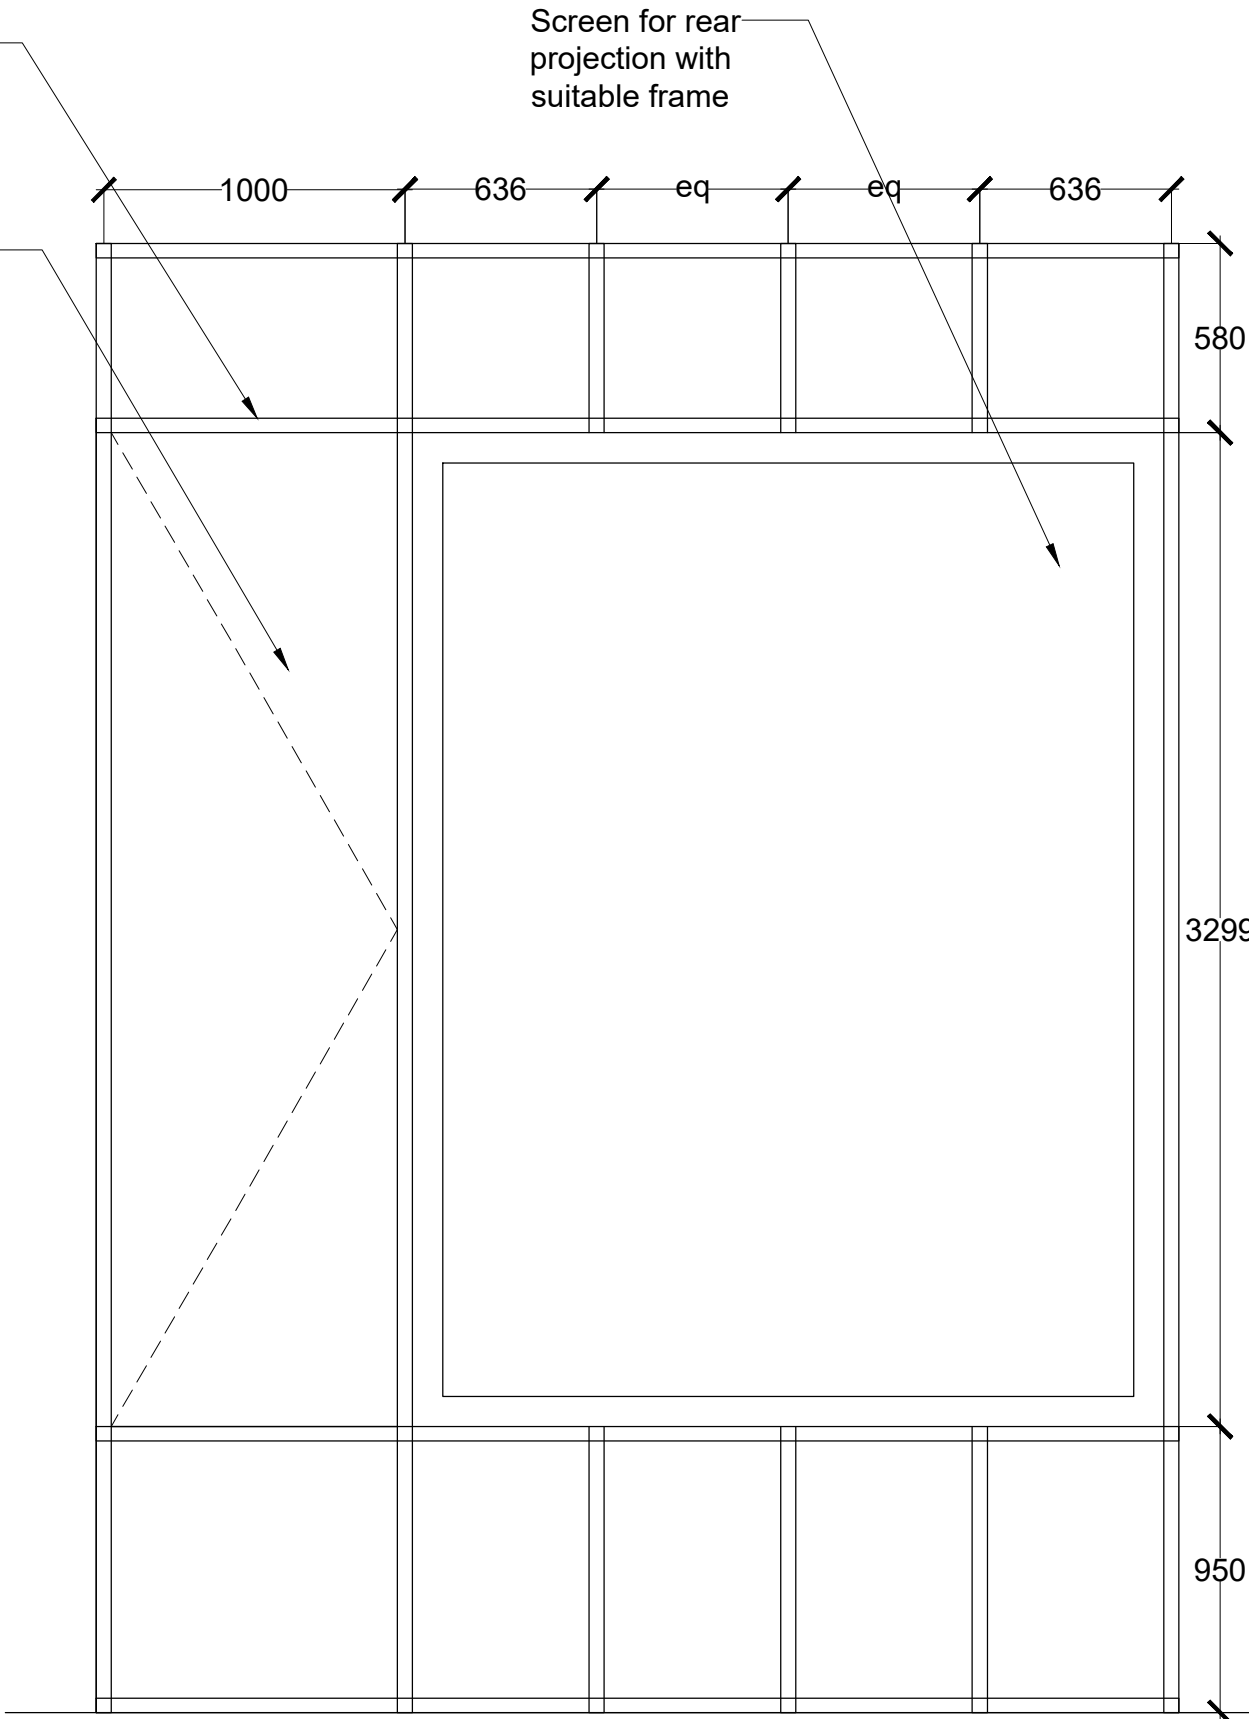


REAR ELEVATION

NOTES:

All dimensions are in millimeters

KEY PLAN

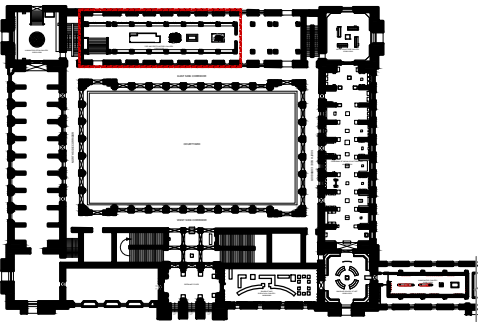

LEGEND

DP	Display Panel
DC	Display Case
DS	Display Shelf
PE	Pedestal
WM	Wall Mural
WG	Wall Graphics
CP	Canvas Painting
M	Model
MET	Mock Excavation Trench
CP	Canvas Painting
AV	Audio Visuals
I	Interactive
P	Projection
HP	Holographic Projection
GS	Gallery Signage
DS	Directional Signage
LG	Logo
RT	Reception Table
CC	Crowd Control Barrier

SCALE: 1:100

0 1m 2m



NORTH

DRAWING NAME: LAYOUT

GALLERY OF STONE AGE SCULPTURES AND HARAPPAN CIVILIZATION

DRAWN BY: Sohini Pyne

CHECKED BY: Shikha Jain

DRAWING NUMBER: IMK/GF/PH/05

SERIES: Tender Drawings

PROJECT:

PLANNING, CONTENT DEVELOPMENT, DESIGNING, RETROFITTING AND CURATORIAL WORK FOR THE INDIAN MUSEUM, KOLKATA

CLIENT:


INDIAN MUSEUM, KOLKATA

CONSULTANT:


**DRONAH**  
DEVELOPMENT & RESEARCH  
ORGANISATION FOR NATURE,ARTS  
& HERITAGE

A-258, SOUTH CITY-1  
GURGAON-122001


DETAIL MS. MET 1

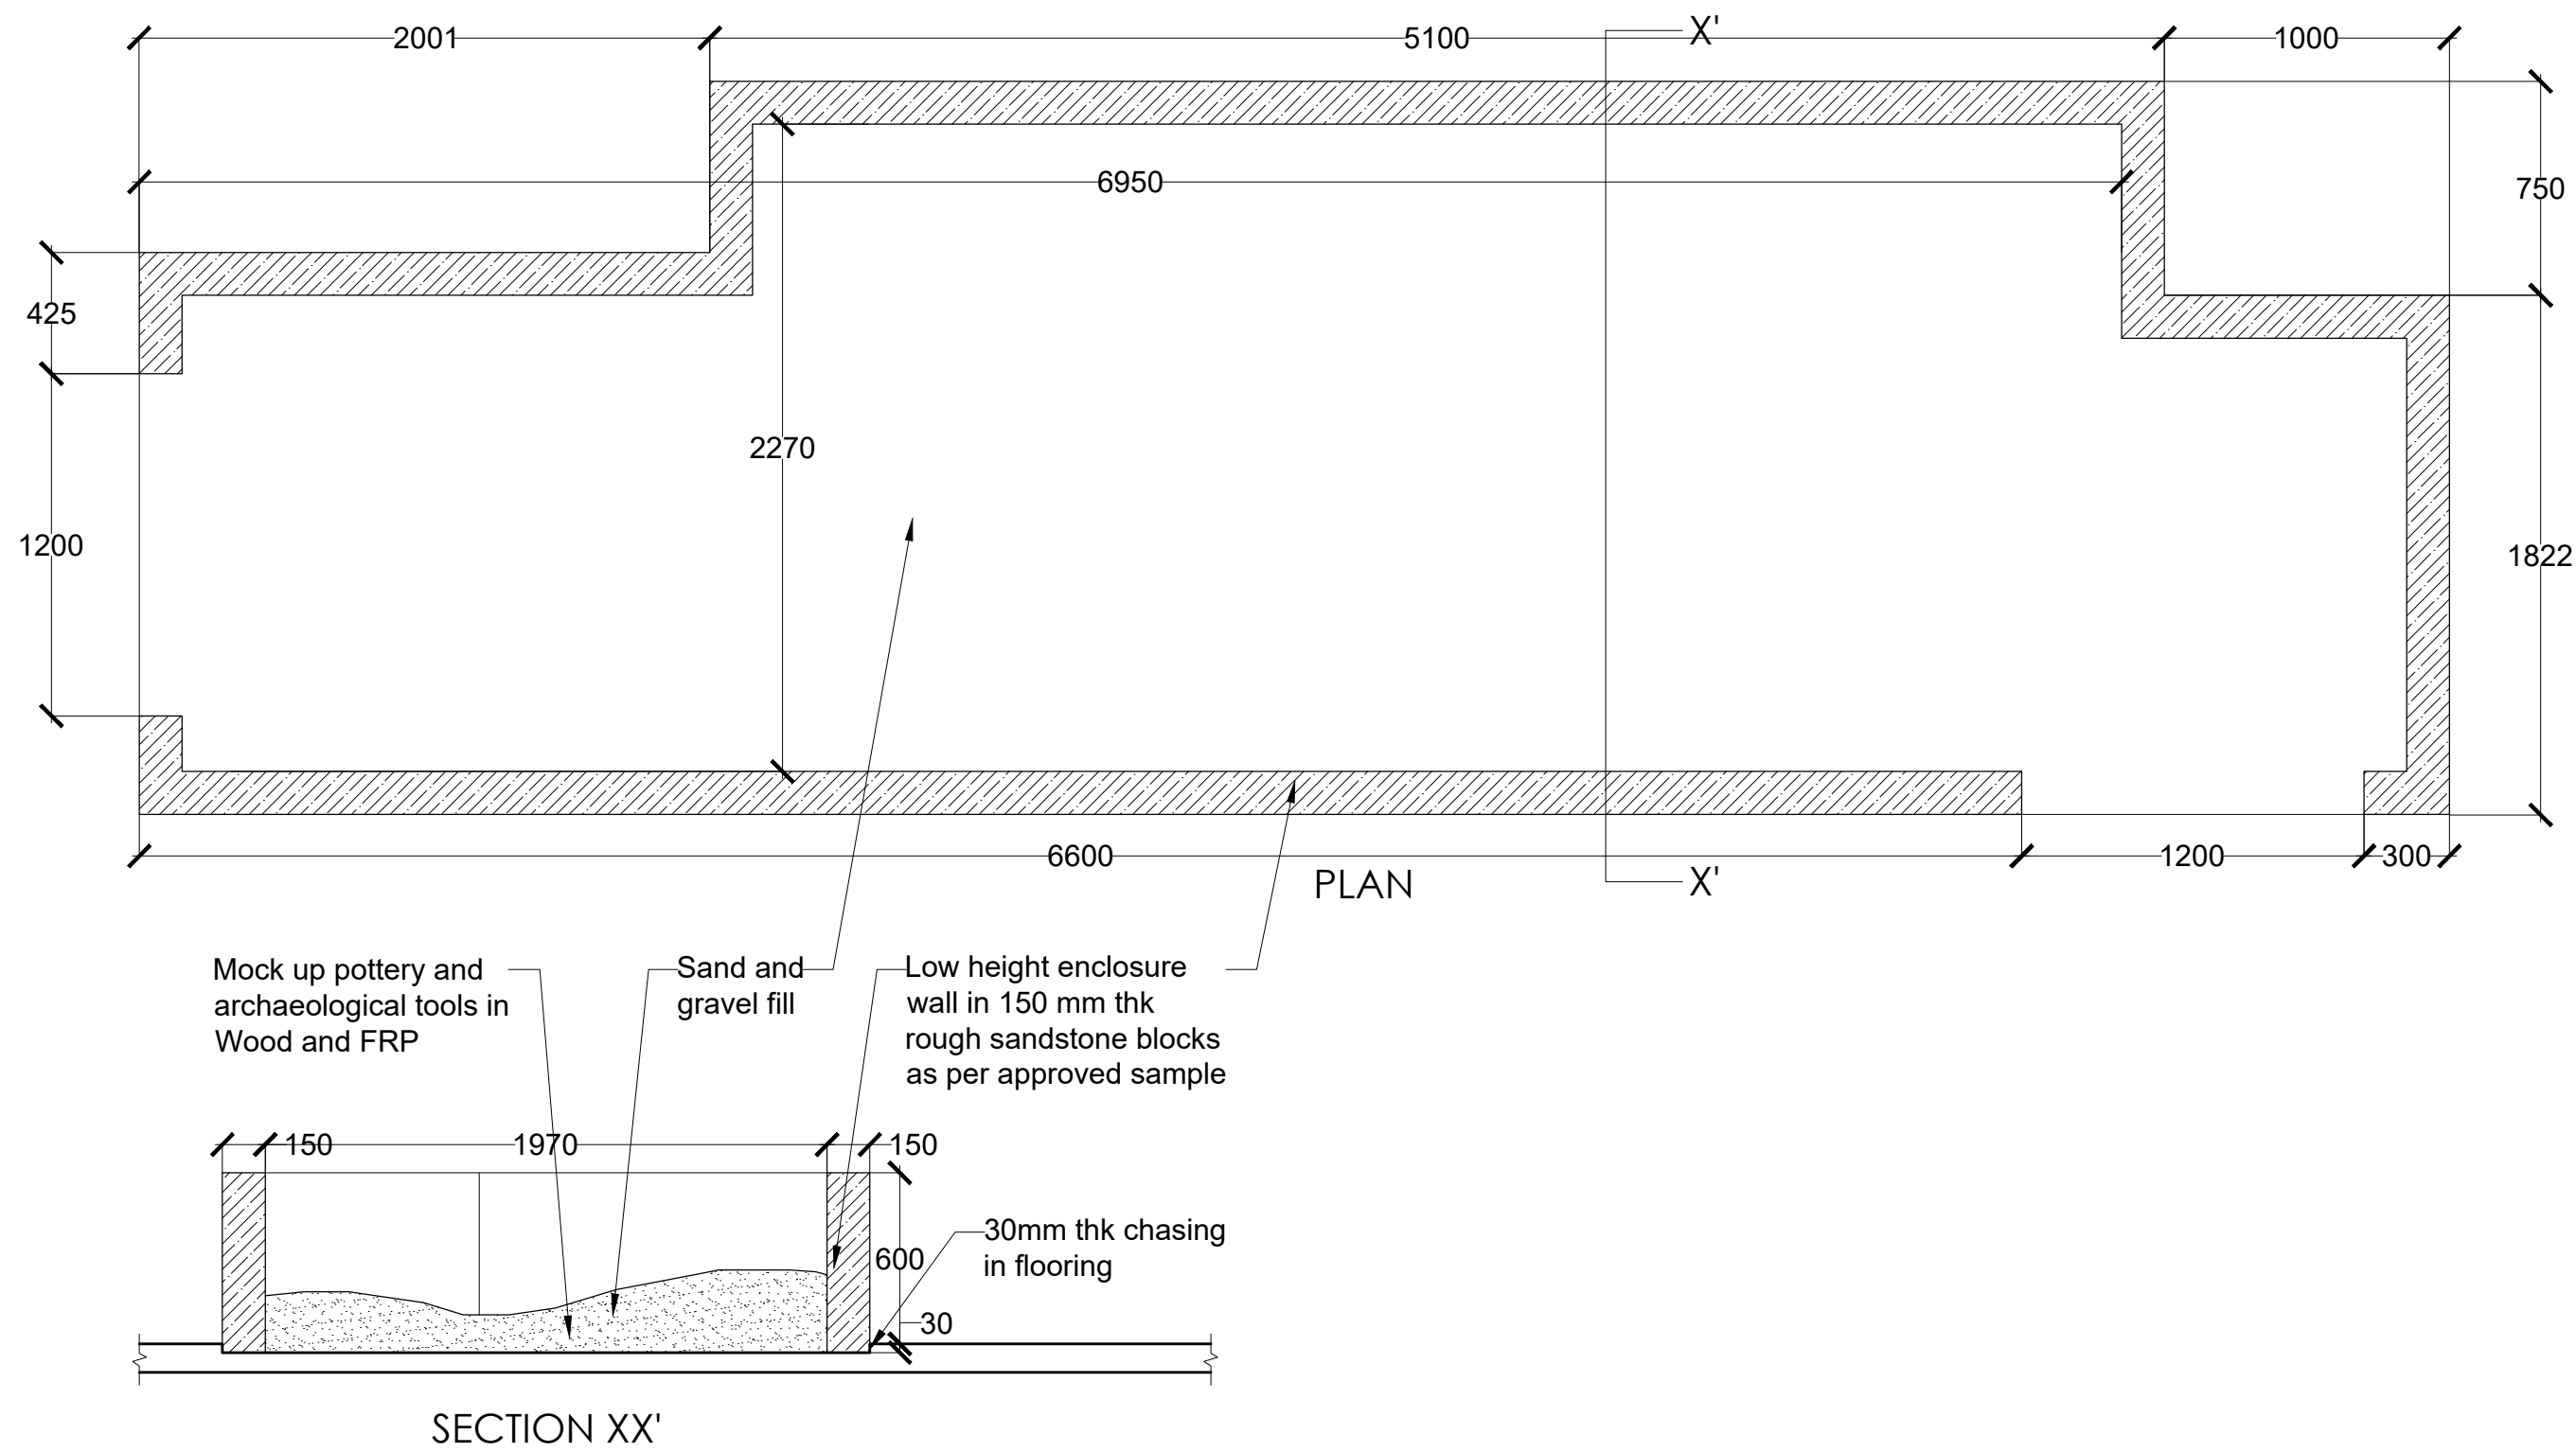

DETAIL MS. DP 09-15

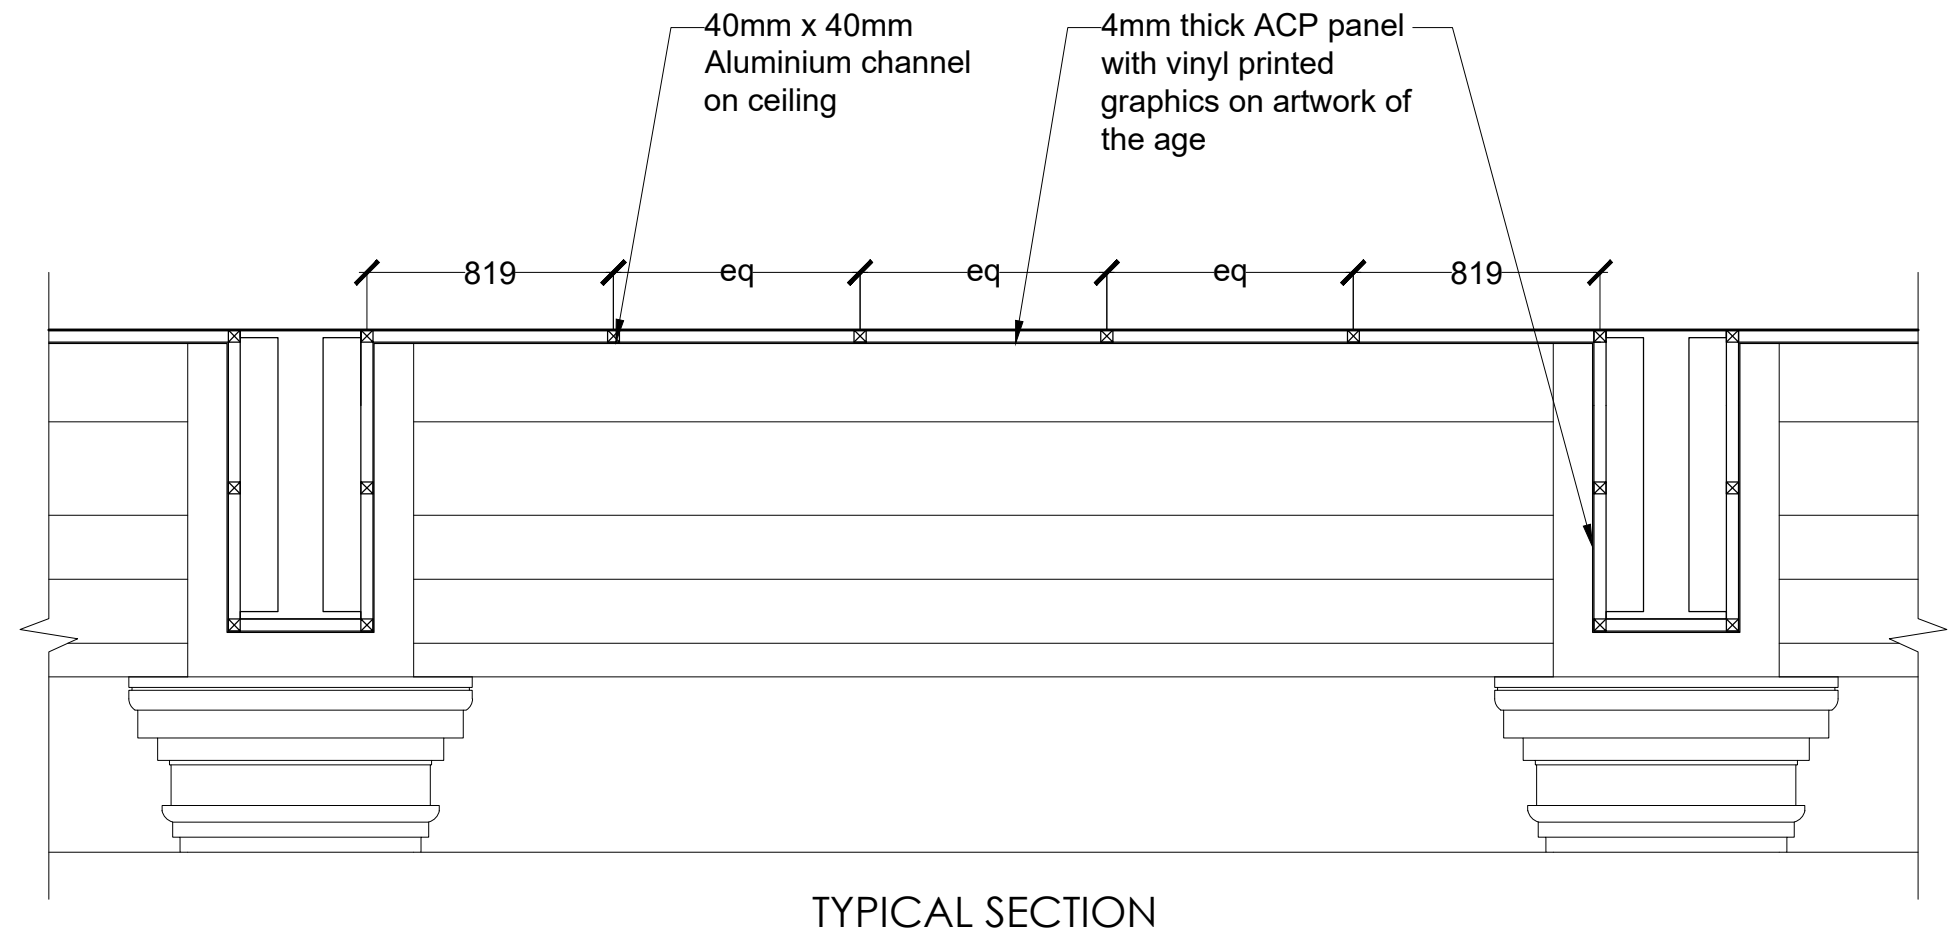


CORNICE MOULDING  
SCALE - 1:5

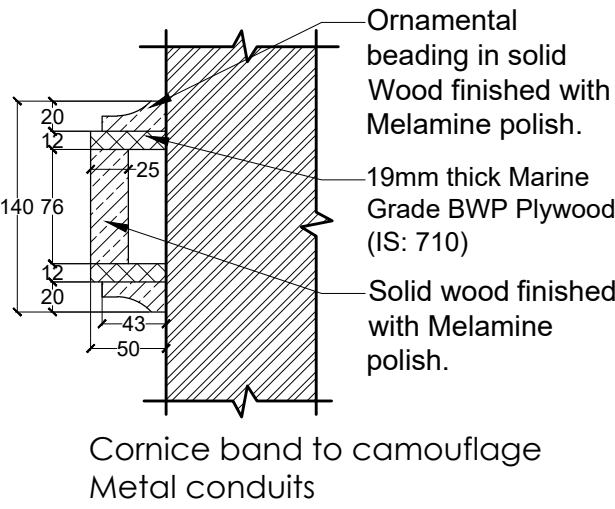

NOTES:

All dimensions are in millimeters

KEY PLAN

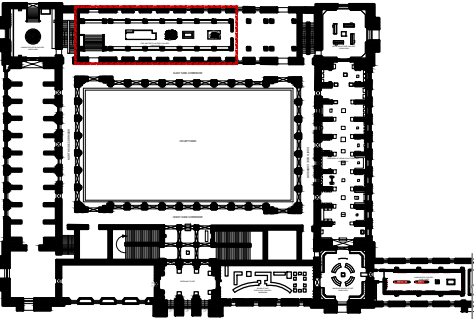

LEGEND

DP	Display Panel
DC	Display Case
DS	Display Shelf
PE	Pedestal
WM	Wall Mural
WG	Wall Graphics
CP	Canvas Painting
M	Model
MET	Mock Excavation Trench
CP	Canvas Painting
AV	Audio Visuals
I	Interactive
P	Projection
HP	Holographic Projection
GS	Gallery Signage
DS	Directional Signage
LG	Logo
RT	Reception Table
CC	Crowd Control Barrier

SCALE: 1:100

0 1m 2m



DRAWING NAME: LAYOUT

GALLERY OF STONE AGE SCULPTURES AND HARAPPAN CIVILIZATION

DRAWN BY: Sohini Pyne

CHECKED BY: Shikha Jain

DRAWING NUMBER: IMK/GF/PH/06

SERIES: Tender Drawings

PROJECT:

PLANNING, CONTENT DEVELOPMENT, DESIGNING, RETROFITTING AND CURATORIAL WORK FOR THE INDIAN MUSEUM, KOLKATA


CLIENT:




INDIAN MUSEUM, KOLKATA

CONSULTANT:

**DRONAH**  
DEVELOPMENT & RESEARCH  
ORGANISATION FOR NATURE,ARTS  
& HERITAGE

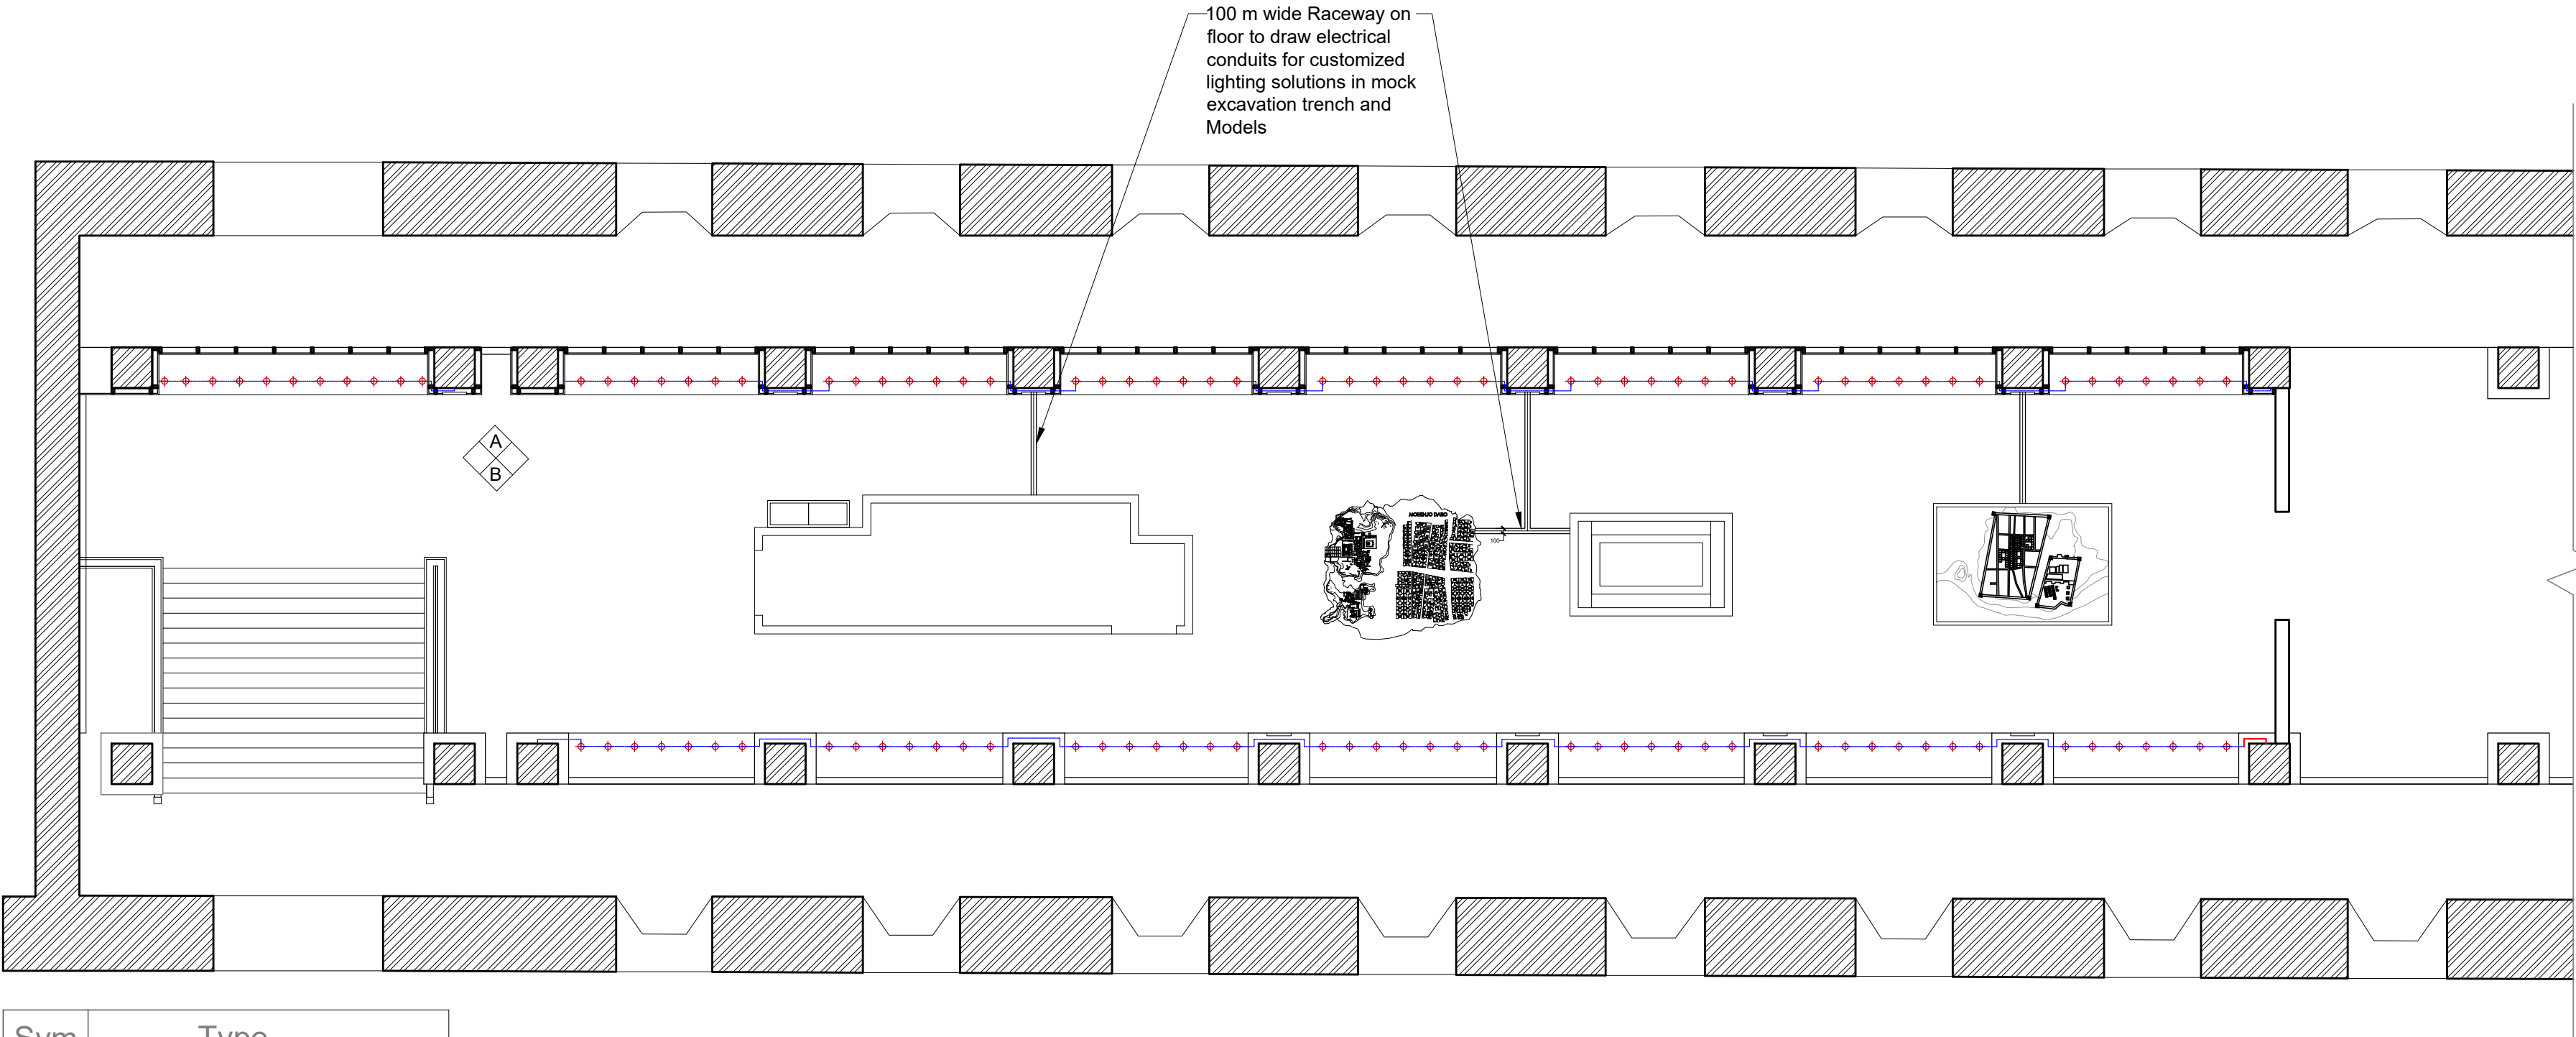A-258, SOUTH CITY-1  
GURGAON-122001




Sym	Type
	Cabinet light with rotatable head
	Ceiling Light Conduit
	Floor Light conduit

NOTES:

All dimensions are in millimeters

KEY PLAN

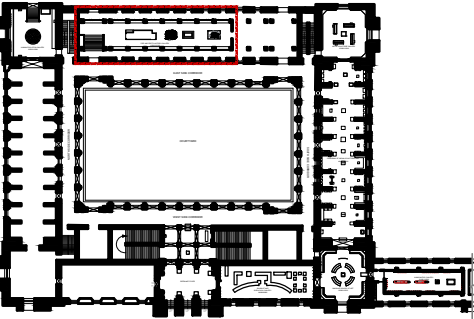

SCALE: 1:100

0 1m 2m



NORTH

DRAWING: LIGHTING LAYOUT

DRAWN BY: Sohini Pyne

CHECKED BY: Shikha Jain

DRAWING NUMBER: IMK/GF/PH/07  
GALLERY OF STONE AGE SCULPTURES AND  
HARAPPAN CIVILIZATION

SERIES: Tender Drawings

PROJECT:

PLANNING, CONTENT  
DEVELOPMENT, DESIGNING,  
RETROFITTING AND CURATORIAL  
WORK FOR THE INDIAN MUSEUM,  
KOLKATA

CLIENT:

INDIAN MUSEUM, KOLKATA


CONSULTANT:

**DRONAH**  
DEVELOPMENT & RESEARCH  
ORGANISATION FOR NATURE,ARTS  
& HERITAGE

A-258, SOUTH CITY-1  
GURGAON-122001





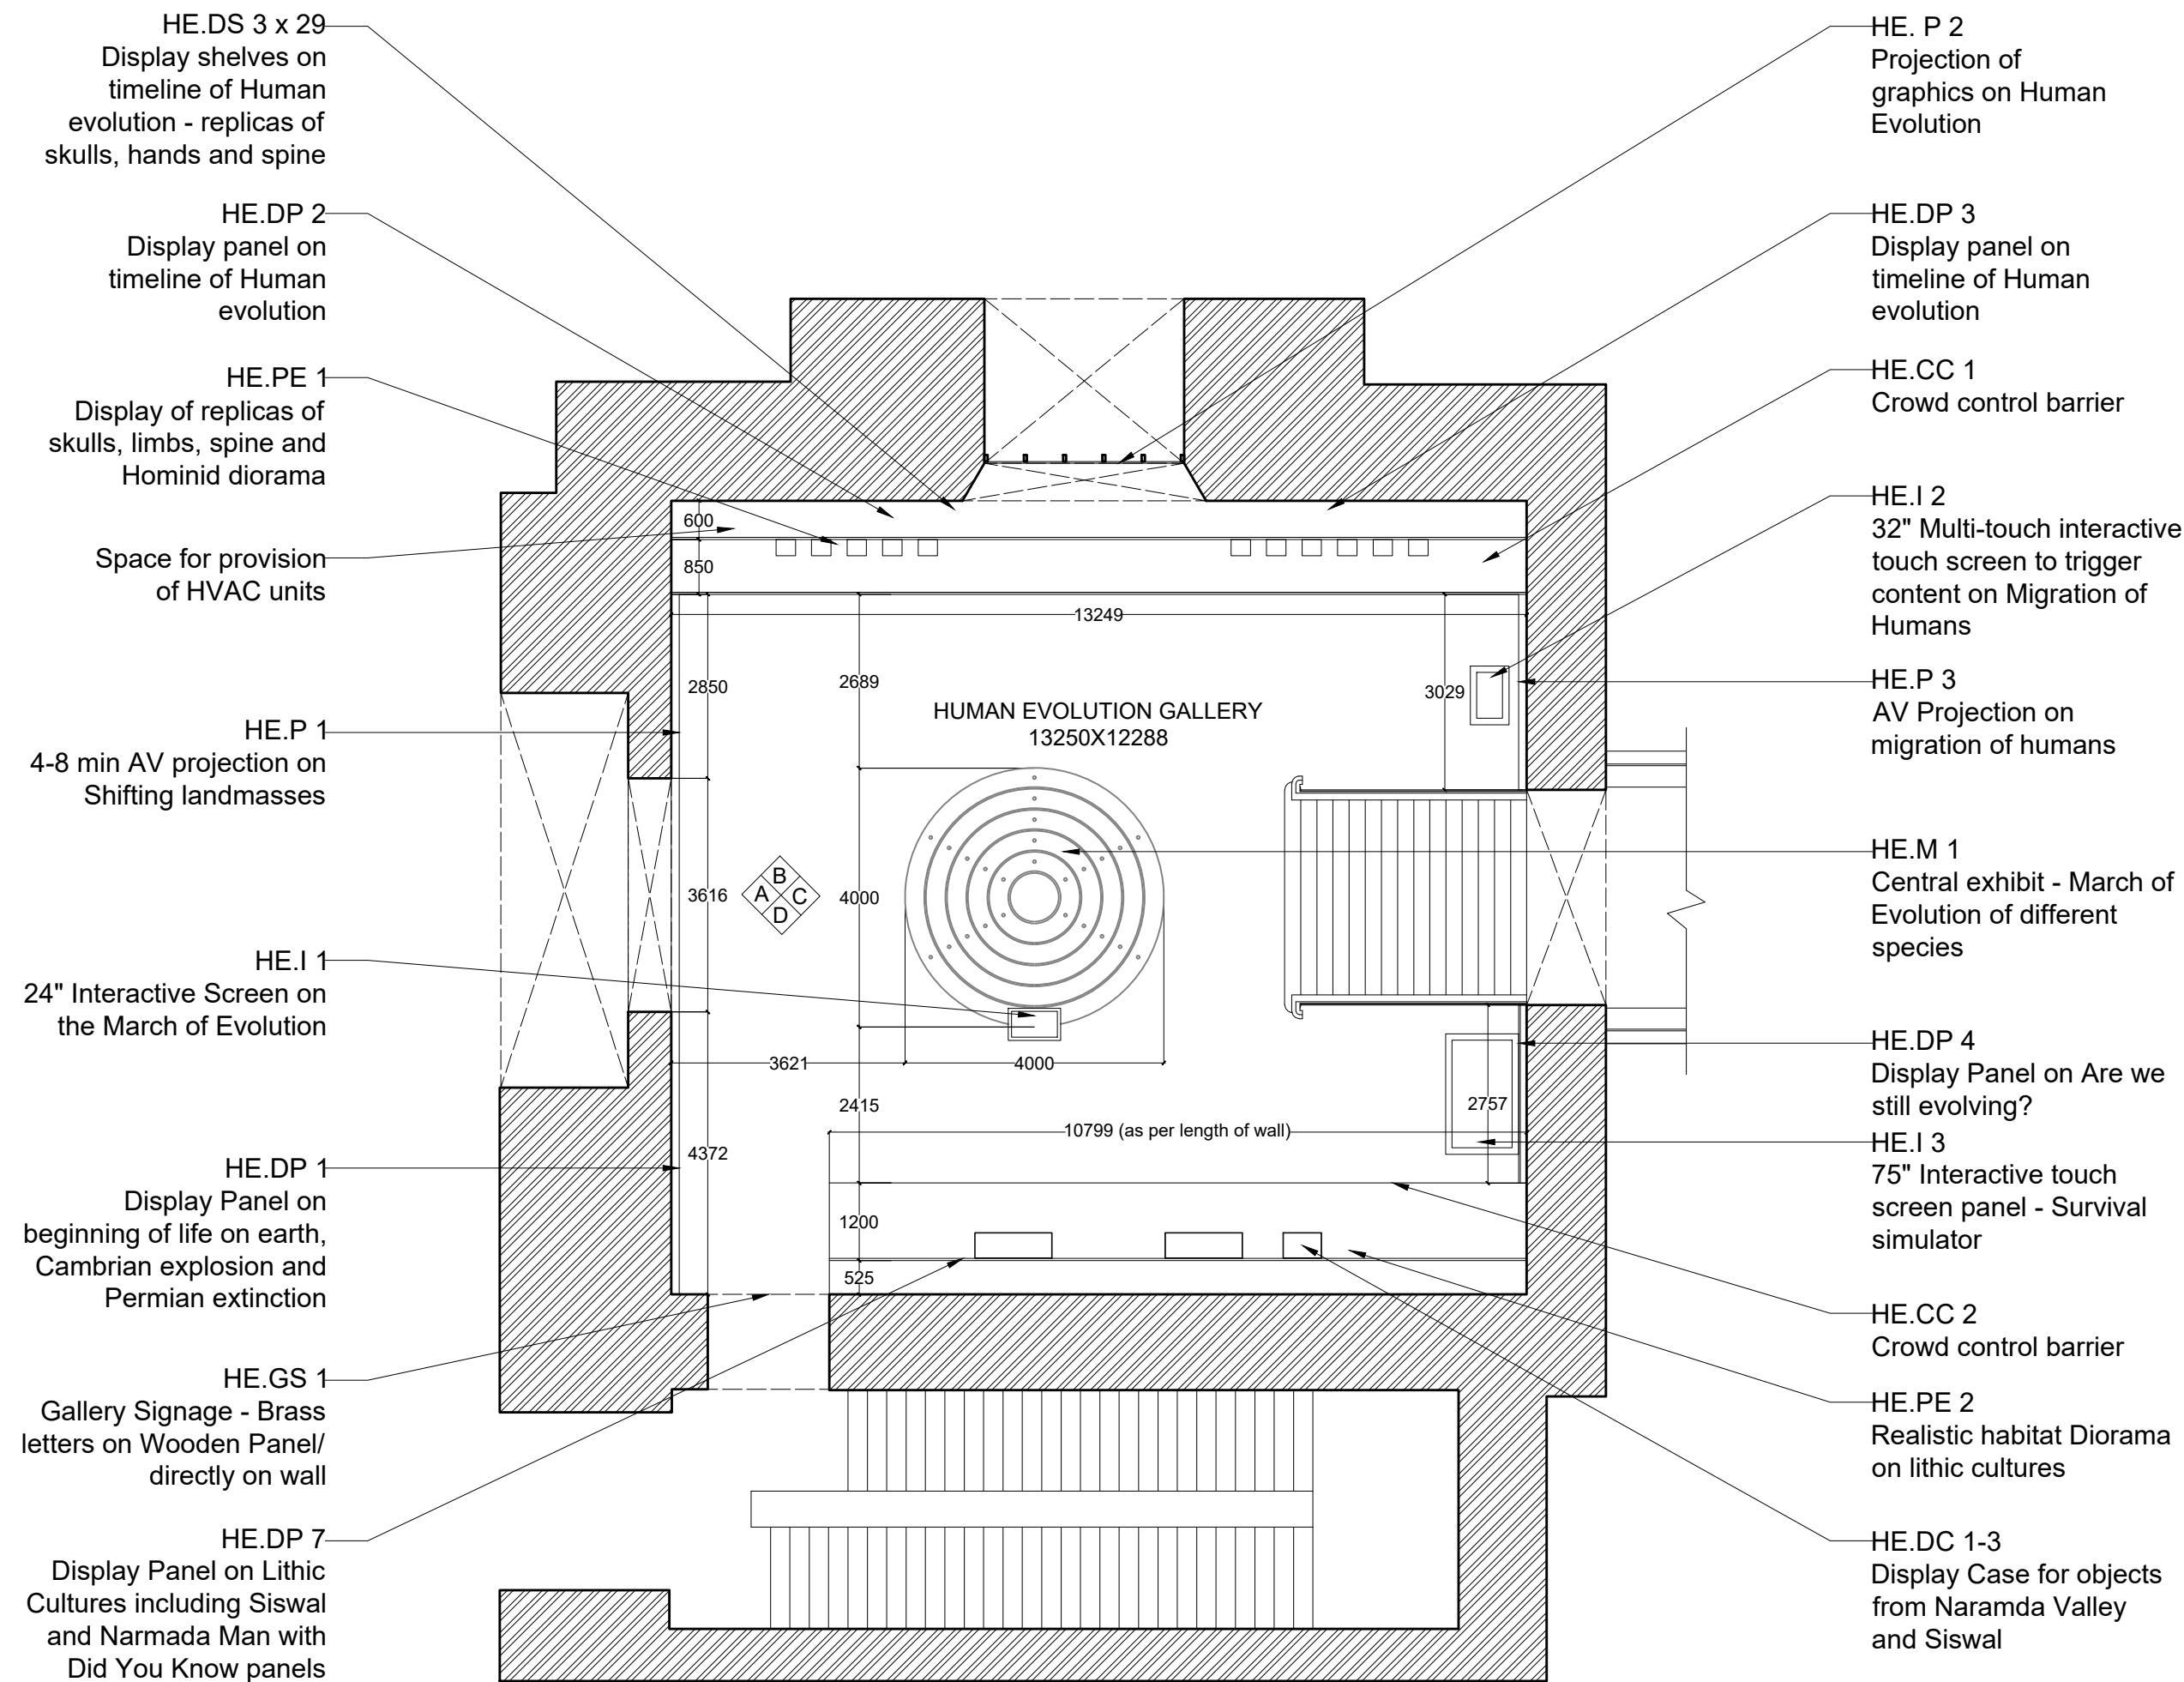


PLAN

NOTES:

All dimensions are in millimeters

KEY PLAN

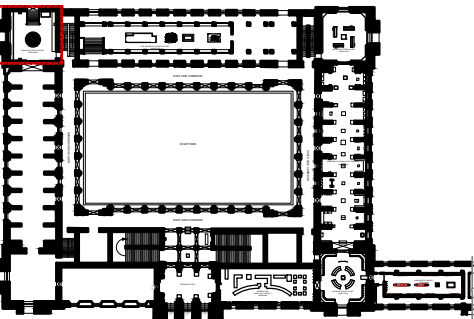

LEGEND

DP	Display Panel
DC	Display Case
DS	Display Shelf
PE	Pedestal
WM	Wall Mural
WG	Wall Graphics
CP	Canvas Painting
M	Model
MET	Mock Excavation Trench
CP	Canvas Painting
AV	Audio Visuals
I	Interactive
P	Projection
HP	Holographic Projection
GS	Gallery Signage
DS	Directional Signage
LG	Logo
RT	Reception Table
CC	Crowd Control Barrier

SCALE: 1:100

0 1m 2m



DRAWING NAME: LAYOUT

HUMAN EVOLUTION GALLERY

DRAWN BY: Sohini Pyne

CHECKED BY: Shikha Jain

DRAWING NUMBER: IMK/GF/HE/01

SERIES: Tender Drawings

PROJECT:

PLANNING, CONTENT DEVELOPMENT, DESIGNING, RETROFITTING AND CURATORIAL WORK FOR THE INDIAN MUSEUM, KOLKATA





CLIENT:

INDIAN MUSEUM, KOLKATA

CONSULTANT:

**DRONAH**  
DEVELOPMENT & RESEARCH  
ORGANISATION FOR NATURE,ARTS  
& HERITAGE


A-258, SOUTH CITY-1  
GURGAON-122001

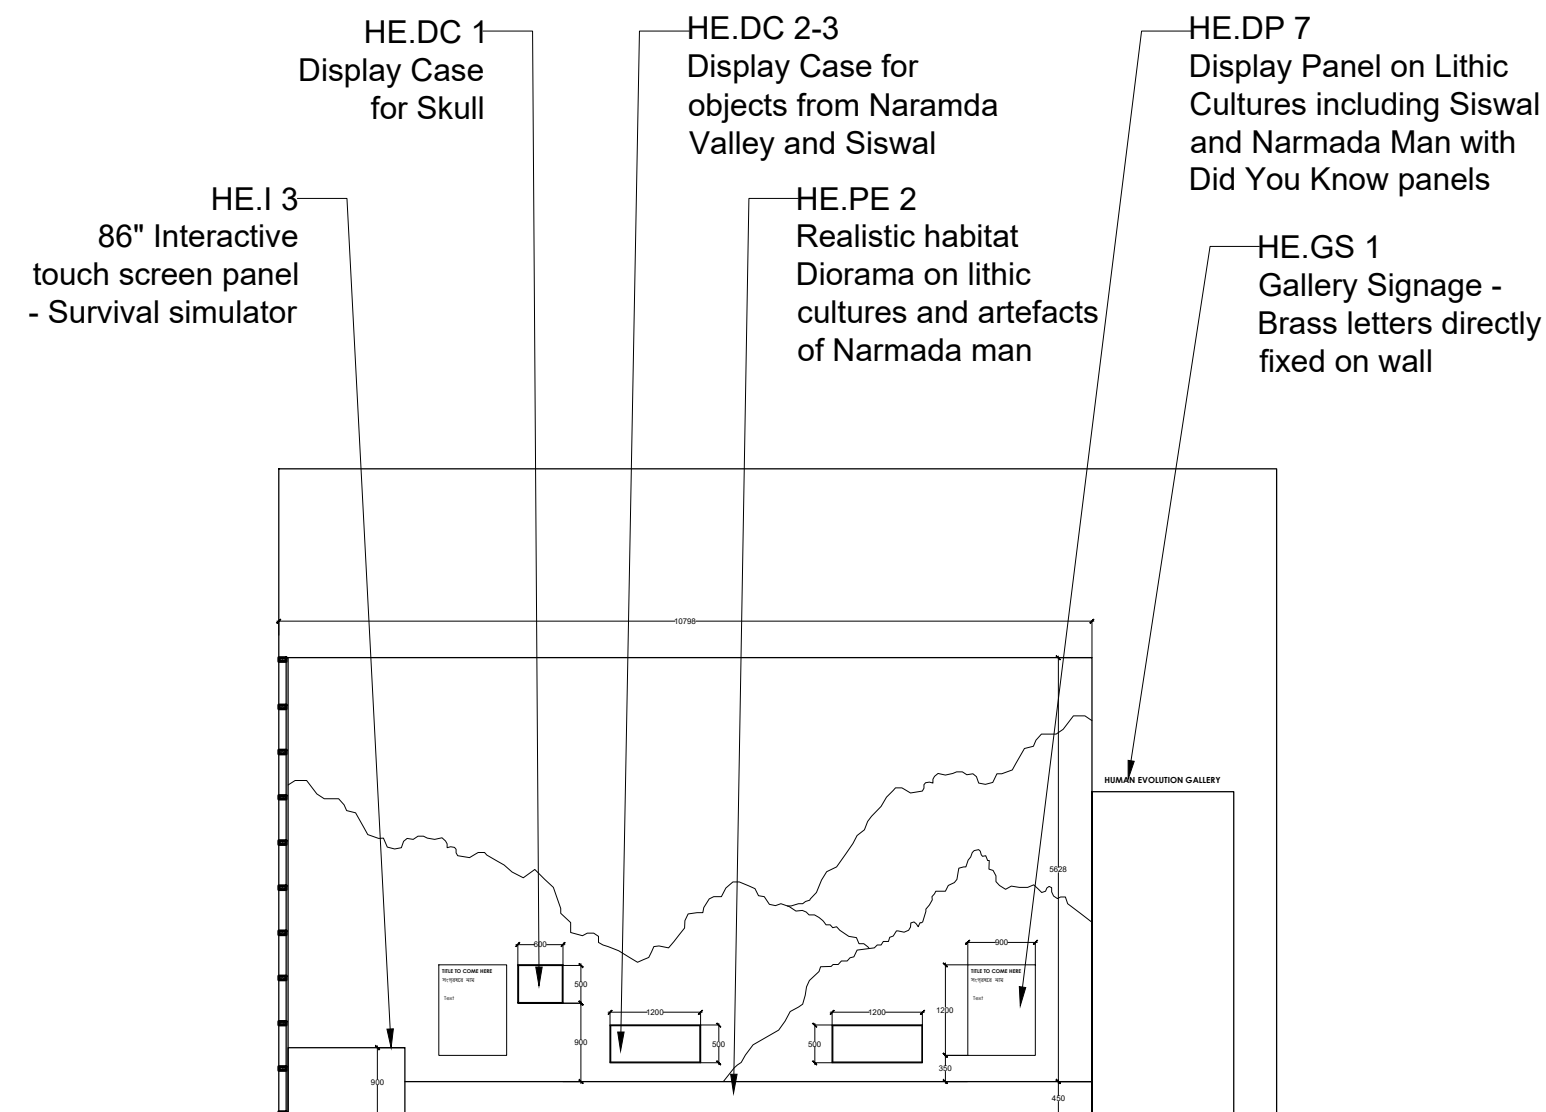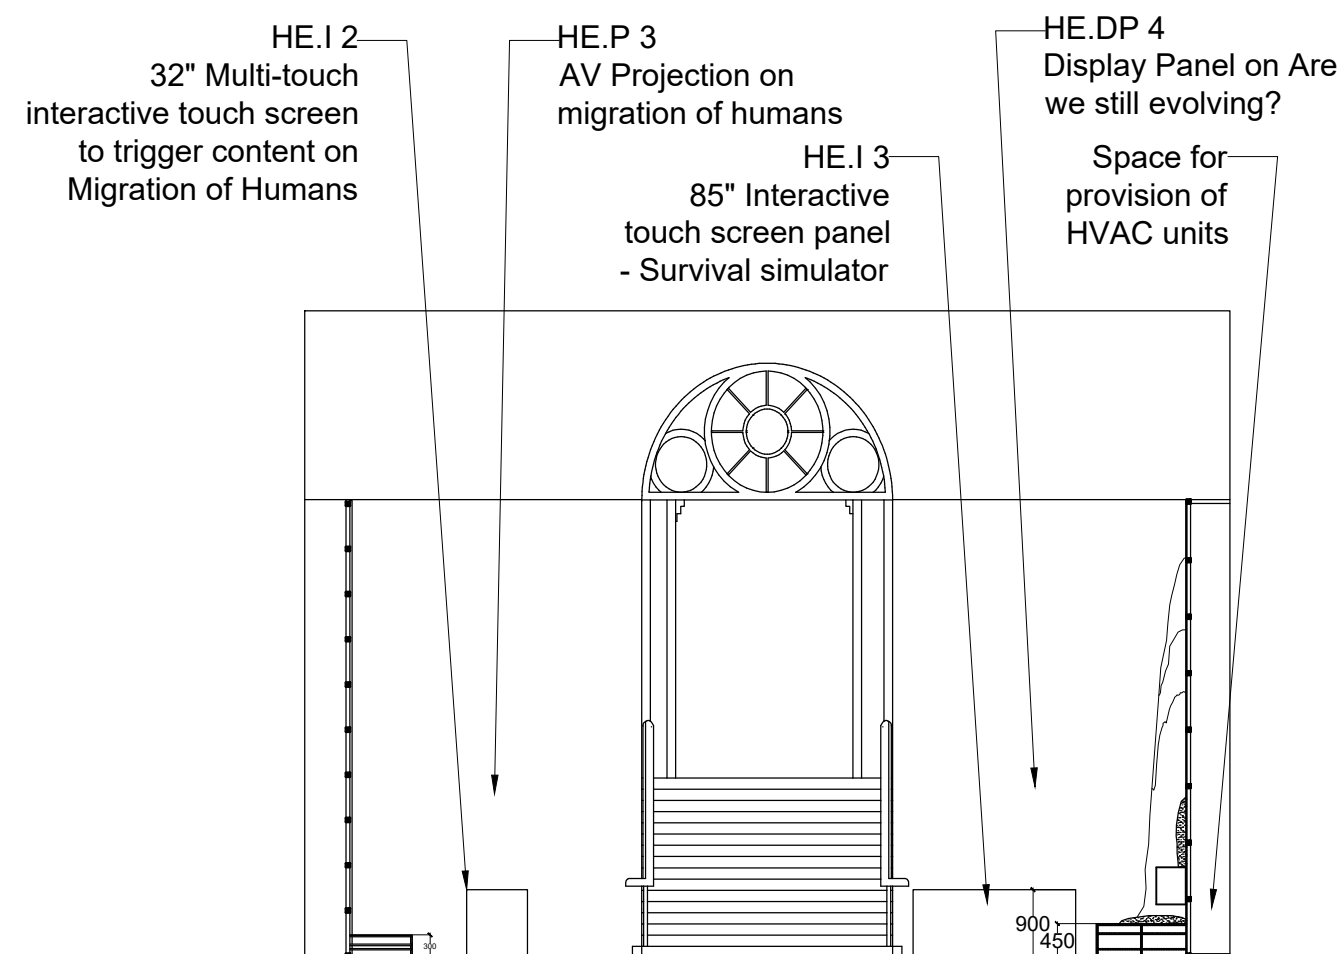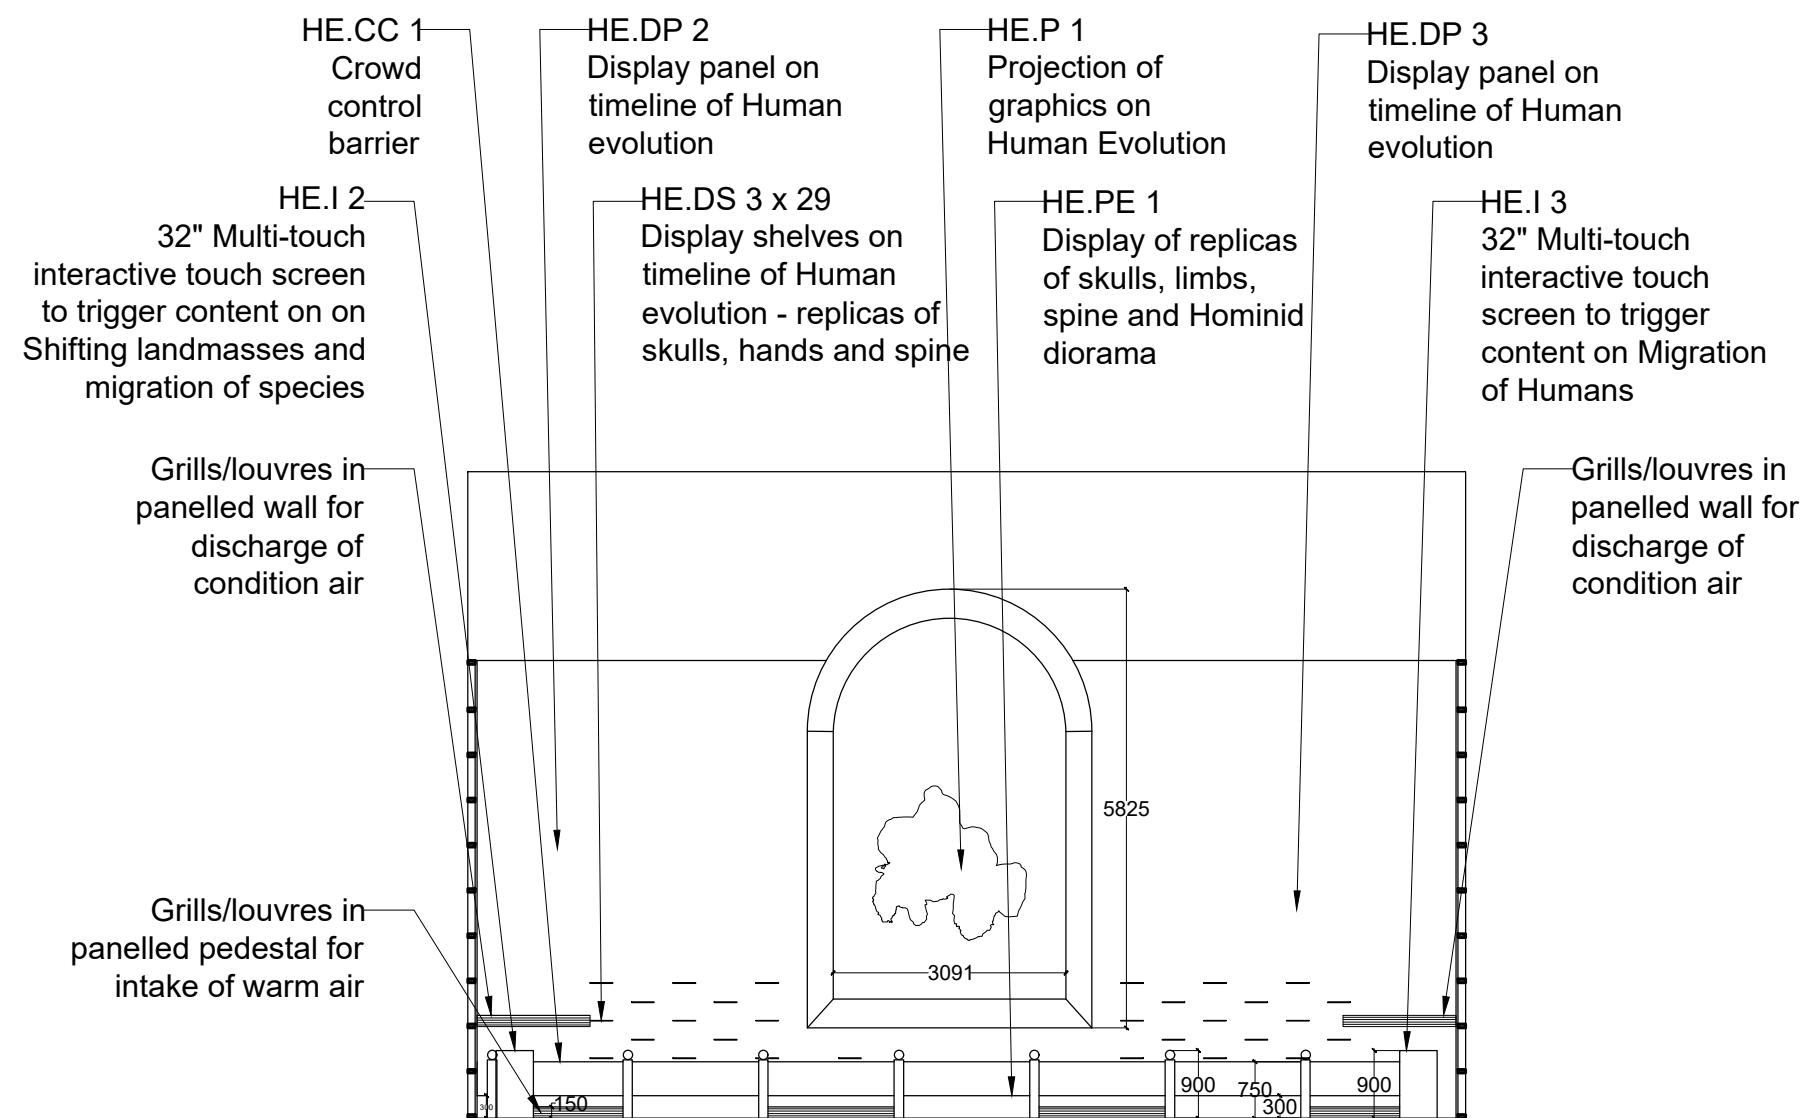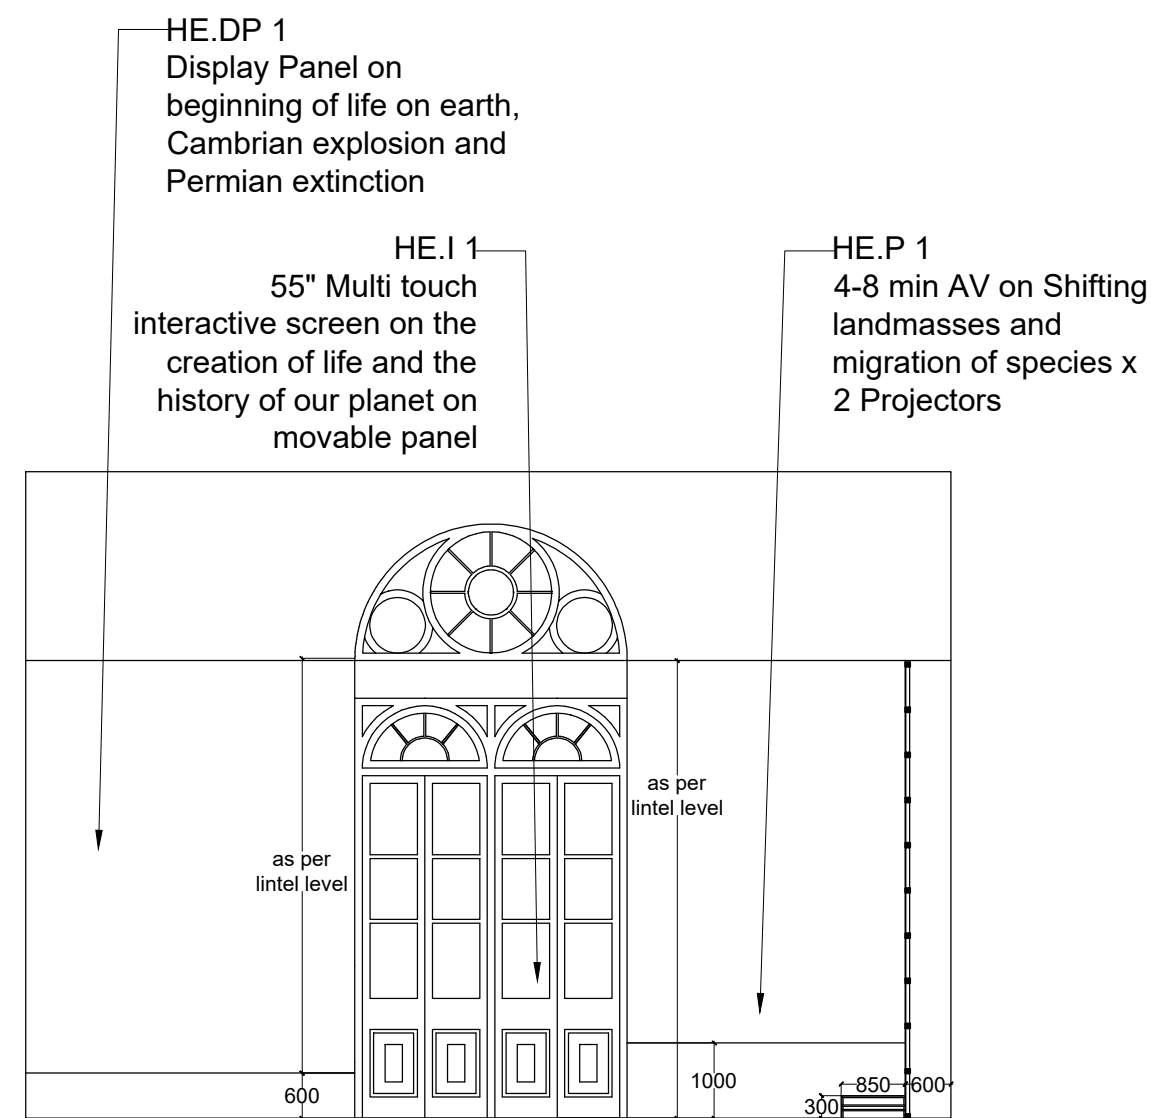

**NOTES:**

All dimensions are in millimeters

## KEY PLAN

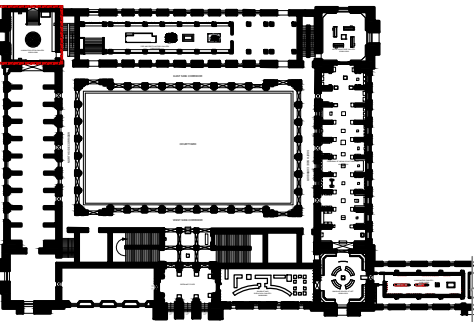

### LEGEND

<b>DP</b>	Display Panel
<b>DC</b>	Display Case
<b>DS</b>	Display Shelf
<b>PE</b>	Pedestal
<b>WM</b>	Wall Mural
<b>WG</b>	Wall Graphics
<b>CP</b>	Canvas Painting
<b>M</b>	Model
<b>MET</b>	Mock Excavation Trench
<b>CP</b>	Canvas Painting
<b>AV</b>	Audio Visuals
<b>I</b>	Interactive
<b>P</b>	Projection
<b>HP</b>	Holographic Projection
<b>GS</b>	Gallery Signage
<b>DS</b>	Directional Signage
<b>LG</b>	Logo
<b>RT</b>	Reception Table
<b>CC</b>	Crowd Control Barrier

**SCALE:** 1:100

0	1m	2m
---	----	----



DRAWING NAME:	LAYOUT
---------------	--------

HUMAN EVOLUTION GALLERY

**DRAWN BY:** Sohini Pyne

**CHECKED BY:** Shikha Jain

**DRAWING NUMBER: IMK/GF/HE/02**

**SERIES:** Tender Drawings

**PROJECT:**

PLANNING, CONTENT  
DEVELOPMENT, DESIGNING,  
RETROFITTING AND CURATORIAL  
WORK FOR THE INDIAN MUSEUM,  
KOLKATA


**CLIENT:**

INDIAN MUSEUM, KOLKATA


CONSULTANT:

**DRONAH**  
DEVELOPMENT & RESEARCH  
ORGANISATION FOR NATURE, ARTS  
& HERITAGE


A-258, SOUTH CITY-1  
GURGAON-122001

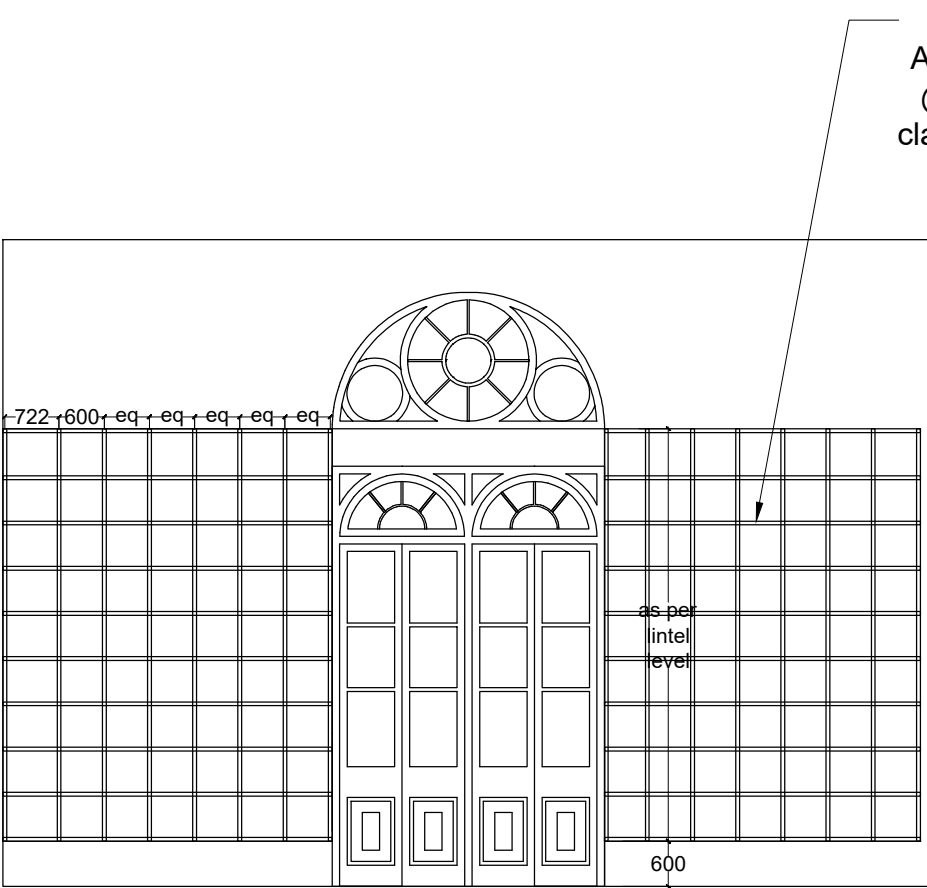


INTERNAL ELEVATION A

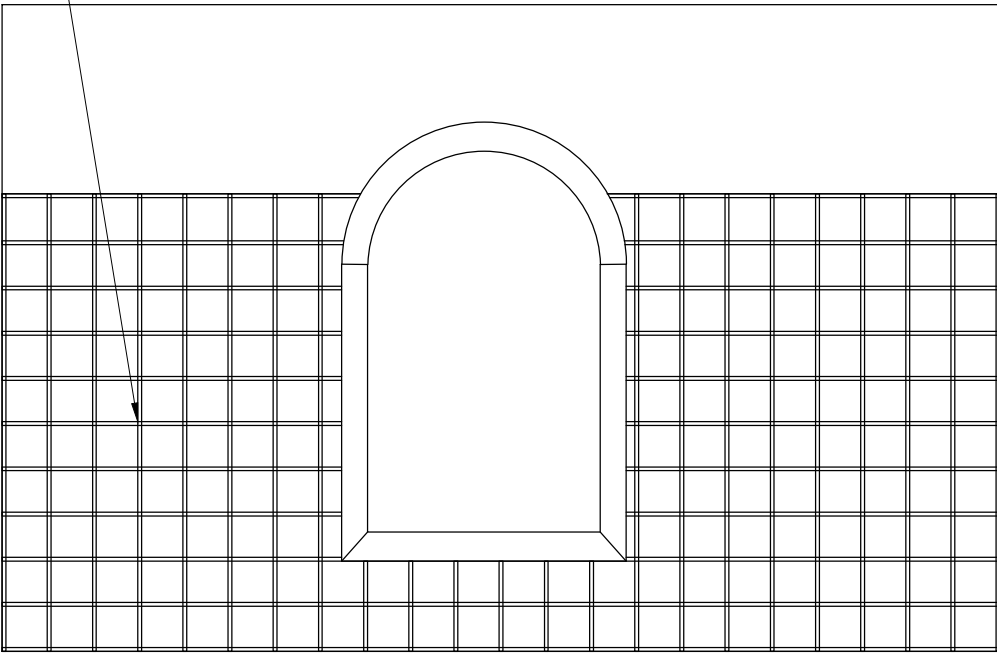

INTERNAL ELEVATION B

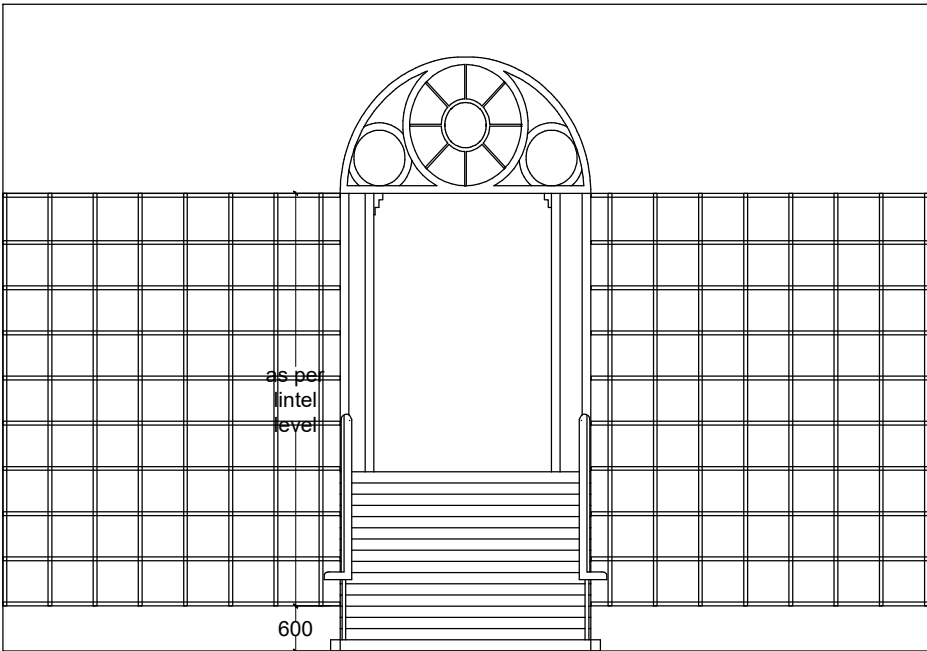

INTERNAL ELEVATION C

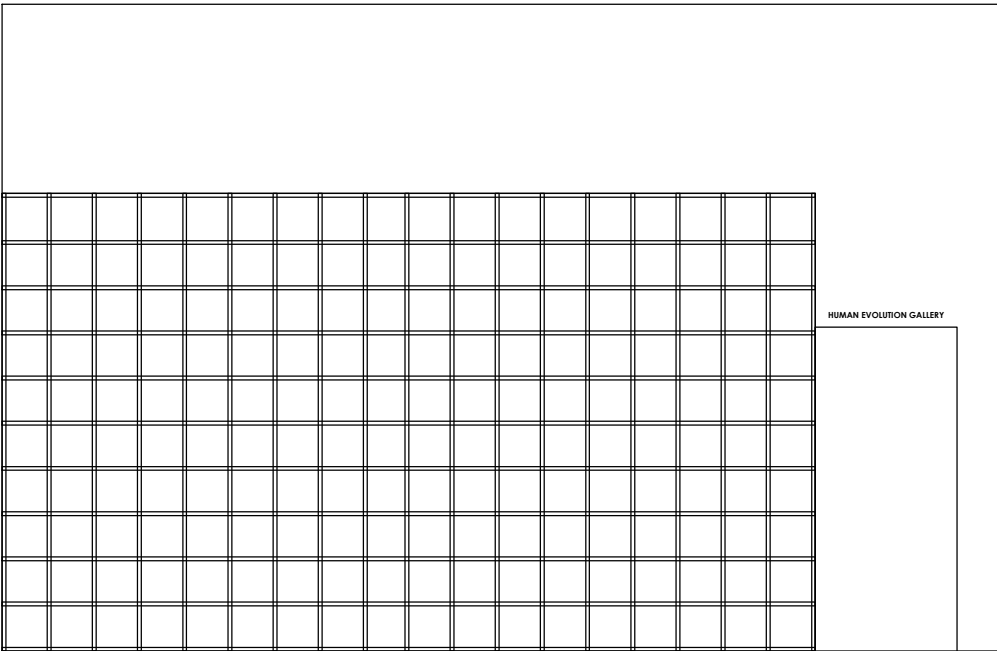


INTERNAL ELEVATION D

NOTES:

All dimensions are in millimeters

KEY PLAN

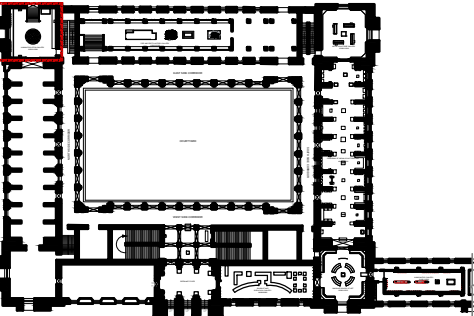

LEGEND

DP	Display Panel
DC	Display Case
DS	Display Shelf
PE	Pedestal
WM	Wall Mural
WG	Wall Graphics
CP	Canvas Painting
M	Model
MET	Mock Excavation Trench
CP	Canvas Painting
AV	Audio Visuals
I	Interactive
P	Projection
HP	Holographic Projection
GS	Gallery Signage
DS	Directional Signage
LG	Logo
RT	Reception Table
CC	Crowd Control Barrier

SCALE: 1:100

0 1m 2m



DRAWING NAME: LAYOUT

HUMAN EVOLUTION GALLERY

DRAWN BY: Sohini Pyne

CHECKED BY: Shikha Jain

DRAWING NUMBER: IMK/GF/HE/03

SERIES: Tender Drawings

PROJECT:

PLANNING, CONTENT DEVELOPMENT, DESIGNING, RETROFITTING AND CURATORIAL WORK FOR THE INDIAN MUSEUM, KOLKATA

CLIENT:





INDIAN MUSEUM, KOLKATA

CONSULTANT:

**DRONAH**  
DEVELOPMENT & RESEARCH ORGANISATION FOR NATURE,ARTS & HERITAGE


A-258, SOUTH CITY-1  
GURGAON-122001



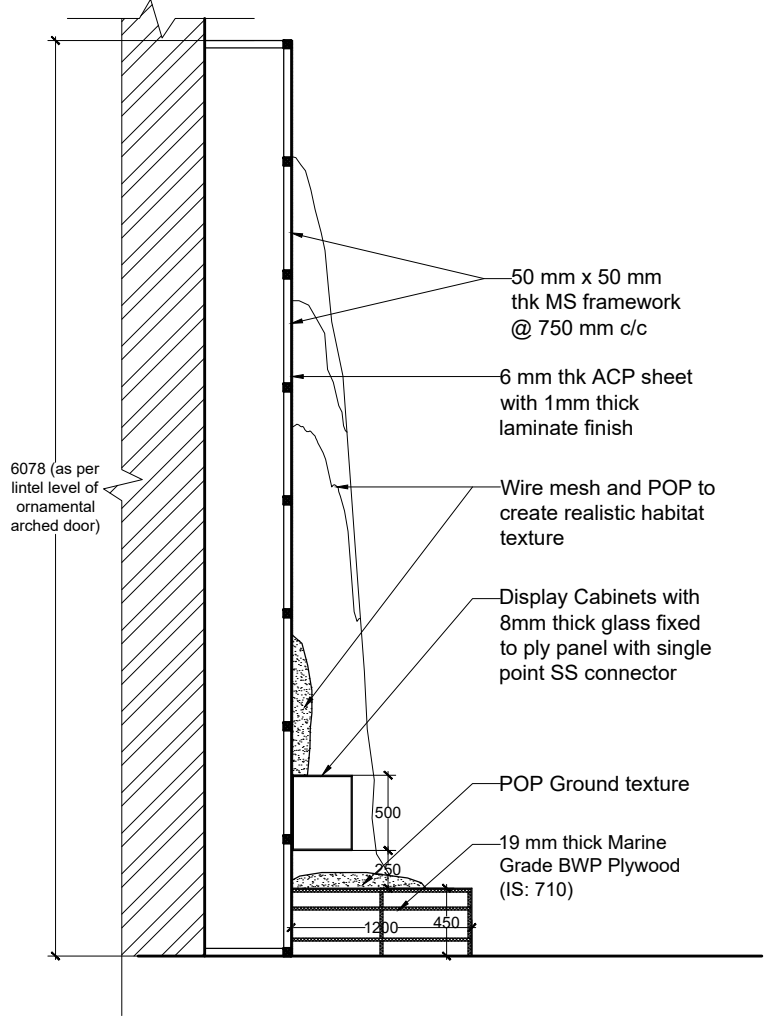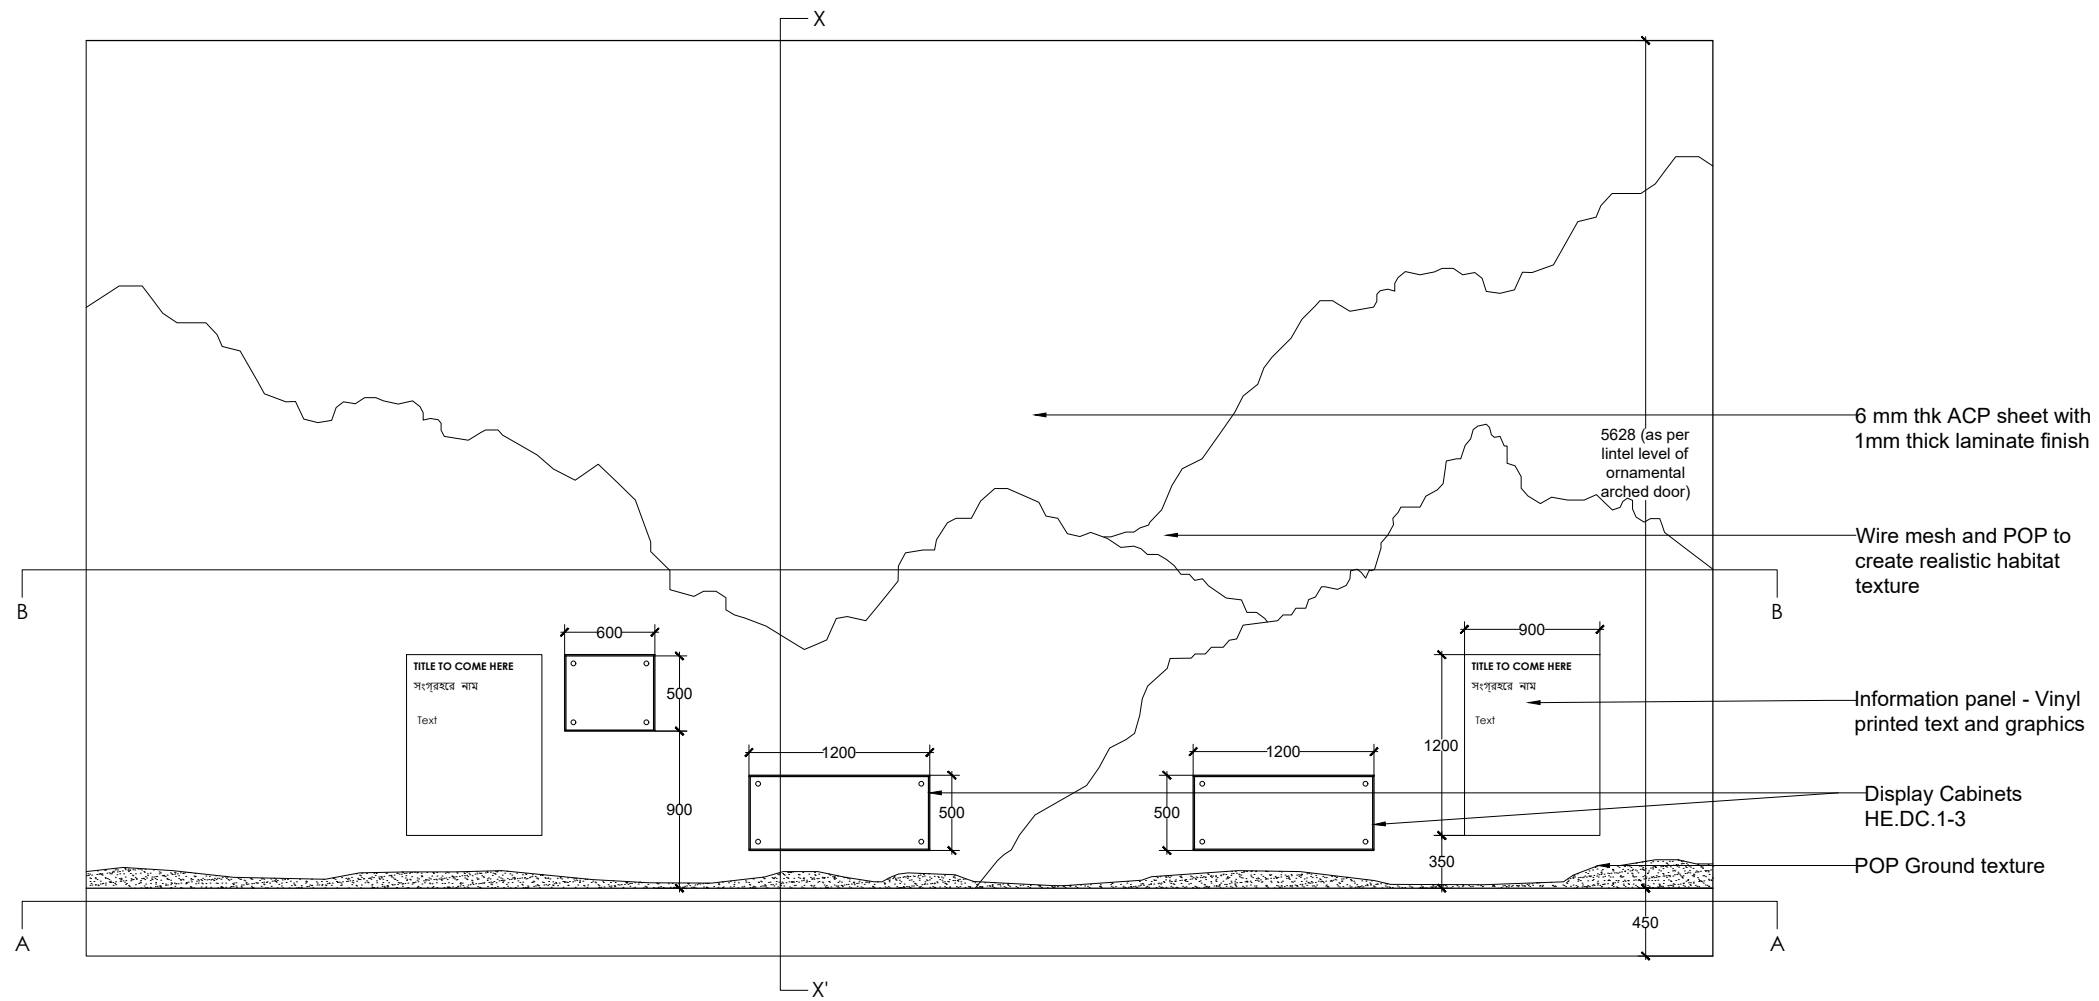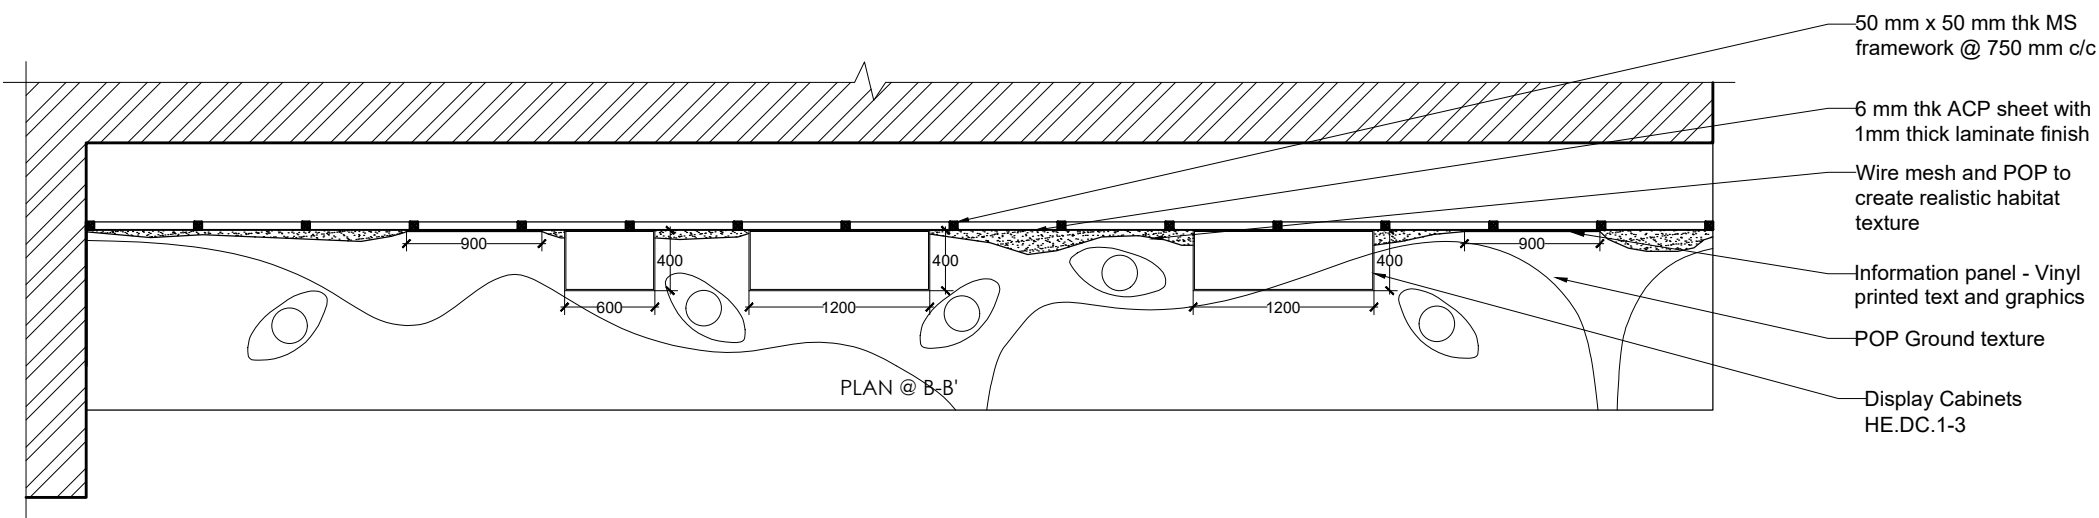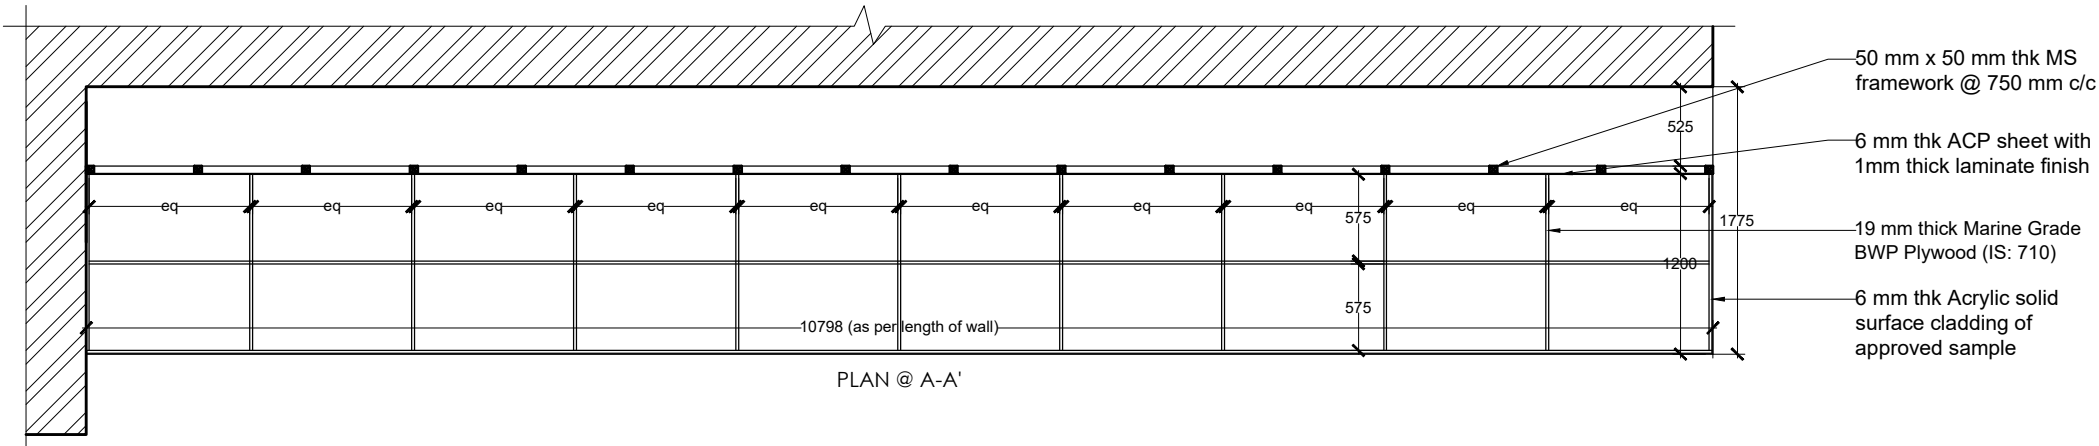

NOTES:

All dimensions are in millimeters

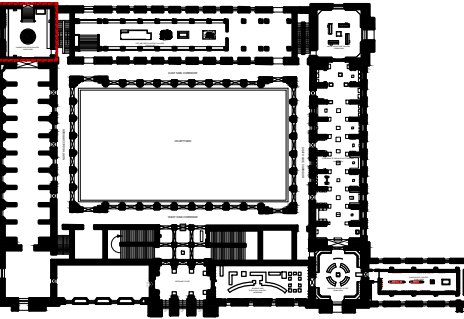

LEGEND

DP	Display Panel
DC	Display Case
DS	Display Shelf
PE	Pedestal
WM	Wall Mural
WG	Wall Graphics
CP	Canvas Painting
M	Model
MET	Mock Excavation Trench
CP	Canvas Painting
AV	Audio Visuals
I	Interactive
P	Projection
HP	Holographic Projection
GS	Gallery Signage
DS	Directional Signage
LG	Logo
RT	Reception Table
CC	Crowd Control Barrier

SCALE: 1:50

0 1m 2m



DRAWING NAME: LAYOUT

HUMAN EVOLUTION GALLERY

DRAWN BY: Sohini Pyne

CHECKED BY: Shikha Jain

DRAWING NUMBER: IMK/GF/HE/04

SERIES: Tender Drawings

PROJECT:

PLANNING, CONTENT DEVELOPMENT, DESIGNING, RETROFITTING AND CURATORIAL WORK FOR THE INDIAN MUSEUM, KOLKATA

CLIENT:


INDIAN MUSEUM, KOLKATA

CONSULTANT:


**DRONAH**  
DEVELOPMENT & RESEARCH  
ORGANISATION FOR NATURE,ARTS  
& HERITAGE

A-258, SOUTH CITY-1  
GURGAON-122001


DETAIL HE. CC 1-2

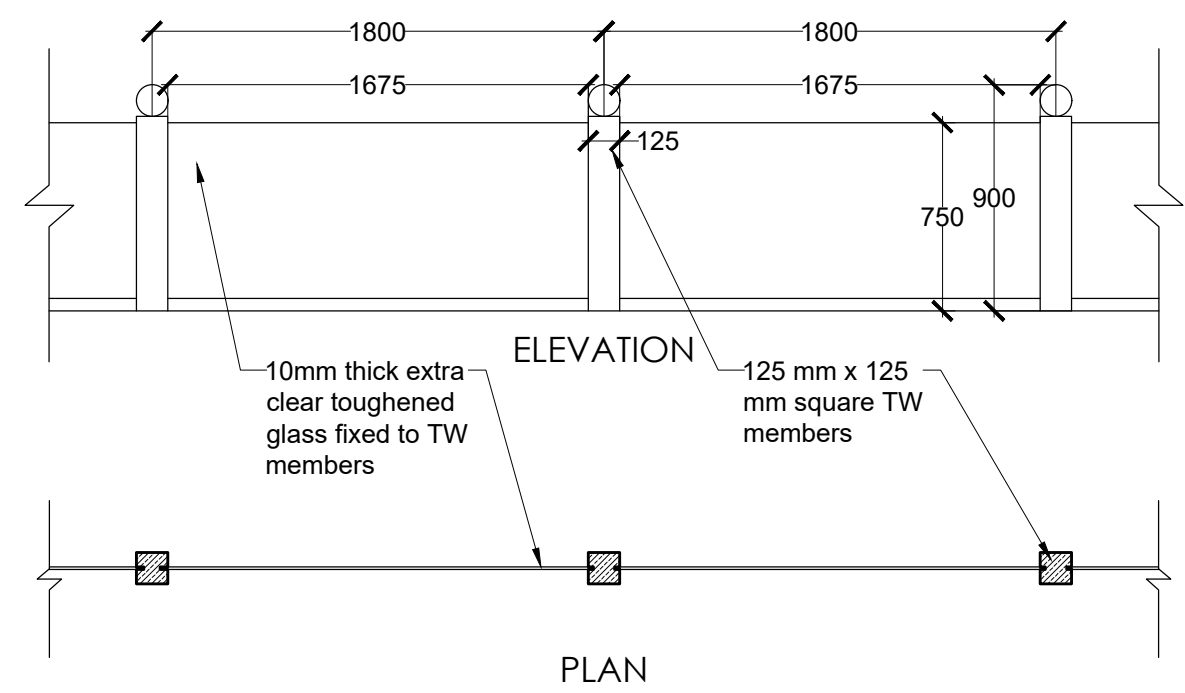

CORNICE MOULDING  
SCALE - 1:5

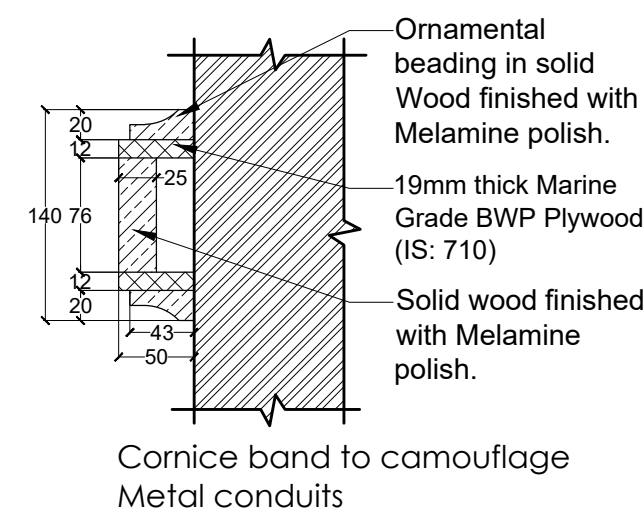


DETAIL HE. PE 1

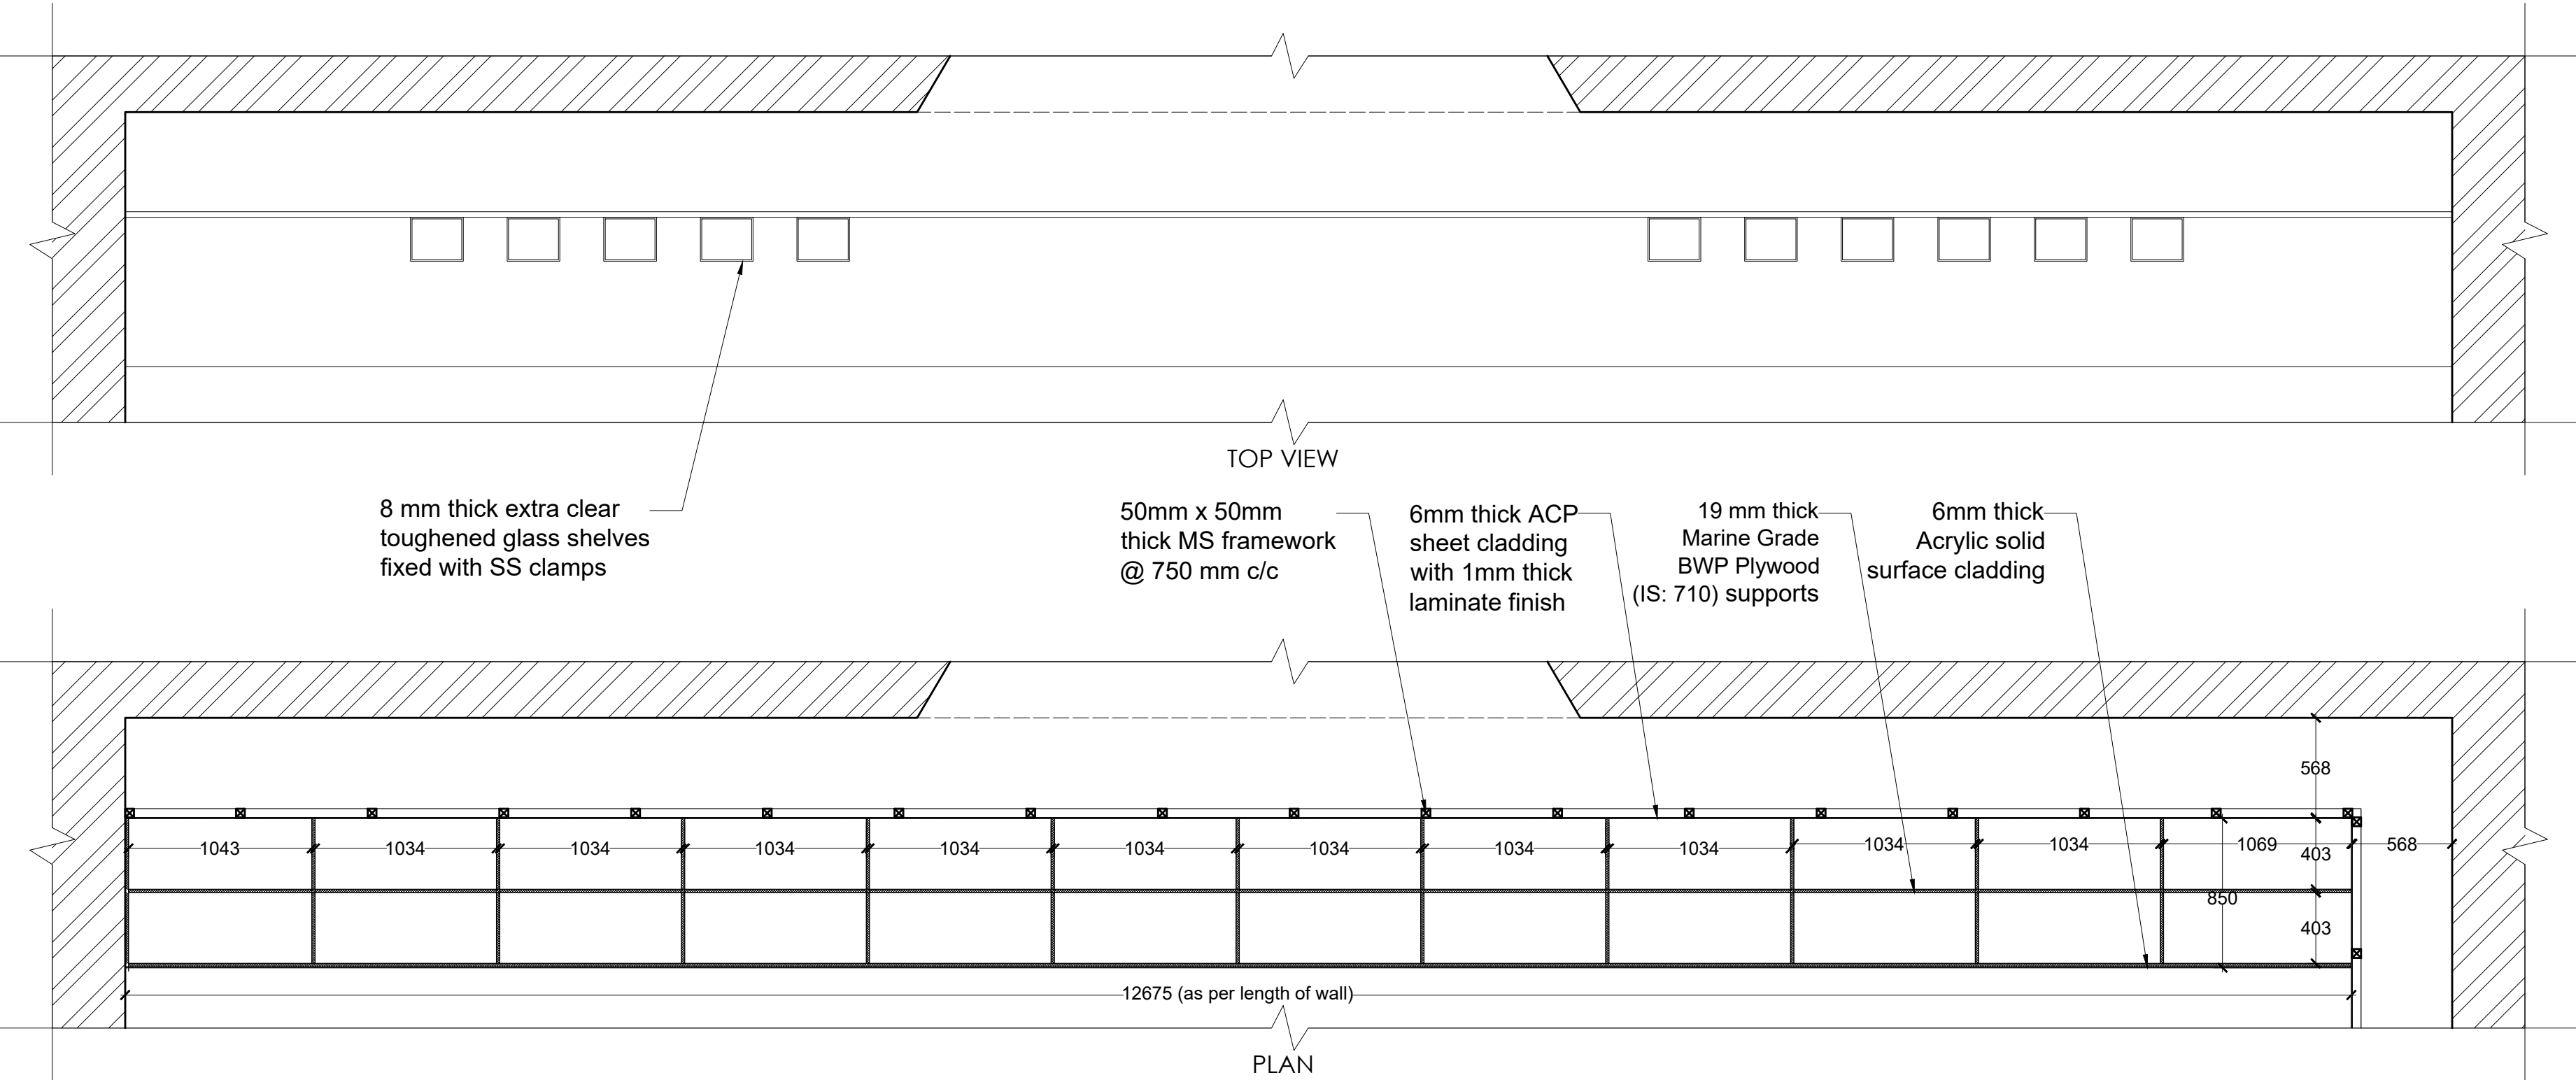

NOTES:

All dimensions are in millimeters

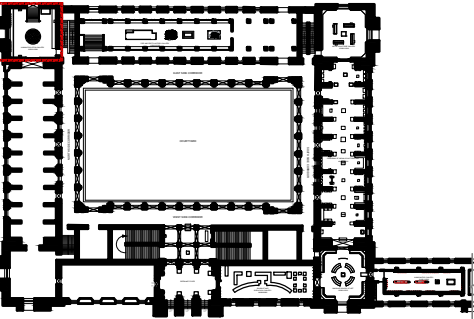

LEGEND

DP	Display Panel
DC	Display Case
DS	Display Shelf
PE	Pedestal
WM	Wall Mural
WG	Wall Graphics
CP	Canvas Painting
M	Model
MET	Mock Excavation Trench
CP	Canvas Painting
AV	Audio Visuals
I	Interactive
P	Projection
HP	Holographic Projection
GS	Gallery Signage
DS	Directional Signage
LG	Logo
RT	Reception Table
CC	Crowd Control Barrier

SCALE: 1:30

0 1m 2m



NORTH

DRAWING NAME: LAYOUT

HUMAN EVOLUTION GALLERY

DRAWN BY: Sohini Pyne

CHECKED BY: Shikha Jain

DRAWING NUMBER: IMK/GF/HE/05

Tender Drawings

PROJECT:

PLANNING, CONTENT DEVELOPMENT, DESIGNING, RETROFITTING AND CURATORIAL WORK FOR THE INDIAN MUSEUM, KOLKATA


INDIAN MUSEUM, KOLKATA

CONSULTANT:

**DRONAH**  
DEVELOPMENT & RESEARCH  
ORGANISATION FOR NATURE,ARTS  
& HERITAGE


A-258, SOUTH CITY-1  
GURGAON-122001

DETAIL HE.M1

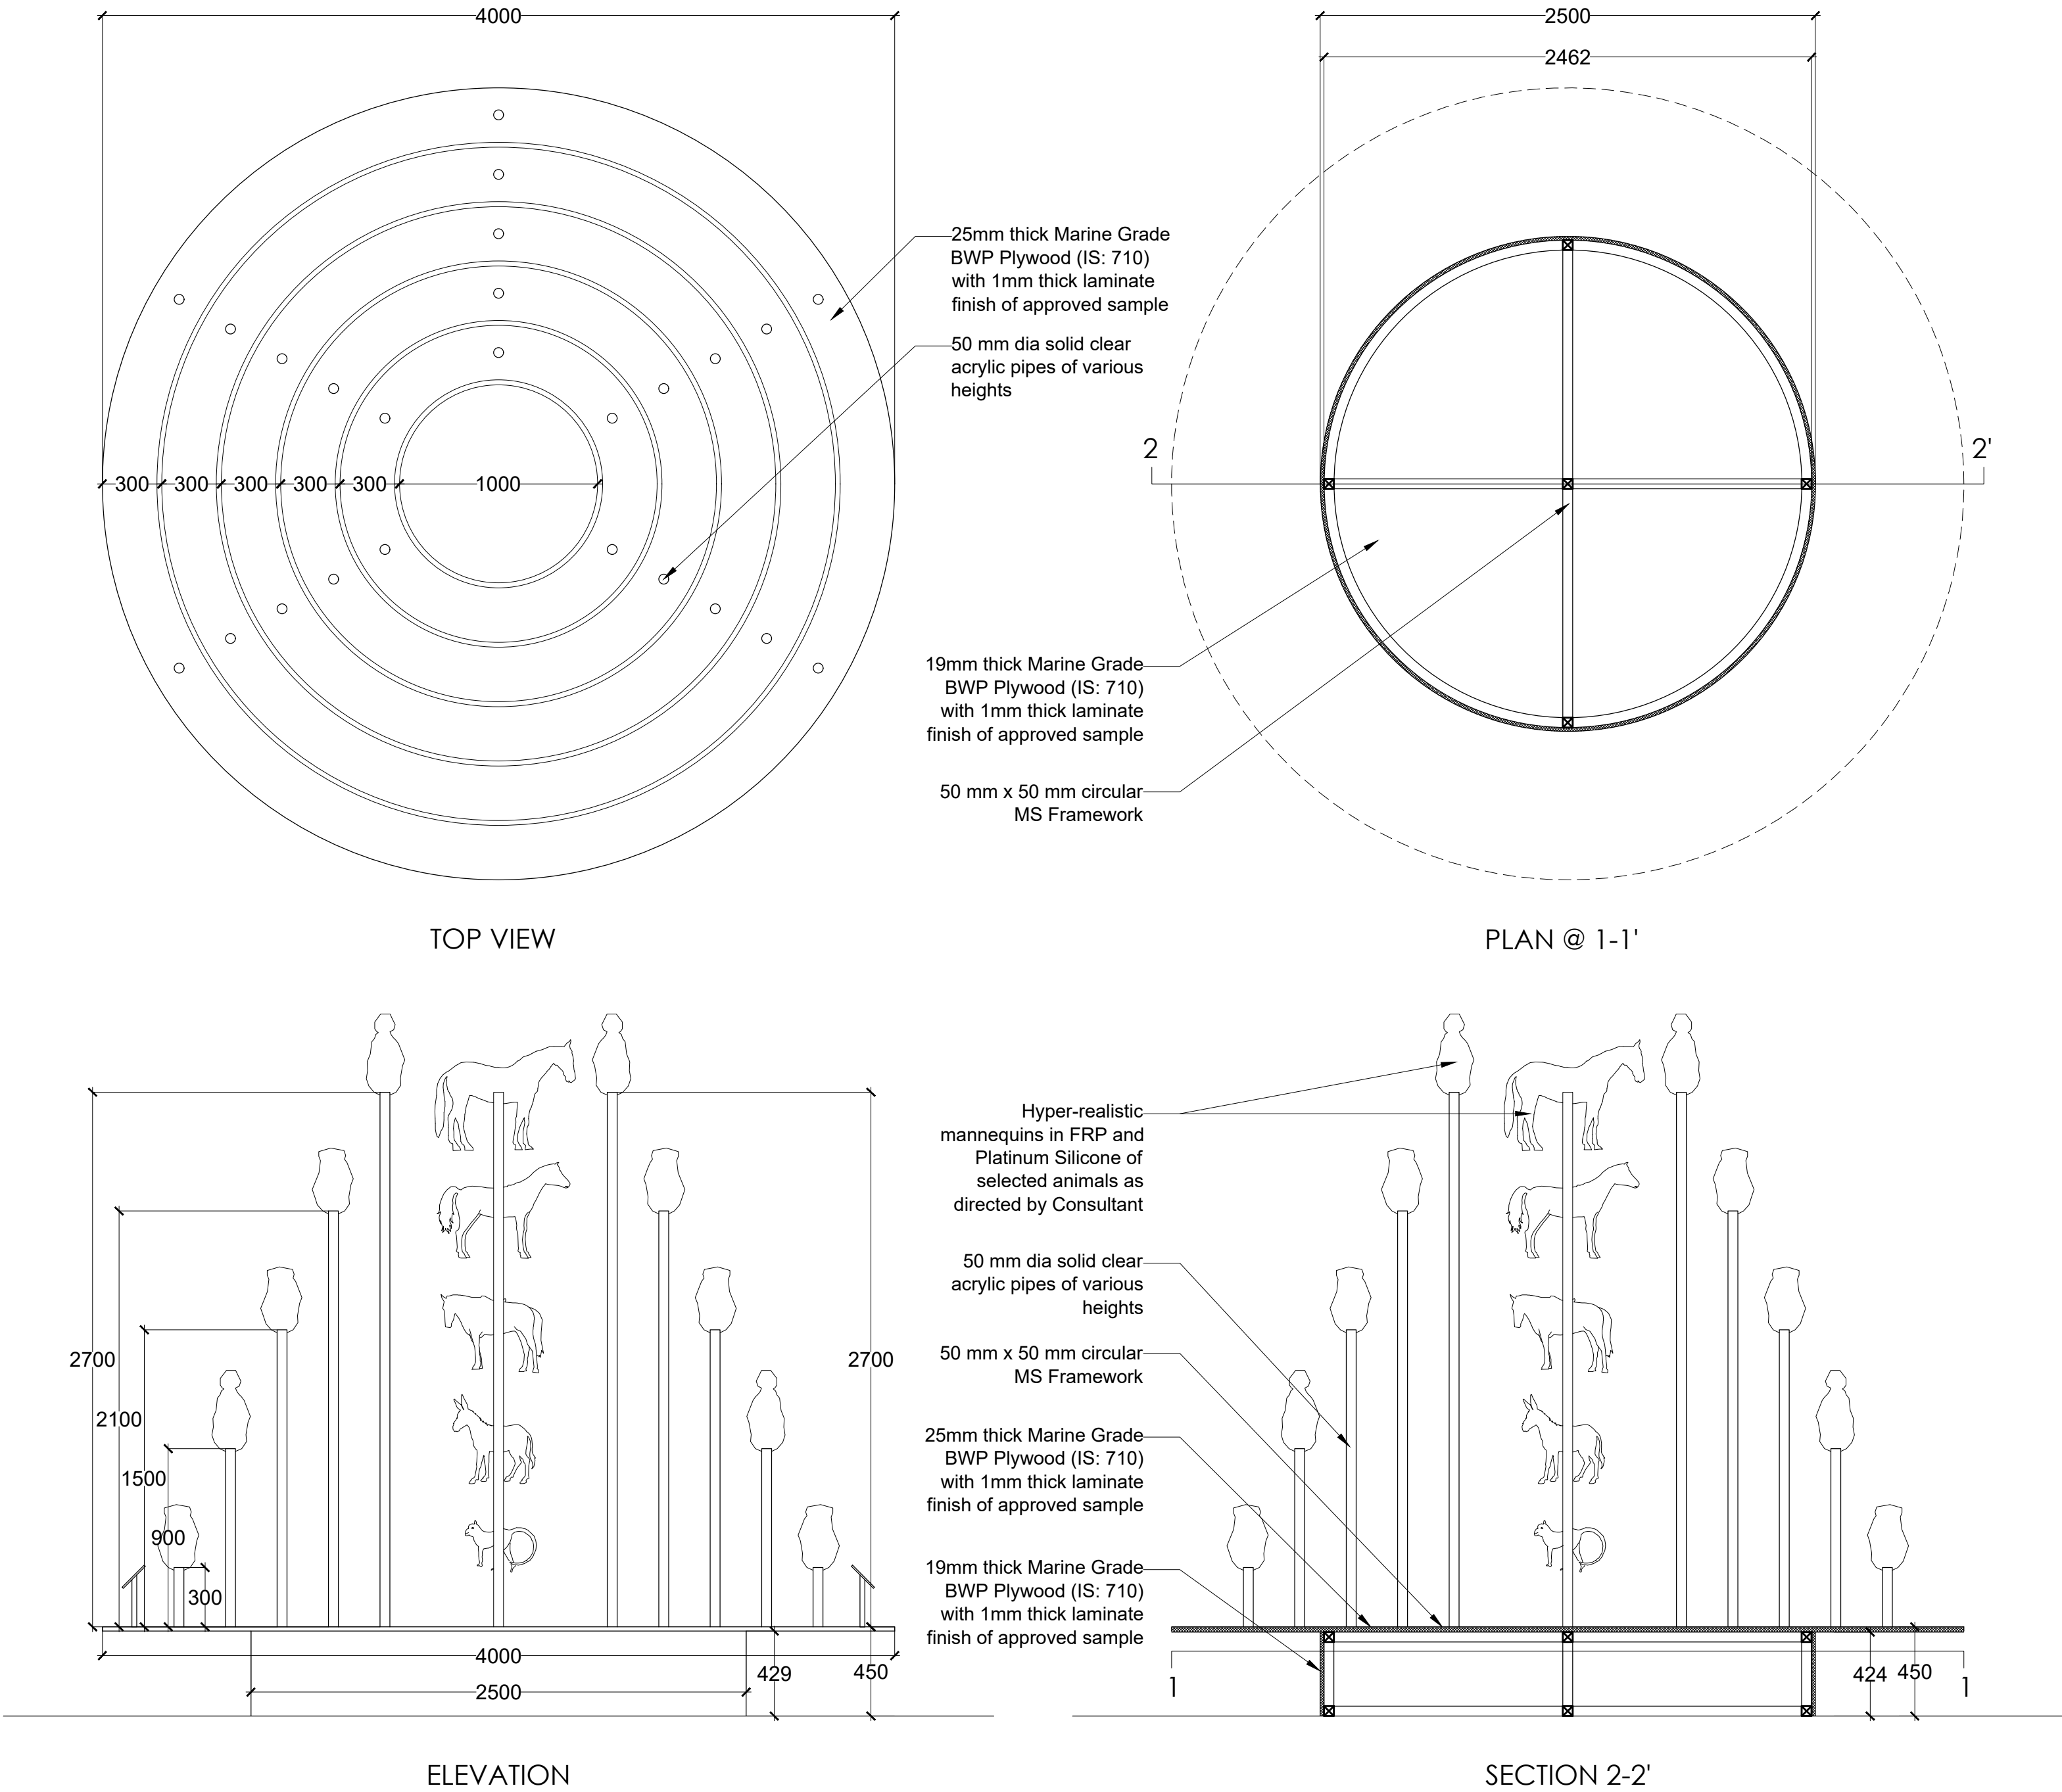

NOTES:

All dimensions are in millimeters

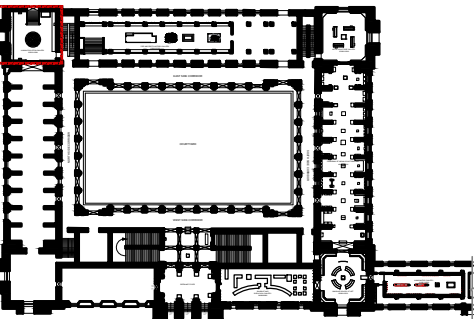

LEGEND

DP	Display Panel
DC	Display Case
DS	Display Shelf
PE	Pedestal
WM	Wall Mural
WG	Wall Graphics
CP	Canvas Painting
M	Model
MET	Mock Excavation Trench
CP	Canvas Painting
AV	Audio Visuals
I	Interactive
P	Projection
HP	Holographic Projection
GS	Gallery Signage
DS	Directional Signage
LG	Logo
RT	Reception Table
CC	Crowd Control Barrier

SCALE: 1:25

0 1m 2m



DRAWING NAME: LAYOUT

HUMAN EVOLUTION GALLERY

DRAWN BY: Sohini Pyne

CHECKED BY: Shikha Jain

DRAWING NUMBER: IMK/GF/HE/06

Tender Drawings

PROJECT:


PLANNING, CONTENT DEVELOPMENT, DESIGNING, RETROFITTING AND CURATORIAL WORK FOR THE INDIAN MUSEUM, KOLKATA

INDIAN MUSEUM, KOLKATA

CONSULTANT:

**DRONAH**  
DEVELOPMENT & RESEARCH  
ORGANISATION FOR NATURE,ARTS  
& HERITAGE

A-258, SOUTH CITY-1  
GURGAON-122001

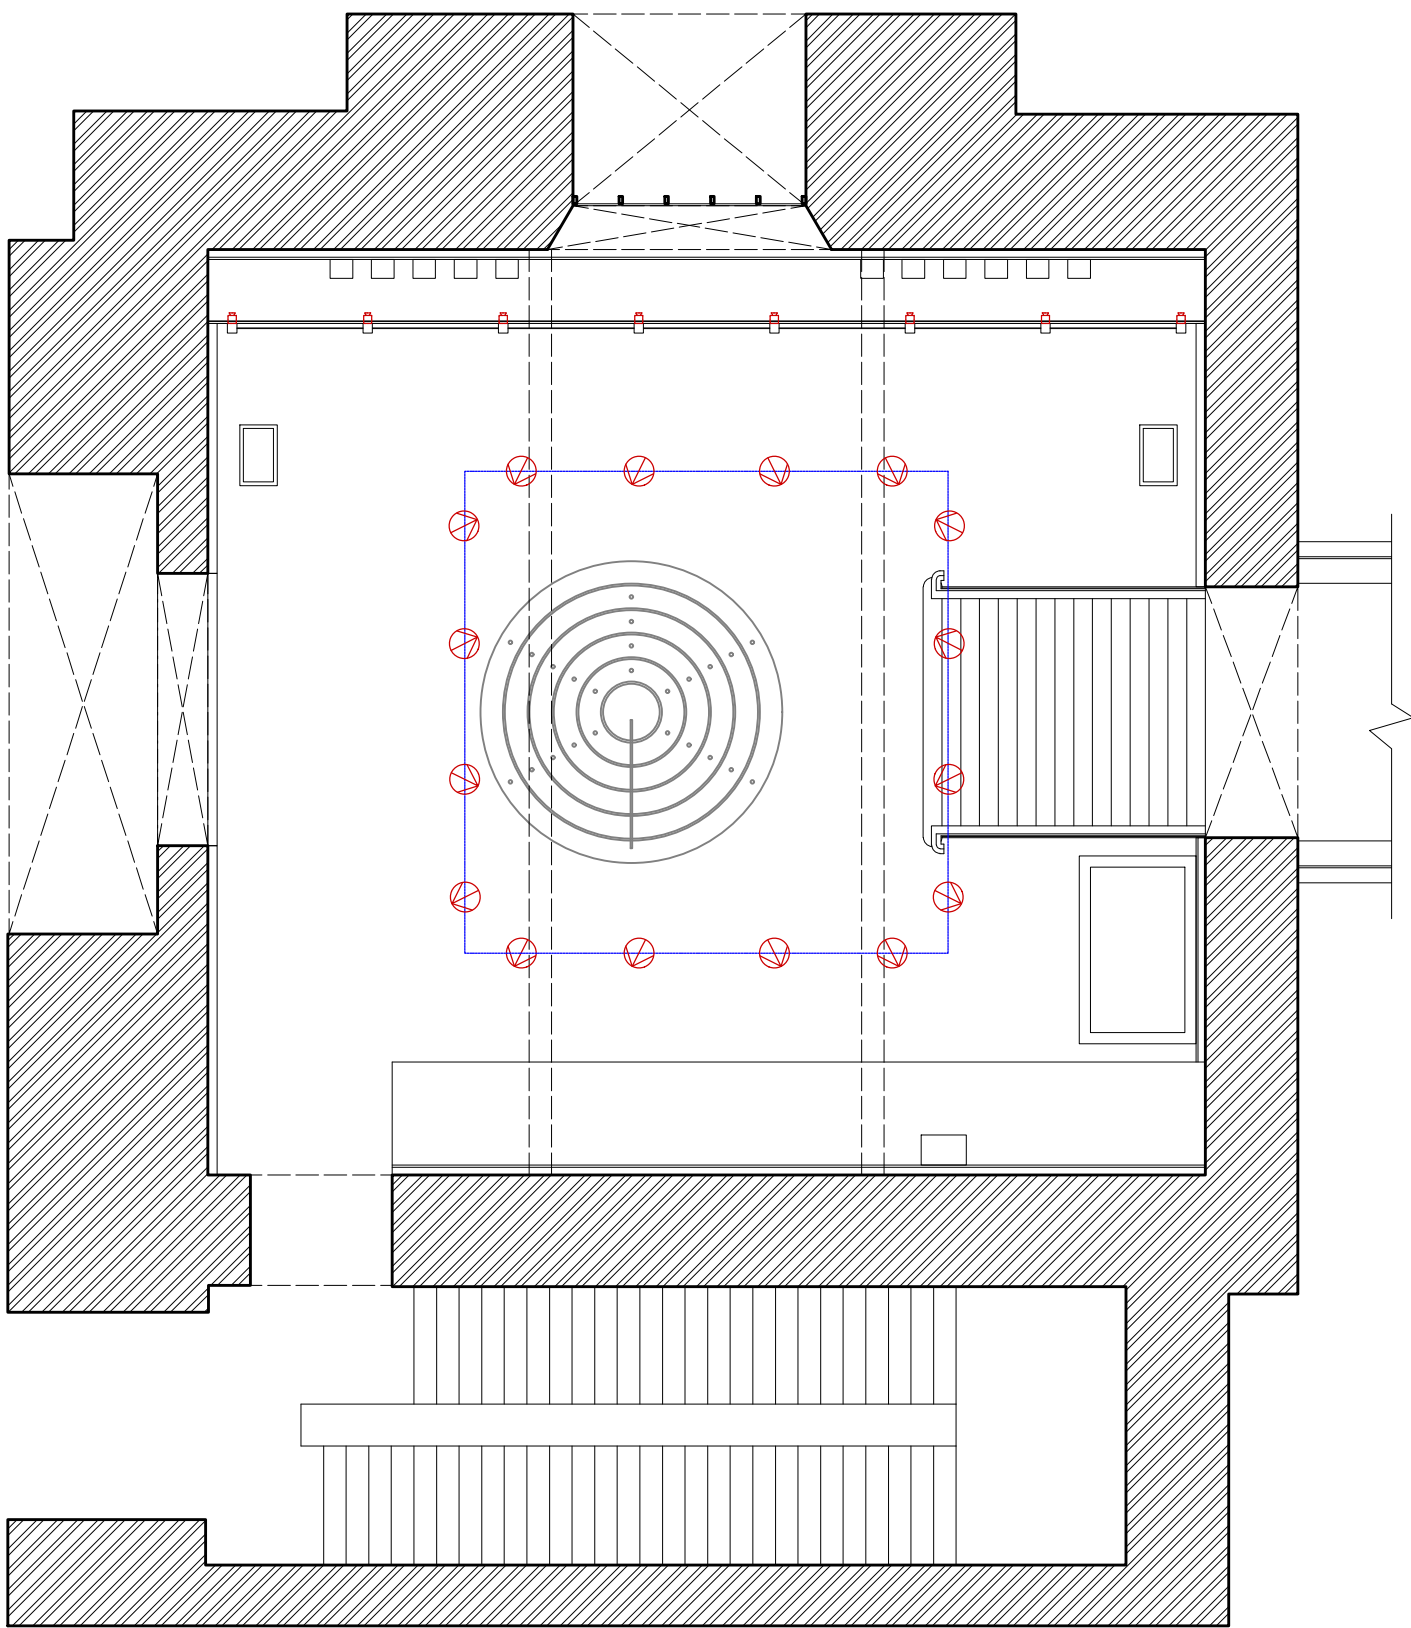



Sym	Type
	Track light on frame
	LED Pole/stand mounted cabinet lights
	Ceiling Light Conduit
	Floor Light conduit

NOTES:

All dimensions are in millimeters

KEY PLAN

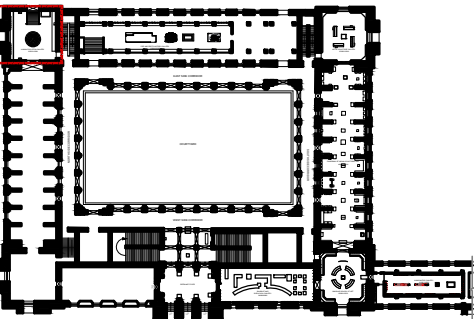

SCALE: 1:100	 NORTH
0 1m 2m	

DRAWING: LIGHTING LAYOUT  
HUMAN EVOLUTION GALLERY

DRAWN BY: Sohini Pyne

CHECKED BY: Shikha Jain

DRAWING NUMBER: IMK/GF/HE/07

SERIES: Tender Drawings


PROJECT:  
PLANNING, CONTENT  
DEVELOPMENT, DESIGNING,  
RETROFITTING AND CURATORIAL  
WORK FOR THE INDIAN MUSEUM,  
KOLKATA

CLIENT:  
INDIAN MUSEUM, KOLKATA

CONSULTANT:  
**DRONAH**  
DEVELOPMENT & RESEARCH  
ORGANISATION FOR NATURE,ARTS  
& HERITAGE  
A-258, SOUTH CITY-1  
GURGAON-122001





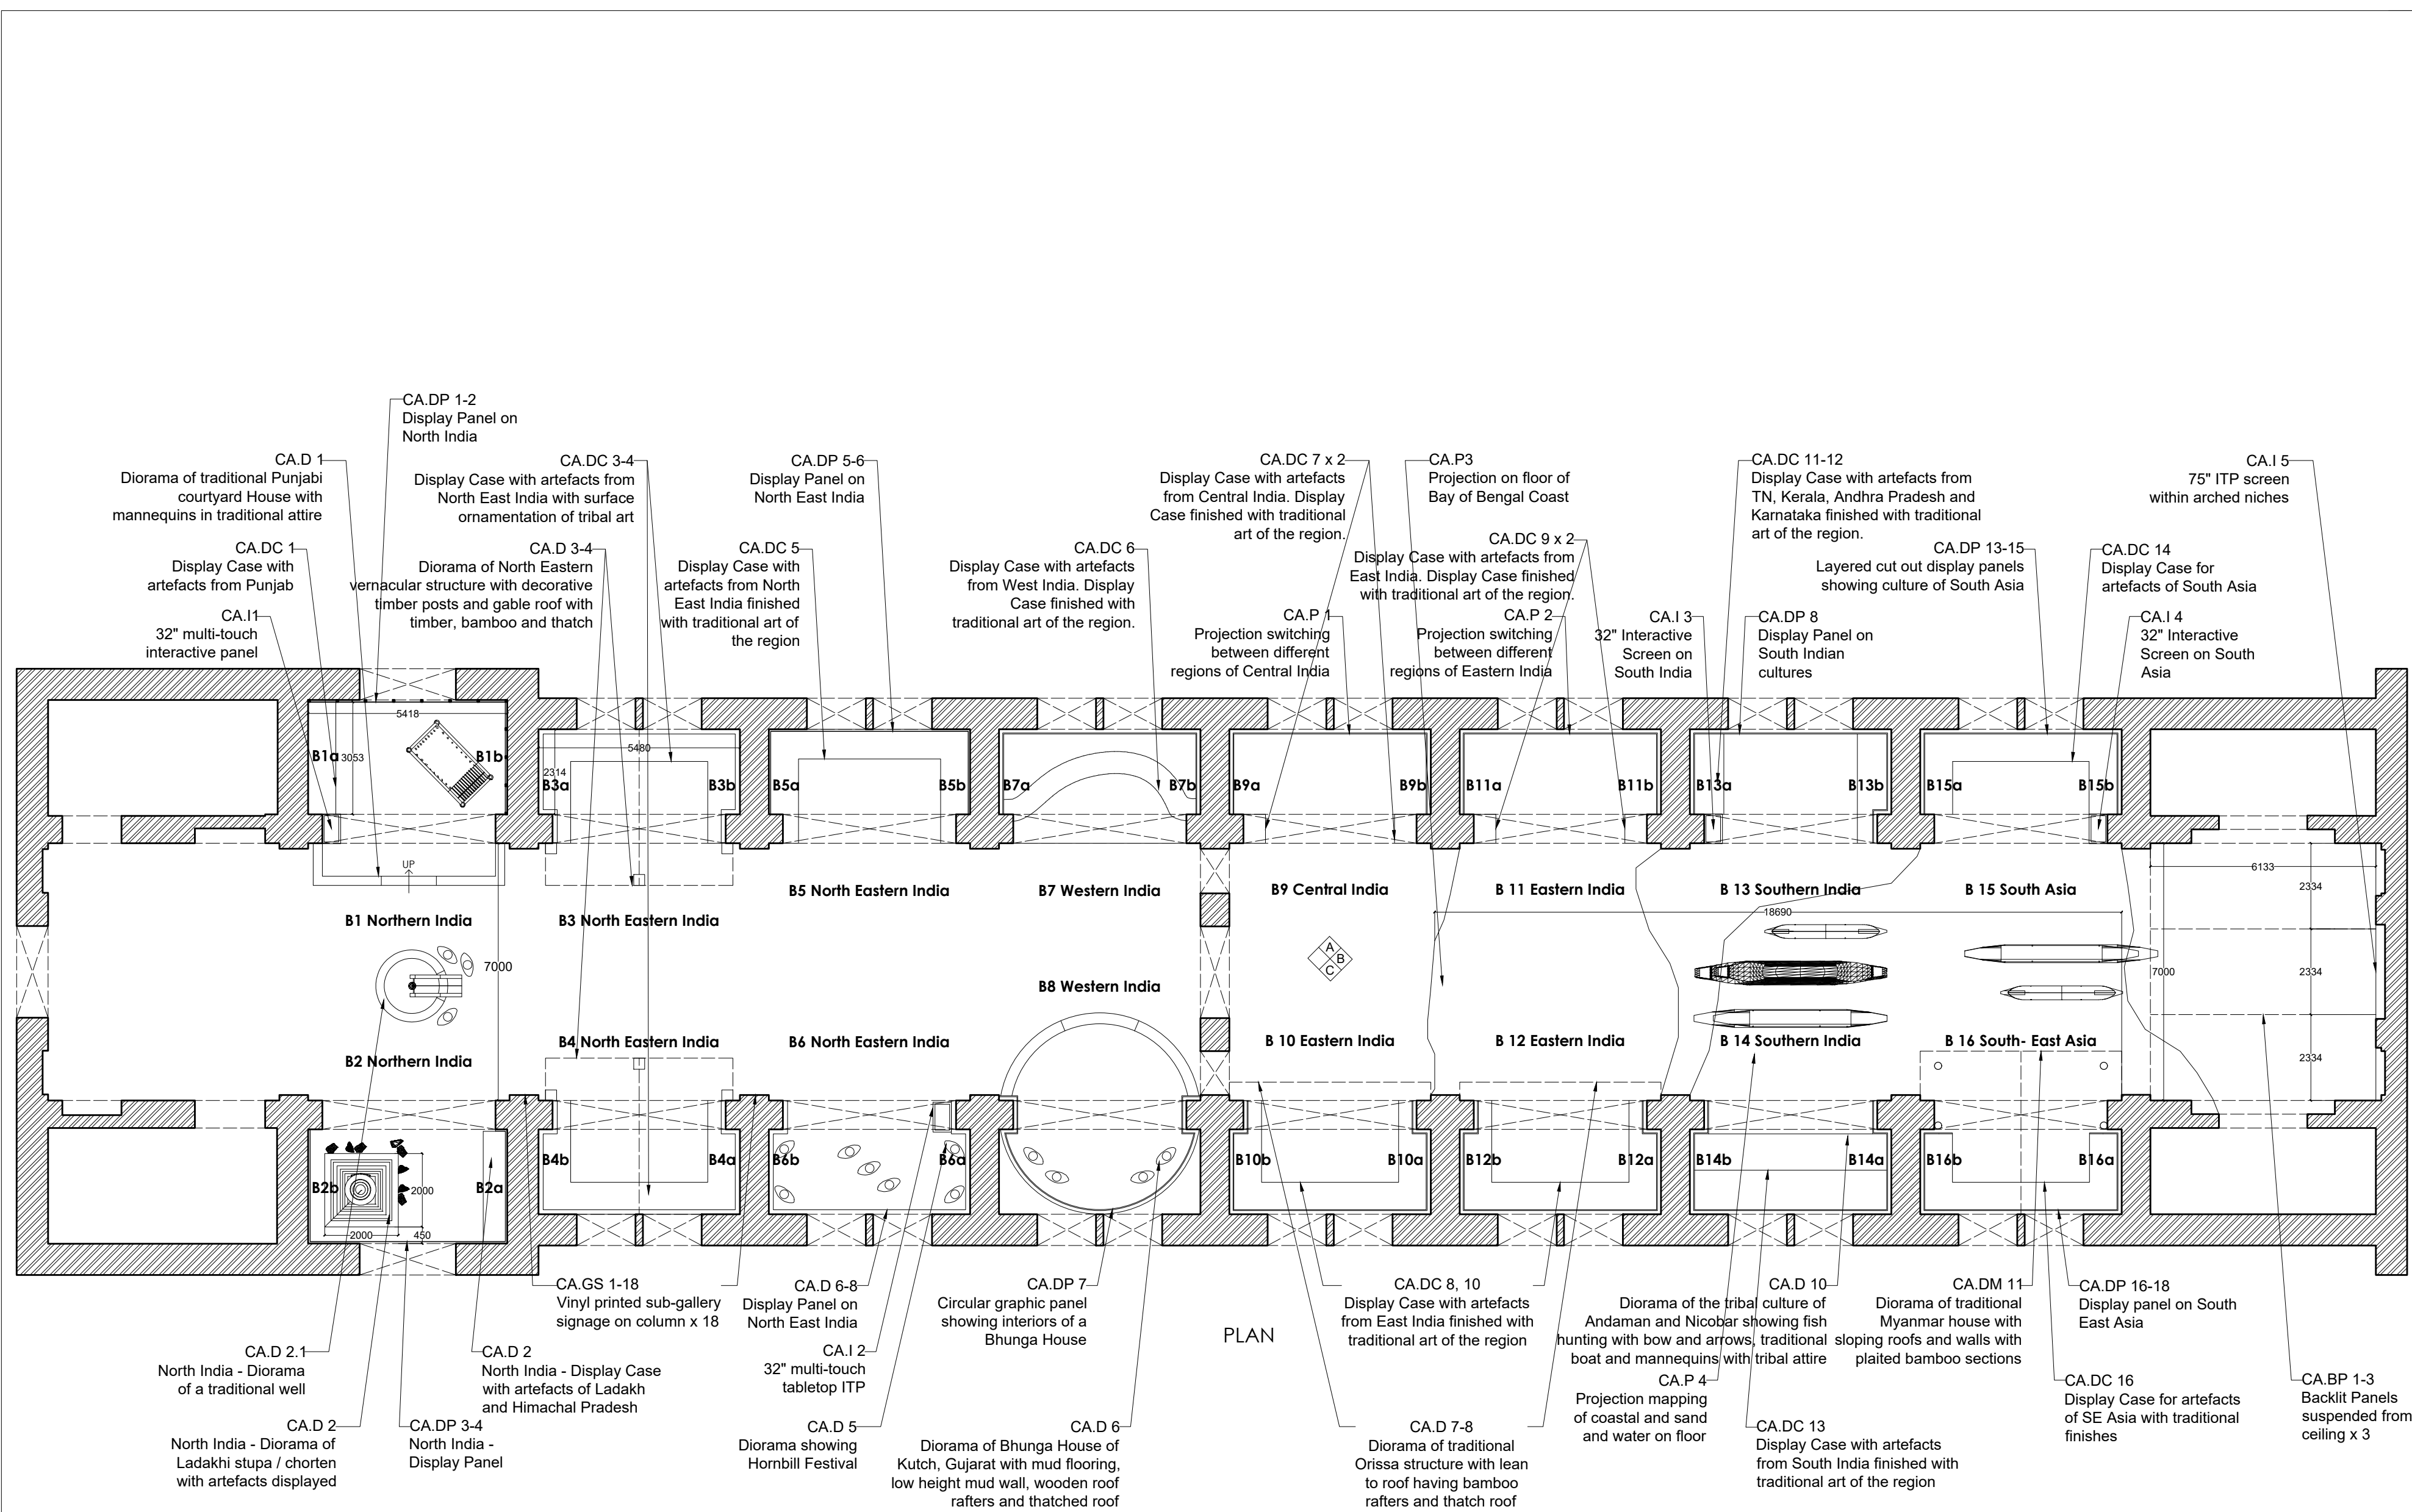

**NOTES:**  
All dimensions in millimeters  
**LEGEND**

DP	Display Panel
DC	Display Case
DS	Display Shelf
PE	Pedestal
WM	Wall Mural
WG	Wall Graphics
CP	Canvas Painting
M	Model
MET	Mock Excavation Trench
CA	Canvas Painting
AV	Audio Visuals
I	Interactive
P	Projection
HP	Holographic Projection
GS	Gallery Signage
DS	Directional Signage
LG	Logo
RT	Reception Table
CC	Crowd Control Barrier

SCALE: 1:100

0 1m 2m

NORTH

DRAWING NAME: LAYOUT

CULTURAL ANTHROPOLOGY

DRAWN BY: Sohini Pyne

CHECKED BY: Shikha Jain

DRAWING NO: IMK/GF/CA/01

SERIES: Tender Drawings

PROJECT:

PLANNING, CONTENT DEVELOPMENT, DESIGNING, RETROFITTING AND CURATORIAL WORK FOR THE INDIAN MUSEUM, KOLKATA

CLIENT:

INDIAN MUSEUM, KOLKATA

CONSULTANT:


DRONAH  
DEVELOPMENT & RESEARCH ORGANISATION FOR NATURE,ARTS & HERITAGE  
A-258, SOUTH CITY-1  
GURGAON-122001

**NOTES:**


All dimensions in millimeters

## LEGEND


DP	Display Panel
DC	Display Case
DS	Display Shelf
PE	Pedestal
WM	Wall Mural
WG	Wall Graphics
CP	Canvas Paint
M	Model
MET	Mock Excavation
CP	Canvas Paint
AV	Audio Visuals
I	Interactive
P	Projection
HP	Holographic Projection
GS	Gallery Signage
DS	Directional Signage
LG	Logo
RT	Reception Table
CC	Crowd Control

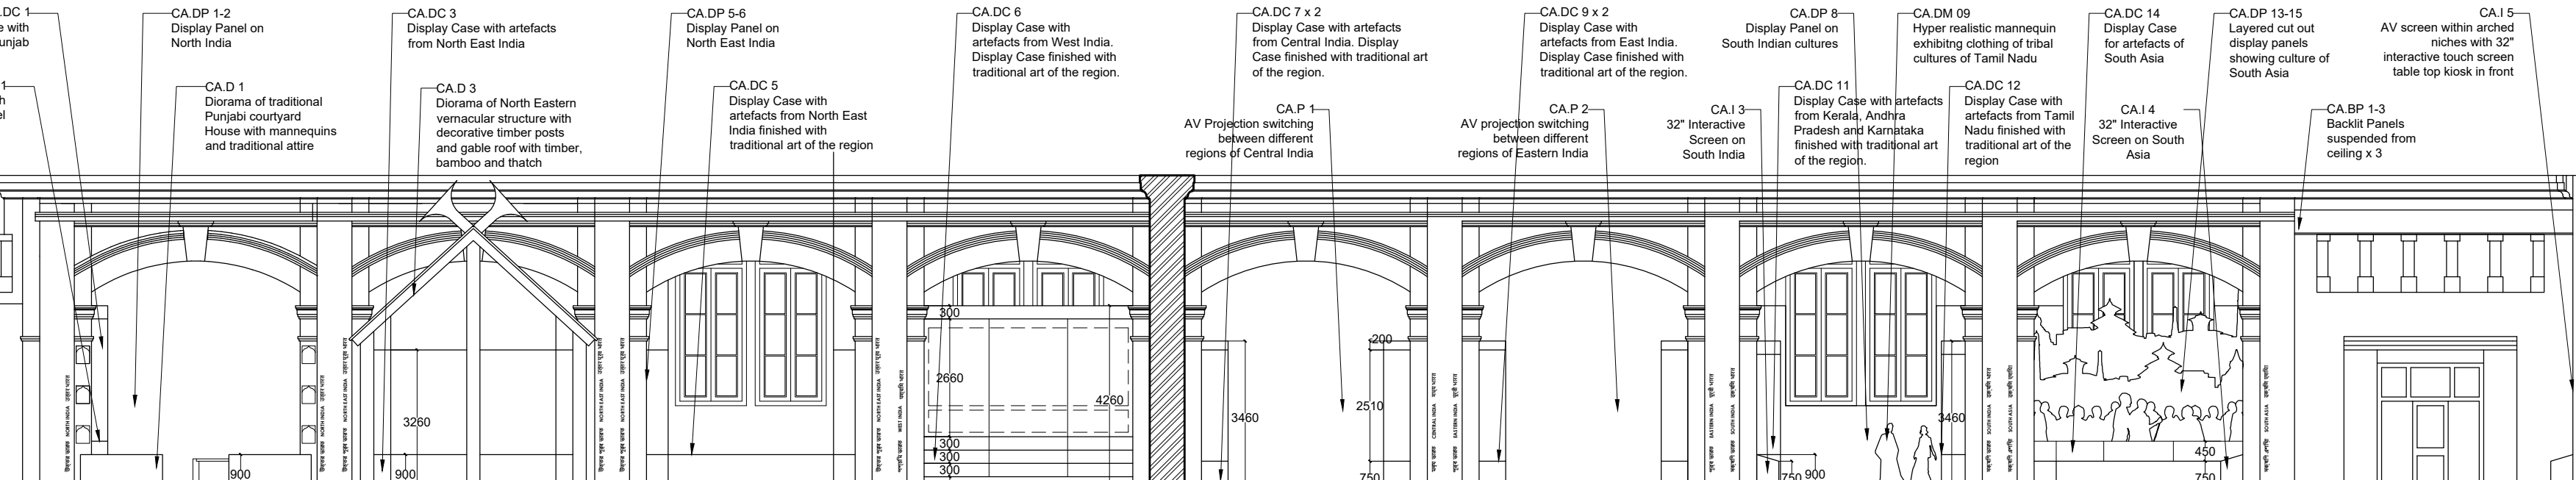

ELEVATION.

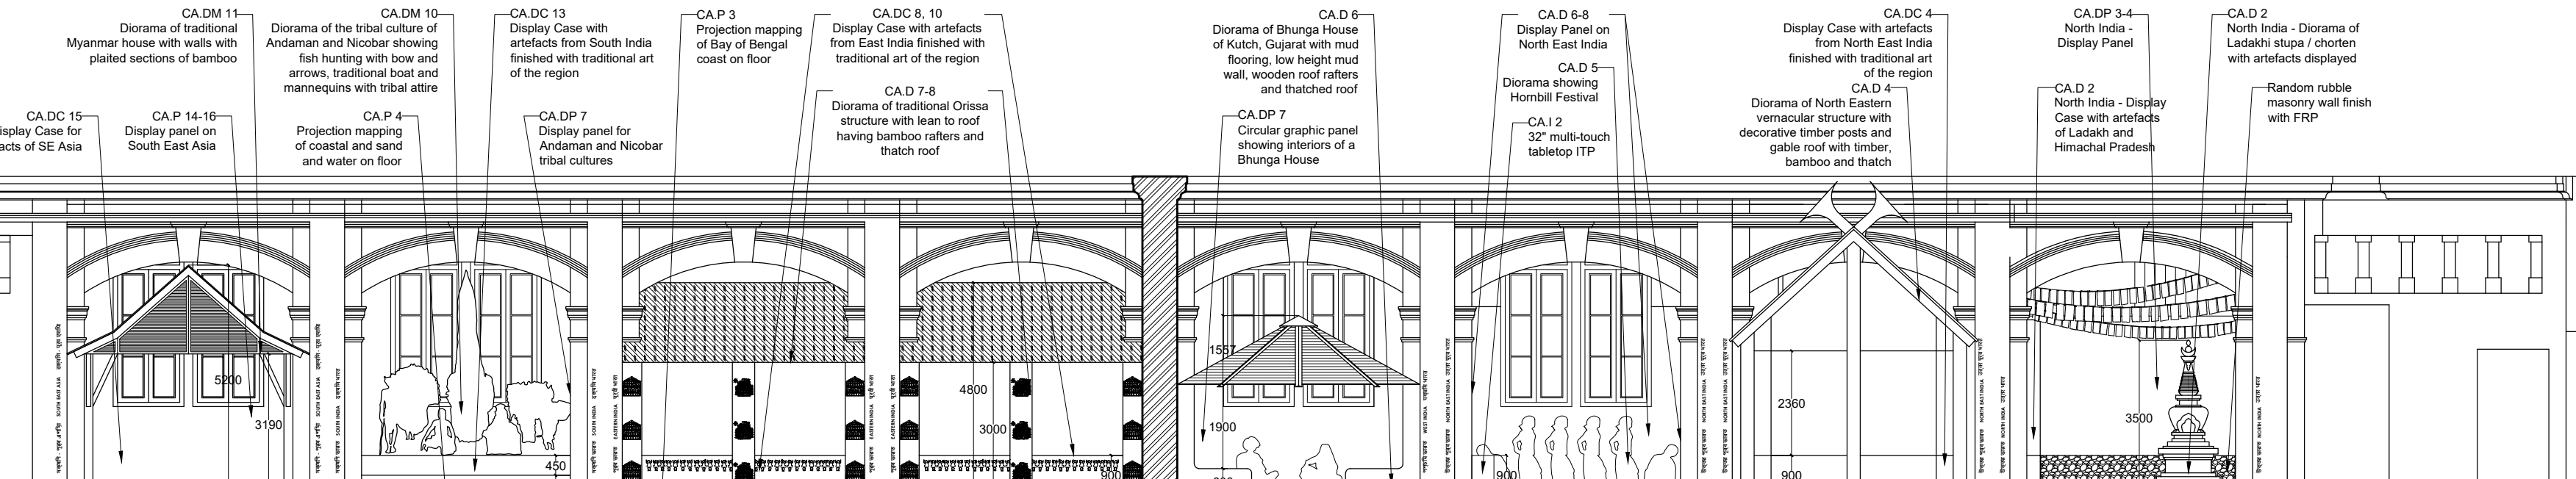

ELEVATION (m)

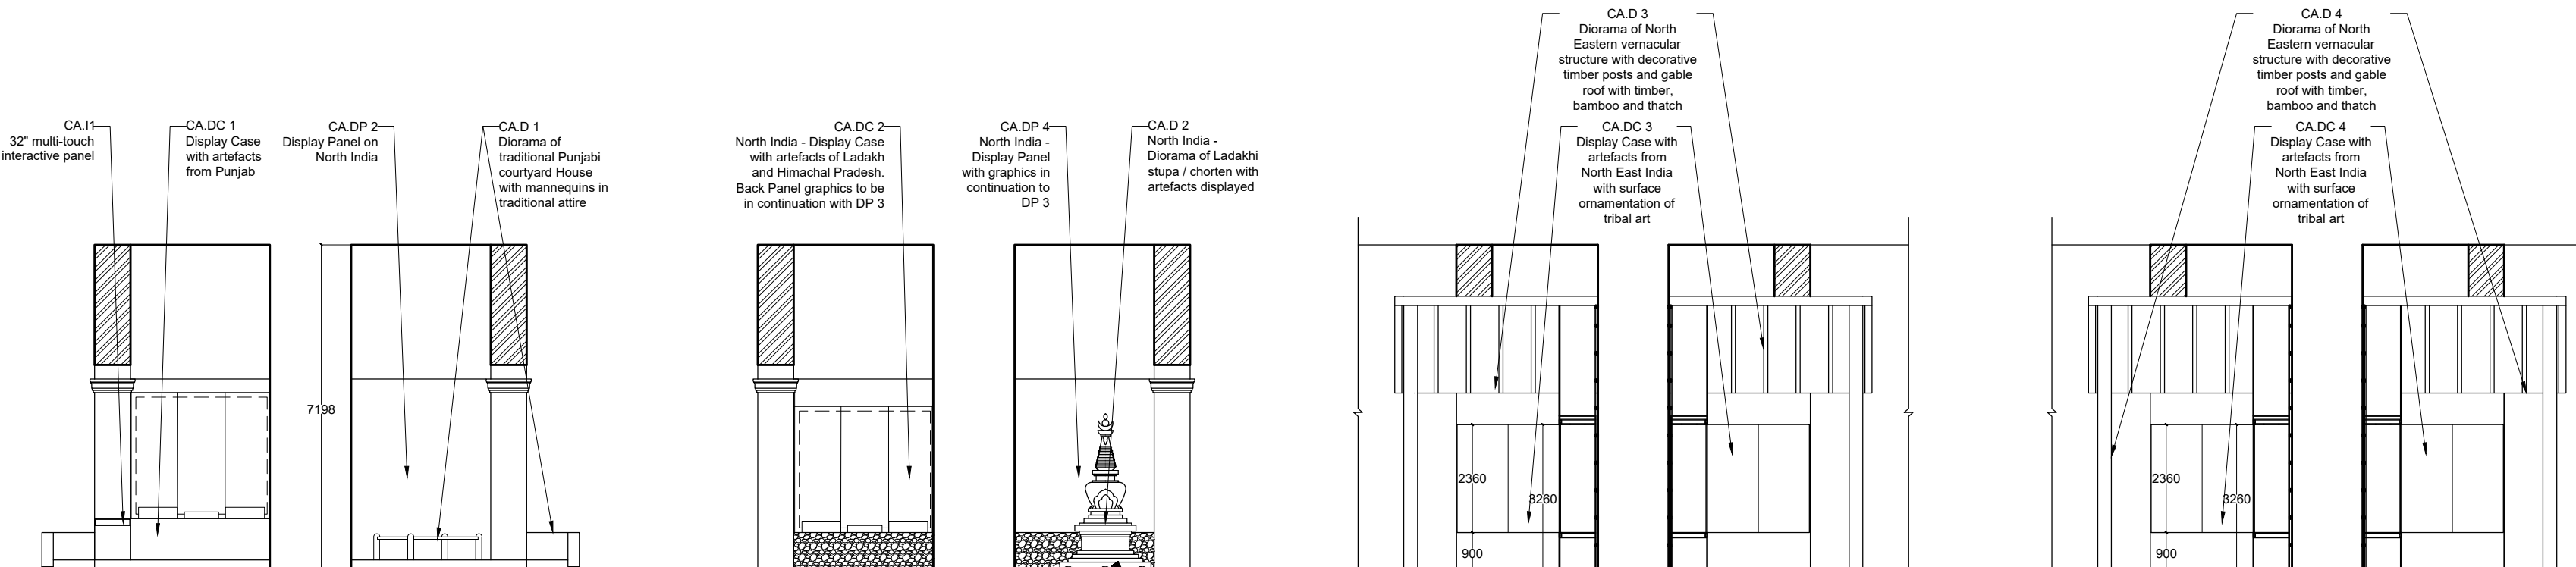

## INTERNAL ELEVATION B1a and B1

## INTERNAL ELEVATION B2a and B2b

### INTERNAL ELEVATION B3a and B2

INTERNAL ELEVATION B4g and B

**SCALE:** 1:100

0 1m 2m



# NORTH

DRAWING NAME: LAYOUT

## CULTURAL ANTHROPOLOGY

DRAWN BY: Sohini Pyne

**CHECKED BY:** Shikha Jain

**DRAWING NO:** IMK/GF/CA/C

**SERIES:** Tender Drawing

## PROJECT:

LANNING, CONTENT  
DEVELOPMENT, DESIGNING,  
RETROFITTING AND  
CURATORIAL WORK FOR THE  
INDIAN MUSEUM, KOLKATA


**CLIENT:**

INDIAN MUSEUM, KOLKATA


**CONSULTANT:**

**DRONAH**  
DEVELOPMENT & RESEARCH  
ORGANISATION FOR  
NATURE, ARTS & HERITAGE


A-258, SOUTH CITY-1  
GURGAON-122001

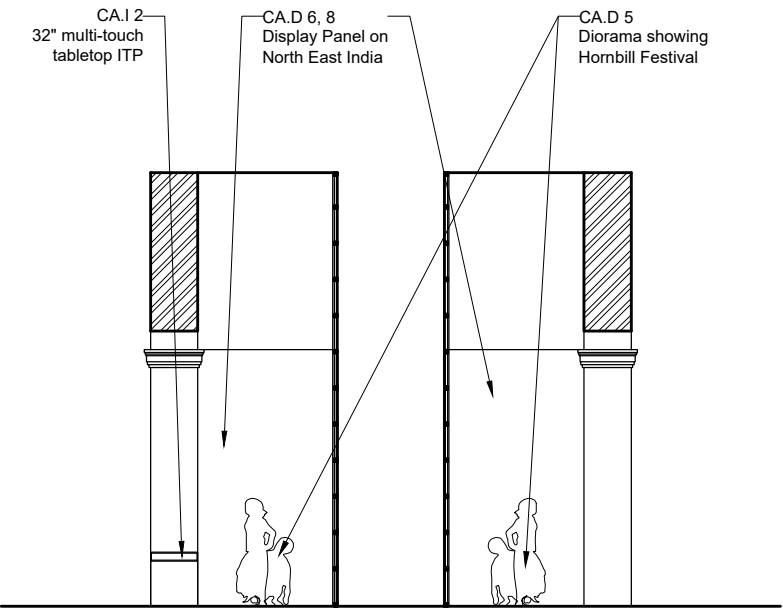


INTERNAL ELEVATION B6a and B6b

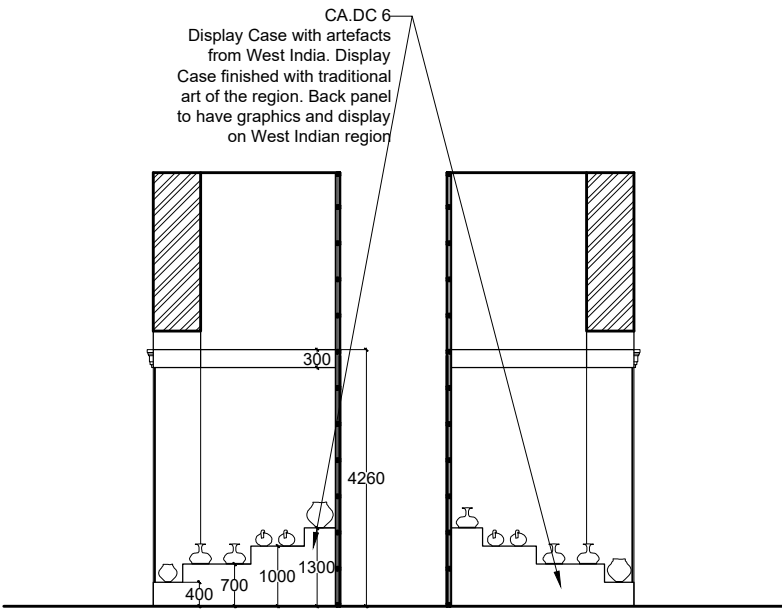


INTERNAL ELEVATION B7a and B7b

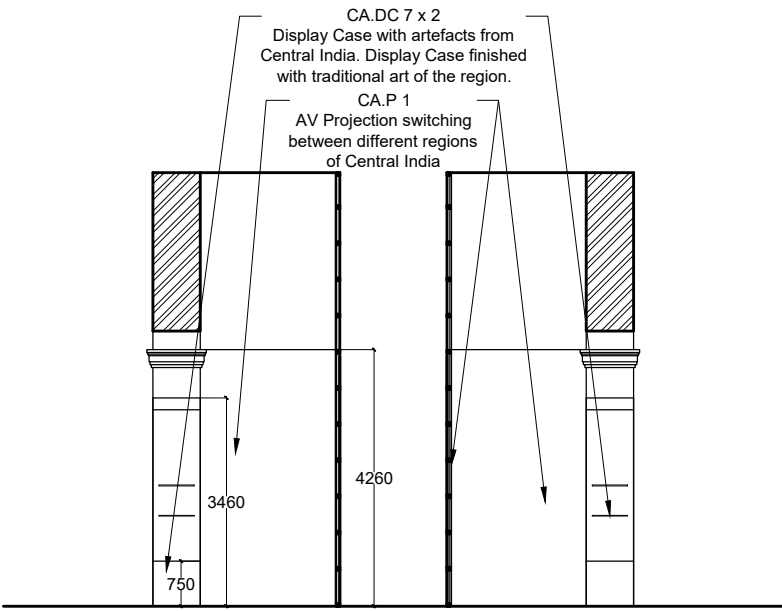


INTERNAL ELEVATION B9a and B9b

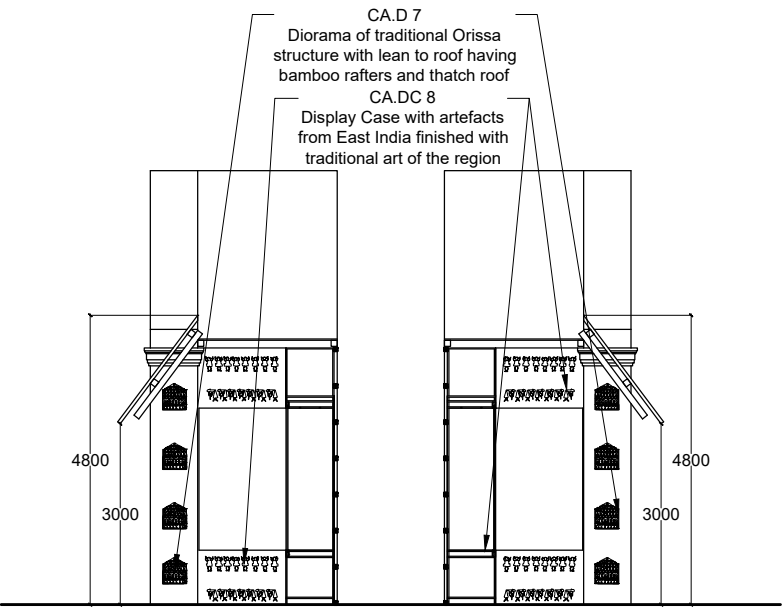


INTERNAL ELEVATION B10a and B10b

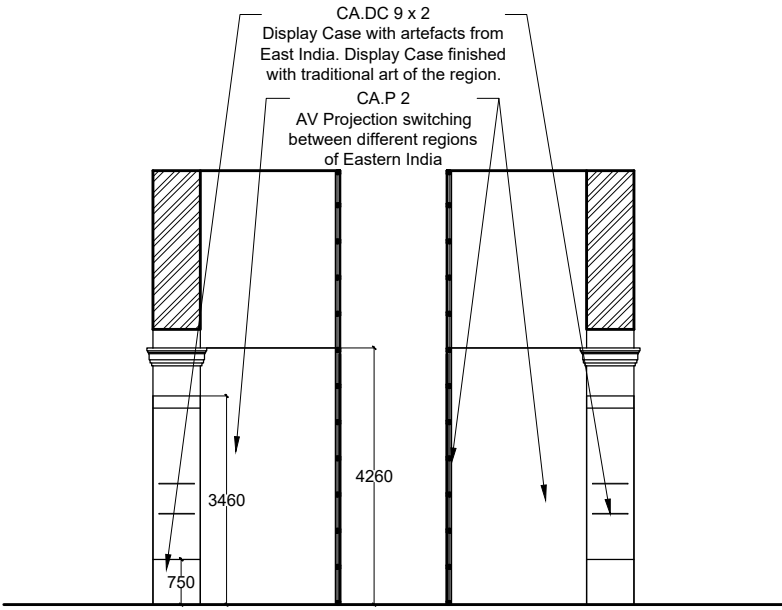


INTERNAL ELEVATION B11a and B11b

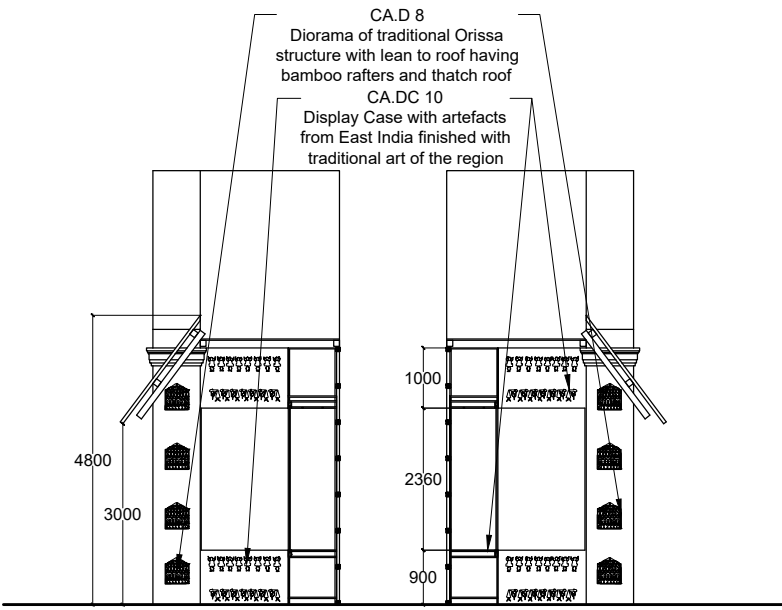


INTERNAL ELEVATION B12a and B12b

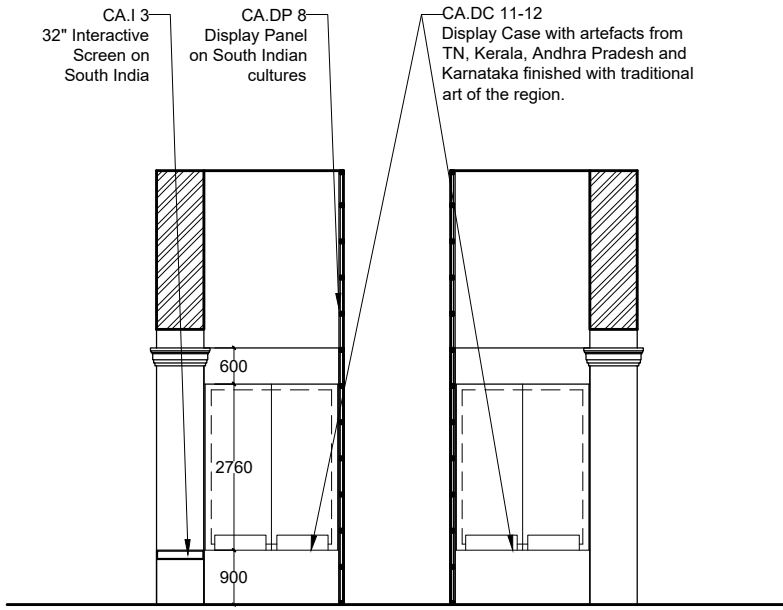


INTERNAL ELEVATION B13a and B13b

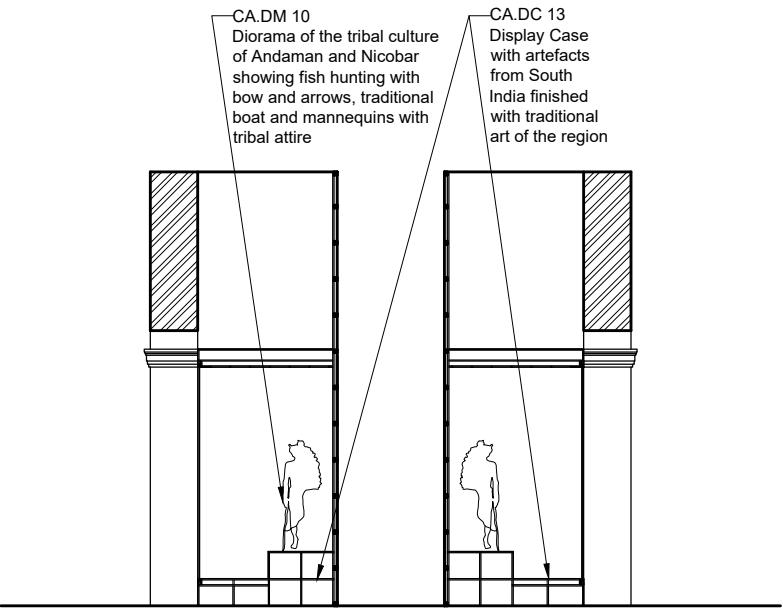

INTERNAL ELEVATION B14a and B14b

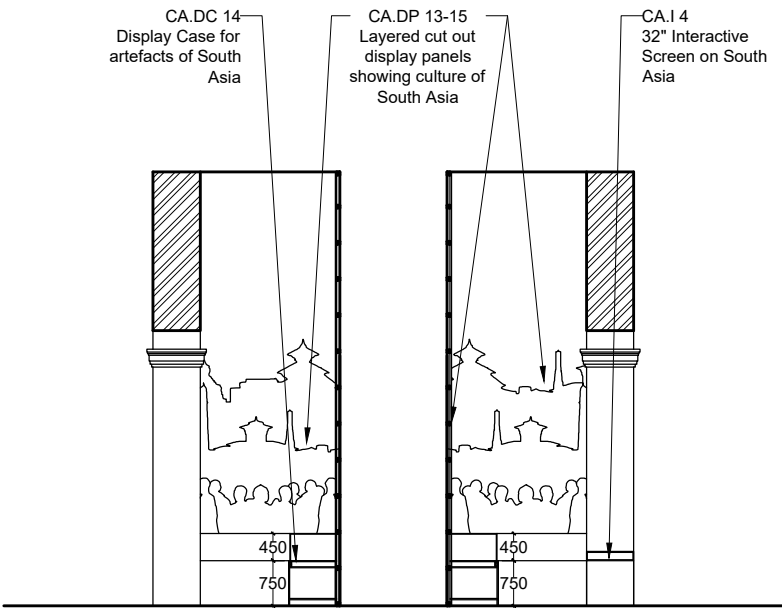

INTERNAL ELEVATION B15a and B15b

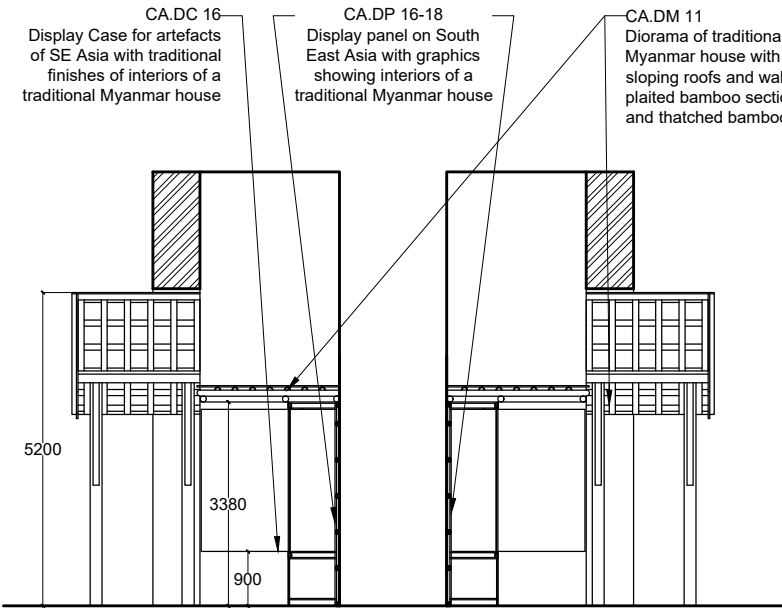

INTERNAL ELEVATION B16a and B16b

NOTES:

All dimensions in millimeters

LEGEND

DP	Display Panel
DC	Display Case
DS	Display Shelf
PE	Pedestal
WM	Wall Mural
WG	Wall Graphics
CP	Canvas Painting
M	Model
MET	Mock Excavation Trench
CP	Canvas Painting
AV	Audio Visuals
I	Interactive
P	Projection
HP	Holographic Projection
GS	Gallery Signage
DS	Directional Signage
LG	Logo
RT	Reception Table
CC	Crowd Control Barrier

SCALE: 1:100

0 1m 2m



DRAWING NAME: LAYOUT

CULTURAL ANTHROPOLOGY

DRAWN BY: Sohini Pyne

CHECKED BY: Shikha Jain

DRAWING NO: IMK/GF/CA/03

SERIES: Tender Drawings

PROJECT:

PLANNING, CONTENT  
DEVELOPMENT, DESIGNING,  
RETROFITTING AND  
CURATORIAL WORK FOR THE  
INDIAN MUSEUM, KOLKATA


CLIENT:

INDIAN MUSEUM, KOLKATA

CONSULTANT:

**DRONAH**  
DEVELOPMENT & RESEARCH  
ORGANISATION FOR  
NATURE,ARTS & HERITAGE  
A-258, SOUTH CITY-1  
GURGAON-122001



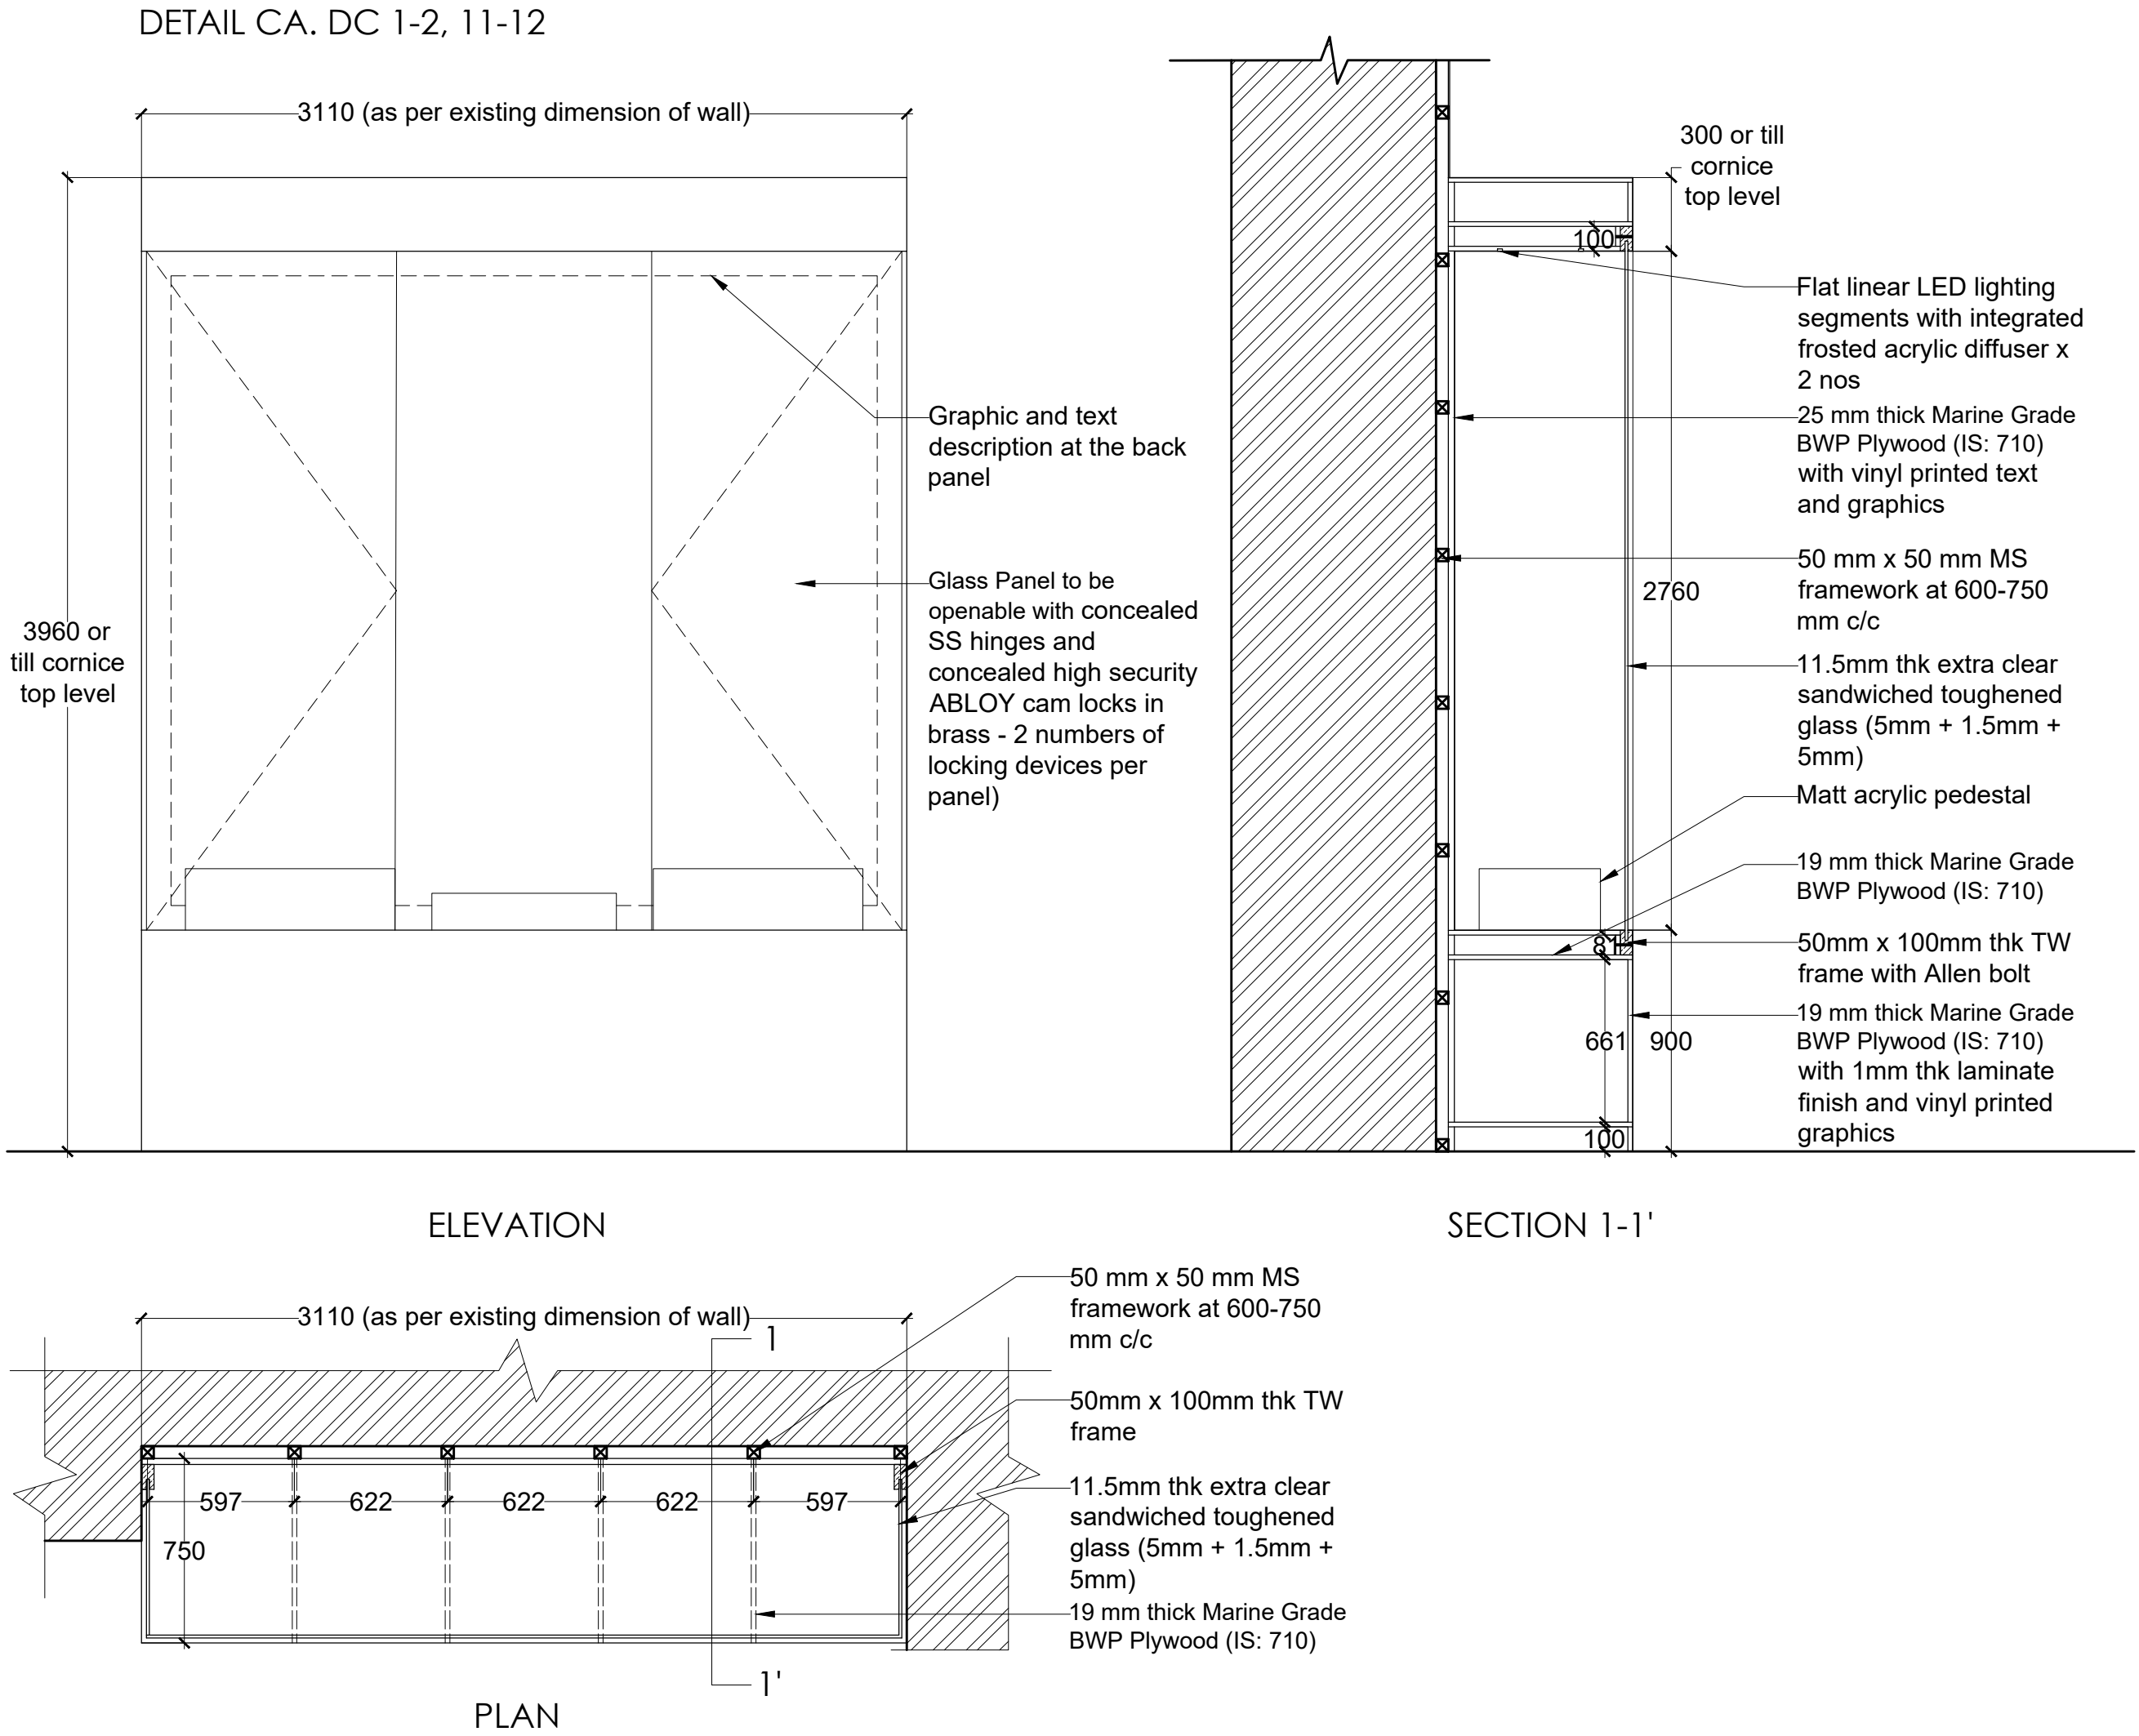

**NOTES:**

All dimensions in millimeters

**LEGEND**

DP	Display Panel
DC	Display Case
DS	Display Shelf
PE	Pedestal
WM	Wall Mural
WG	Wall Graphics
CP	Canvas Painting
M	Model
MET	Mock Excavation Trench
CP	Canvas Painting
AV	Audio Visuals
I	Interactive
P	Projection
HP	Holographic Projection
GS	Gallery Signage
DS	Directional Signage
LG	Logo
RT	Reception Table
CC	Crowd Control Barrier

**SCALE:** 1:100

0 1m 2m



**NORTH**

**DRAWING NAME:** LAYOUT

**CULTURAL ANTHROPOLOGY**

**DRAWN BY:** Sohini Pyne

**CHECKED BY:** Shikha Jain

**DRAWING NO:** IMK/GF/CA/04

**SERIES:** Tender Drawings

**PROJECT:**

PLANNING, CONTENT DEVELOPMENT, DESIGNING, RETROFITTING AND CURATORIAL WORK FOR THE INDIAN MUSEUM, KOLKATA


**CLIENT:**

INDIAN MUSEUM, KOLKATA


**CONSULTANT:**

**DRONAH**  
DEVELOPMENT & RESEARCH ORGANISATION FOR NATURE,ARTS & HERITAGE  
A-258, SOUTH CITY-1  
GURGAON-122001

DETAIL CA. DC 3, 4, 5, 8, 10,

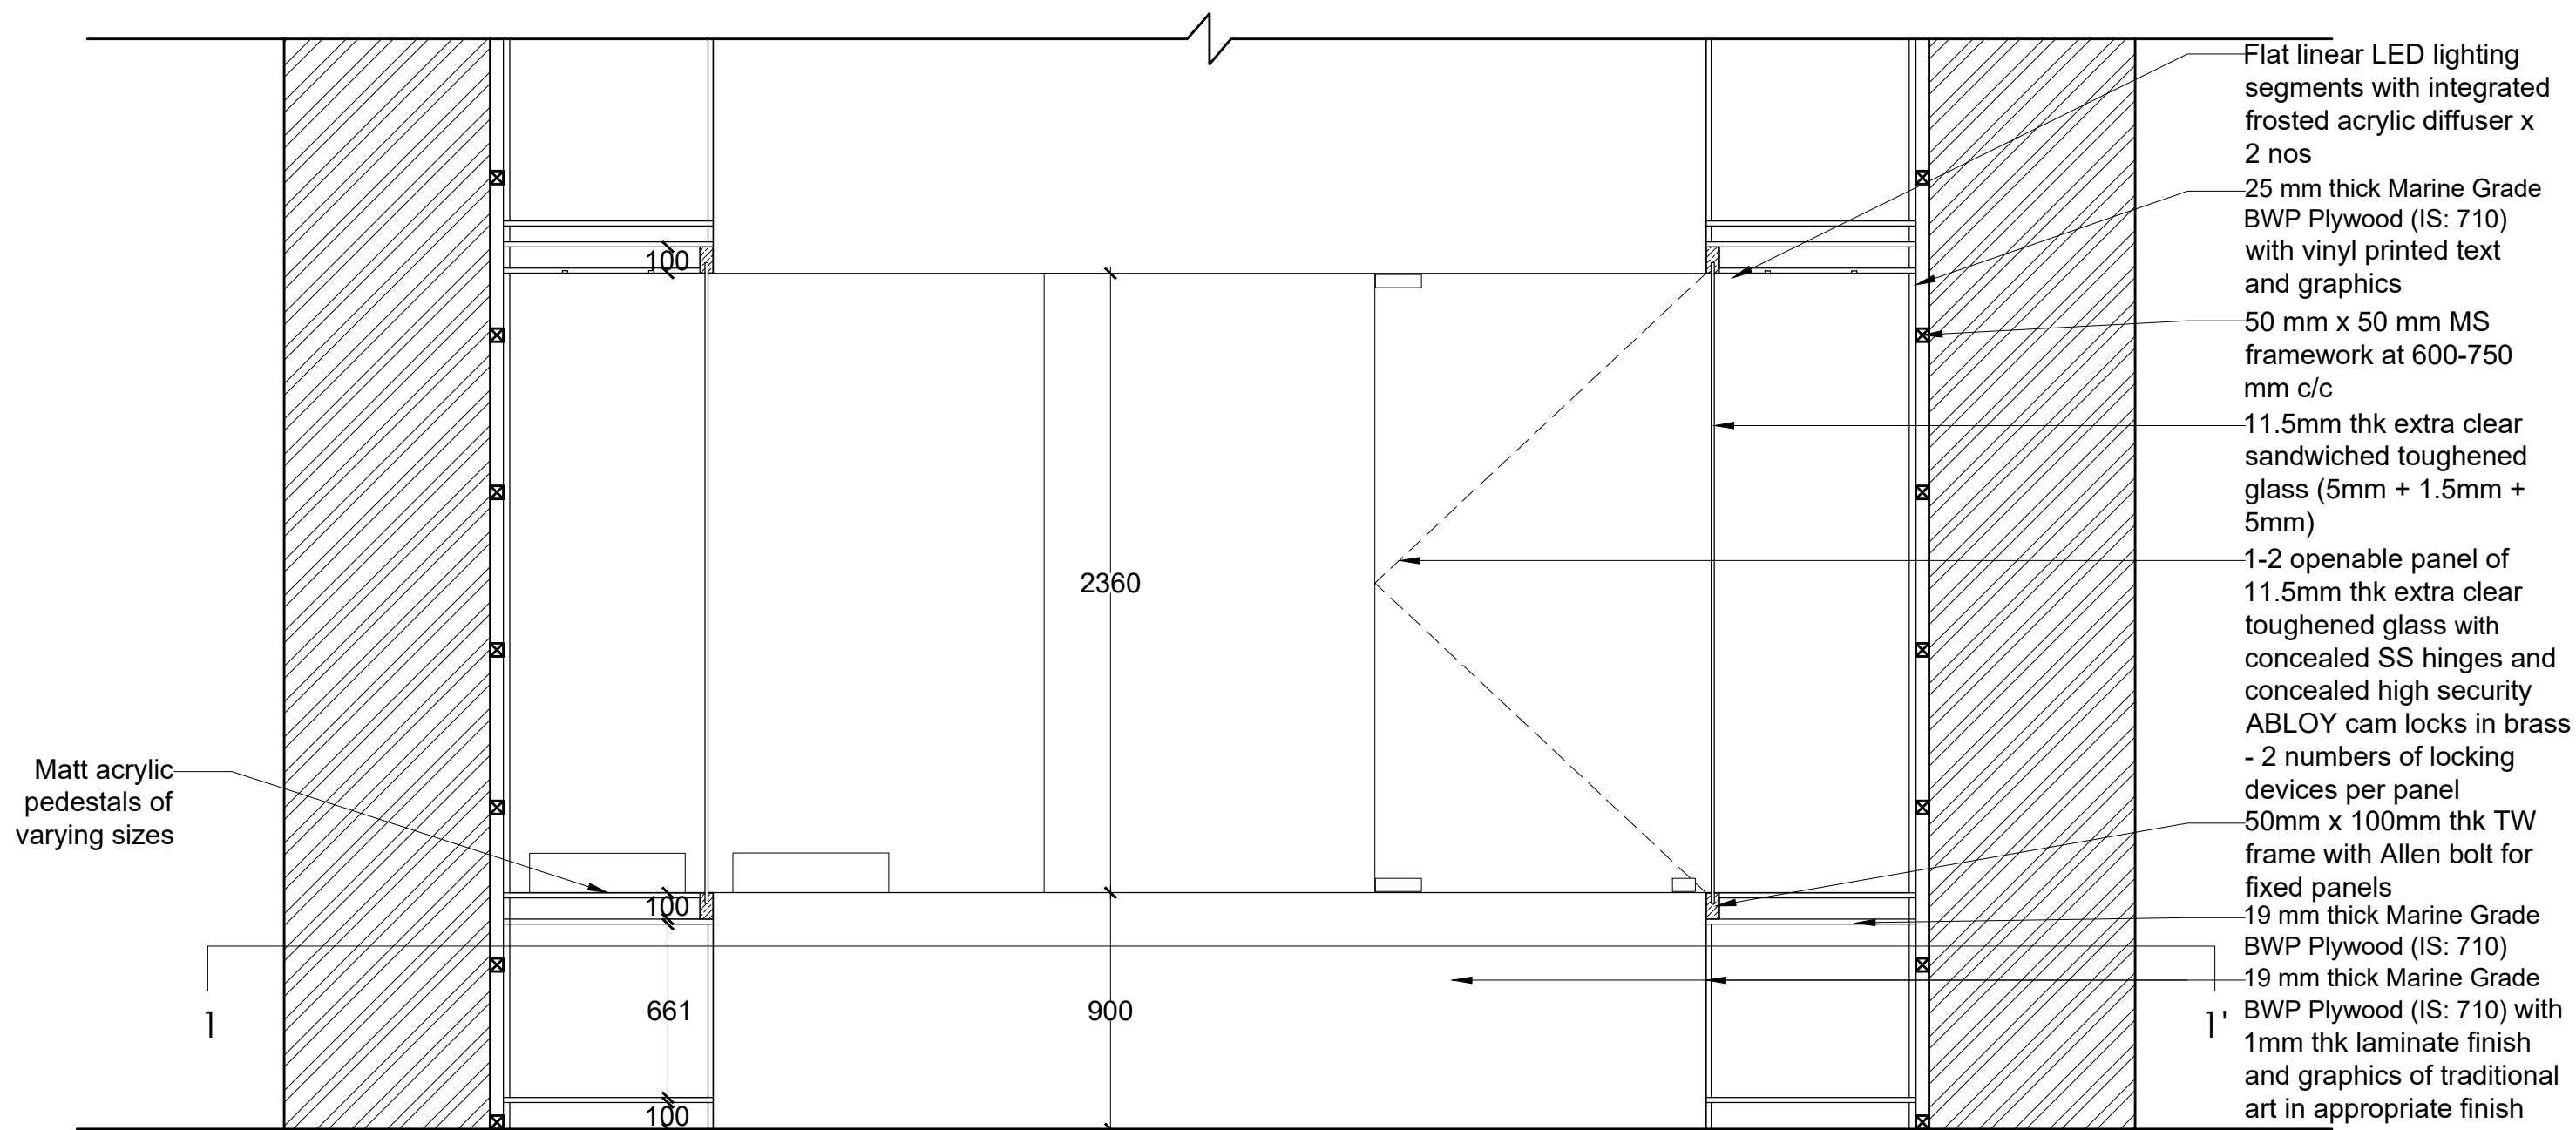

SECTIONAL ELEVATION

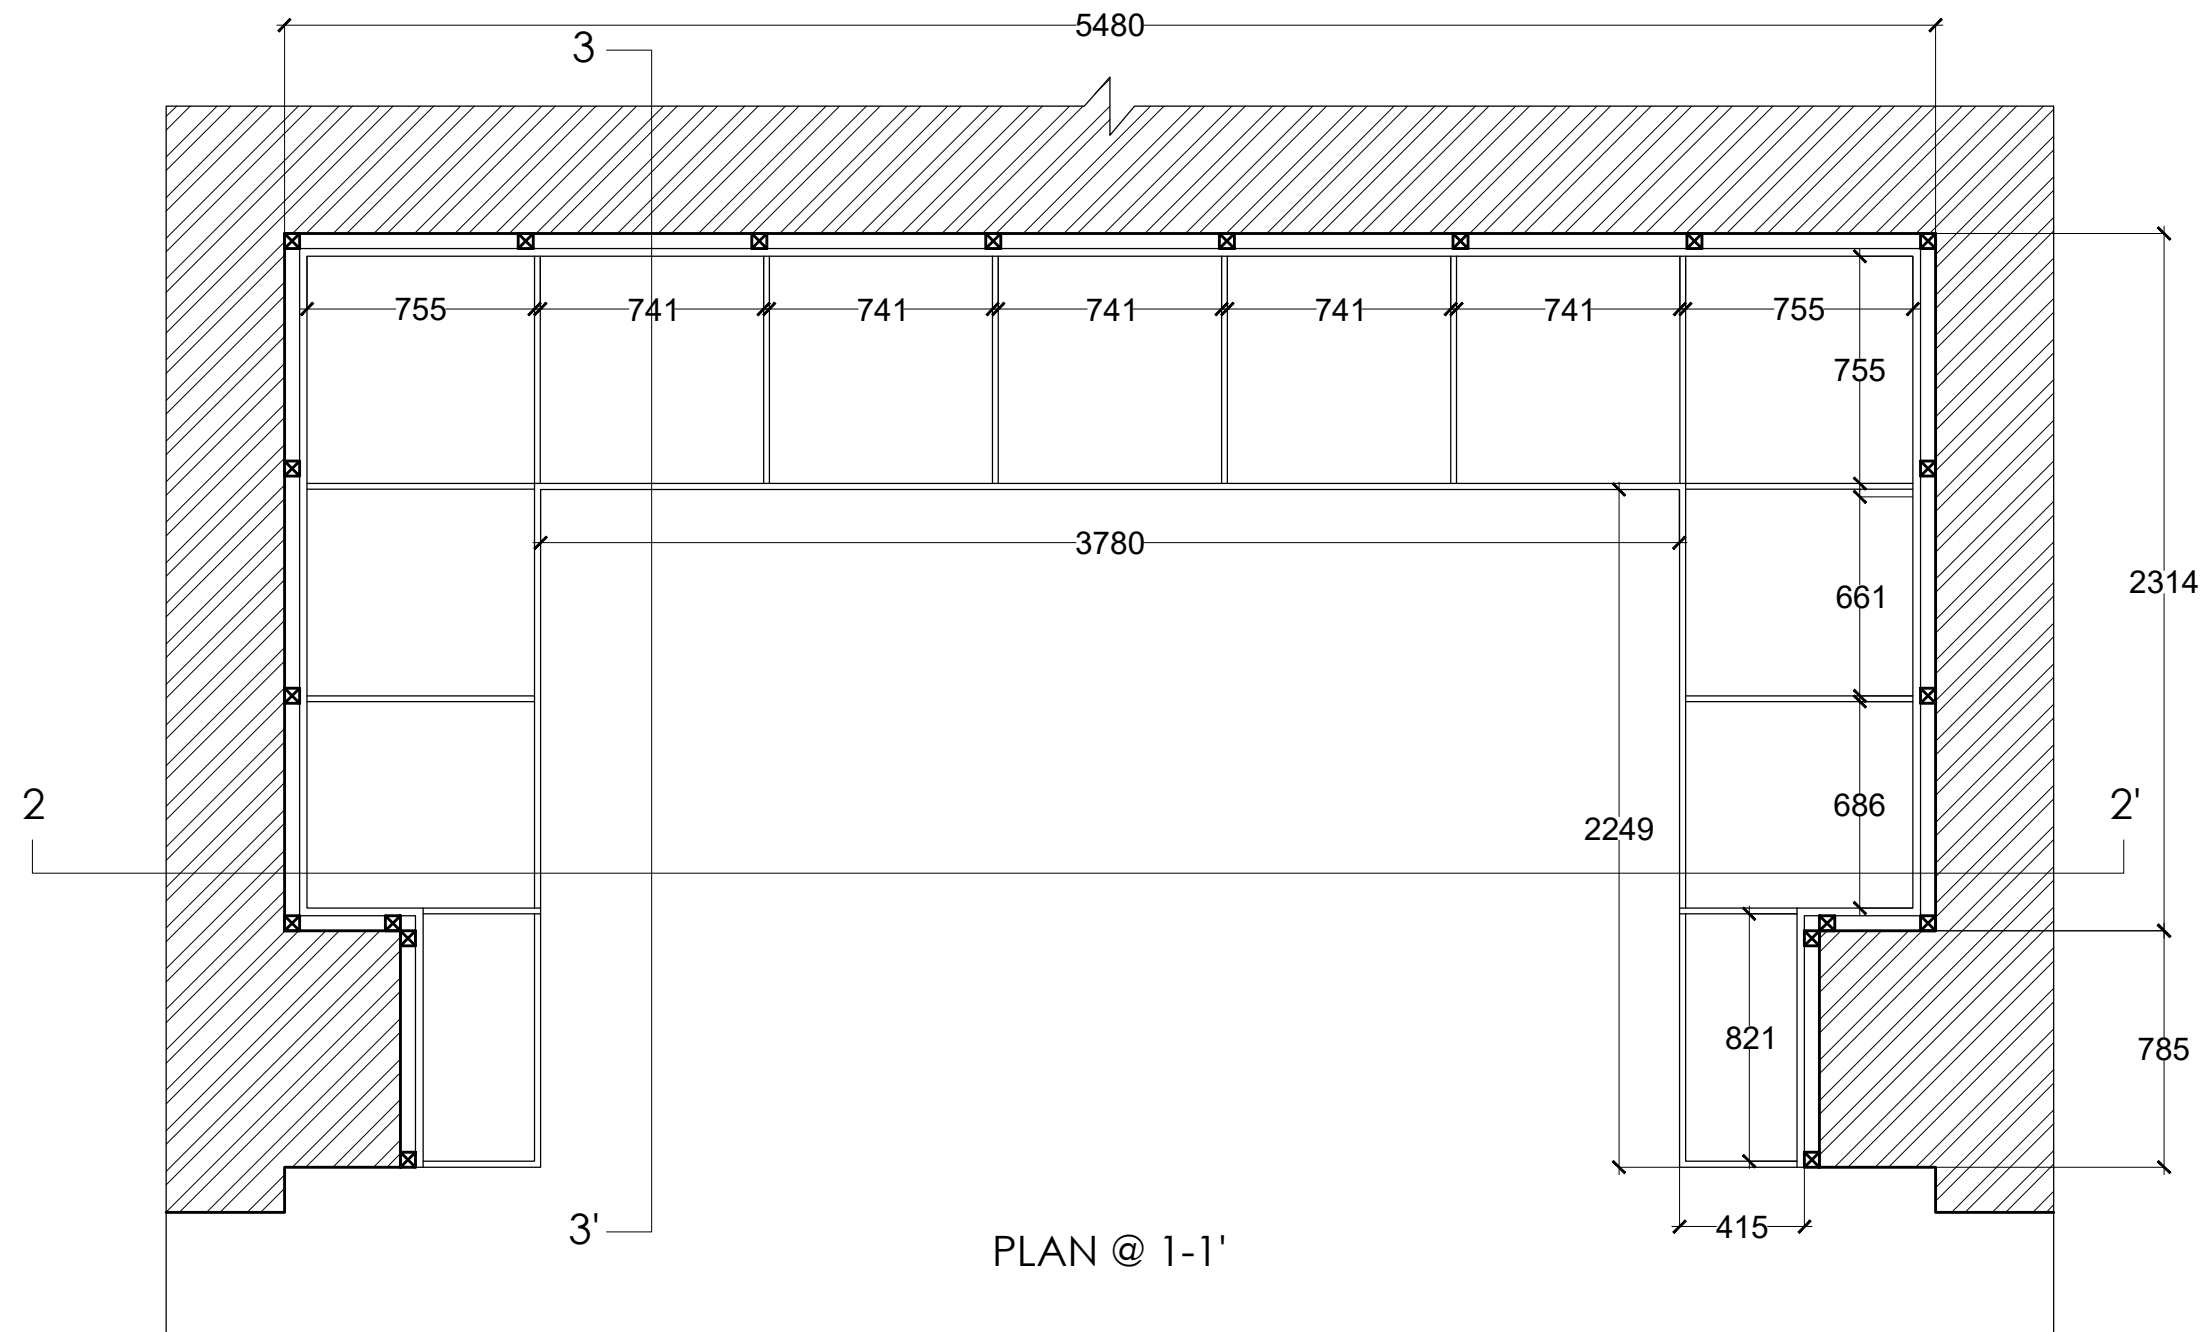

PLAN @ 1-1'

NOTES:

All dimensions in millimeters

LEGEND

DP	Display Panel
DC	Display Case
DS	Display Shelf
PE	Pedestal
WM	Wall Mural
WG	Wall Graphics
CP	Canvas Painting
M	Model
MET	Mock Excavation Trench
CP	Canvas Painting
AV	Audio Visuals
I	Interactive
P	Projection
HP	Holographic Projection
GS	Gallery Signage
DS	Directional Signage
LG	Logo
RT	Reception Table
CC	Crowd Control Barrier

SCALE: 1:100

0 1m 2m



NORTH

DRAWING NAME: LAYOUT

CULTURAL ANTHROPOLOGY

DRAWN BY: Sohini Pyne

CHECKED BY: Shikha Jain

DRAWING NO: IMK/GF/CA/05

SERIES: Tender Drawings

PROJECT:

PLANNING, CONTENT DEVELOPMENT, DESIGNING, RETROFITTING AND CURATORIAL WORK FOR THE INDIAN MUSEUM, KOLKATA




CLIENT:

INDIAN MUSEUM, KOLKATA

CONSULTANT:

**DRONAH**  
DEVELOPMENT & RESEARCH ORGANISATION FOR NATURE,ARTS & HERITAGE  
A-258, SOUTH CITY-1  
GURGAON-122001

DETAIL CA. DC 6

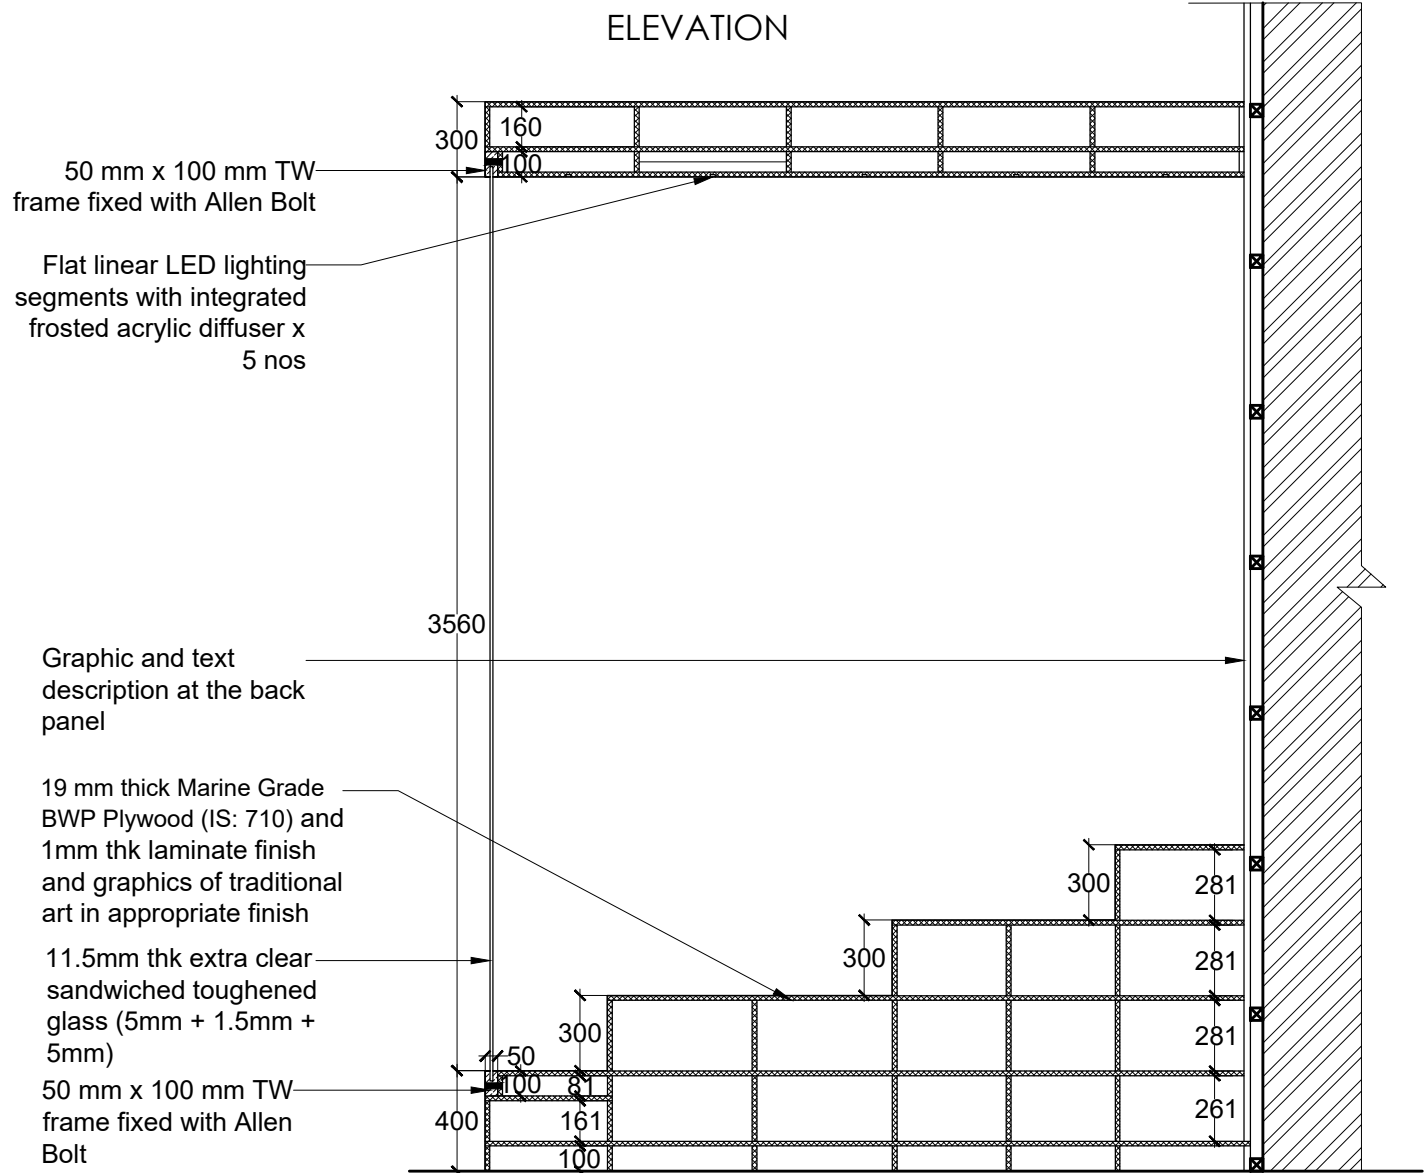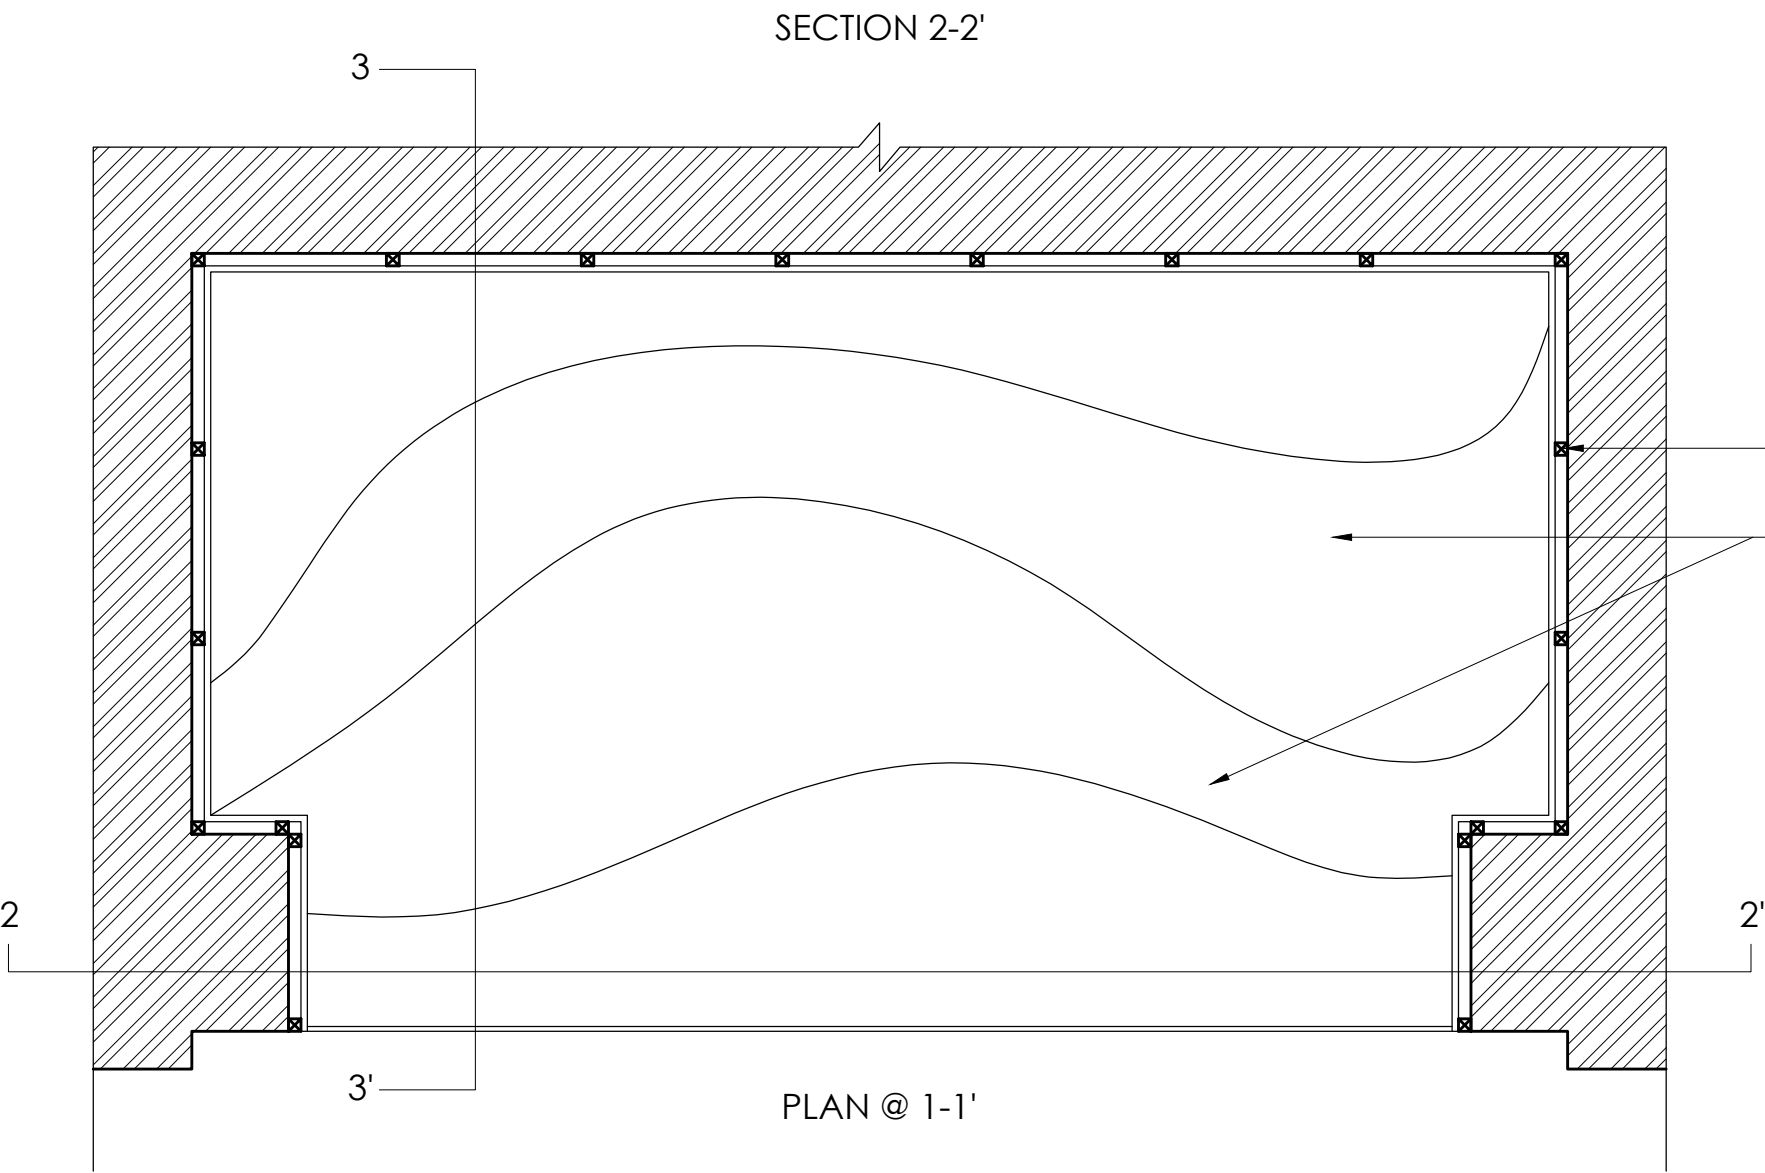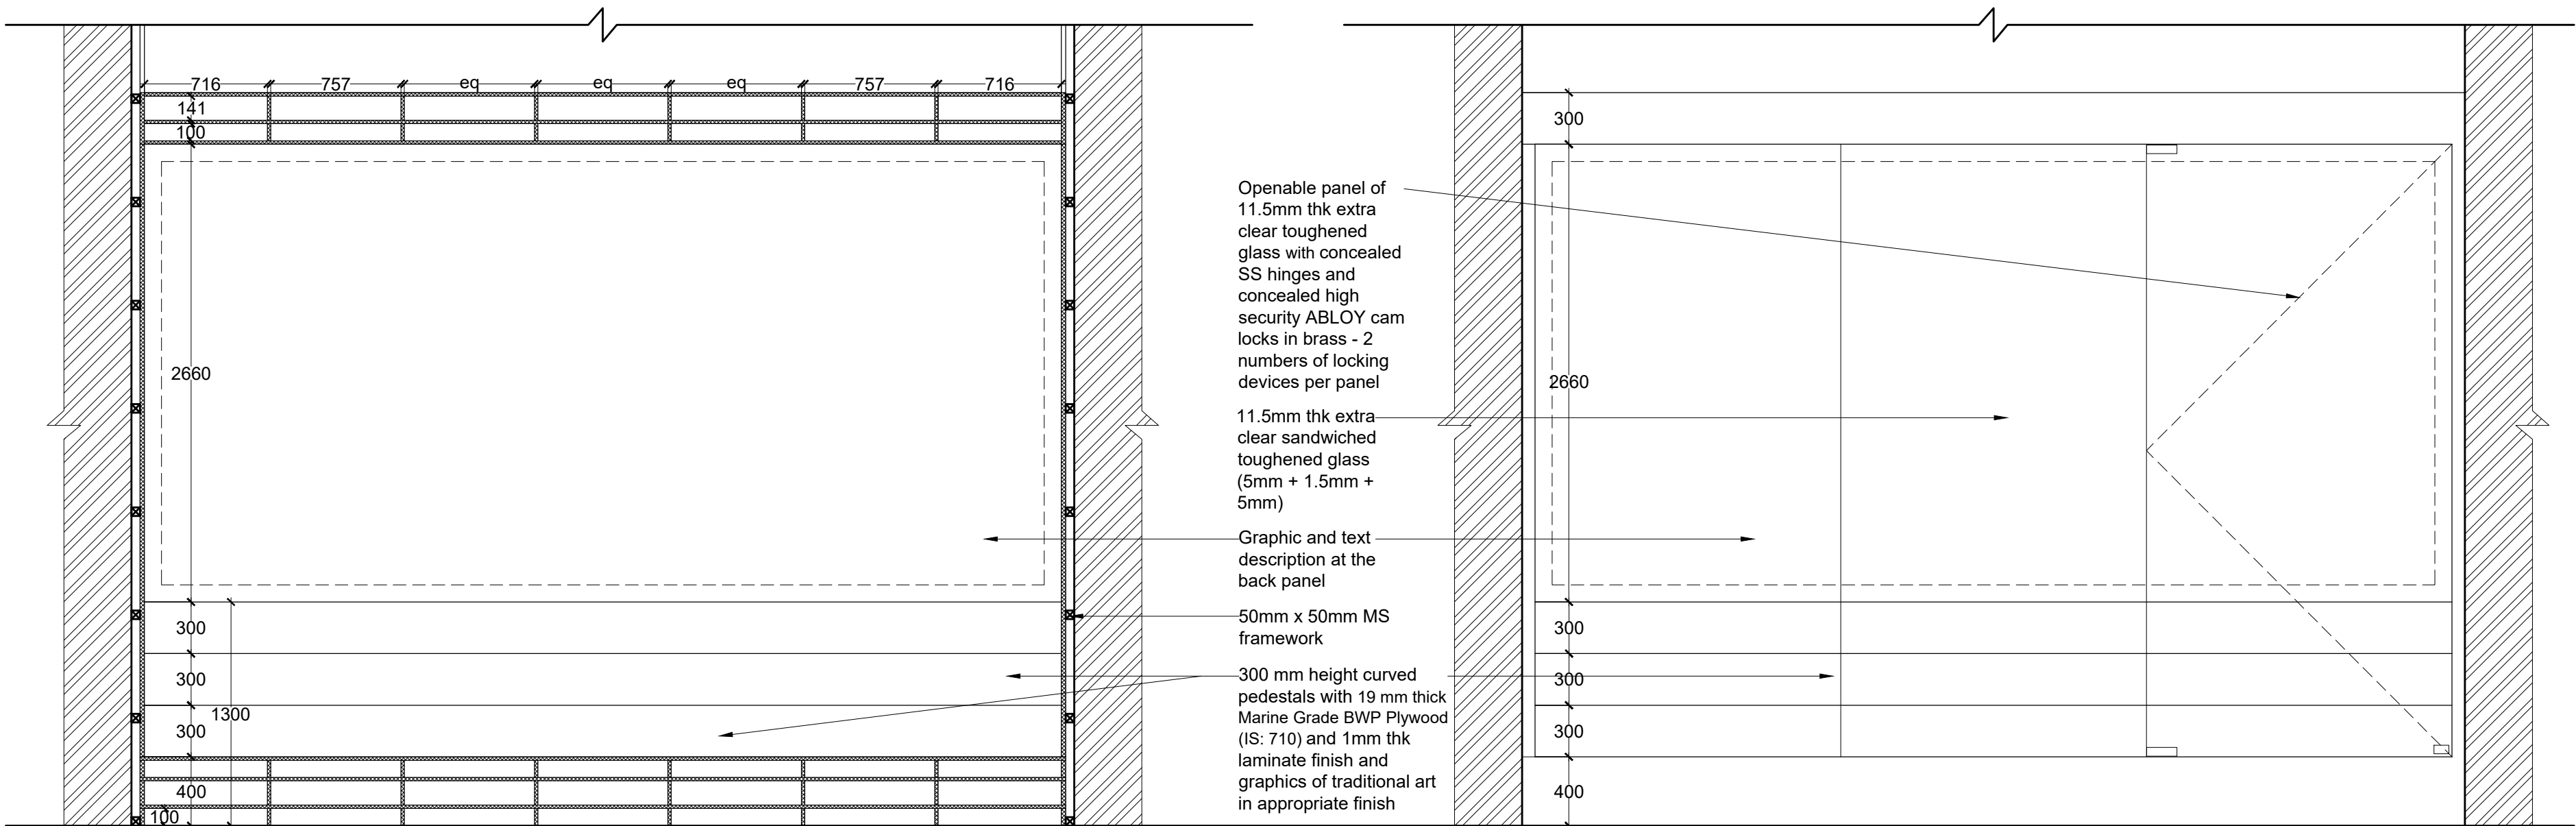

NOTES:

All dimensions in millimeters

LEGEND

DP	Display Panel
DC	Display Case
DS	Display Shelf
PE	Pedestal
WM	Wall Mural
WG	Wall Graphics
CP	Canvas Painting
M	Model
MET	Mock Excavation Trench
CP	Canvas Painting
AV	Audio Visuals
I	Interactive
P	Projection
HP	Holographic Projection
GS	Gallery Signage
DS	Directional Signage
LG	Logo
RT	Reception Table
CC	Crowd Control Barrier

SCALE: 1:100

0 1m 2m



NORTH

DRAWING NAME: LAYOUT

CULTURAL ANTHROPOLOGY

DRAWN BY: Sohini Pyne

CHECKED BY: Shikha Jain

DRAWING NO: IMK/GF/CA/06

SERIES: Tender Drawings

PROJECT:

PLANNING, CONTENT DEVELOPMENT, DESIGNING, RETROFITTING AND CURATORIAL WORK FOR THE INDIAN MUSEUM, KOLKATA

CLIENT:


INDIAN MUSEUM, KOLKATA

CONSULTANT:


**DRONAH**  
DEVELOPMENT & RESEARCH  
ORGANISATION FOR  
NATURE,ARTS & HERITAGE

A-258, SOUTH CITY-1  
GURGAON-122001

DETAIL CA. DC 7 (2 numbers), 9 (2 numbers)

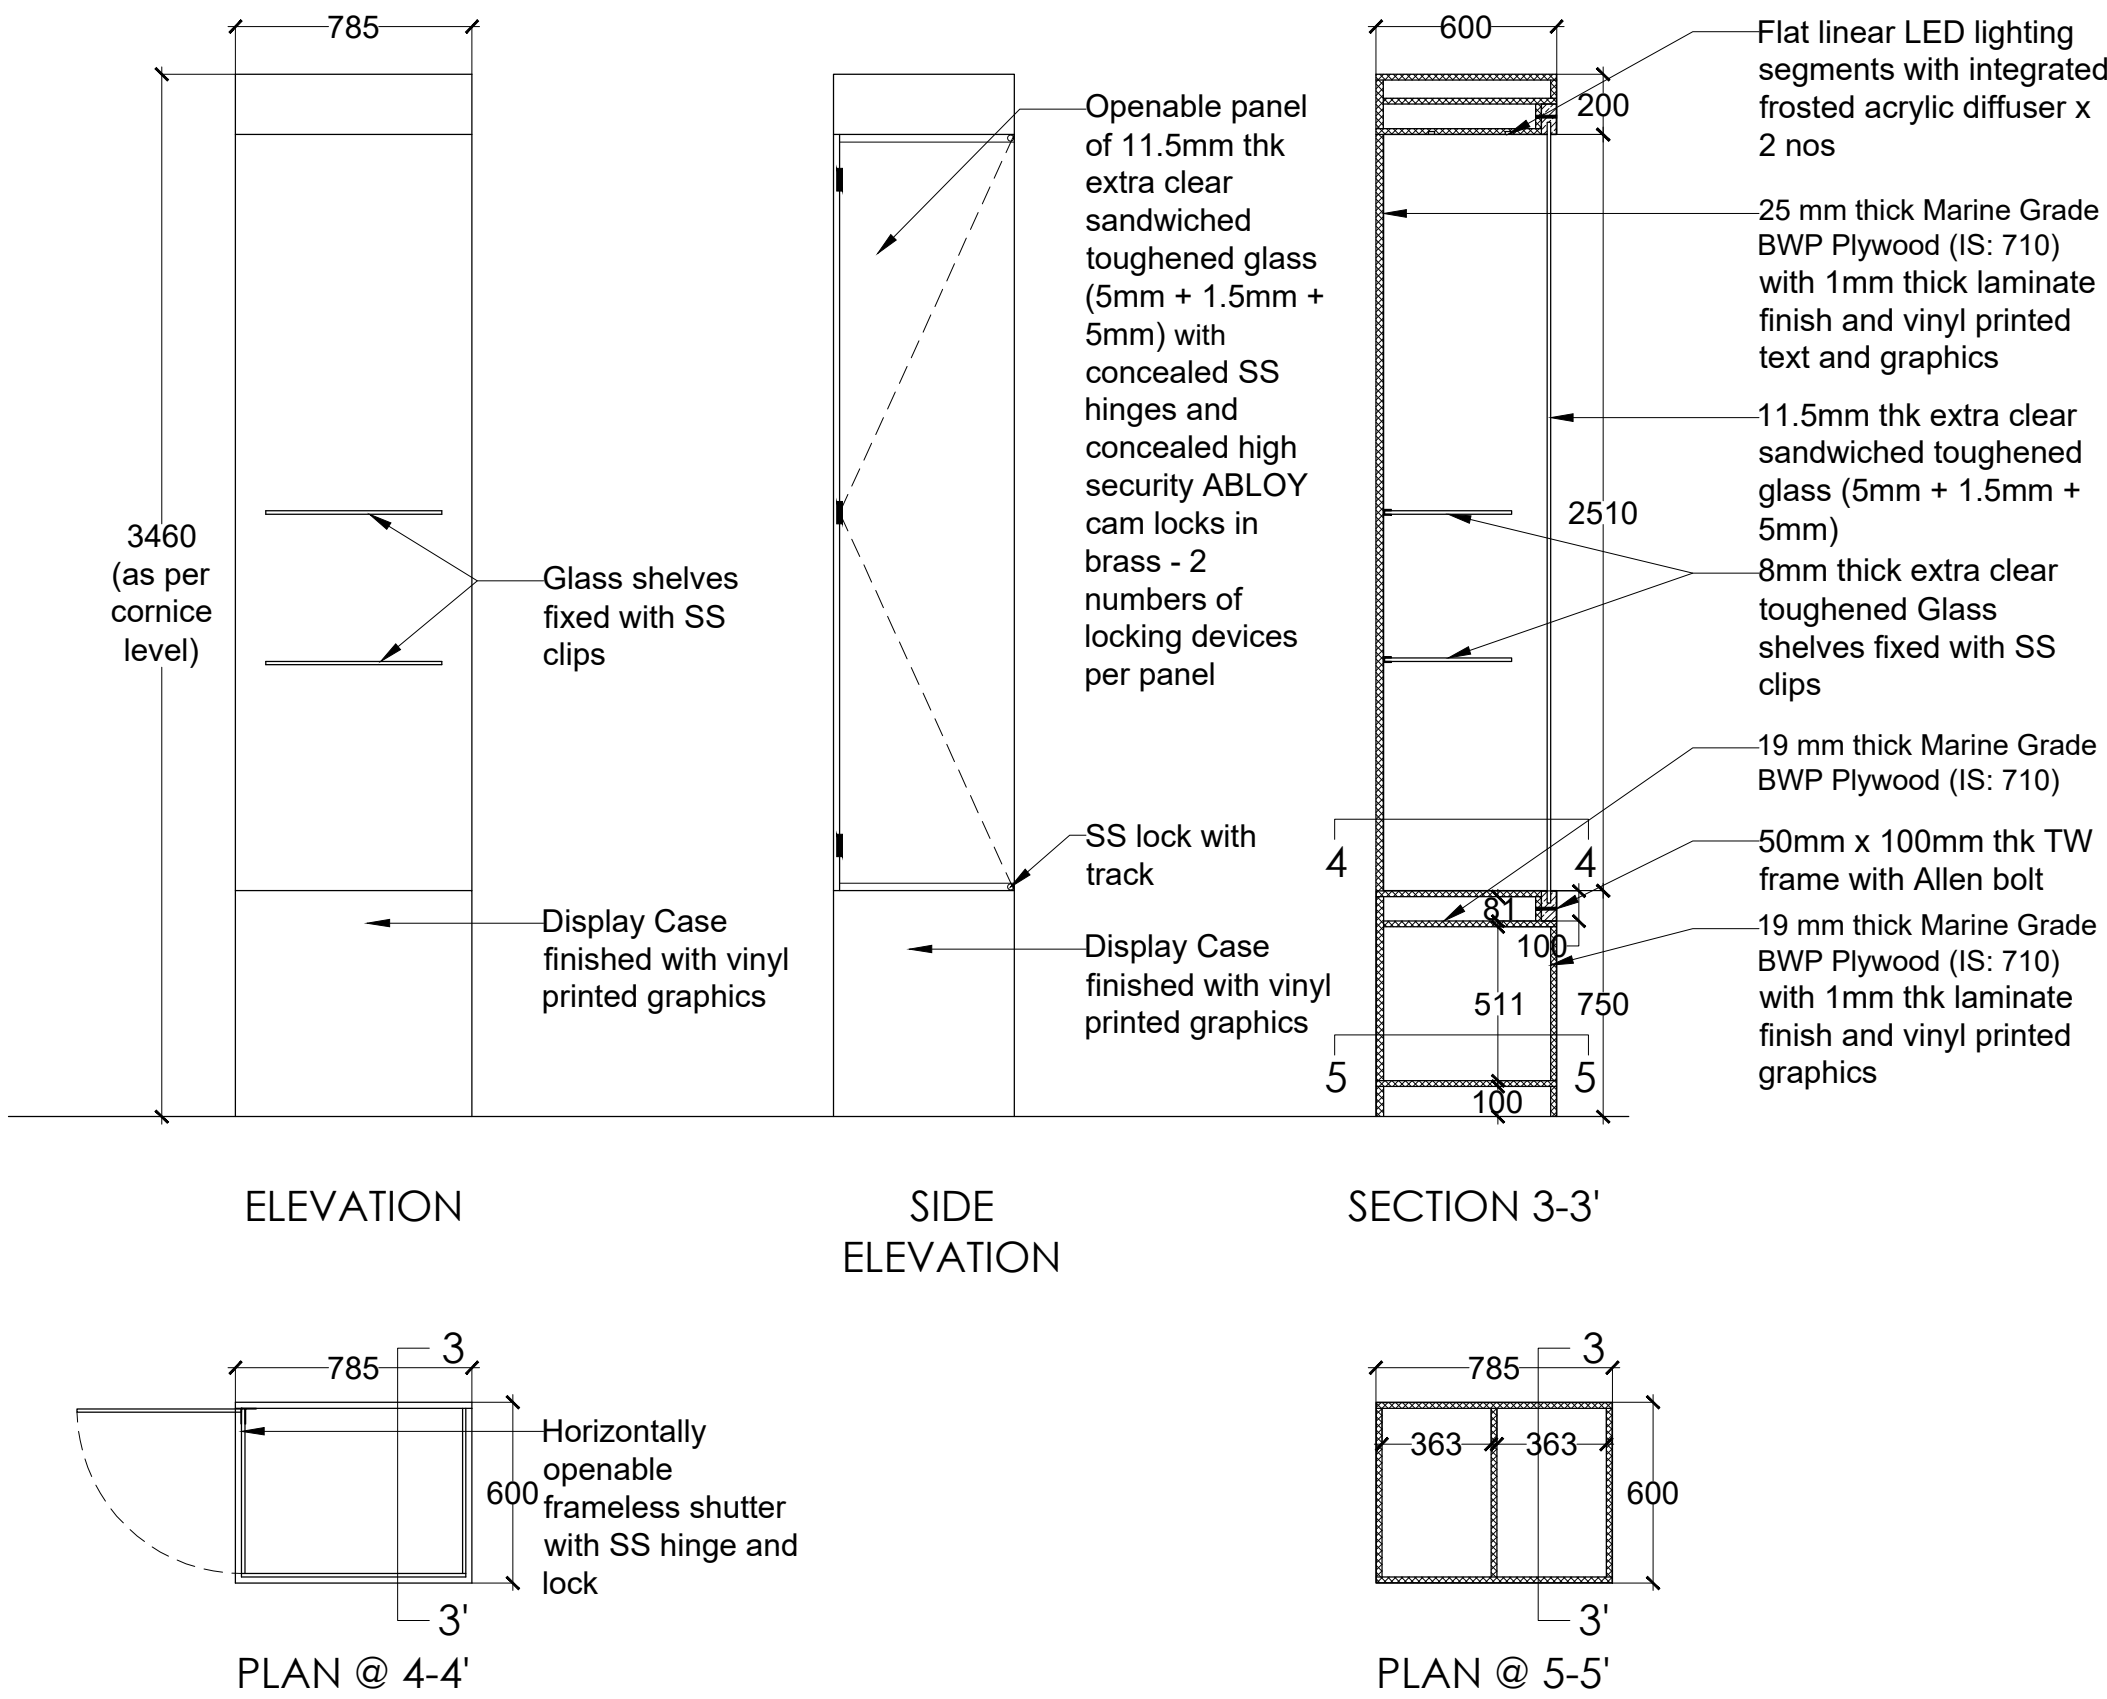

NOTES:	
All dimensions in millimeters	
LEGEND	
DP	Display Panel
DC	Display Case
DS	Display Shelf
PE	Pedestal
WM	Wall Mural
WG	Wall Graphics
CP	Canvas Painting
M	Model
MET	Mock Excavation Trench
CP	Canvas Painting
AV	Audio Visuals
I	Interactive
P	Projection
HP	Holographic Projection
GS	Gallery Signage
DS	Directional Signage
LG	Logo
RT	Reception Table
CC	Crowd Control Barrier

SCALE: 1:100	 NORTH
0 1m 2m	

DRAWING NAME: LAYOUT	
CULTURAL ANTHROPOLOGY	
DRAWN BY:	Sohini Pyne
CHECKED BY:	Shikha Jain
DRAWING NO:	IMK/GF/CA/07

SERIES:	Tender Drawings
---------	-----------------


PROJECT:
PLANNING, CONTENT DEVELOPMENT, DESIGNING, RETROFITTING AND CURATORIAL WORK FOR THE INDIAN MUSEUM, KOLKATA

CLIENT:
INDIAN MUSEUM, KOLKATA


CONSULTANT:
DRONAH DEVELOPMENT & RESEARCH ORGANISATION FOR NATURE,ARTS & HERITAGE A-258, SOUTH CITY-1 GURGAON-122001



DETAIL CA. DC 14

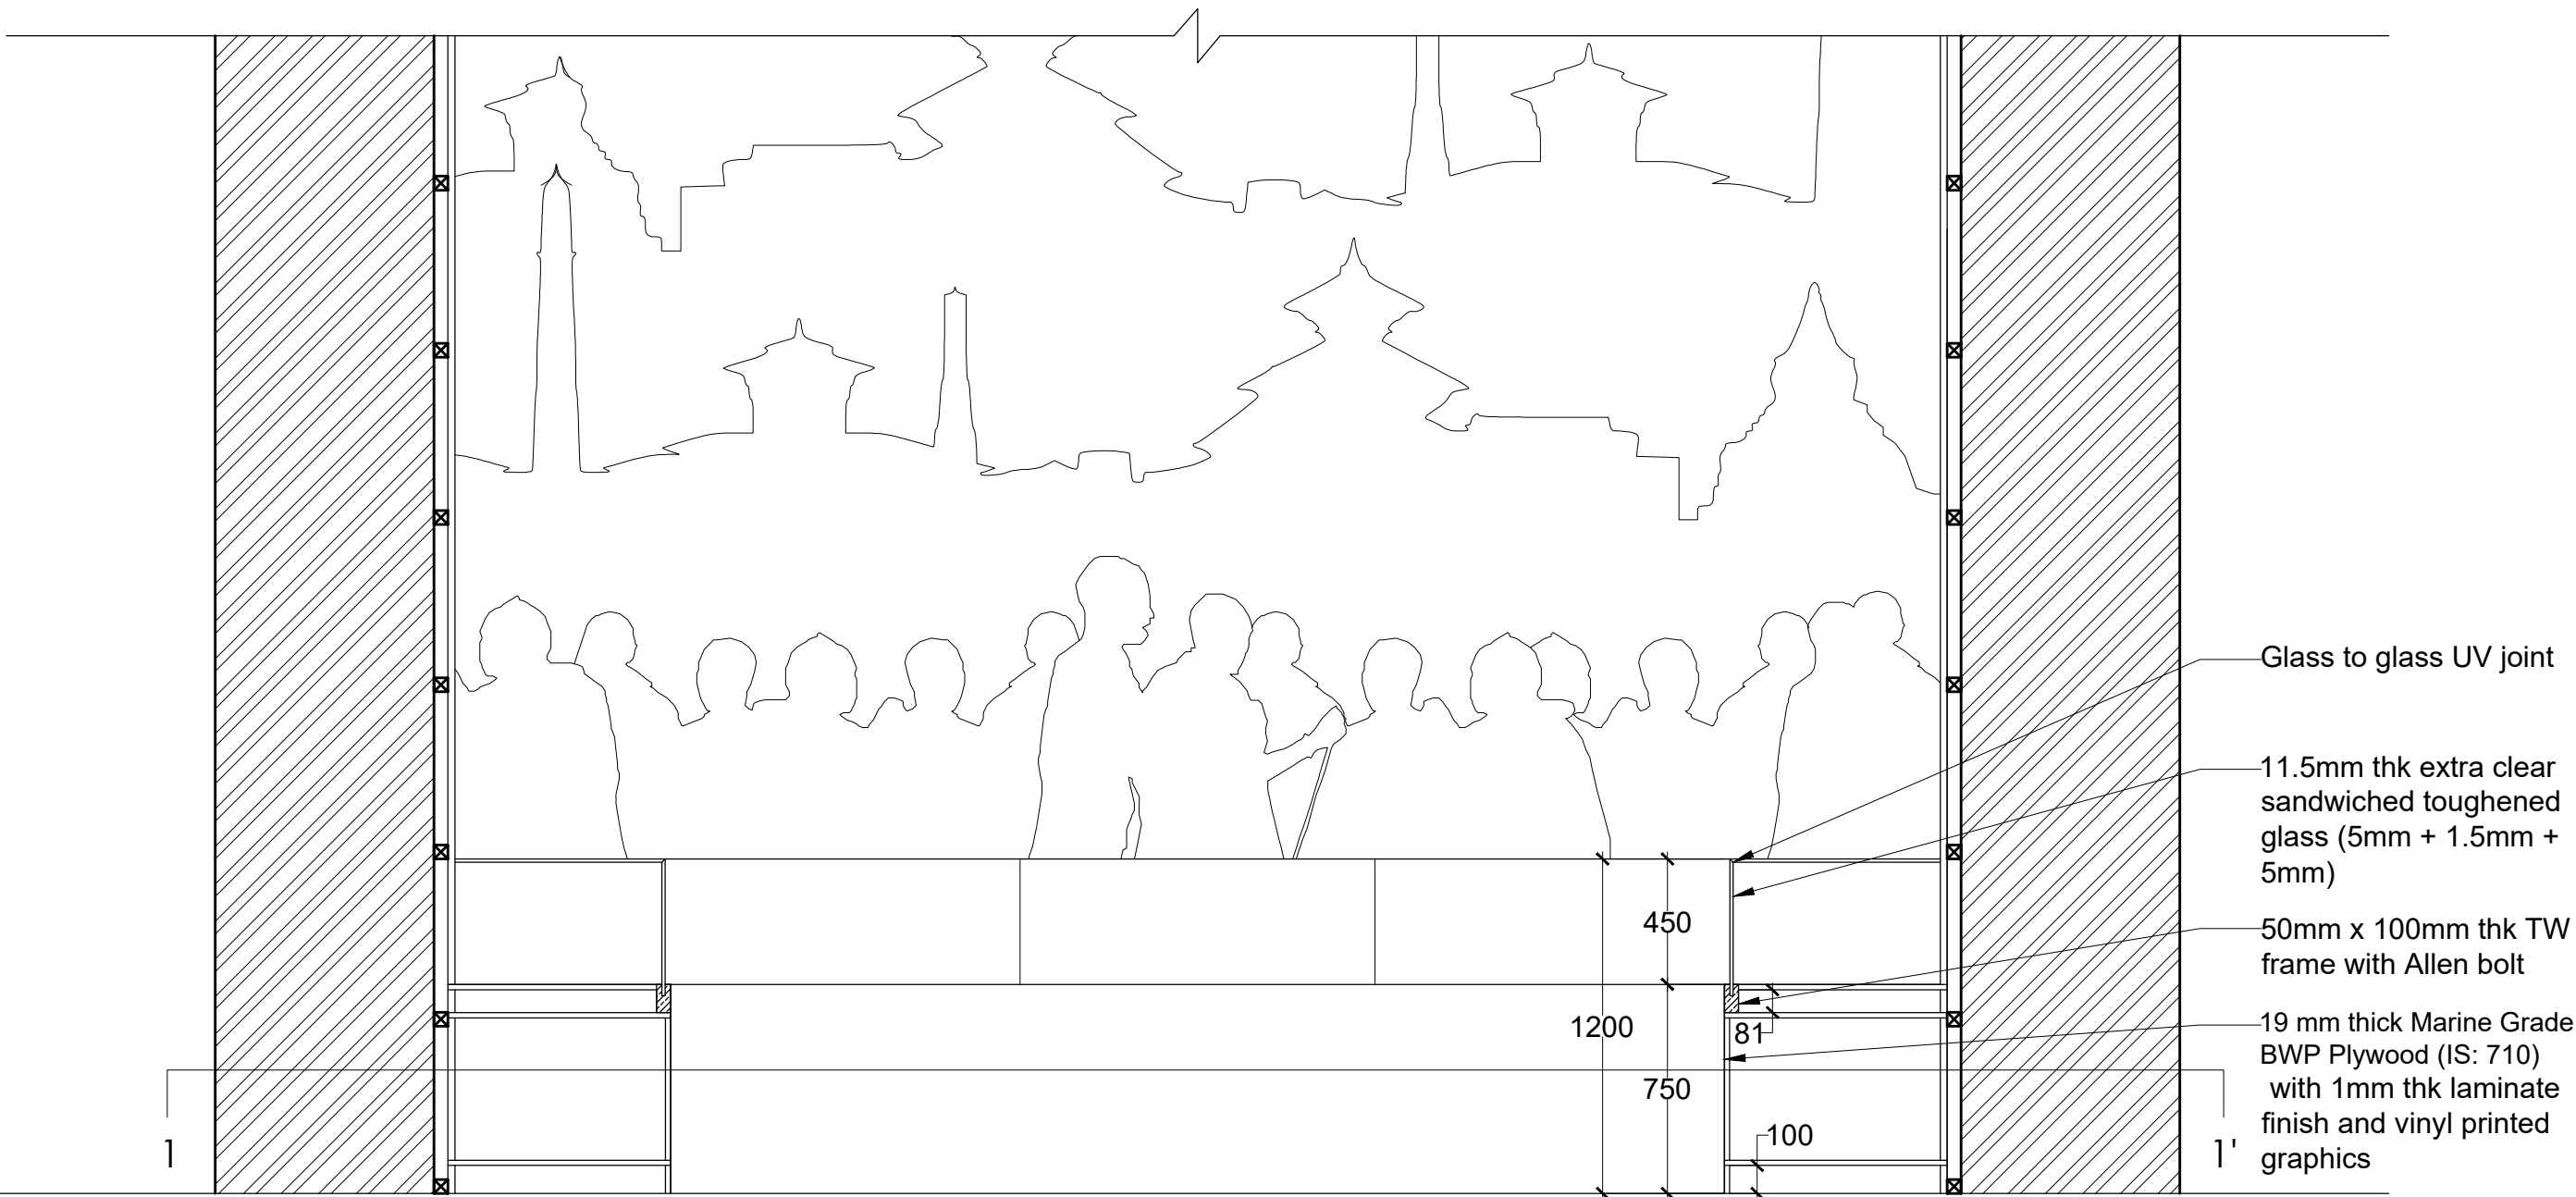


SECTIONAL ELEVATION

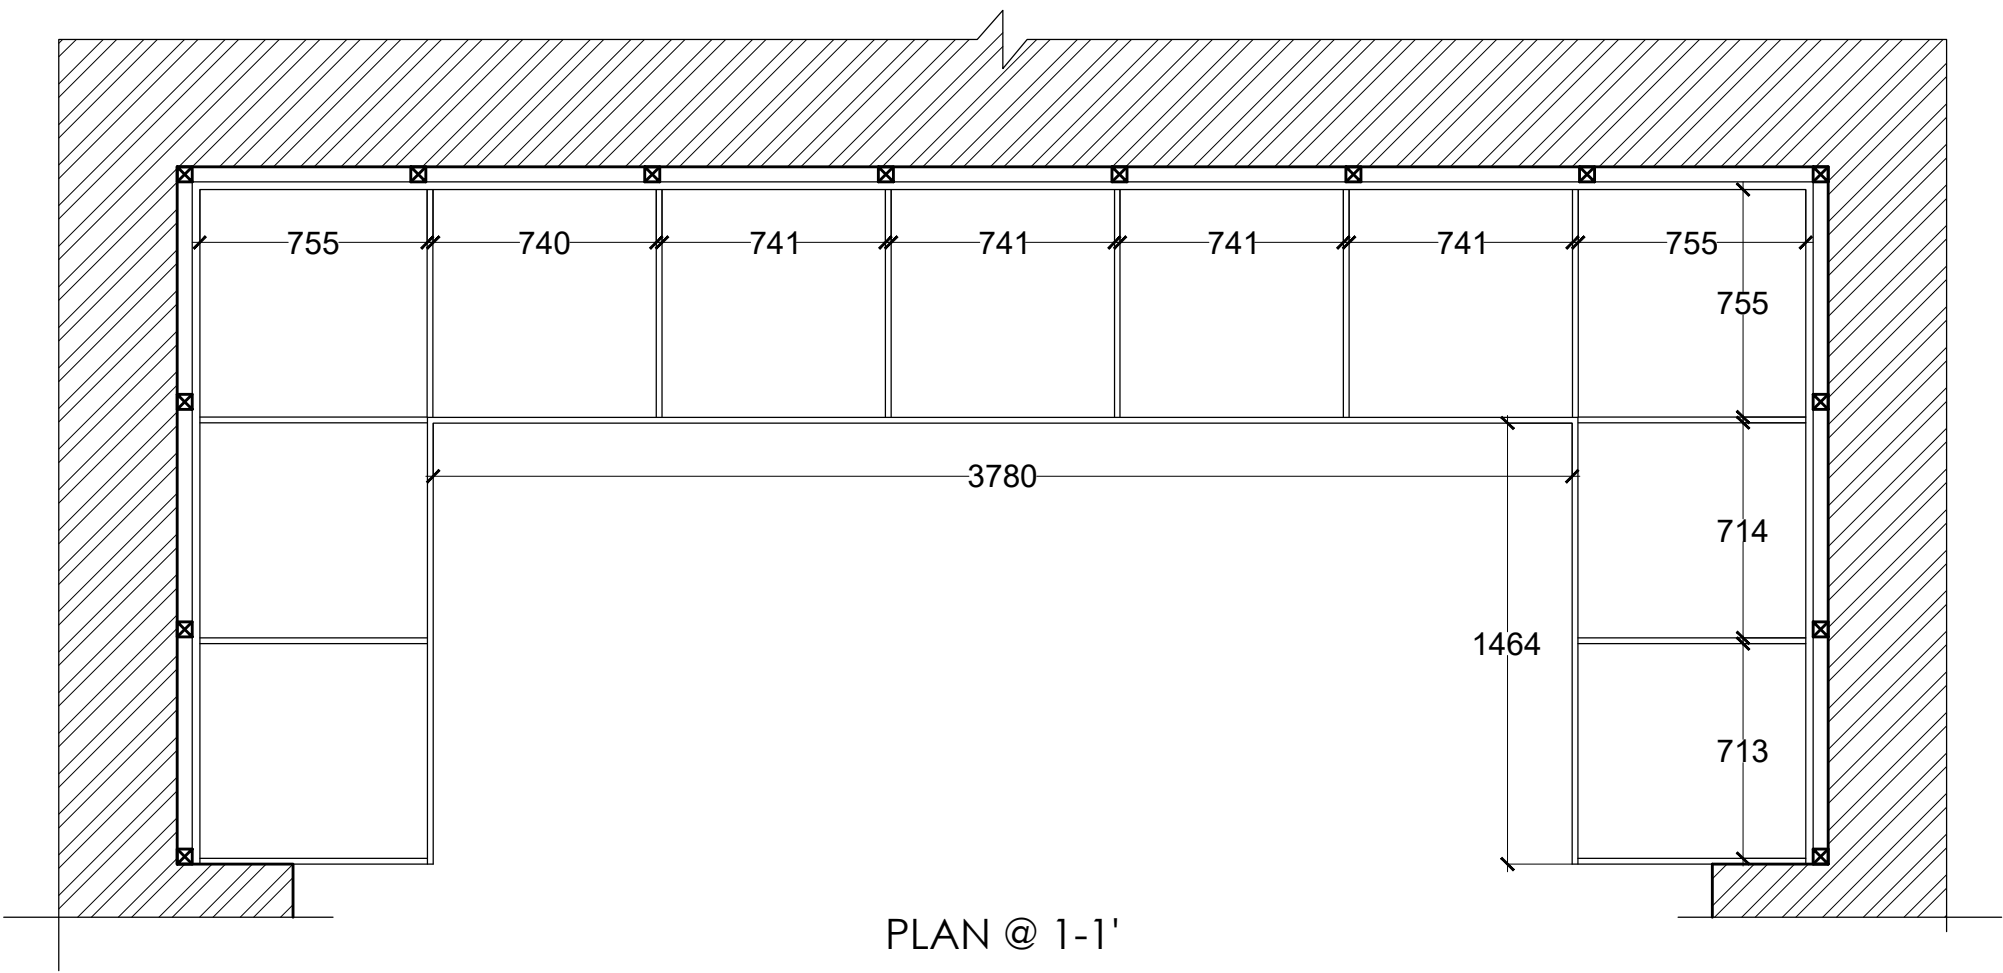

PLAN @ 1-1'

CORNICE MOULDING  
SCALE - 1:5

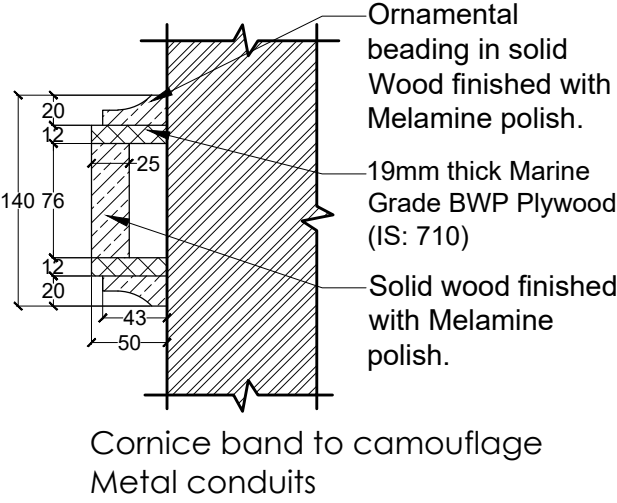

NOTES:

All dimensions in millimeters

LEGEND

DP	Display Panel
DC	Display Case
DS	Display Shelf
PE	Pedestal
WM	Wall Mural
WG	Wall Graphics
CP	Canvas Painting
M	Model
MET	Mock Excavation Trench
CP	Canvas Painting
AV	Audio Visuals
I	Interactive
P	Projection
HP	Holographic Projection
GS	Gallery Signage
DS	Directional Signage
LG	Logo
RT	Reception Table
CC	Crowd Control Barrier

SCALE: 1:100

0 1m 2m



NORTH

DRAWING NAME: LAYOUT

CULTURAL ANTHROPOLOGY

DRAWN BY: Sohini Pyne

CHECKED BY: Shikha Jain

DRAWING NO: IMK/GF/CA/08

SERIES: Tender Drawings

PROJECT:


PLANNING, CONTENT  
DEVELOPMENT, DESIGNING,  
RETROFITTING AND  
CURATORIAL WORK FOR THE  
INDIAN MUSEUM, KOLKATA

CLIENT:

INDIAN MUSEUM, KOLKATA

CONSULTANT:

**DRONAH**  
DEVELOPMENT & RESEARCH  
ORGANISATION FOR  
NATURE,ARTS & HERITAGE  
A-258, SOUTH CITY-1  
GURGAON-122001

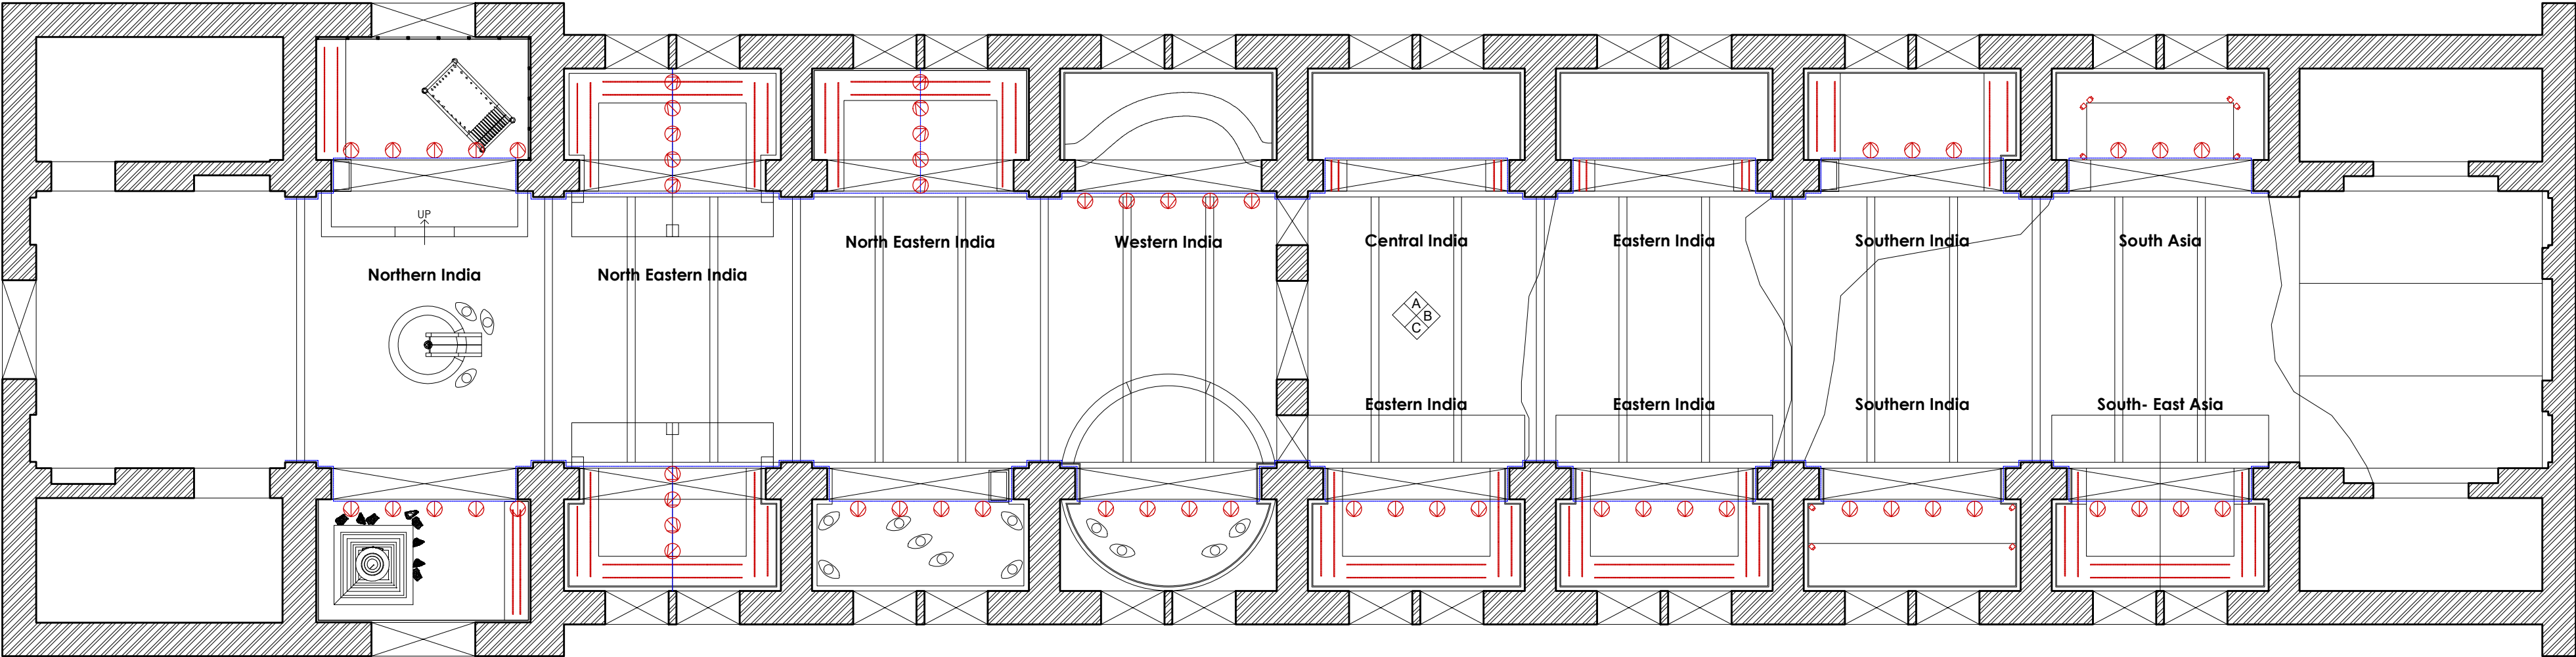

Sym	Type
	Track light on frame
	LED Pole/stand mounted cabinet lights
	Linear segment with integrated acrylic diffuser
	Ceiling Light Conduit

PLAN

NOTES:

All dimensions in millimeters

LEGEND

DP	Display Panel
DC	Display Case
DS	Display Shelf
PE	Pedestal
WM	Wall Mural
WG	Wall Graphics
CP	Canvas Painting
M	Model
MET	Mock Excavation Trench
CP	Canvas Painting
AV	Audio Visuals
I	Interactive
P	Projection
HP	Holographic Projection
GS	Gallery Signage
DS	Directional Signage
LG	Logo
RT	Reception Table
CC	Crowd Control Barrier

SCALE: 1:100

0 1m 2m



NORTH

DRAWING NAME: LAYOUT

CULTURAL ANTHROPOLOGY

DRAWN BY: Sohini Pyne

CHECKED BY: Shikha Jain

DRAWING NO: IMK/GF/CA/09

SERIES: Tender Drawings

PROJECT:

PLANNING, CONTENT DEVELOPMENT, DESIGNING, RETROFITTING AND CURATORIAL WORK FOR THE INDIAN MUSEUM, KOLKATA

CLIENT:

INDIAN MUSEUM, KOLKATA

CONSULTANT:

**DRONAH**  
DEVELOPMENT & RESEARCH ORGANISATION FOR NATURE,ARTS & HERITAGE  
A-258, SOUTH CITY-1  
GURGAON-122001